


PARTIAL DECK DRAINAGE LAYOUT

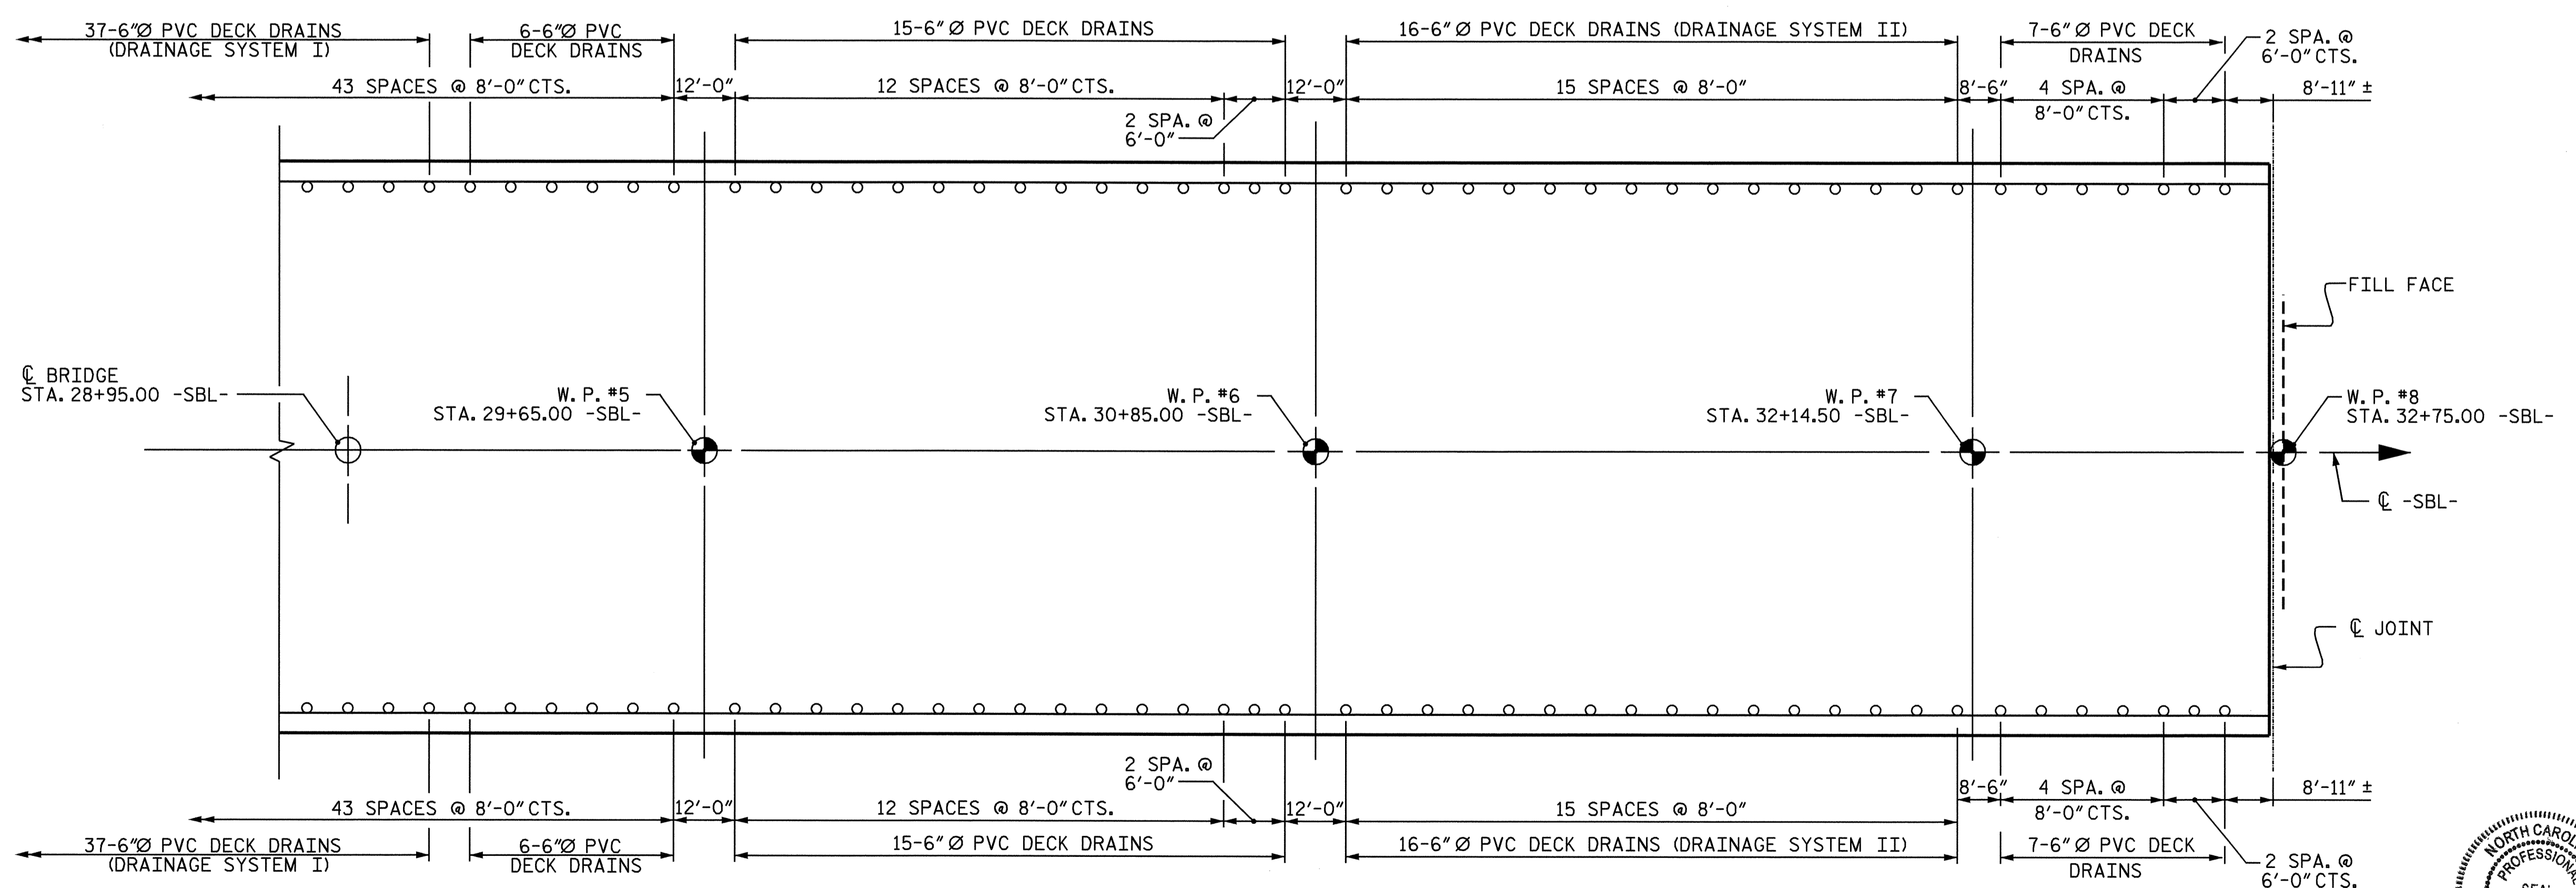


PARTIAL DECK DRAINAGE LAYOUT

PROJECT NO. I-4025A
YADKIN-SURRY COUNTY
 STATION: 28+95.00 -SBL-

SHEET 1 OF 3

STATE OF NORTH CAROLINA
 DEPARTMENT OF TRANSPORTATION
 RALEIGH

**SUPERSTRUCTURE
 STRUCTURE
 DRAINAGE SYSTEM**

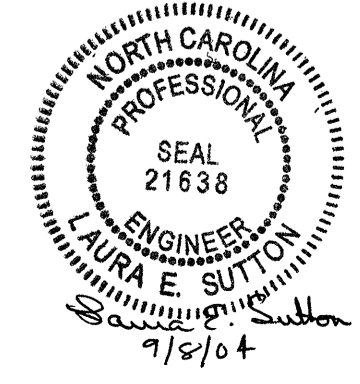

DRAWN BY : T.A. WALTER DATE : 6/8/2004
 CHECKED BY : M.A. ALLEN DATE : 8/4/2004

REVISIONS						SHEET NO. 5-19 TOTAL SHEETS 73
NO.	BY:	DATE:	NO.	BY:	DATE:	
1			3			
2			4			