
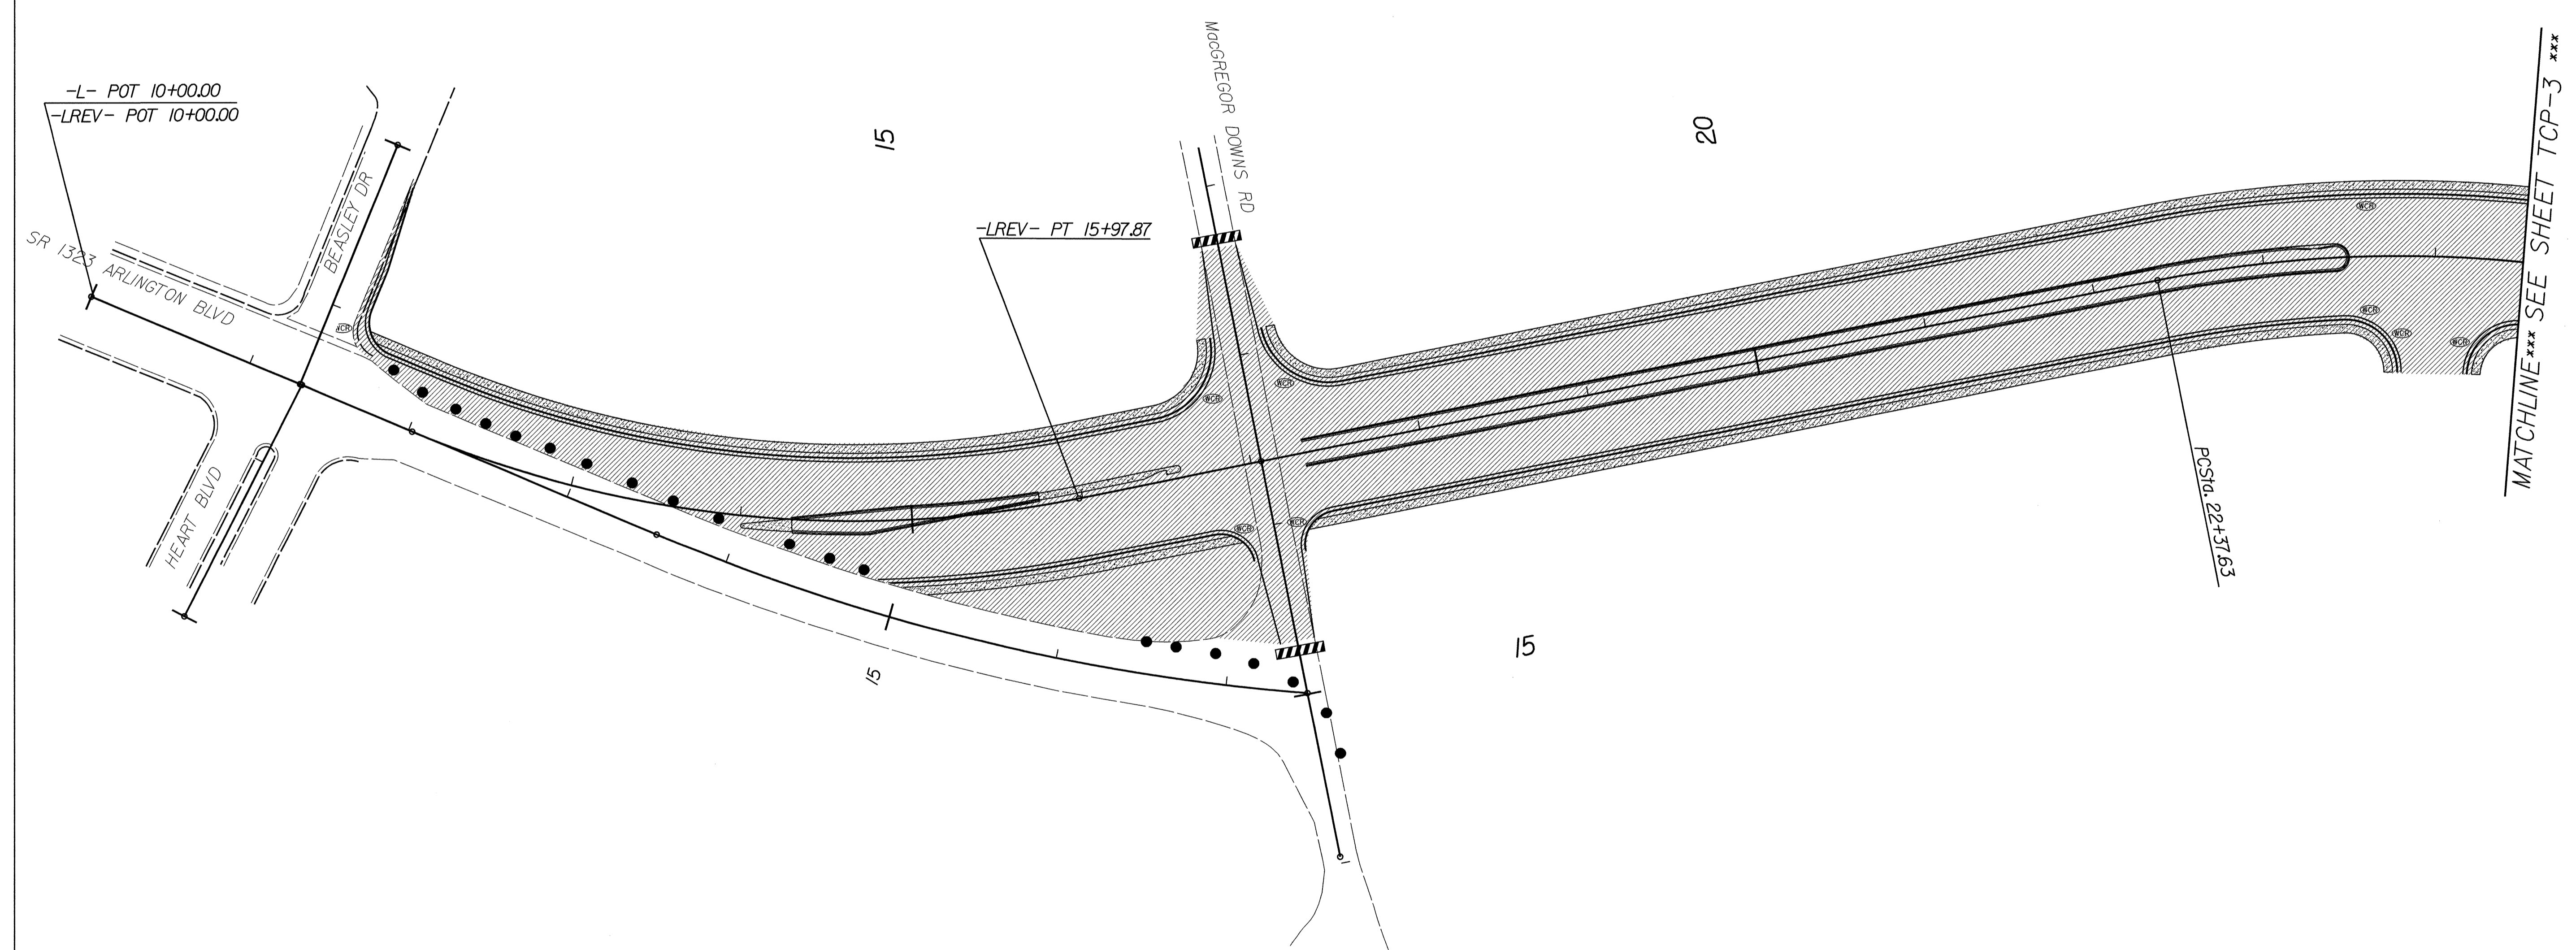


PROJ. REFERENCE NO.	SHEET NO.
U-4737	TCP-2

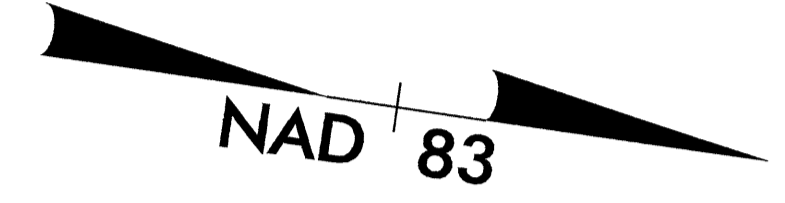

22-MAR-2005 10:11  
 D:\DDC\PROJECTS\PITT\ARLINGTON BLVD\arlington with left turn\arlington.ddc2.tcp2.dgn  
 mjackson AI

APPROVED: <i>J. Bull</i> DATE: 3/21/05	<b>PHASE I</b>									
	SCALE: NONE	<table border="1"> <thead> <tr> <th colspan="2">REVISIONS</th> </tr> </thead> <tbody> <tr> <td> </td> <td> </td> </tr> <tr> <td> </td> <td> </td> </tr> <tr> <td> </td> <td> </td> </tr> </tbody> </table>	REVISIONS							
	REVISIONS									
DATE: 1-05										
DWG. BY: MRJ										
DESIGN BY: JAB										
REVIEWED BY: MWN	<small>CADD FILE</small>									