 


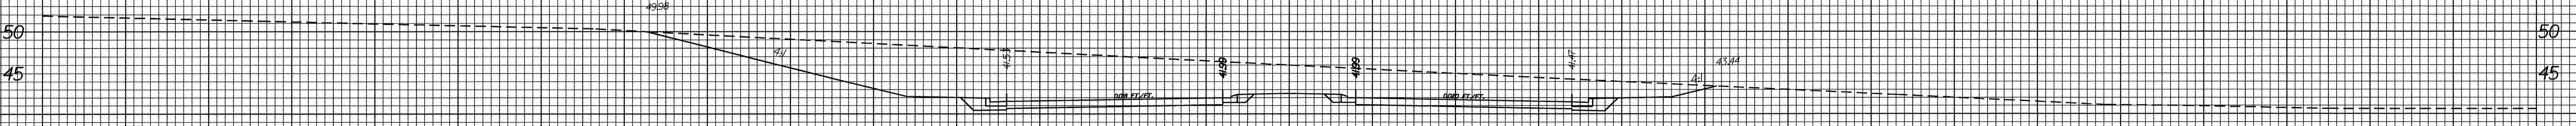
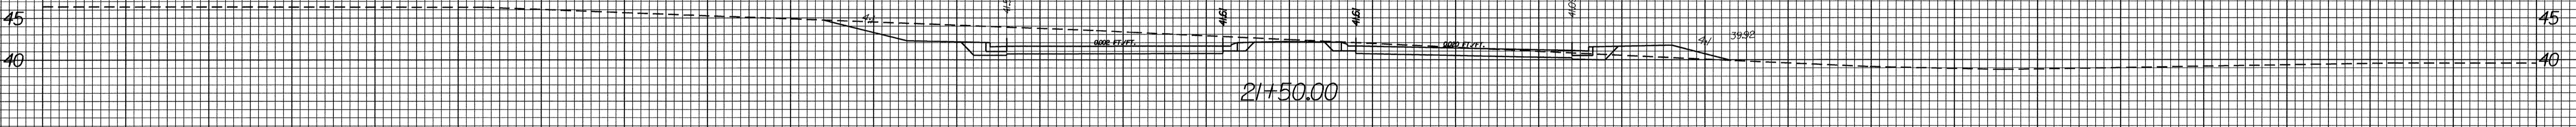
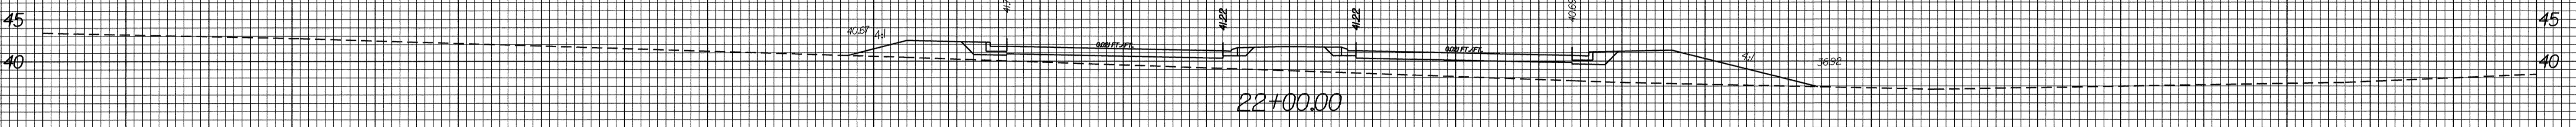


8/23/99

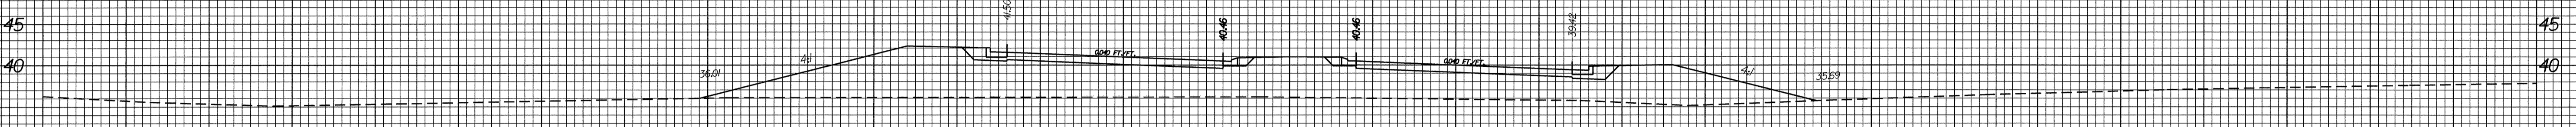

| | |
|---------------------|-----------|
| PROJ. REFERENCE NO. | SHEET NO. |
| U-4737 | X-5 |

150 140 130 120 110 100 90 80 70 60 50 40 30 20 10 0 10 20 30 40 50 60 70 80 90 100 110 120 130 140 150

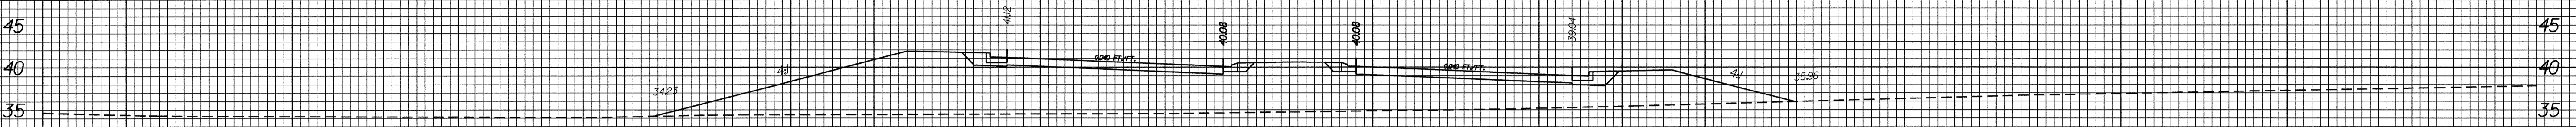

LREV

150 140 130 120 110 100 90 80 70 60 50 40 30 20 10 0 10 20 30 40 50 60 70 80 90 100 110 120 130 140 150

22-MAR-2005 5:42
 D:\DDC\PROJECTS\PTT\ARLINGTON\ARLINGTON BLVD\ArLington with left turn\arlington.ddc2.xpl.1.rev.dgn
 Johnson