


TIP NO.	SHEET NO.
U-3837	SIGN-1

**STATE OF NORTH CAROLINA  
DEPARTMENT OF TRANSPORTATION**

**SIGNING PLANS  
FORSYTH COUNTY**


**LOCATION: WINSTON-SALEM - BRIDGE OVER I-40 ON SR 3153 (HANES MALL BLVD)  
FROM WEST OF KESTER MILL ROAD TO WEST OF WESTGATE CENTER DRIVE**

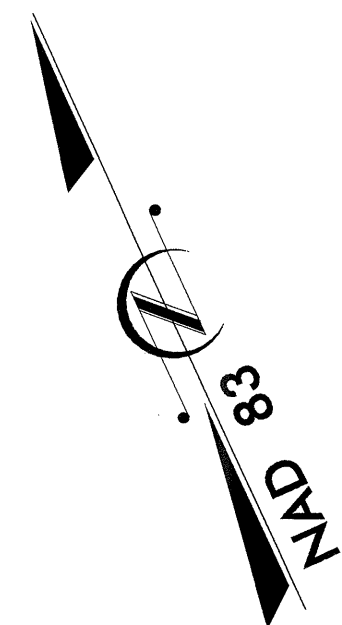

**T.I.P.: U-3837**

**CONTRACT: C201013**

STA. 10+00  
BEGIN STATE SIGNING PROJECT U-3837

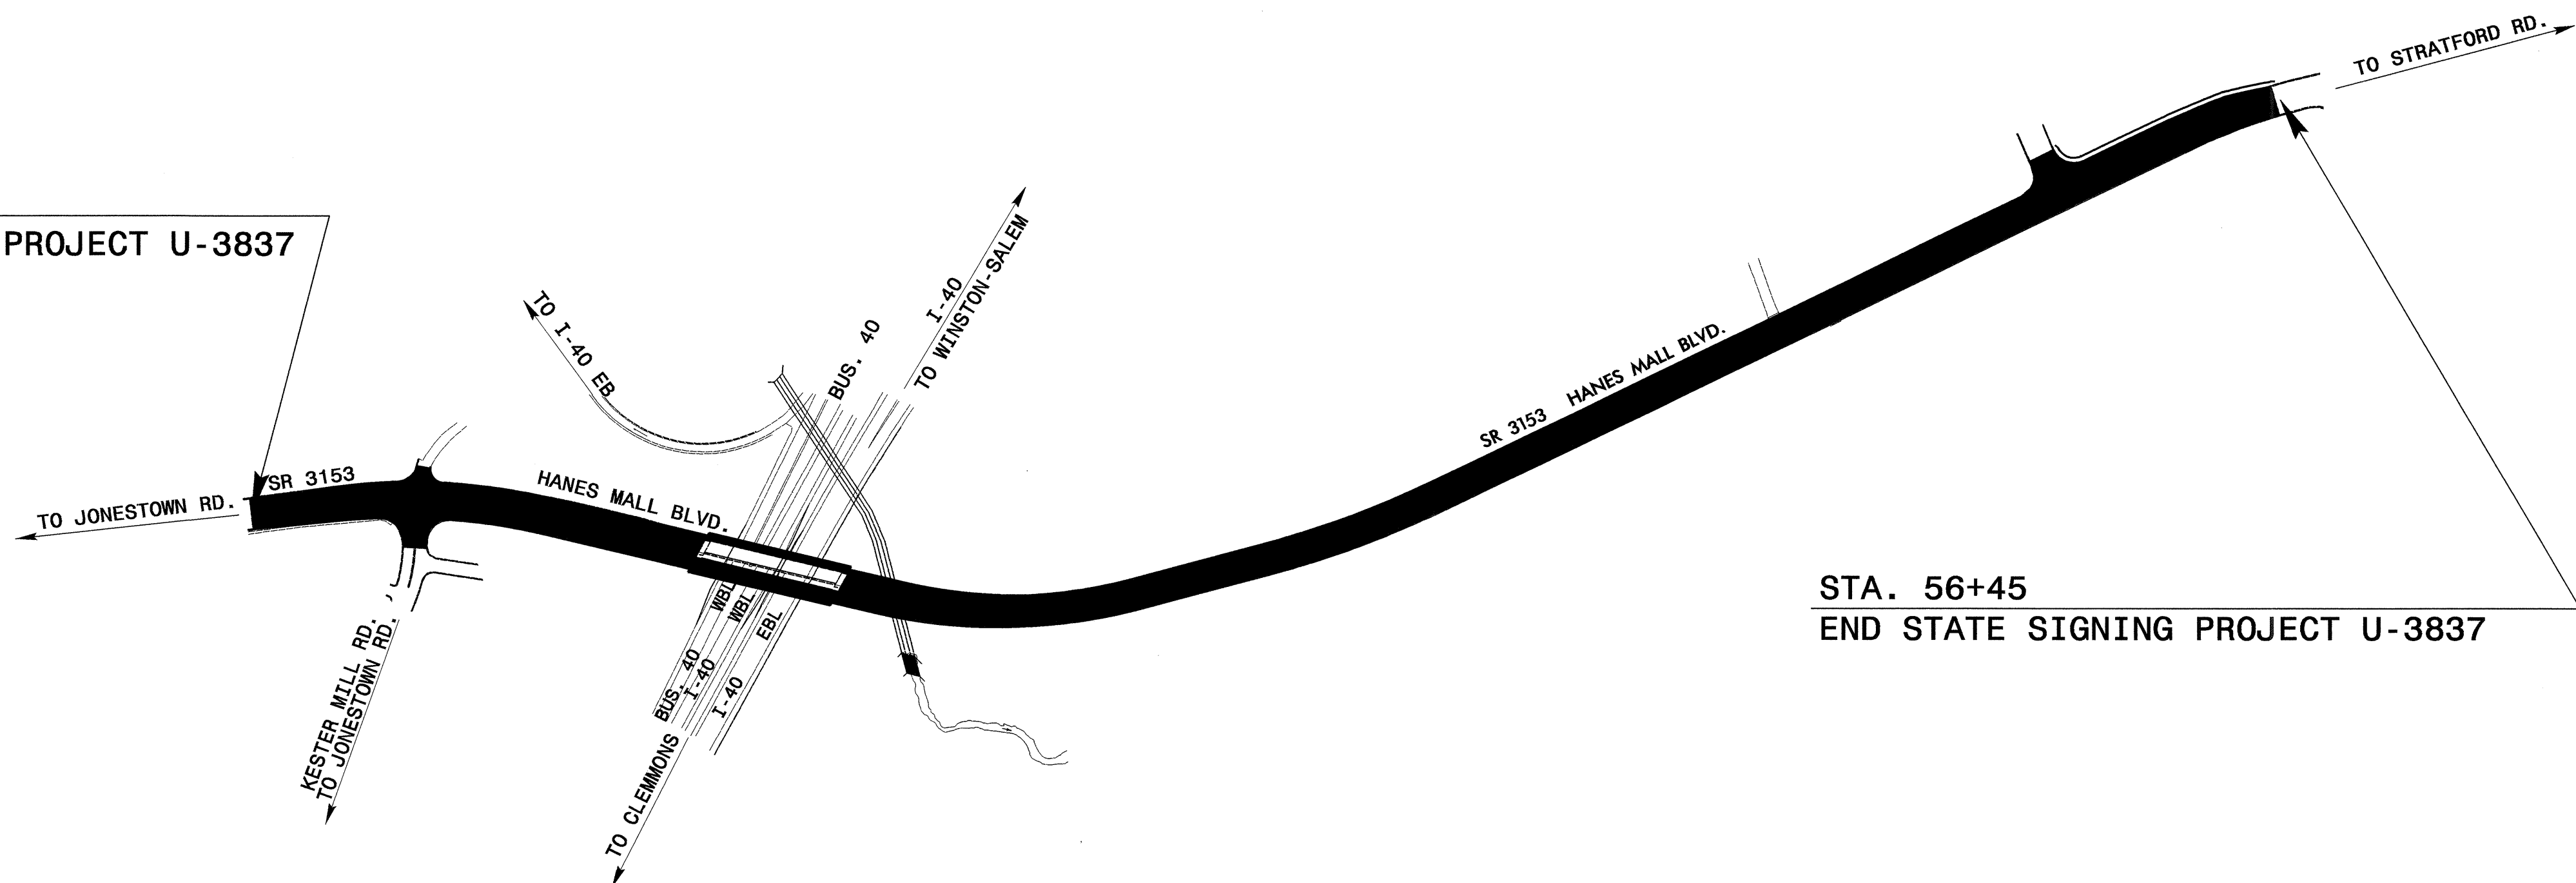

STA. 56+45  
END STATE SIGNING PROJECT U-3837

**INDEX**

<u>SHEET NO.</u>	<u>DESCRIPTION</u>
SIGN-1	TITLE SHEET
SIGN-2	NOTES
SIGN-3	E SHEET
SIGN-4	STRUCTURE LINE DRAWING
SIGN-5 thru 6	OVERHEAD LIGHTING PLANS
SIGN-7 thru 10	EXISTING SIGNING PLANS
SIGN-11 thru 15	PROPOSED SIGNING PLANS

**SUMMARY OF QUANTITIES**

ITEM NO.	DESC. NO.	SECT. NO.	ITEM DESCRIPTION	QUANTITY	UNIT
4072000000	903		SUPPORTS, 3 LB STEEL U-CHANNEL	550	L.F.
4096000000	904		SIGN ERECTION, TYPE E	29	EA.
4149000000	907		DISPOSAL OF SIGN SYSTEM, OVERHEAD	1	EA.
4155000000	907		DISPOSAL OF SIGN SYSTEM, U-CHANNEL	6	EA.
4082200000	SP		OVERHEAD SIGN ASSEMBLY AT STA 13+00	1	L.S.
4127500000	SP		LRS LIGHTING SYSTEM FOR OVERHEAD SIGN ASSEMBLY AT STA 13+00	1	L.S.

901.10    904.10  
901.20    904.20  
901.50    904.50

PLAN PREPARED BY: N.C.D.O.T. SIGNING SECTION	SEAL
RON KING, P.E.    SIGNING ENGINEER	
A. I. ALQUDWAH, P.E.    SIGNING PROJECT ENGINEER	
D. M. EATON    SIGNING PROJ. DESIGN ENGINEER	
D. IVES    SIGNING DESIGN ENGINEER	