

8/17/99


PROJECT REFERENCE NO.	SHEET NO.
37631	UC-4
DESIGNED BY: NSH	
DRAWN BY: NSH	
CHECKED BY: JSM	
APPROVED BY: JSM	
REVISED:	
NORTH CAROLINA DEPARTMENT OF TRANSPORTATION	
DESIGN SERVICES UNIT PHONE: (919) 250-4128 FAX: (919) 250-4119	
UTILITY CONSTRUCTION PLANS ONLY	

### UTILITY CONSTRUCTION



MATCH LINE STA 15+00 SEE SHEET UC-3

STA 22+00

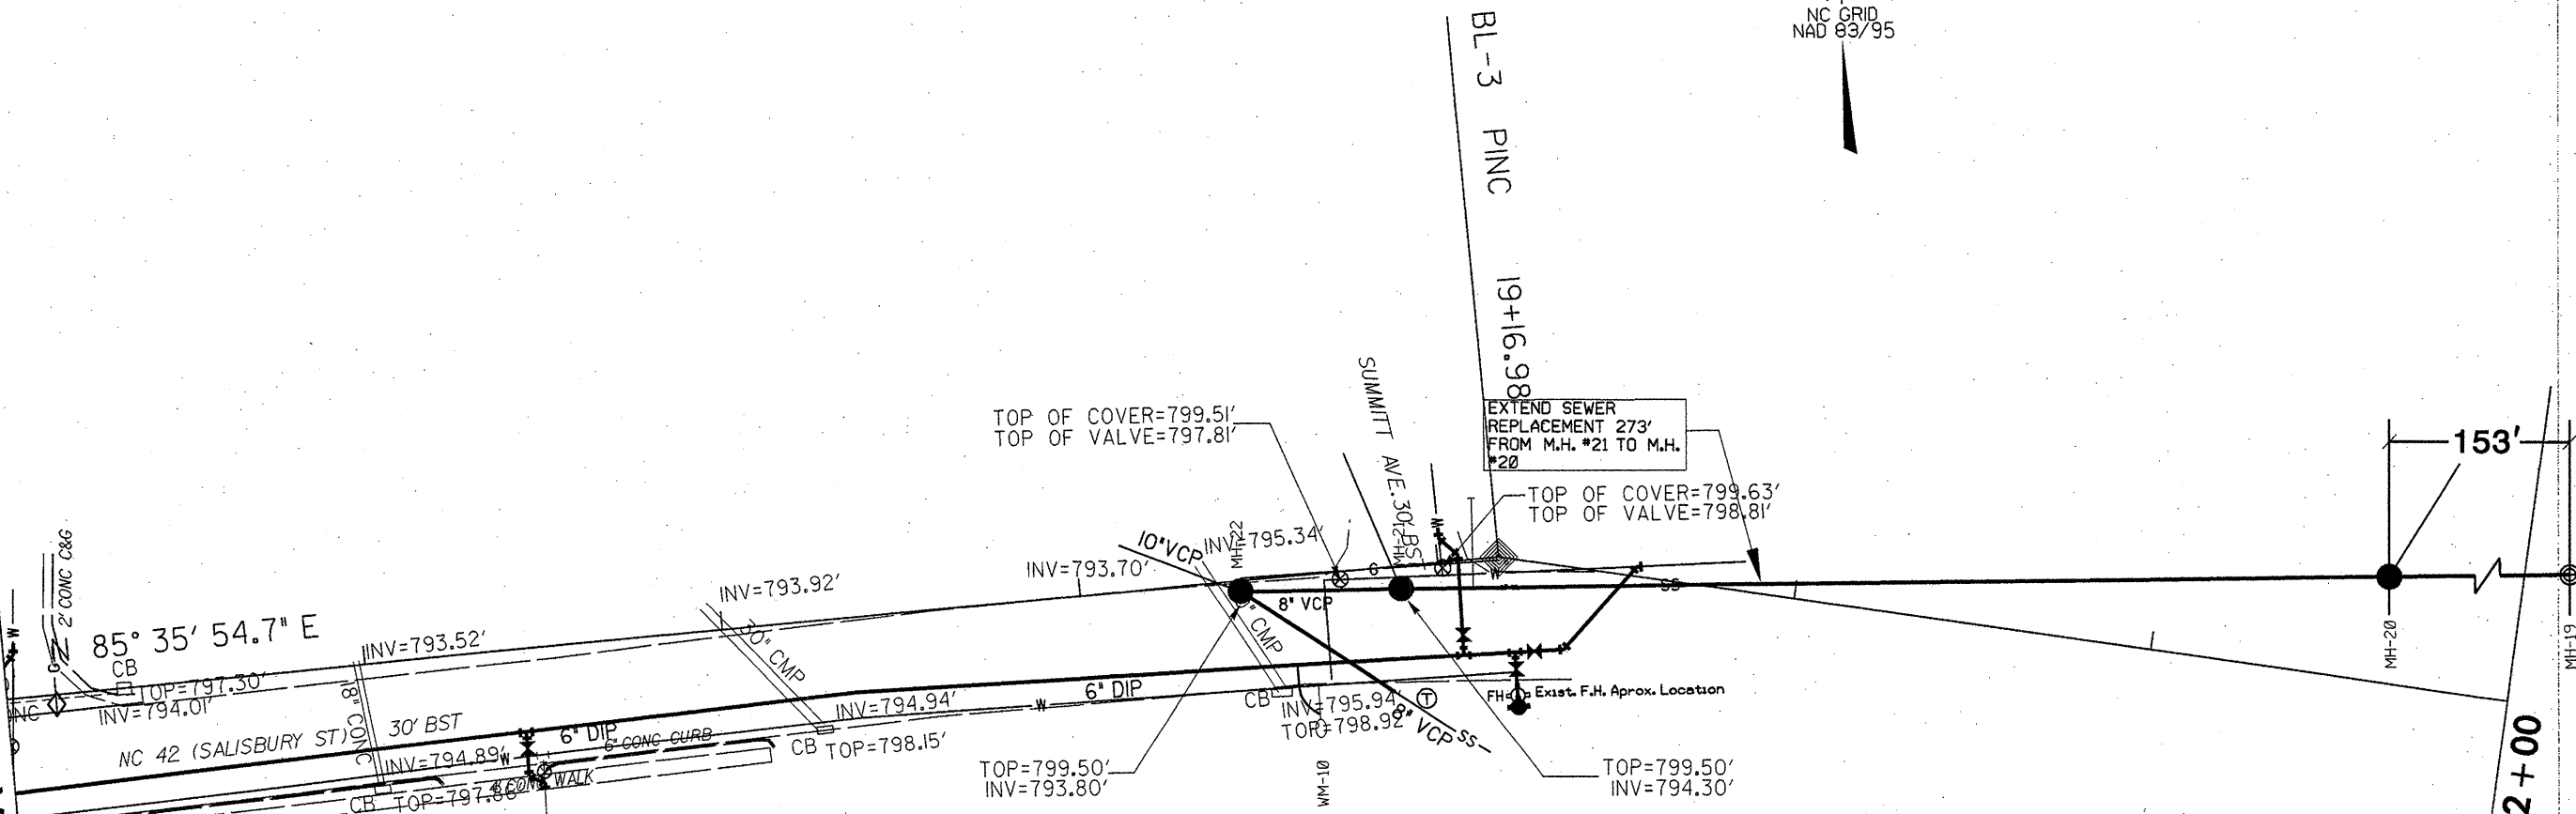

PROP. 522' - 8" DI SEWER PIPE, PC 350  
 3 - 4' DIA. PRECAST M.H.  
 NOTE: INSTALL SEWER PIPE IN EXISTING ALIGNMENT

PROP. 540' - 6" DI WATER PIPE, PC 350  
 7 - 6" DI 45 BEND  
 3 - 6" X 6" DI TEE  
 1 - FIRE HYDRANT  
 4 - 6" GATE VALVE AND VALVE BOX, 200 # WP  
 1 - REMOVE & STOCKPILE EXIST. FIRE HYDRANT  
 4 - 6" TRANSITION COUPLING (CI TO DI)

SCALE: 1" = 25'

14-MAR-2006 16:44 s:\specdes\vt\1324318\sh\ddc\_and\_wbs\wbs\37631\_ashboro\_r\ndolphoo\proj\_pah\Salisbury\_ut\_Uc4\_S06\_WBS\_37631\_Ashboro.dgn