

09/20/15

TIP PROJECT: R-2915A



STATE OF NORTH CAROLINA
DIVISION OF HIGHWAYS

T.I.P. NO.	SHEET NO.
R-2915A	UC-1

UTILITY CONSTRUCTION PLANS
WATAUGA & ASHE COUNTY

LOCATION: US 221 FROM US 421 IN WATAUGA COUNTY
TO SR 1003 (IDLEWILD RD) IN ASHE COUNTY


TYPE OF WORK: UTILITY CONSTRUCTION - NATURAL GAS

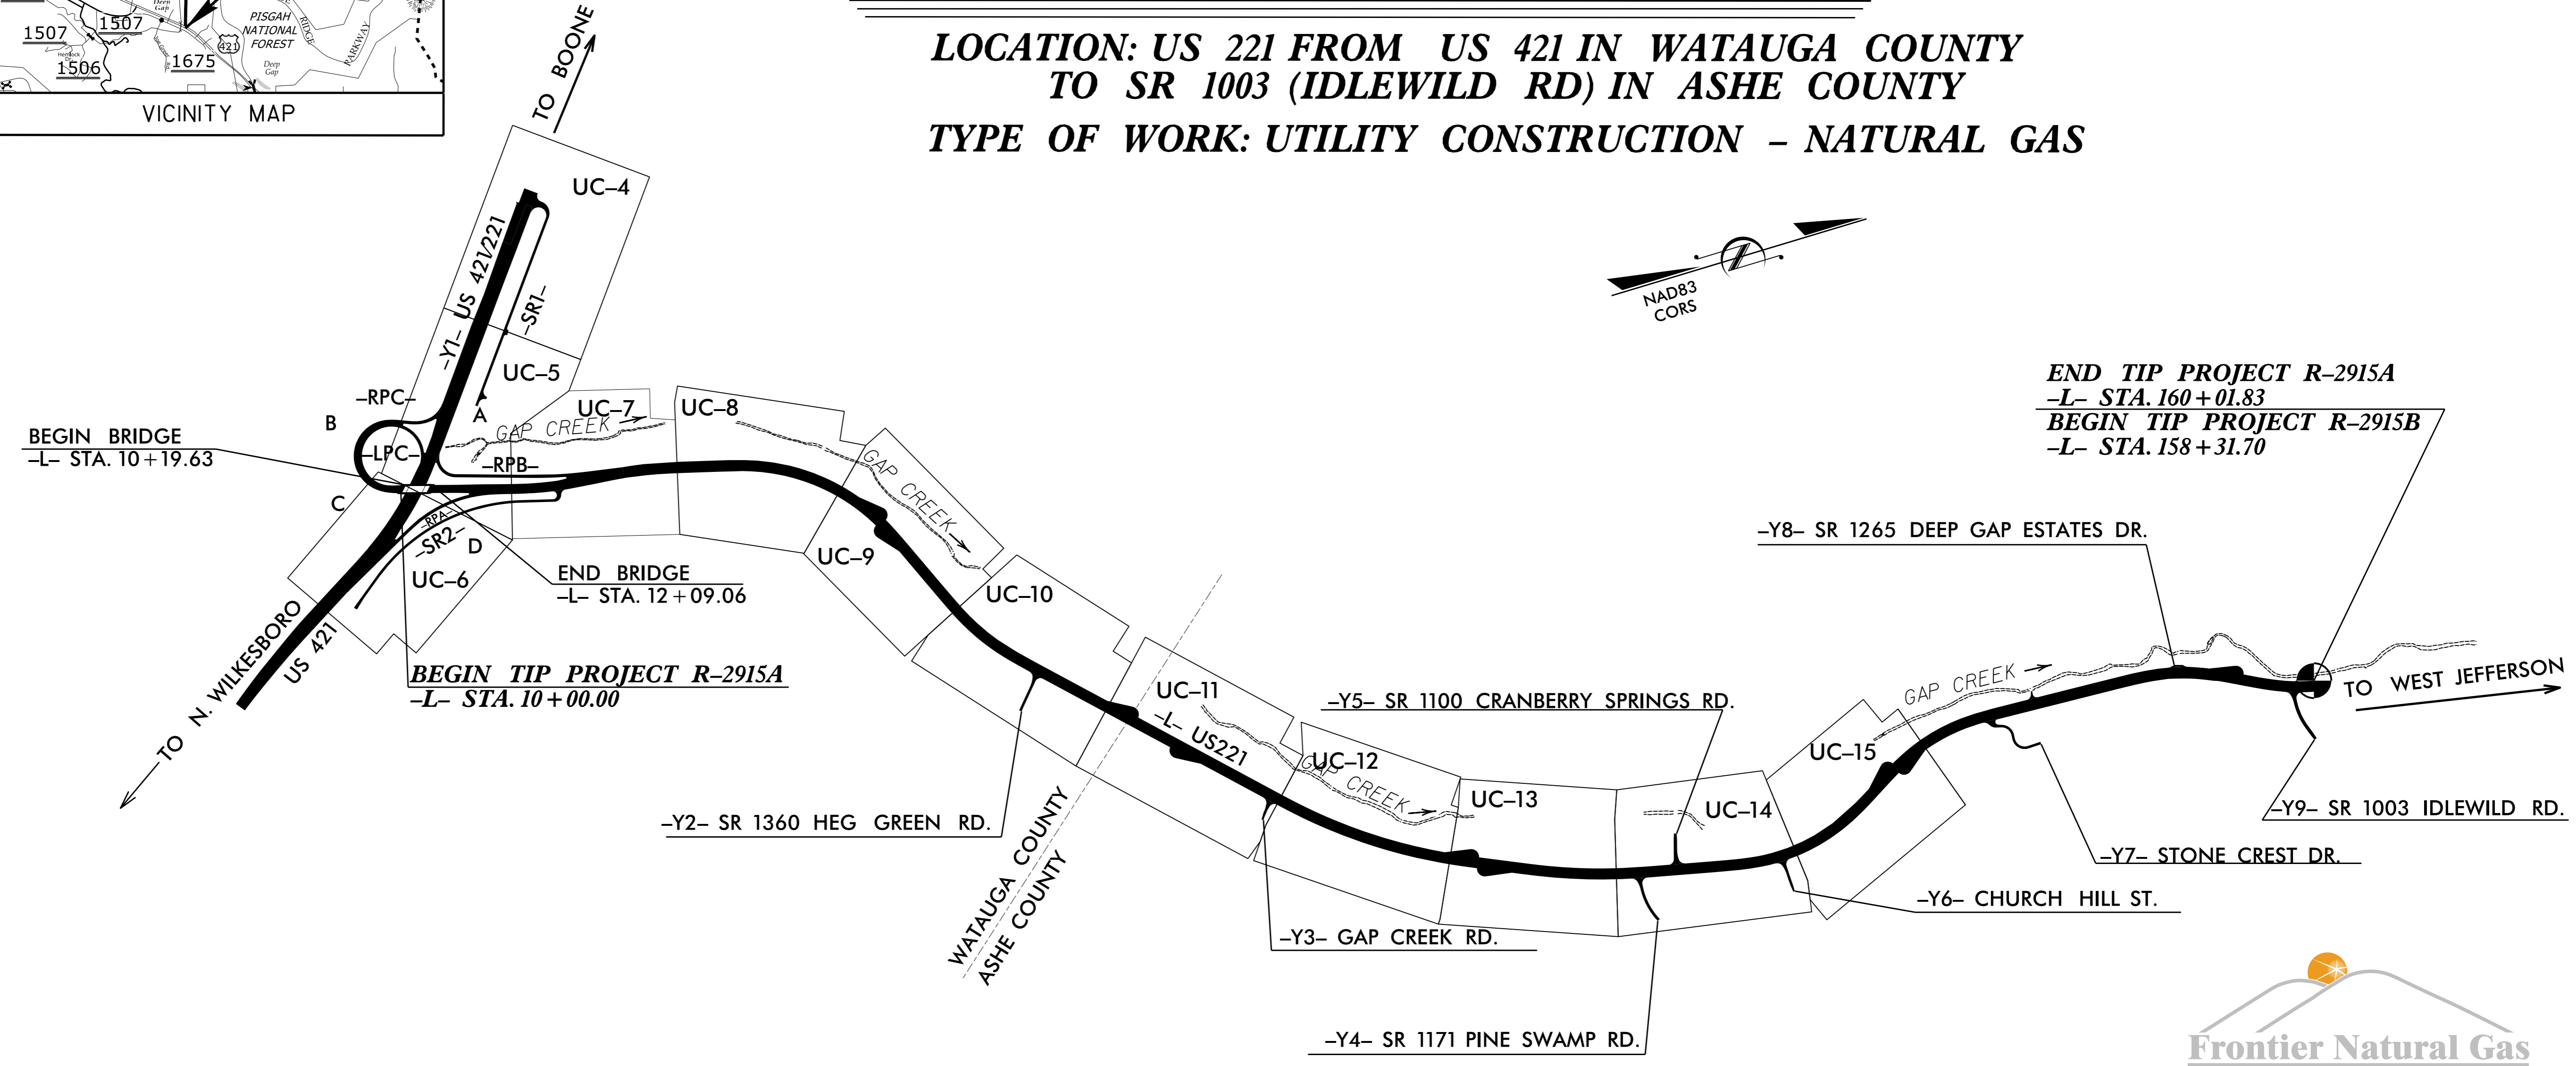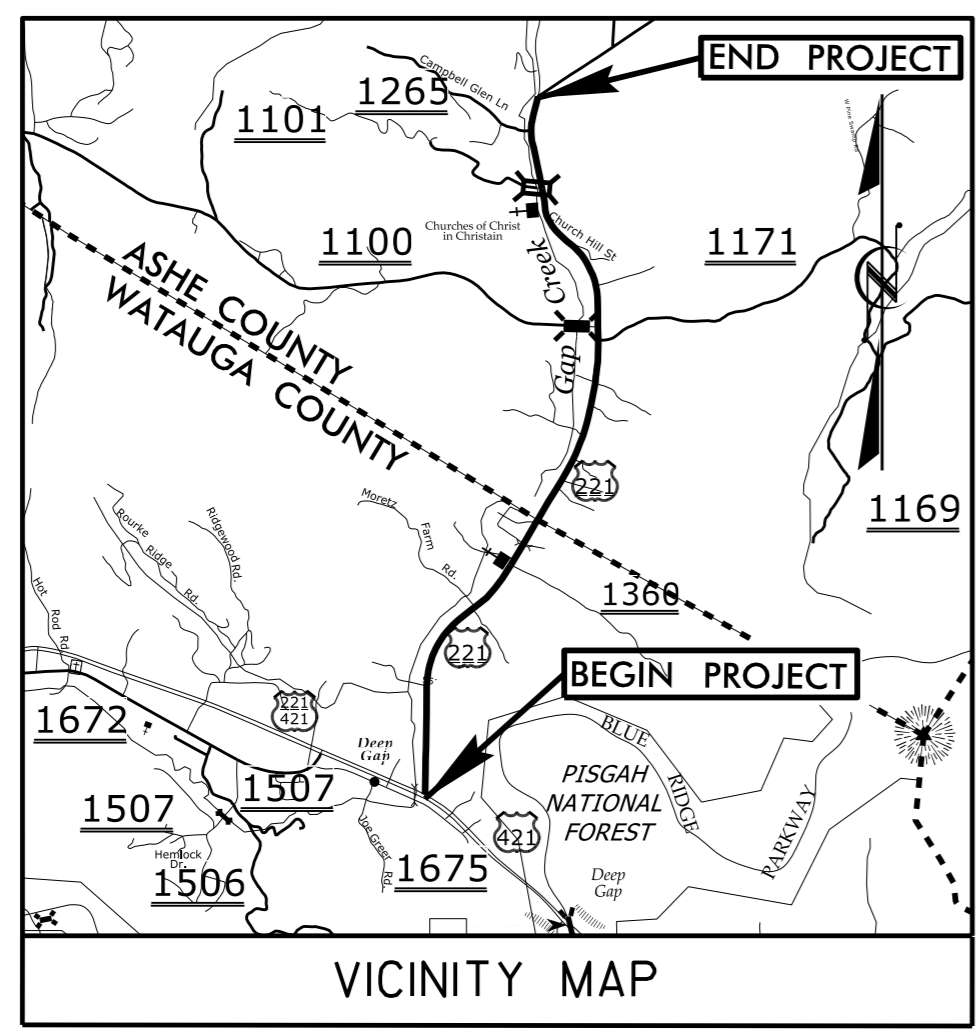

END TIP PROJECT R-2915A
 -L- STA. 160 + 01.83
 BEGIN TIP PROJECT R-2915B
 -L- STA. 158 + 31.70




M A Engineering Consultants, Inc. 598 East Chatham Street - Suite 137
 Cary, NC 27511
 Phone: 919.297.0220 Fax: 919.297.0221
 NC License: F-0160

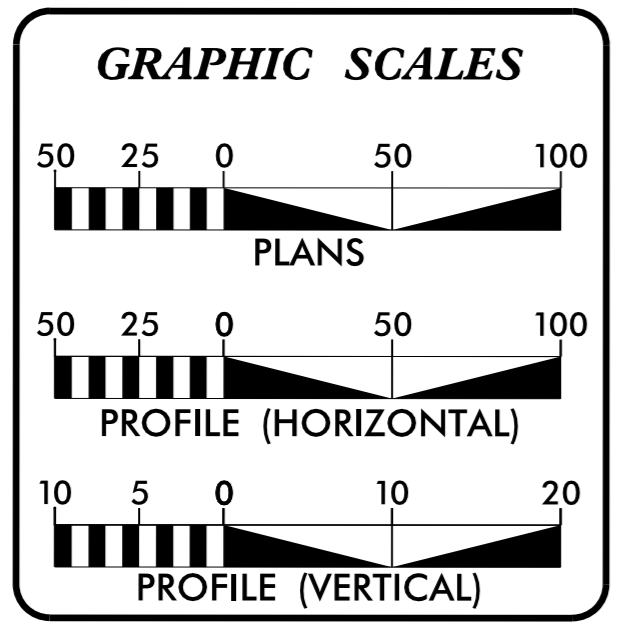

SHEET NO.	DESCRIPTION
UC-1	TITLE SHEET
UC-2	SYMBOLGY SHEET
UC-3 THRU UC-3G	NOTES & DETAIL SHEETS
UC-4 THRU UC-19	PLAN & PROFILE SHEETS
UC-20 THRU UC-22	MECHANICAL DRAWINGS
UC-23	GRADING PLAN

UTILITY OWNER ON PROJECT
 (1) GAS - FRONTIER NATURAL GAS

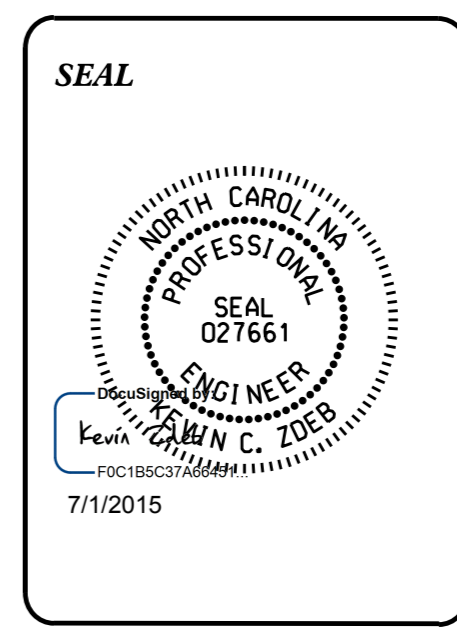

PREPARED IN THE OFFICE OF:
 DIVISION OF HIGHWAYS
 UTILITIES UNIT
 UTILITIES ENGINEERING

1555 MAIL SERVICES CENTER
 RALEIGH NC 27699-1555
 PHONE (919) 707-6690
 FAX (919) 250-4151

Roger Worthington, P.E. UTILITIES SECTION ENGINEER
 Carl Barclay, P.E. UTILITIES SQUAD LEADER PROJECT ENGINEER
 James Swinson UTILITIES PROJECT DESIGNER

\$\$\$\$\$ SYSTEM TIME \$\$\$\$\$\$
\$\$\$\$\$ DDMMYY \$\$\$\$\$\$
\$\$\$\$\$ USERNAME \$\$\$\$\$\$