


PROJECT REFERENCE NO. W-5103A	SHEET NO. 1C-3
RW SHEET NO.	

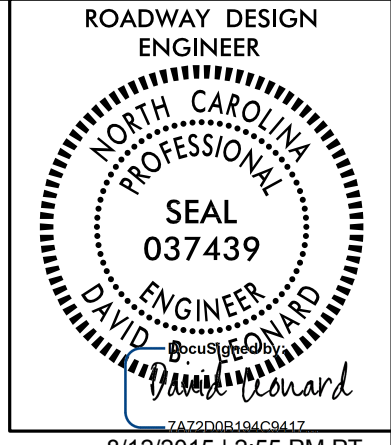

8/12/2015 | 2:55 PM PT




STATE OF NORTH CAROLINA
DIVISION OF HIGHWAYS
SURVEY CONTROL SHEET

8/17/99

REVISIONS

03-AUG-2015 12:47 NEW HANDOVER\W-5103-41867-1.1.1.US 421 Median Crossover Relet (use this file)\ROADWAY\Proj\Plan_Sheets\W5103A-D03_RdJ-1C-3.dgn
\$\$\$\$\$SUSTAINABLE\$\$\$\$\$

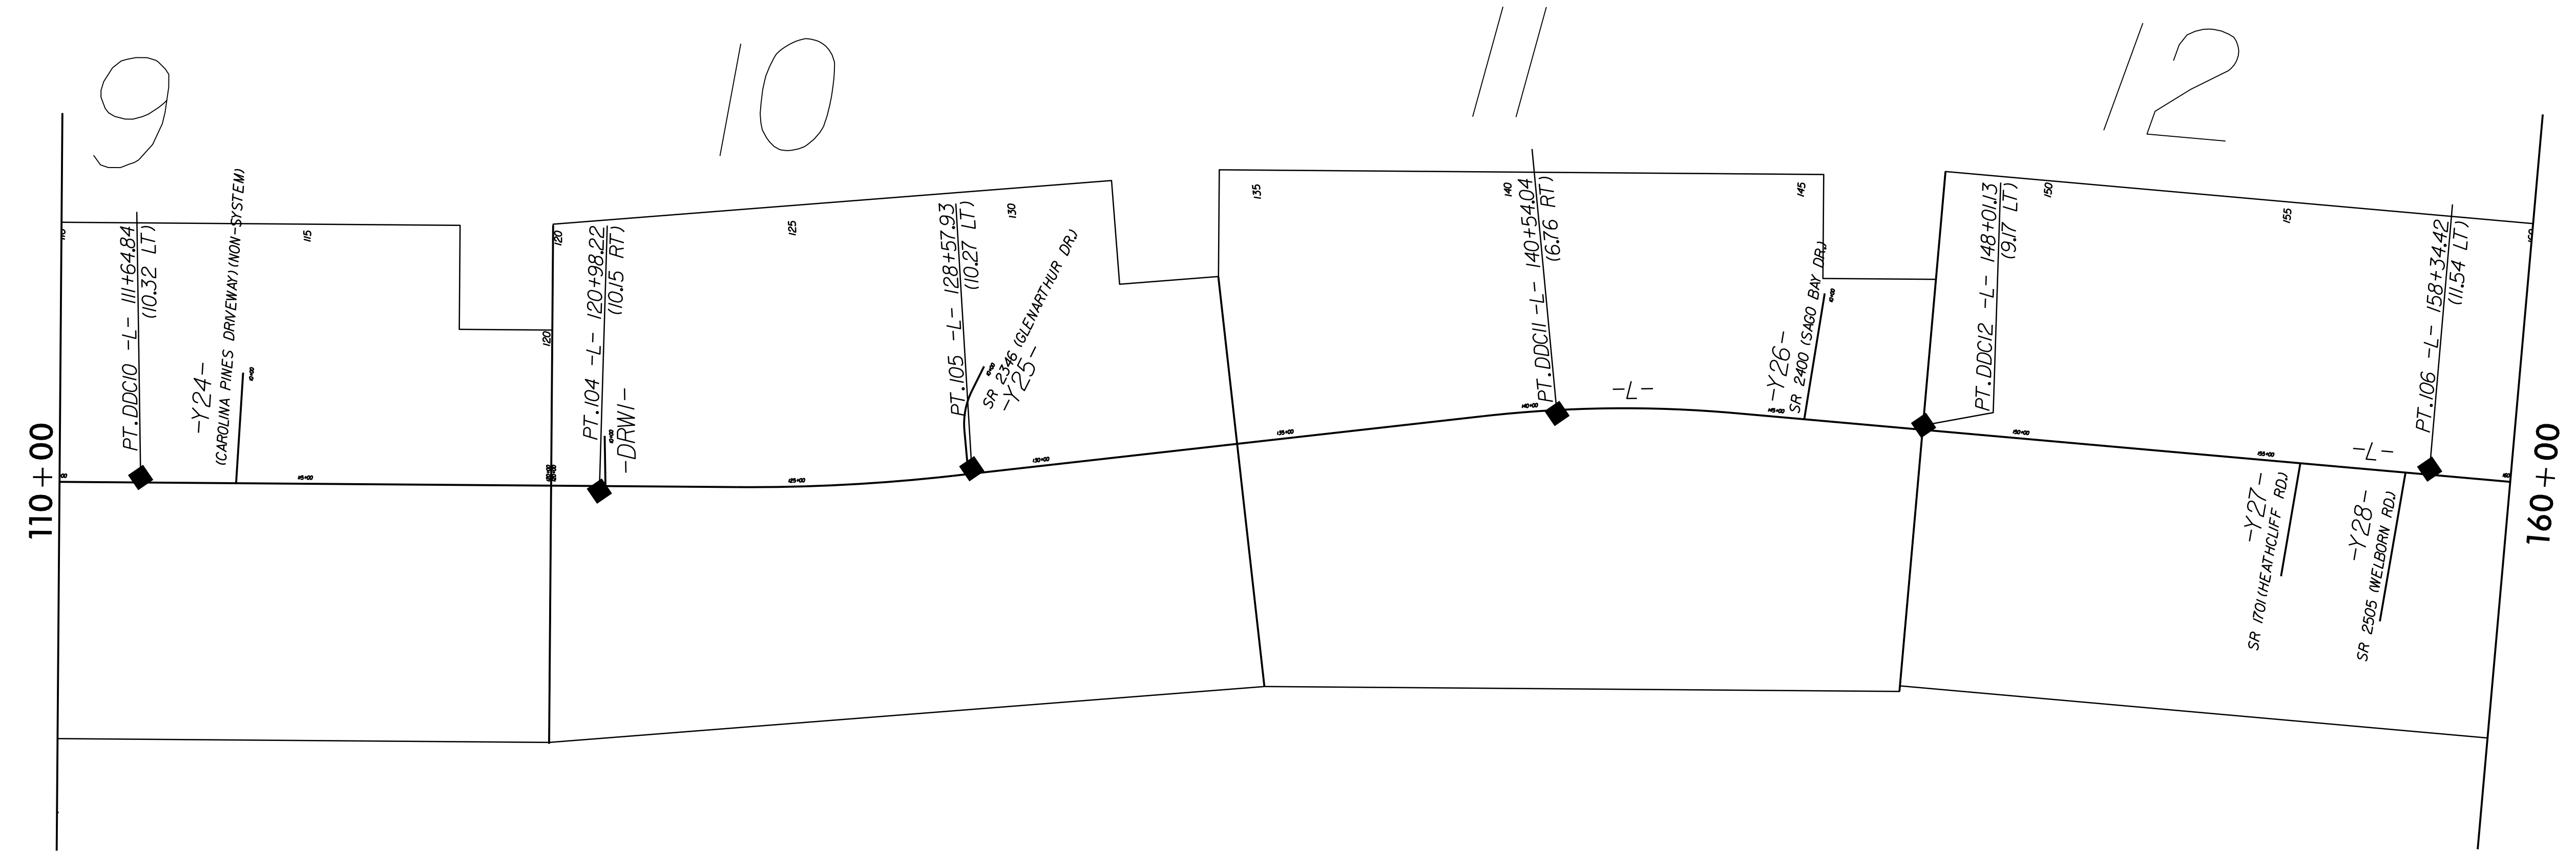

CONTROL POINTS LIST (THIS SHEET):
 P1 104 : N 126678.56 : E 2333907.23 : Z 28.19
 P1 105 : N 127414.75 : E 2333723.03 : Z 25.09
 P1 106 : N 130329.90 : E 2333177.91 : Z 34.39
 P1 DDC10 : N 125756.22 : E 2334051.77 : Z 26.12
 P1 DDC11 : N 128564.27 : E 2333393.45 : Z 26.60
 P1 DDC12 : N 129301.68 : E 2333280.06 : Z 28.79

NOT TO SCALE