


PROJECT REFERENCE NO. W-5103A	SHEET NO. 1C-5
RW SHEET NO.	

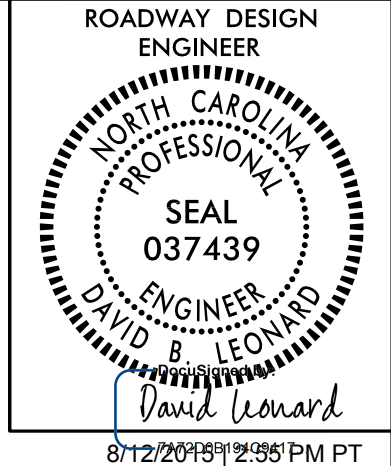


NAD 83/NSRS 2007

STATE OF NORTH CAROLINA
DIVISION OF HIGHWAYS
SURVEY CONTROL SHEET

8/17/99

REVISIONS

03-AUG-2015 12:47 NEW HANDOVER W-5103-41867-1.1.1 US 421 Median Crossover Relet (use this file) \ROADWAY\Proj\NPlan_Sheets\W5103A-D03_RdJ-1C-5.dgn
\$\$\$\$\$SUSPENSE\$\$\$\$\$

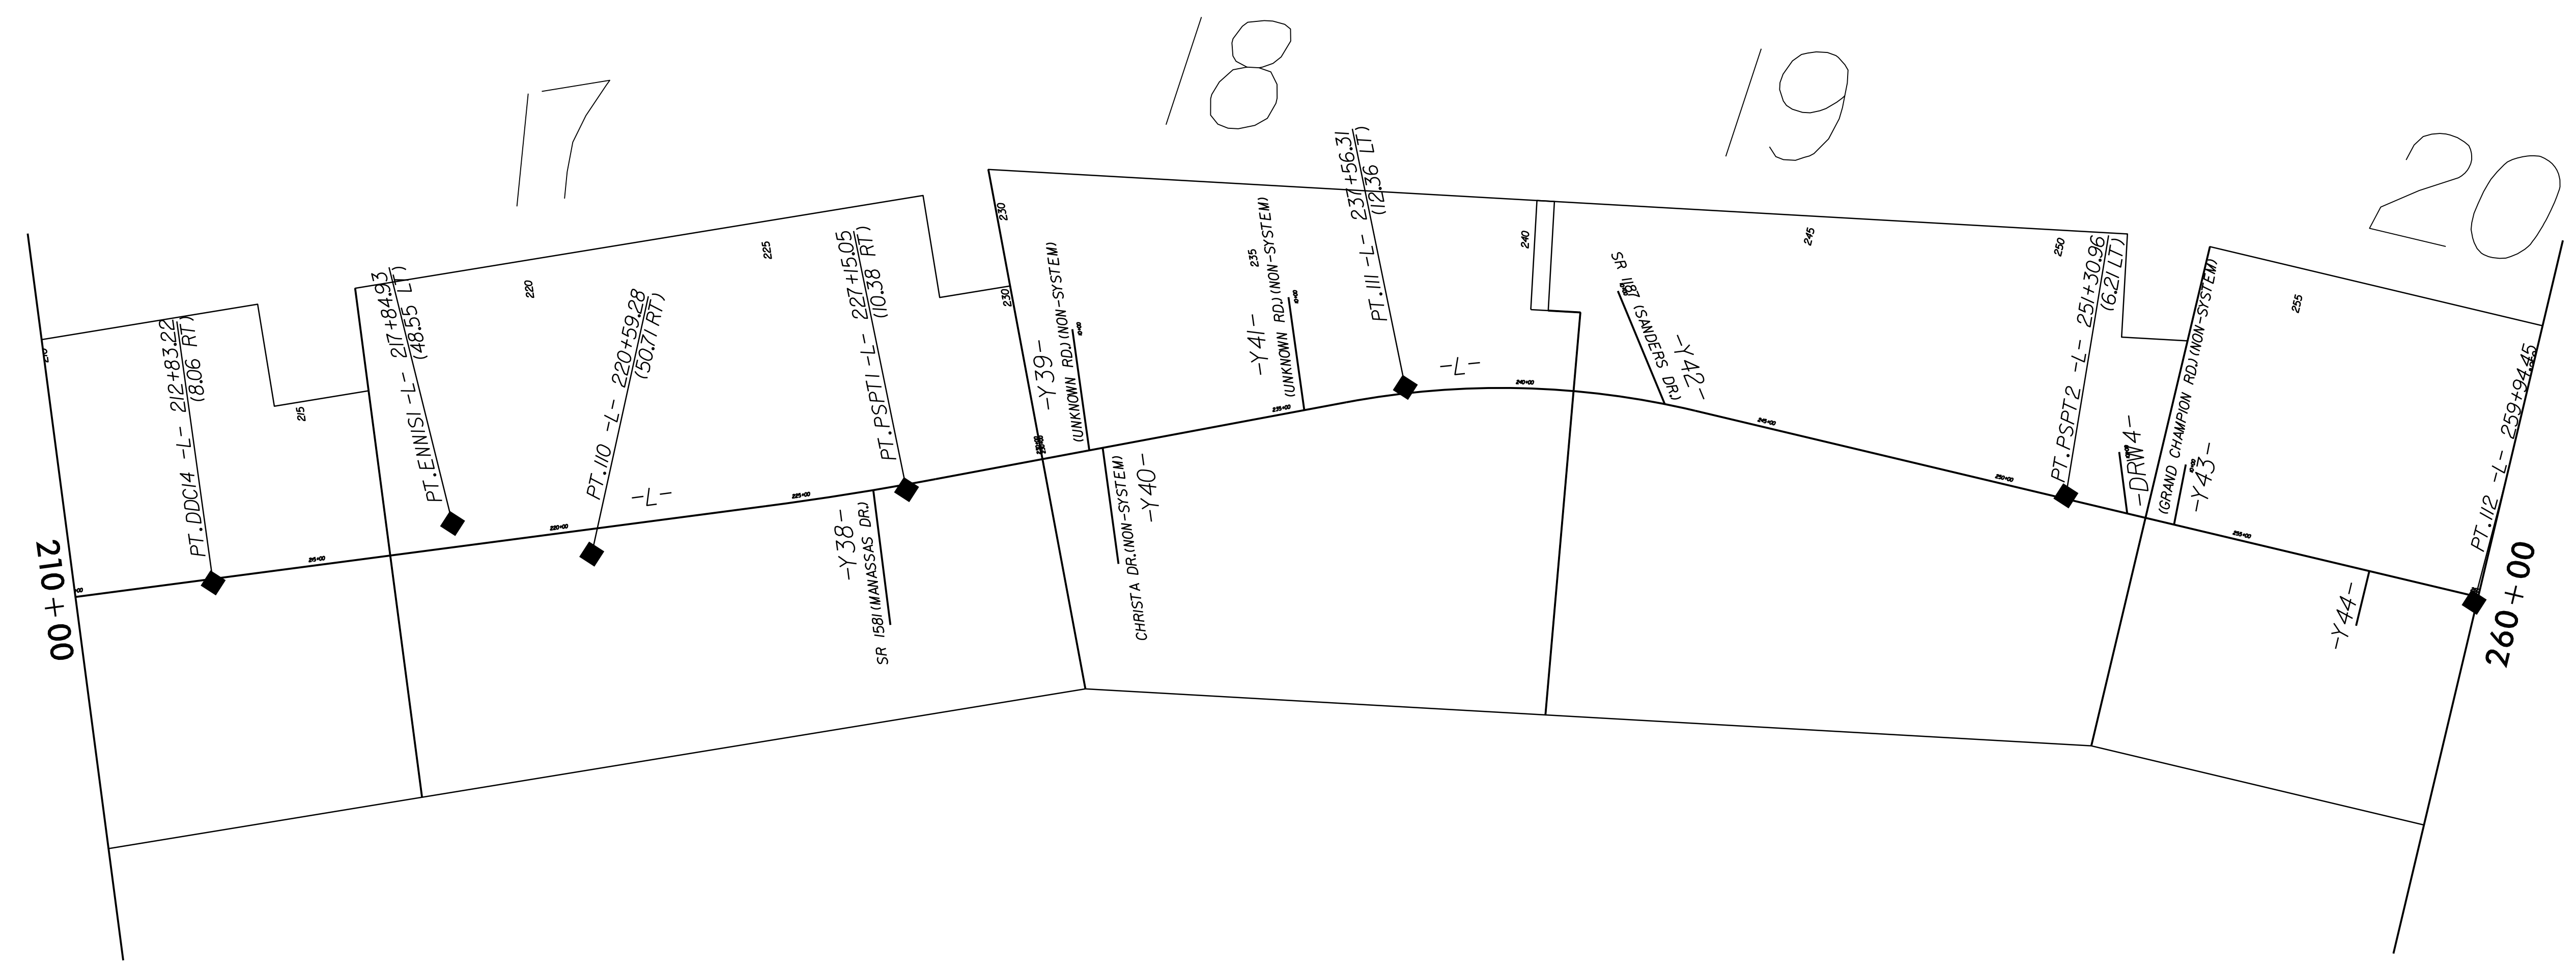

CONTROL POINTS LIST (THIS SHEET):

PT I10	: N 136526.65	: E 2332932.50	: Z 49.74
PT III	: N 138226.66	: E 2332949.22	: Z 39.20
PT I12	: N 140273.32	: E 2333839.35	: Z 35.54
PT DDC14	: N 135756.60	: E 2332827.09	: Z 47.35
PT ENNIS1	: N 136261.24	: E 2332811.34	: Z 49.23
PT PSPT1	: N 137184.42	: E 2332939.04	: Z 44.25
PT PSPT2	: N 139502.06	: E 2333450.61	: Z 34.34

NOT TO SCALE