

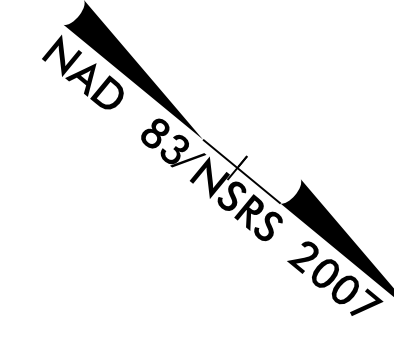


PROJECT REFERENCE NO. W-5103A	SHEET NO. 1C-7
RW SHEET NO.	

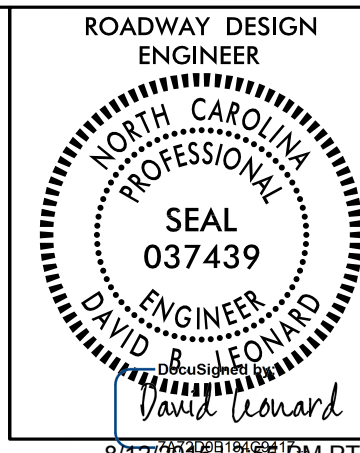

STATE OF NORTH CAROLINA  
DIVISION OF HIGHWAYS  
**SURVEY CONTROL SHEET**

25                      26                      27                      28

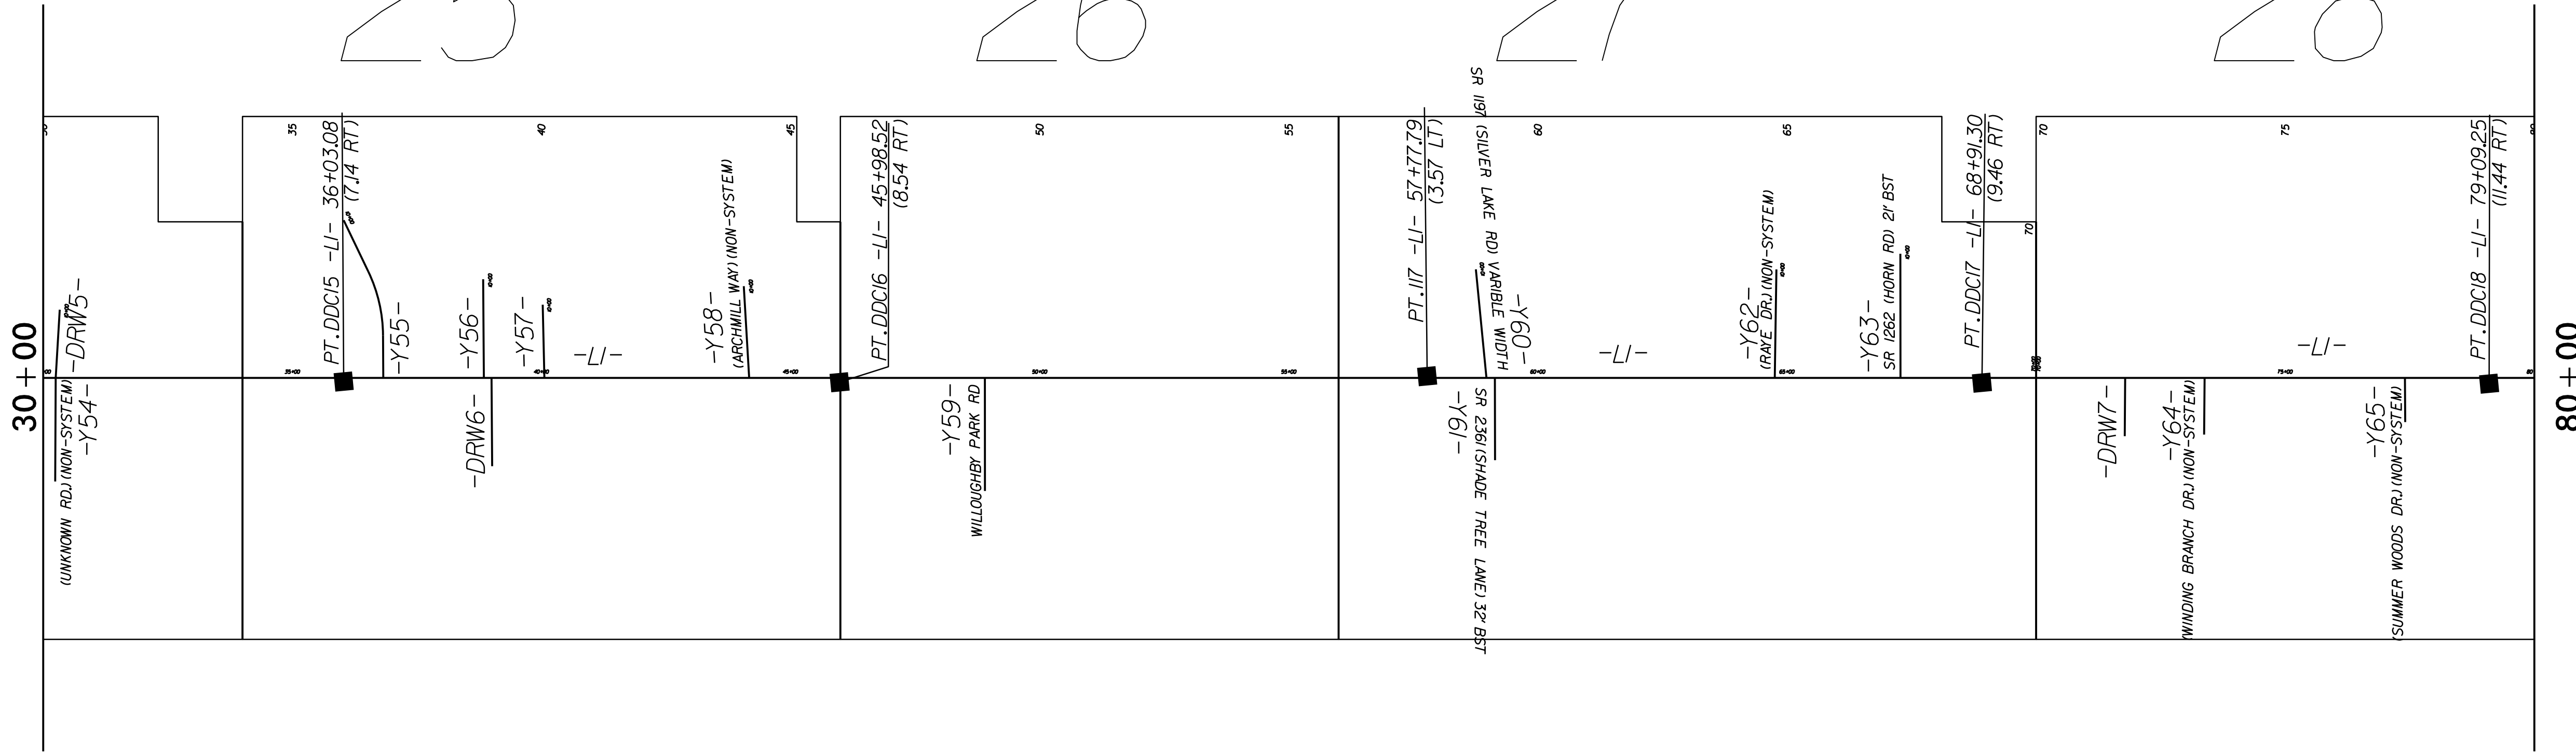

REVISIONS  
 03-AUG-2016 12:47 NEW HANDOVER W-5103.41867.1.1.1 US 421 Median Crossover Relet (use this file) \ROADWAY\Proj\Plan\_Sheets\W5103A\_D03\_RdJ\_IC-7.dgn  
 \$\$\$SUSTAINABLE\$\$\$

CONTROL POINTS LIST (THIS SHEET):  
 P1 N17 : N 147397.14 : E 2331680.52 : Z 18.39  
 P1 DDC15 : N 145727.61 : E 2333274.13 : Z 21.03  
 P1 DDC16 : N 146495.82 : E 2332641.09 : Z 19.90  
 P1 DDC17 : N 148263.78 : E 2331181.24 : Z 21.30  
 P1 DDC18 : N 149049.72 : E 2330534.30 : Z 21.75

**NOT TO SCALE**