



STATE OF NORTH CAROLINA
DEPARTMENT OF TRANSPORTATION

TIP NO. W-5103A	SHEET NO. SIGN-1
APPROVED: <i>David Leonard</i> 7A7202B194C9417	
DATE: 8/13/2015 12:16 PM PT	
SEAL	

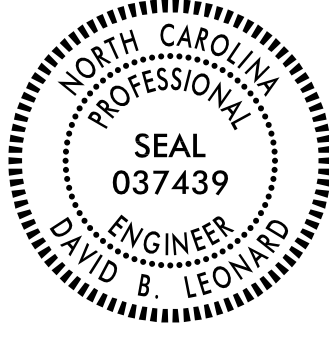

SIGNING PLAN
NEW HANOVER COUNTY

LOCATION: US 421 (CAROLINA BEACH RD.) FROM BRIDGE NO. 30 (SNOW'S CUT BRIDGE)
TO 0.31 MI. NORTH OF GEORGE ANDERSON DR. (NON-SYSTEM).

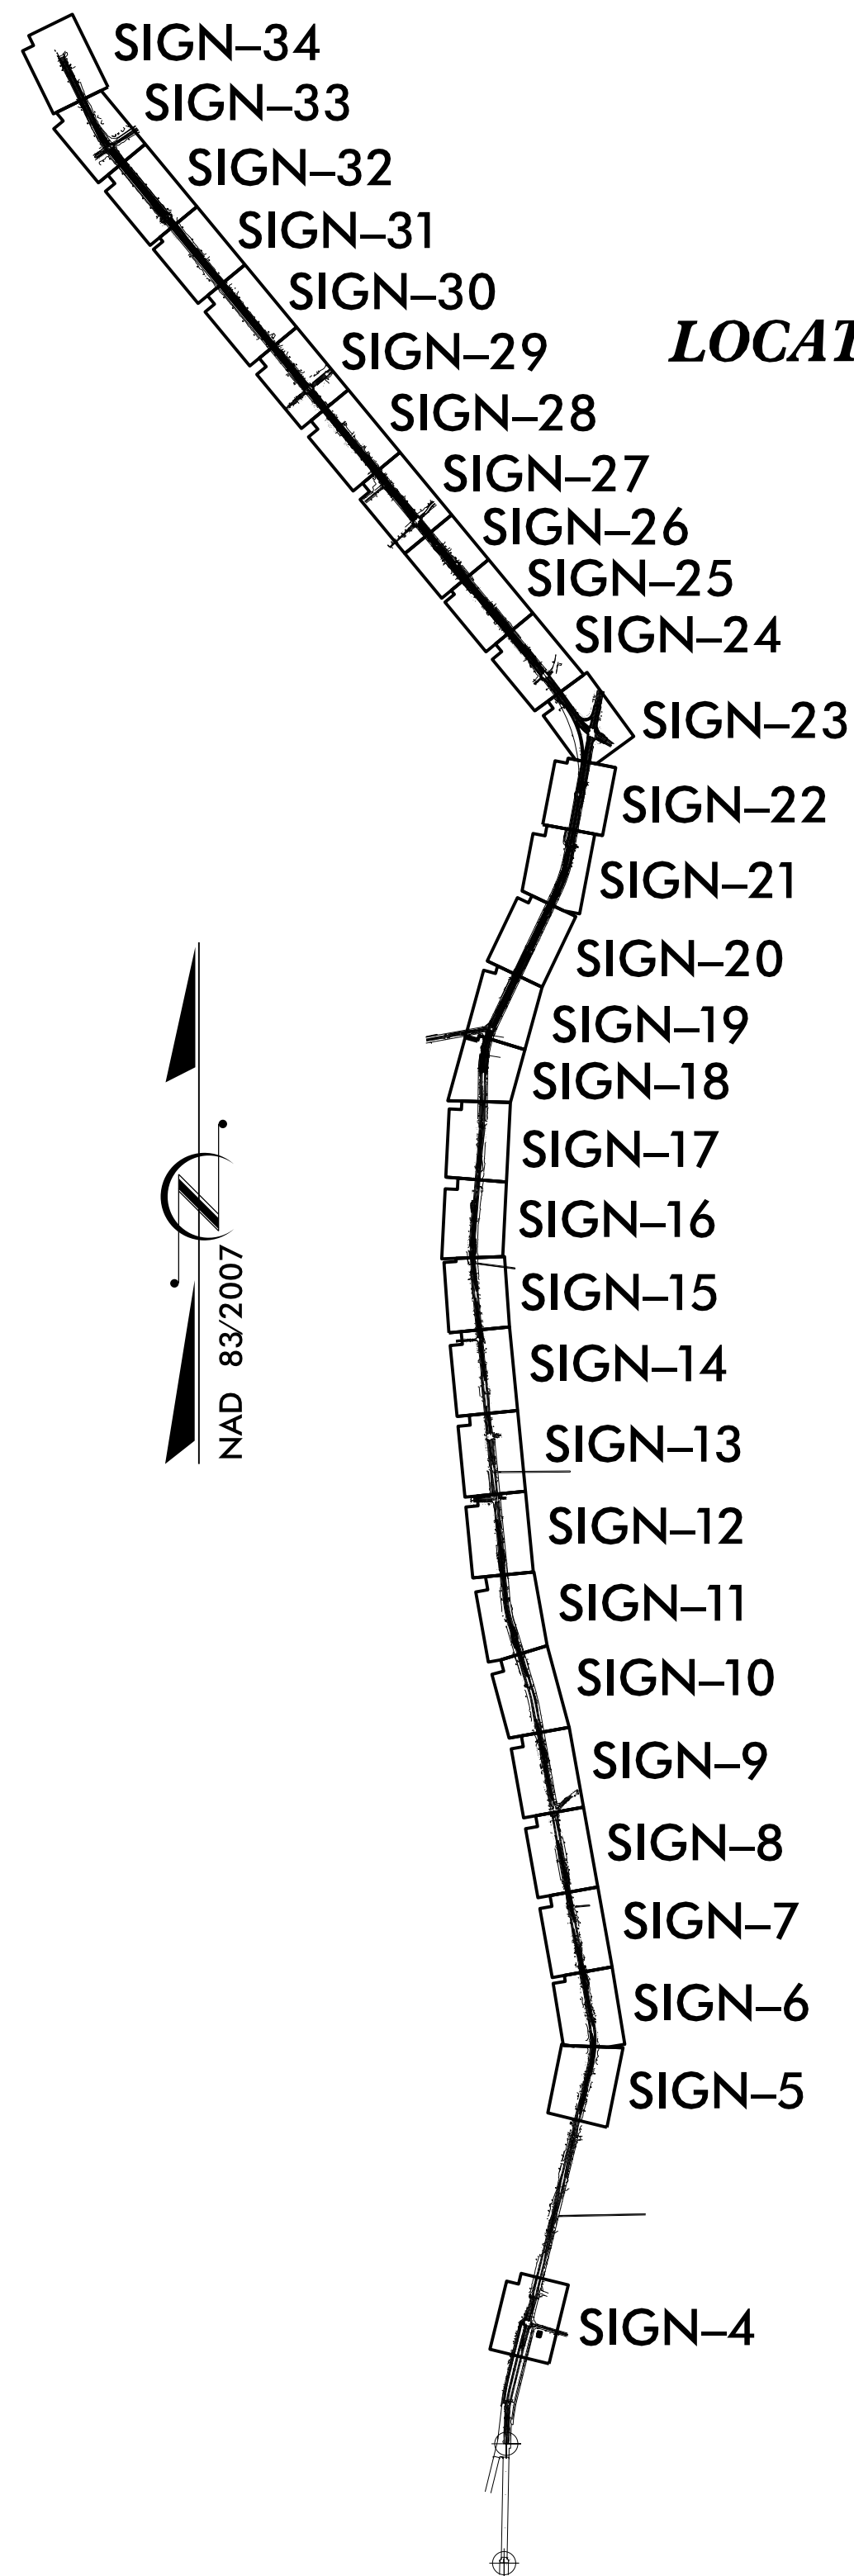

ROADWAY STANDARD DRAWING

THE FOLLOWING ROADWAY STANDARDS AS APPEAR IN "ROADWAY STANDARD DRAWINGS" - PROJECT SERVICES UNIT - N.C. DEPARTMENT OF TRANSPORTATION - RALEIGH, N.C., DATED JANUARY 2012 ARE APPLICABLE TO THIS PROJECT AND BY REFERENCE HEREBY ARE CONSIDERED A PART OF THESE PLANS:

STD. NO.	TITLE
903.10	GROUND MOUNTED SIGN SUPPORTS
903.20	WOOD SIGN SUPPORTS
904.10	ORIENTATION OF GROUND MOUNTED SIGNS
904.50	MOUNTING OF TYPE 'D', 'E' AND 'F' SIGNS ON 'U' CHANNEL POSTS

INDEX

SHEET NO.	DESCRIPTION
SIGN-1	TITLE SHEET
SIGN-3-3A	E AND F SHEETS
SIGN-4-34	SIGNING PLAN SHEETS

SUMMARY OF QUANTITIES

ITEM NO.	ITEM DESCRIPTION	QUANTITY	UNIT
DESC. NO.	SECT. NO.		
4025000000	901	780.75	S.F.
4025000000	901	314.13	S.F.
4072000000	903	1500	L.F.
4102000000	904	83	EA.
4108000000	904	37	EA.

GENERAL NOTES


- . SIGNS FURNISHED BY CONTRACTOR
- . WHEN NOT STATIONED OR DIMENSIONED ON PLANS, ALL 'E' AND 'F' SIGNS SHALL BE FIELD LOCATED BY THE ENGINEER
- . THE BACKGROUND FOR TYPE E & F SIGNS SHALL BE TYPE C REFLECTIVE SHEETING.

T.I.P.: W-5103A

CONTRACT: C203755

PLAN REVIEWED BY: N.C.D.O.T. SIGNING AND DELINEATION UNIT

AYMAN I. ALQUDWAH, P.E. SIGNING & DELINEATION REGIONAL ENGINEER,
EASTERN REGION (DIVISIONS 1-4, 6)

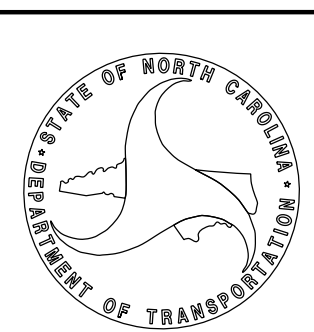

PLAN PREPARED BY: NCDOT, DIVISION 3 DDC

CARLA M. SCHOONMAKER ENGINEERING TECHNICIAN