


STATE OF NORTH CAROLINA
DIVISION OF HIGHWAYS

TRANSYLVANIA COUNTY

LOCATION: ROADWAY IMPROVEMENTS ON CALDWELL STREET FROM ROSMAN HIGHWAY (US 64) TO PROBART STREET

TYPE OF WORK: TRAFFIC SIGNALS

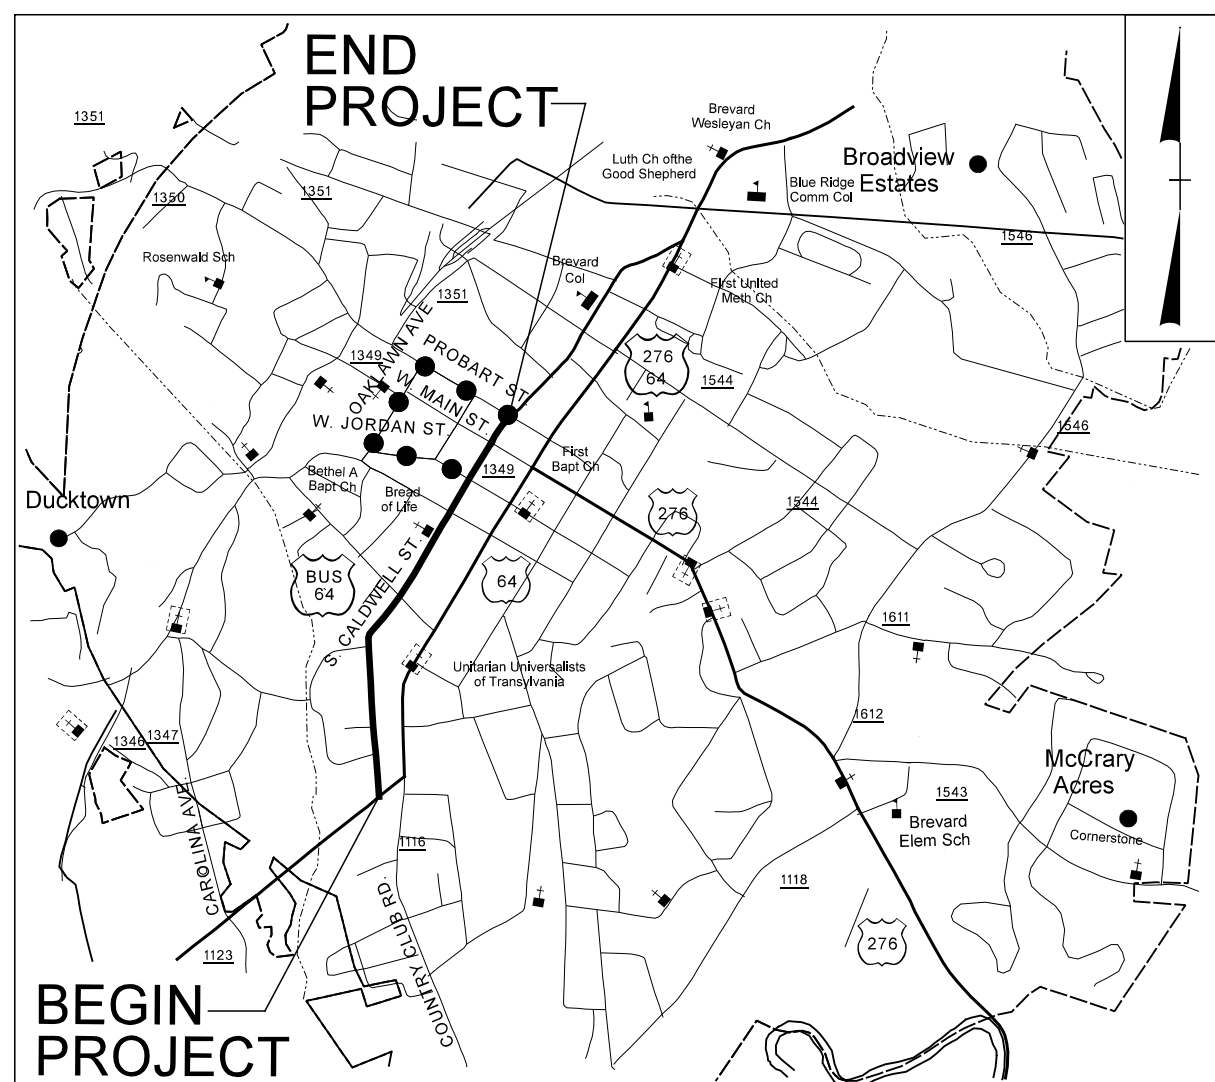


VICINITY MAP

OFF-SITE DETOUR ROUTE



BEGIN CONSTRUCTION
-L- STA 10+28.80

BEGIN TIP PROJECT U-5104
-L- STA 10+00.00

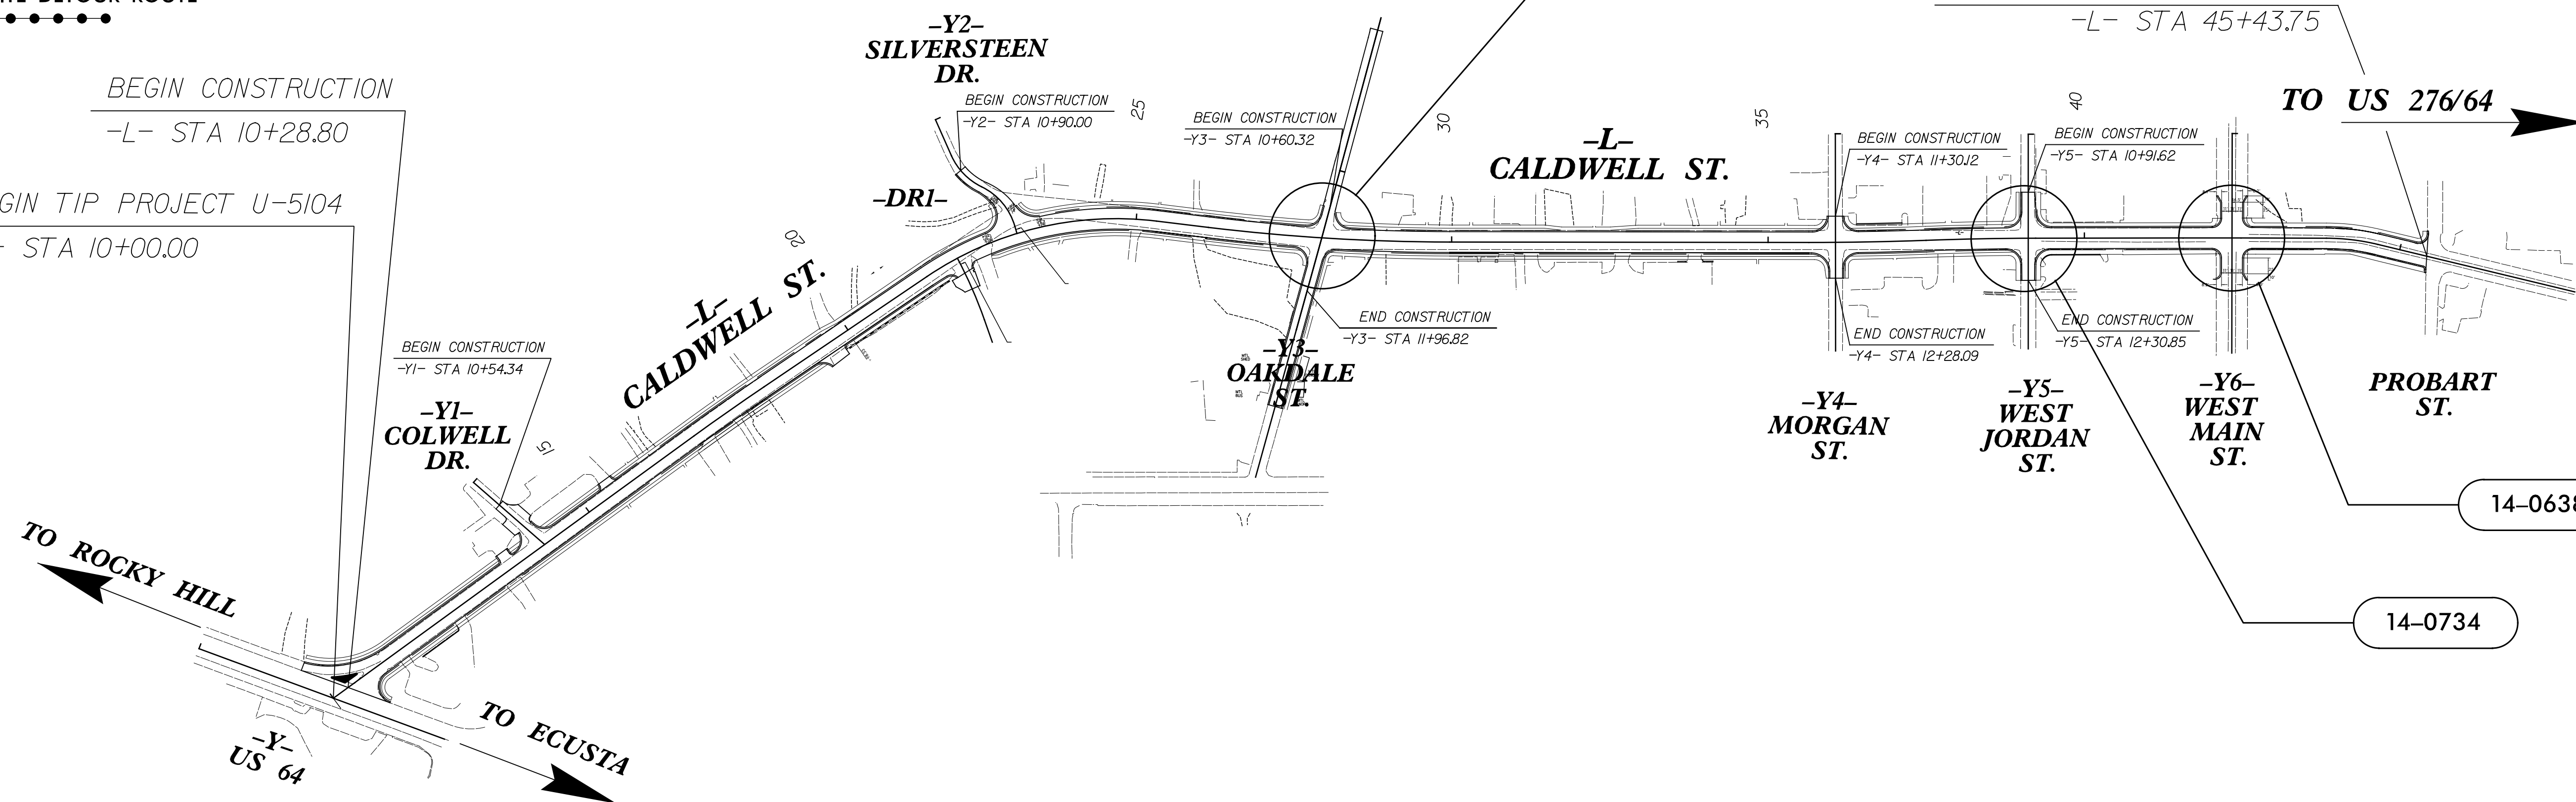

TIP PROJECT: U-5104

PLANS PREPARED BY:



1025 Wade Avenue
Raleigh, NC 27605
Tel: 919-789-9977
Fax: 919-789-9591
License #: C-2197

JOSEPH B. KOPASKIE, P.E. - PROJECT ENGINEER
MATTHEW B. COPPLE, PE - DESIGN ENGINEER
CLIFF LAWSON, E.I. - DESIGN ENGINEER

INDEX OF PLANS

SHEET NUMBER	SIGNAL INV. NUMBER	LOCATION / DESCRIPTION
Sig. 1.0	-	TITLE SHEET
Sig. 2.0 - 5.0	14-0909	US 64 BUS.(CALDWELL STREET) AT OAKDALE STREET
Sig. 6.0 - 9.0	14-0734	US 64 BUS.(CALDWELL STREET) AT JORDAN STREET
Sig. 10.0 - 11.0	14-0638	US 64 BUS.(CALDWELL STREET) AT SR 1349 MAIN STREET
MI - M9	-	NCDOT METAL POLE STANDARDS DRAWINGS
PI - P3	-	NCDOT STANDARD PUSHBUTTON DETAILS
SCP-I - SCP11	-	SIGNAL COMMUNICATIONS PLANS

LEGEND


##-###
SIGNAL INVENTORY NUMBER

PLANS PREPARED FOR:

TRANSPORTATION MOBILITY AND SAFETY DIVISION
TIMOTHY J. WILLIAMS, P.E. - WESTERN REGION SIGNALS ENGINEER
ZACHARY M. LITTLE, P.E. - SIGNAL PROJECT ENGINEER
GEORGE C. BROWN, P.E. - SIGNAL EQUIPMENT DESIGN ENGINEER



ALL DIMENSIONS IN THESE PLANS ARE IN FEET UNLESS OTHERWISE NOTED

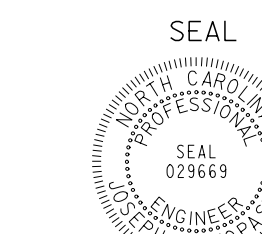

DocuSigned by Joseph Kopaskie 8/7/2015 DATE