

Project: W-5206AM



STATE OF NORTH CAROLINA
DIVISION OF HIGHWAYS

Project No.	Sheet No.
W-5206AM	Sig. 1.0

CUMBERLAND

LOCATION: NC 24/NC87 FROM BARRINGTON CROSS STREET TO EAST OF MARTIN LUTHER KING WESTBOUND RAMPS; AND NC 24/ NC 210 (ROWAN STREET) BETWEEN RAY AVENUE AND RAMSEY STREET

TYPE OF WORK: GRADING, PAVING, DRAINAGE, SIGNING, PAVEMENT MARKINGS, & SIGNALS

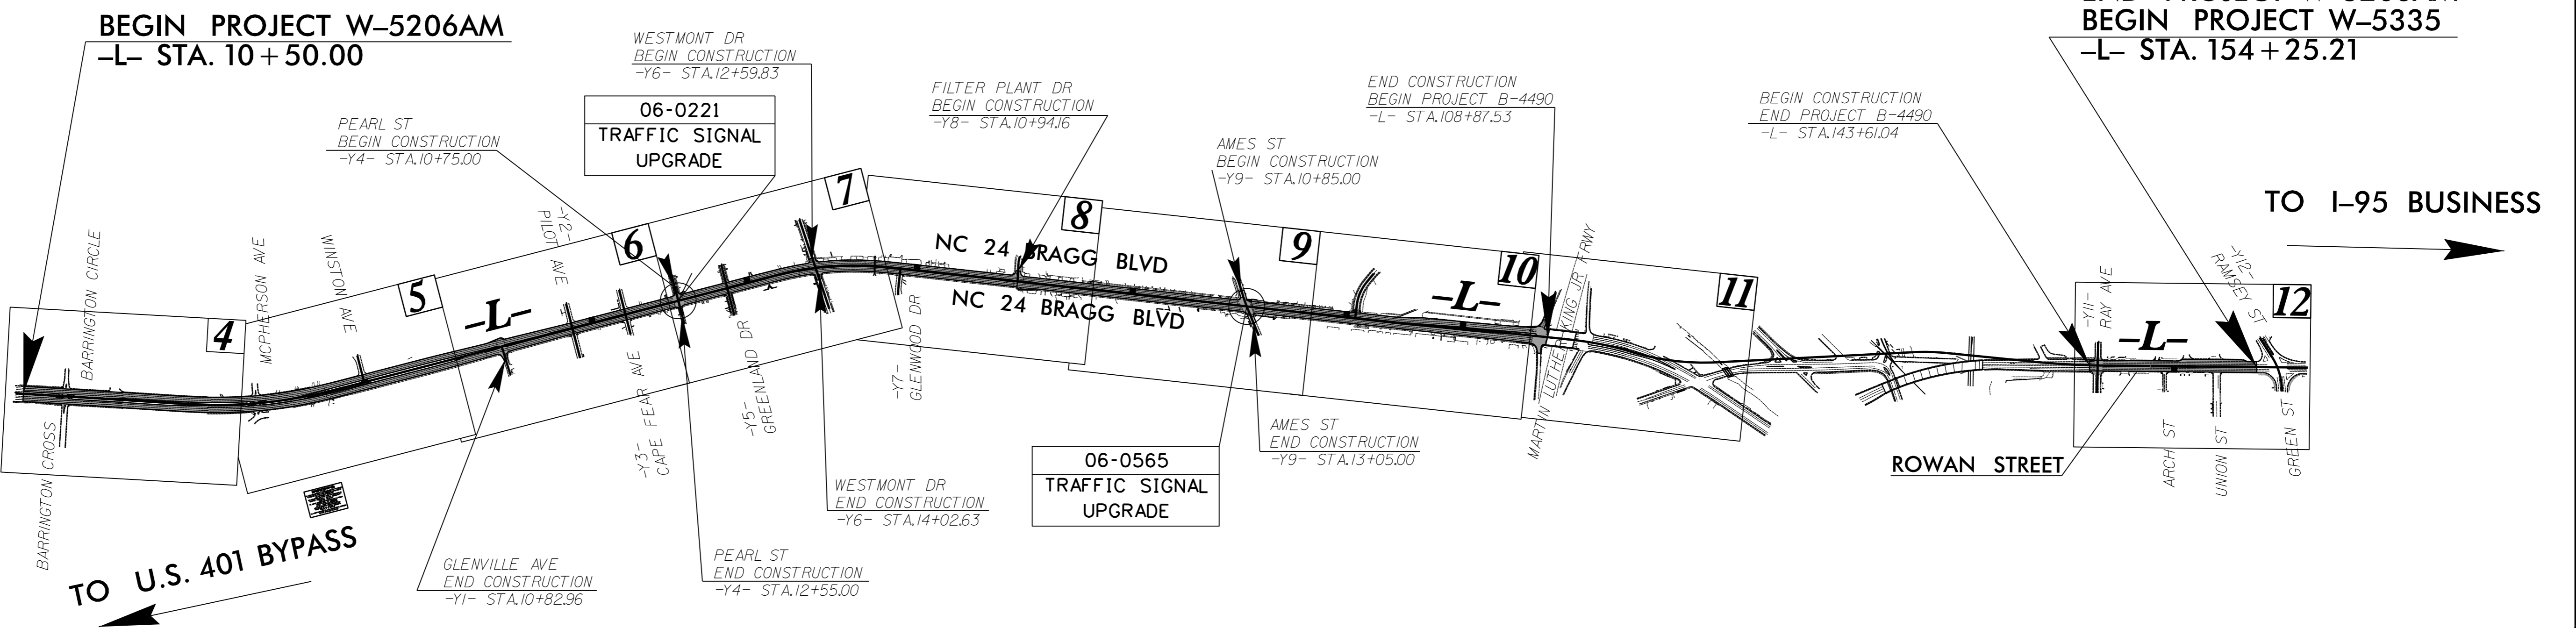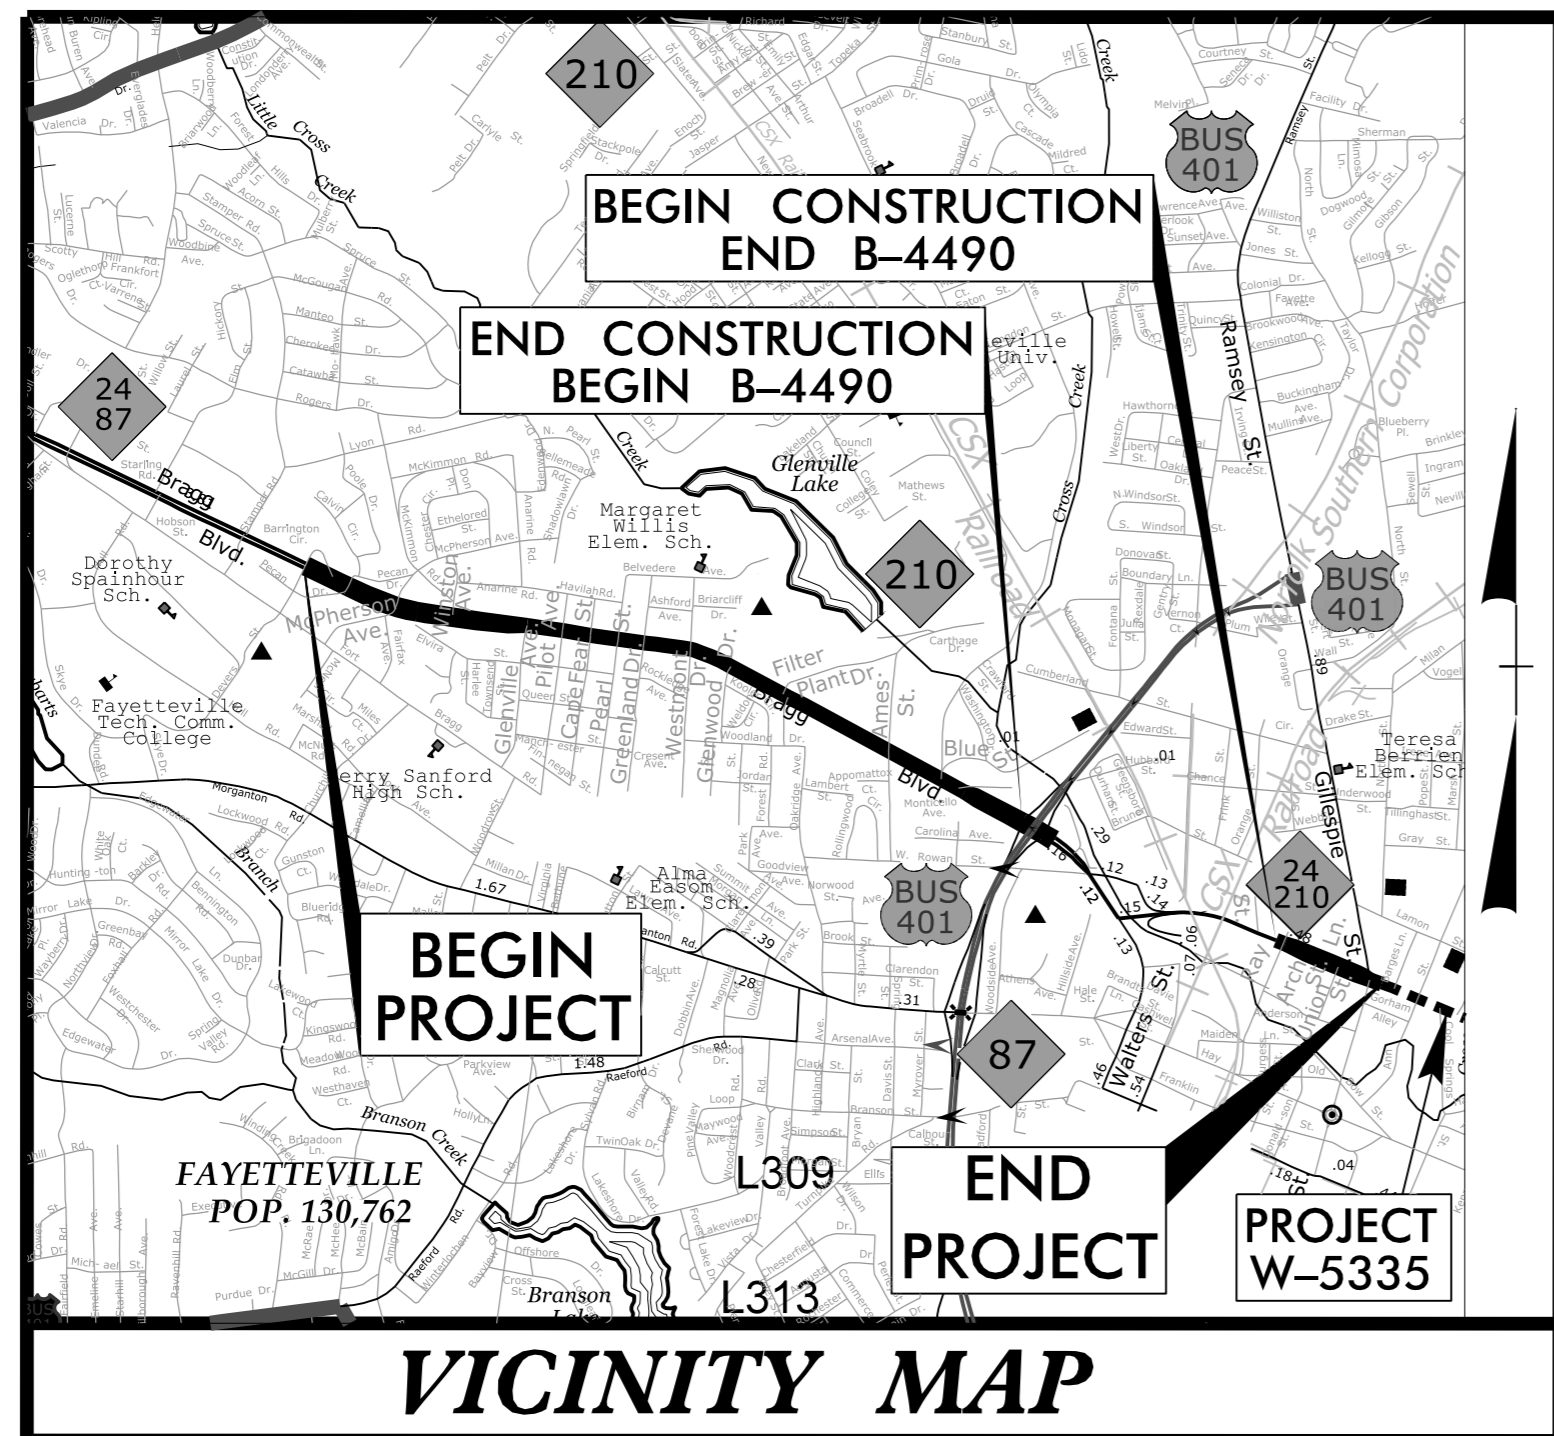

Refer to "Roadway Standard Drawings NCDOT" dated January 2012 and "Standard Specifications for Roads and Structures" dated January 2012.

Sheet #	Reference #	Index of Plans	Location/Description
Sig. 1.0	N/A	Title Sheet	
Sig. 2.0	05-0221	NC 24/NC 87 (Bragg Blvd) at Pearl Street / Signal Design	
Sig. 2.1	05-0221	NC 24/NC 87 (Bragg Blvd) at Pearl Street / Electrical Details-1	
Sig. 2.2	05-0221	NC 24/NC 87 (Bragg Blvd) at Pearl Street / Electrical Details-2	
Sig. 3.0	05-0565	NC 24/NC 87 (Bragg Blvd) at Ames Street / Signal Design	
Sig. 3.1	05-0565	NC 24/NC 87 (Bragg Blvd) at Ames Street / Electrical Details-1	
Sig. 3.2	05-0565	NC 24/NC 87 (Bragg Blvd) at Ames Street / Electrical Details-2	
Sig. 3.3	05-0565	NC 24/NC 87 (Bragg Blvd) at Ames Street / Electrical Details-3	
Sig. 3.4	05-0565	NC 24/NC 87 (Bragg Blvd) at Ames Street / Electrical Details-4	

INTELLIGENT TRANSPORTATION AND SIGNALS UNIT

Contacts:

Pamela L. Alexander, PE - Eastern Region Signals Engineer
Todd Joyce, PE - Signal Equipment Design Engineer
I. Neil Avery - Intelligent Transportation Systems Engineer

Prepared In the Office of:
DIVISION OF HIGHWAYS
TRANSPORTATION MOBILITY AND SAFETY
DIVISION

750 N. Greenfield Parkway, Garner, NC 27529

9/28/2015 9:49:55 AM T:\SIGNALS\2015\W-5206AM\SIG. 1.0.dgn