


DRAWING NOTES:

- CONTRACTOR TO COORDINATE ELECTRICAL SERVICE INSTALLATION WITH POWER COMPANY.
- EXACT LOCATION OF ELECTRICAL SERVICE POLE TO BE DETERMINED IN FIELD. POLE BY POWER COMPANY.
- SEE ANTENNA POLE DETAILS ON SHEET E003.


UTILITY CONSTRUCTION

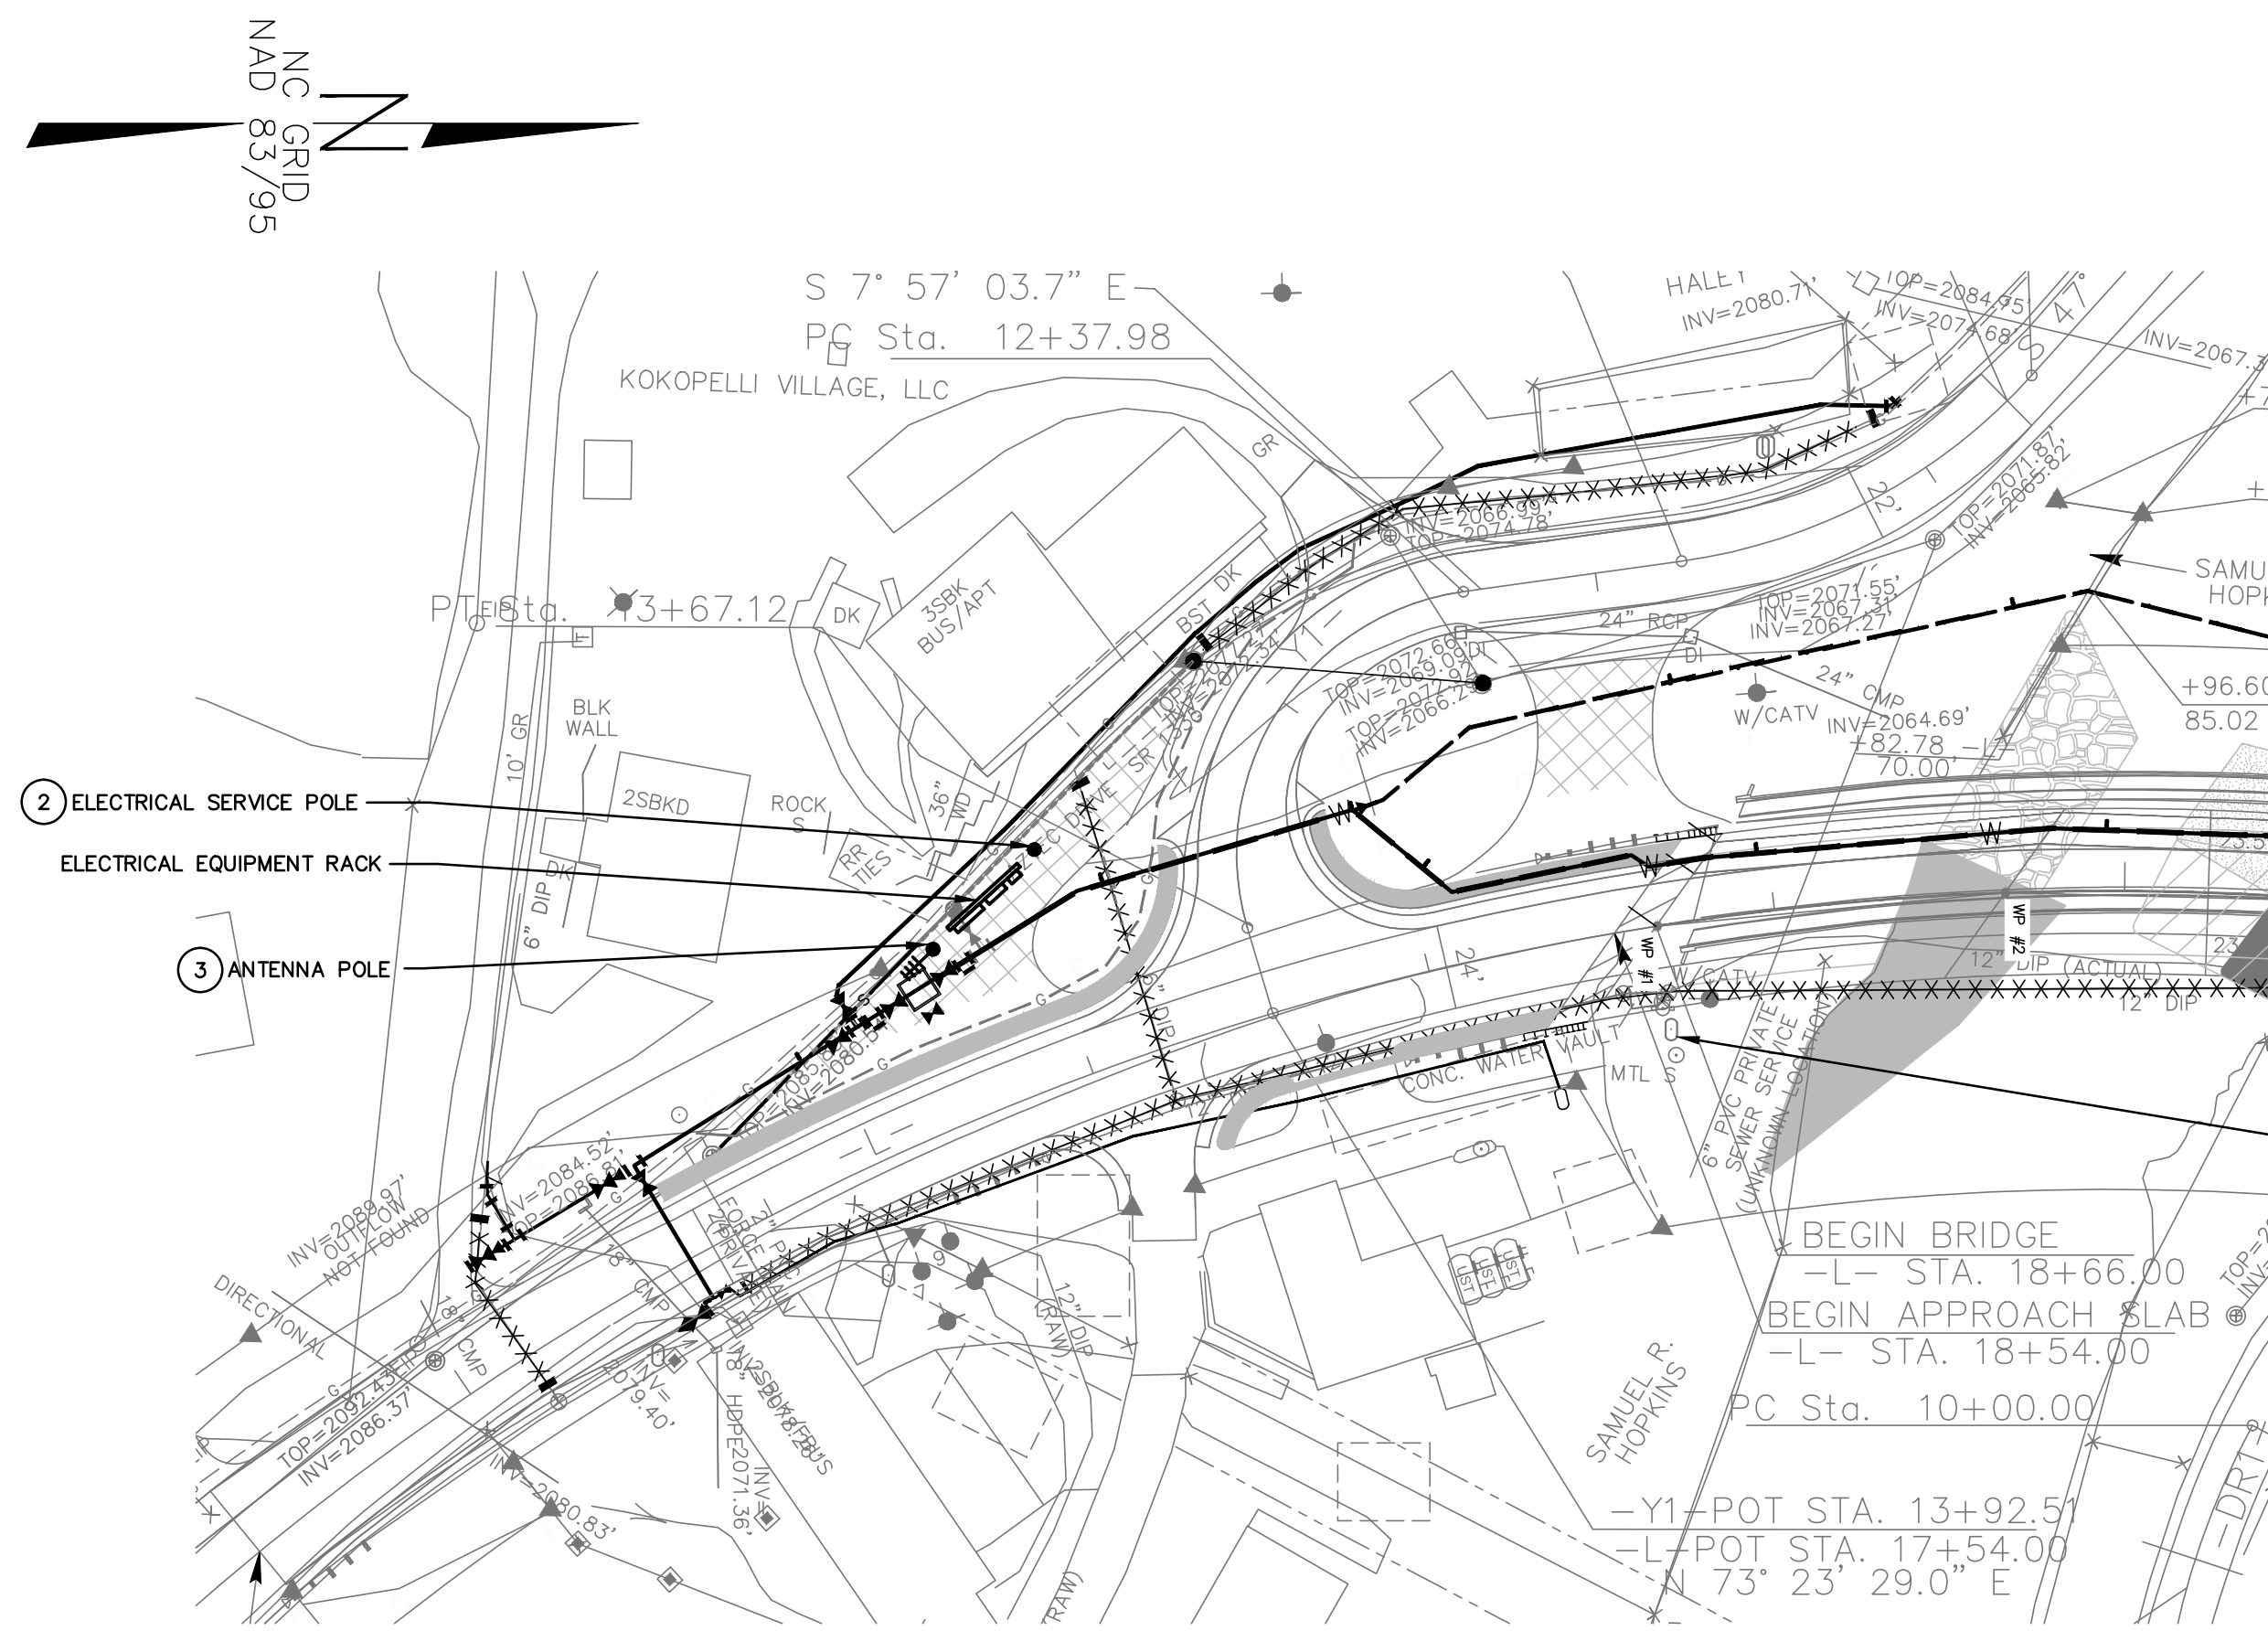


ELECTRICAL SITE PLAN
SCALE: 1"=50'-0"

CORE DRILL PRECAST CONCRETE FOR CONDUIT PENETRATIONS. GROUT SOLID ANNULAR SPACE AROUND PENETRATION. ANNULAR SPACE NOT TO EXCEED 1/4".


REMOVE EXISTING ELECTRICAL AND CONTROLS EQUIPMENT AT THE EXISTING CONTROL VALVE SITE. ALL ELECTRICAL EQUIPMENT SHALL BE TURNED OVER TO OWNER INCLUDING CONTROL VALVE AND ACTUATOR.

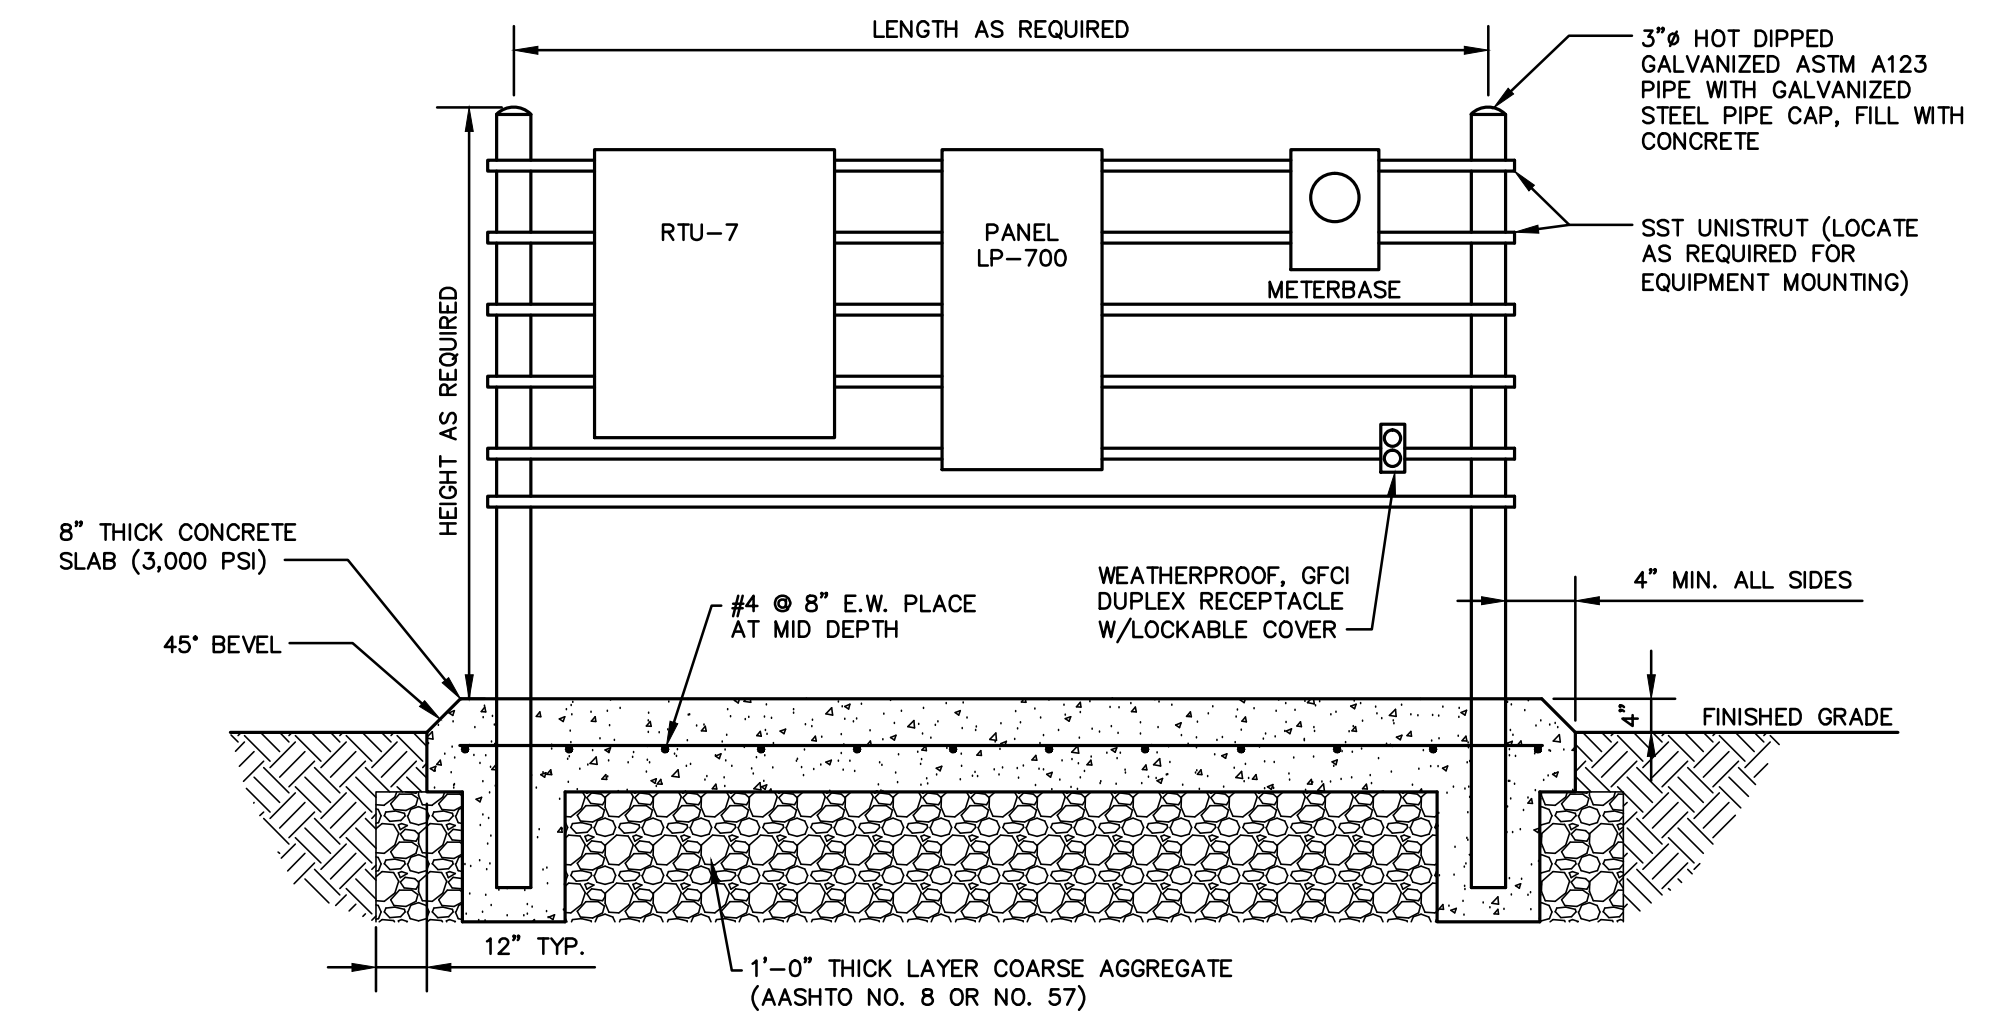

CONTROL VALVE SITE ELECTRICAL EQUIPMENT RACK LAYOUT
NOT TO SCALE

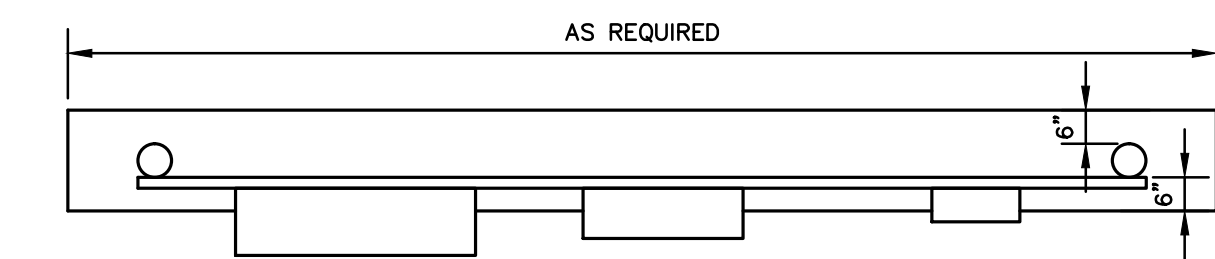

CONTROL VALVE SITE ELECTRICAL EQUIPMENT RACK PLAN VIEW
NOT TO SCALE

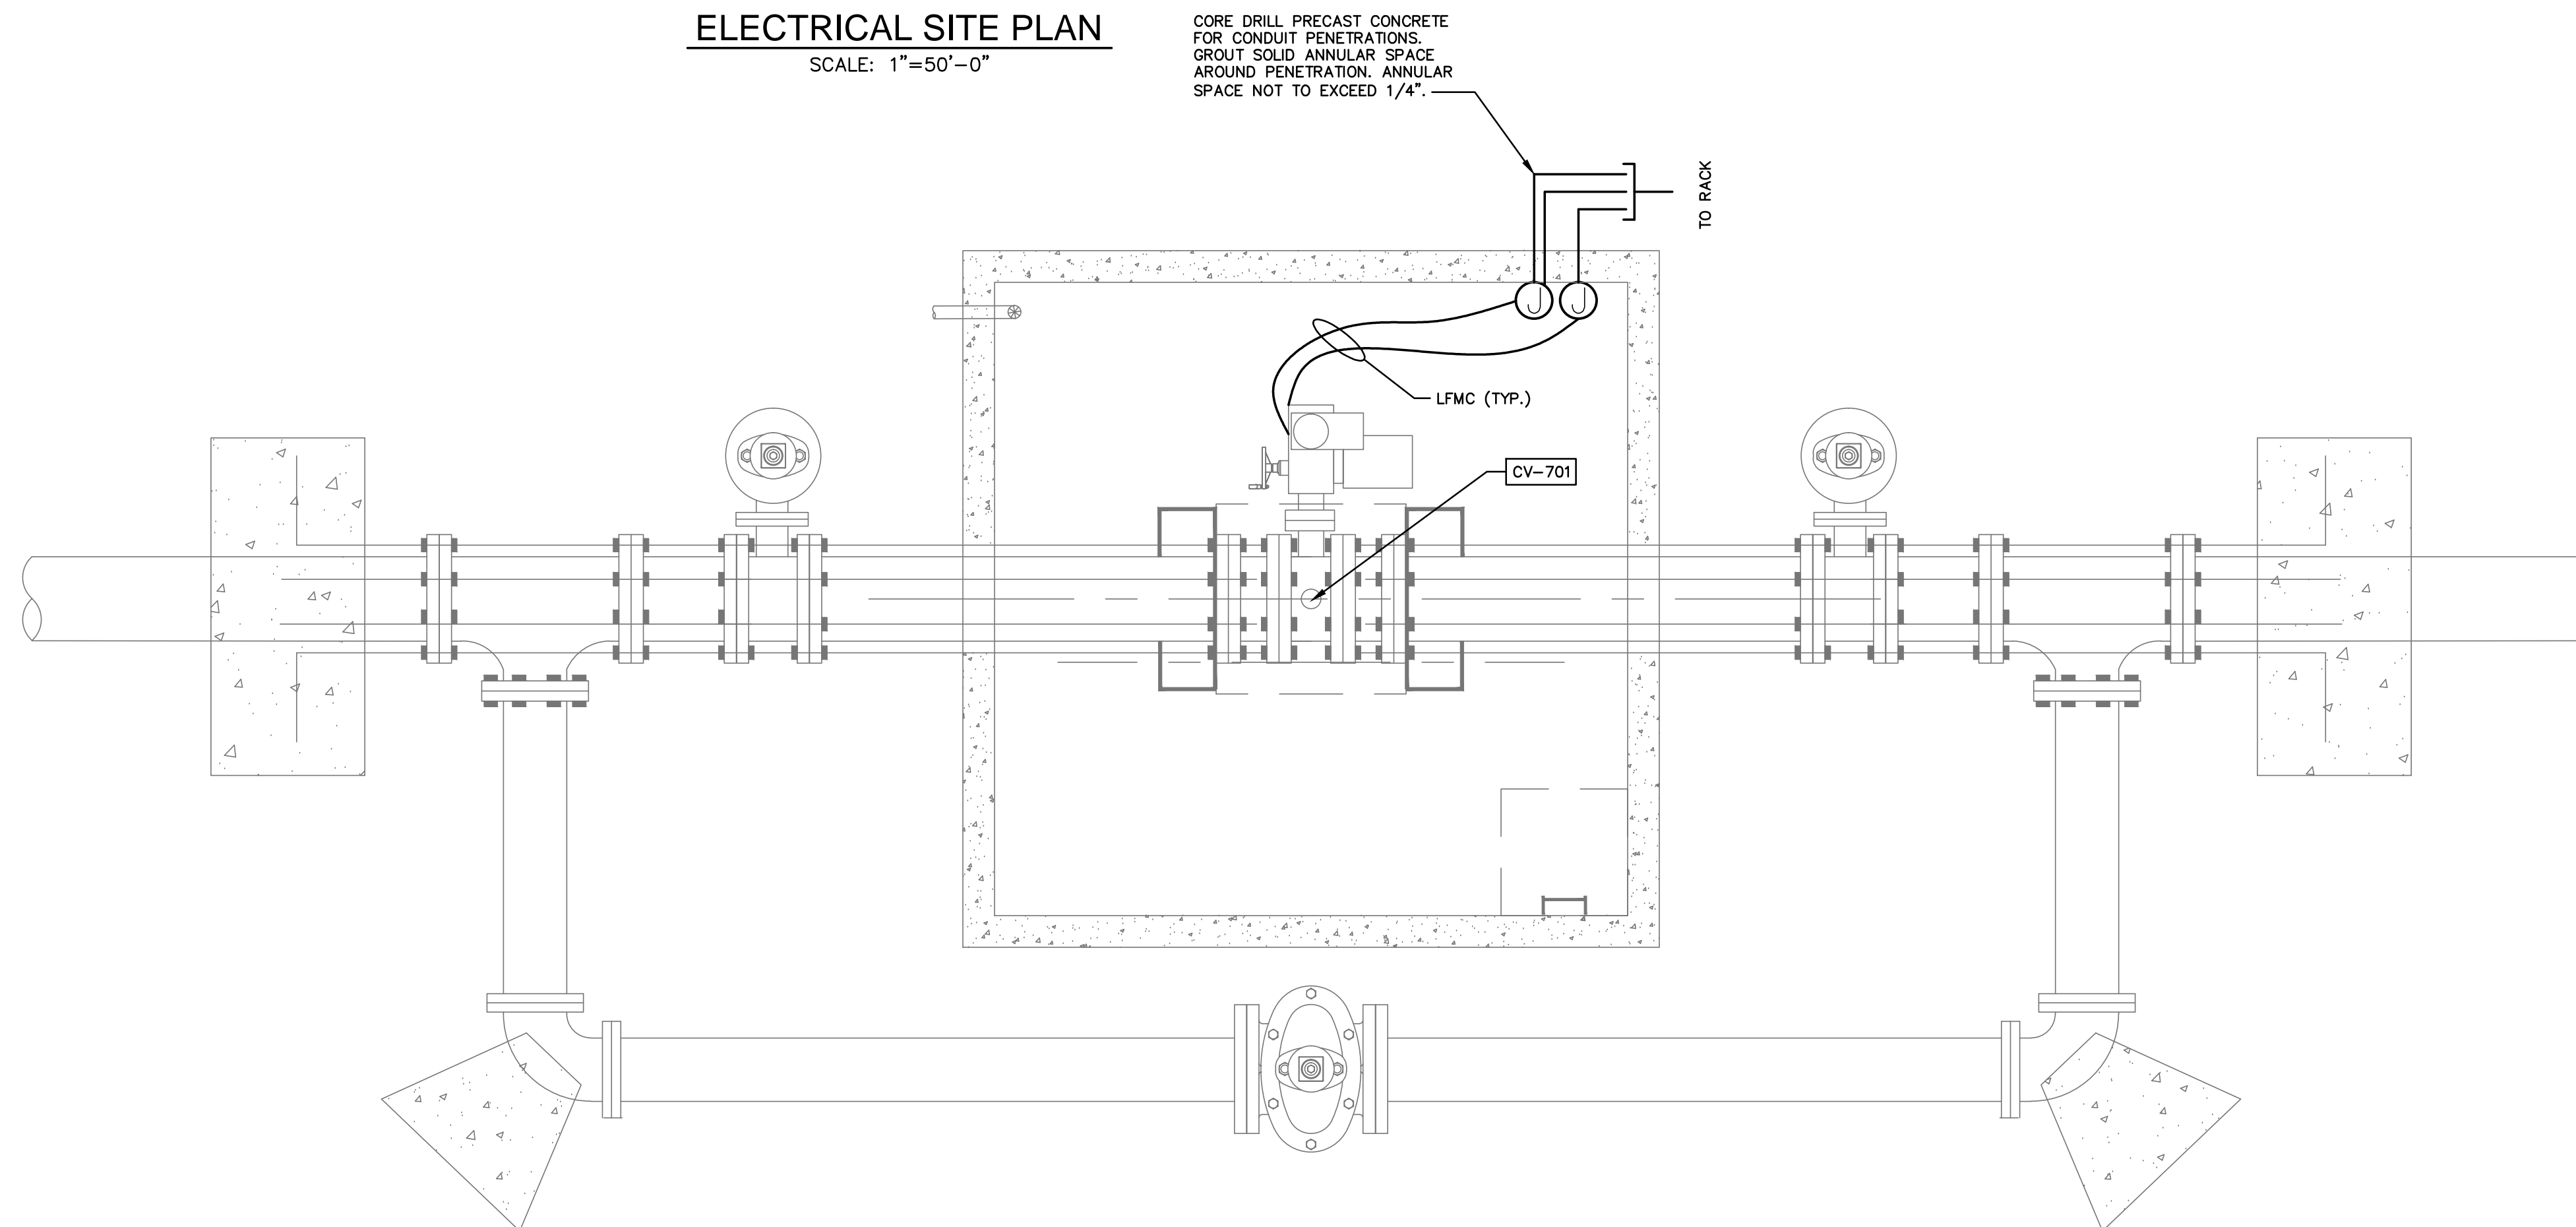

CONTROL VALVE VAULT ELECTRICAL PLAN
NOT TO SCALE

REVISIONS