

See Sheet 1-A For Index of Sheets

T.I.P. NO.
R-4060

SHEET NO.
UC-1


STATE OF NORTH CAROLINA DIVISION OF HIGHWAYS

UTILITY CONSTRUCTION PLANS ALLEGHANY COUNTY


LOCATION: US 21 (SPARTA WESTERN LOOP) FROM
SR 1172 (GRANDVIEW DR.) TO US 21

TYPE OF WORK: WATER AND SEWER RELOCATION

TIP PROJECT: R-4060

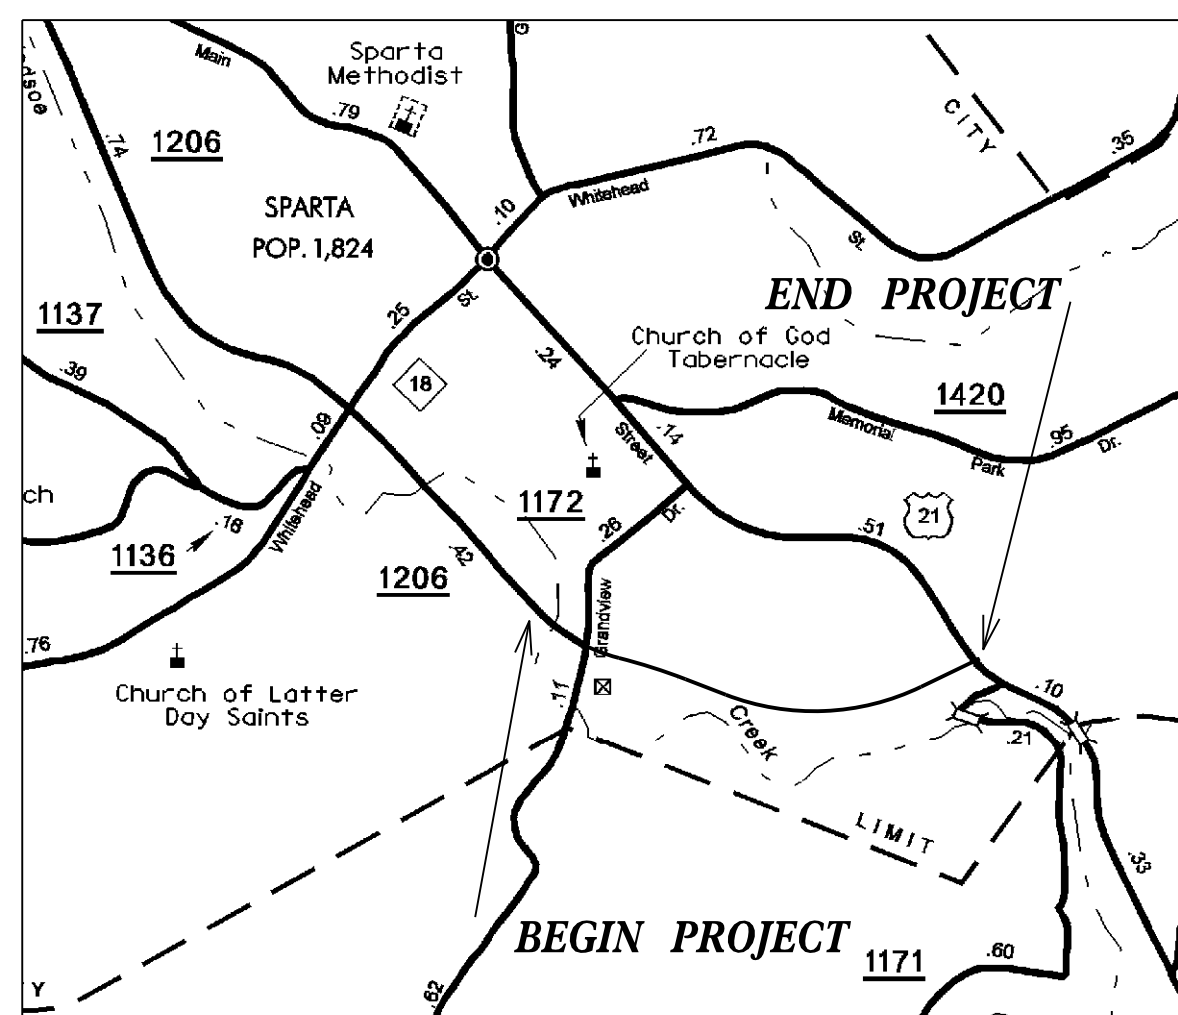

VICINITY MAP

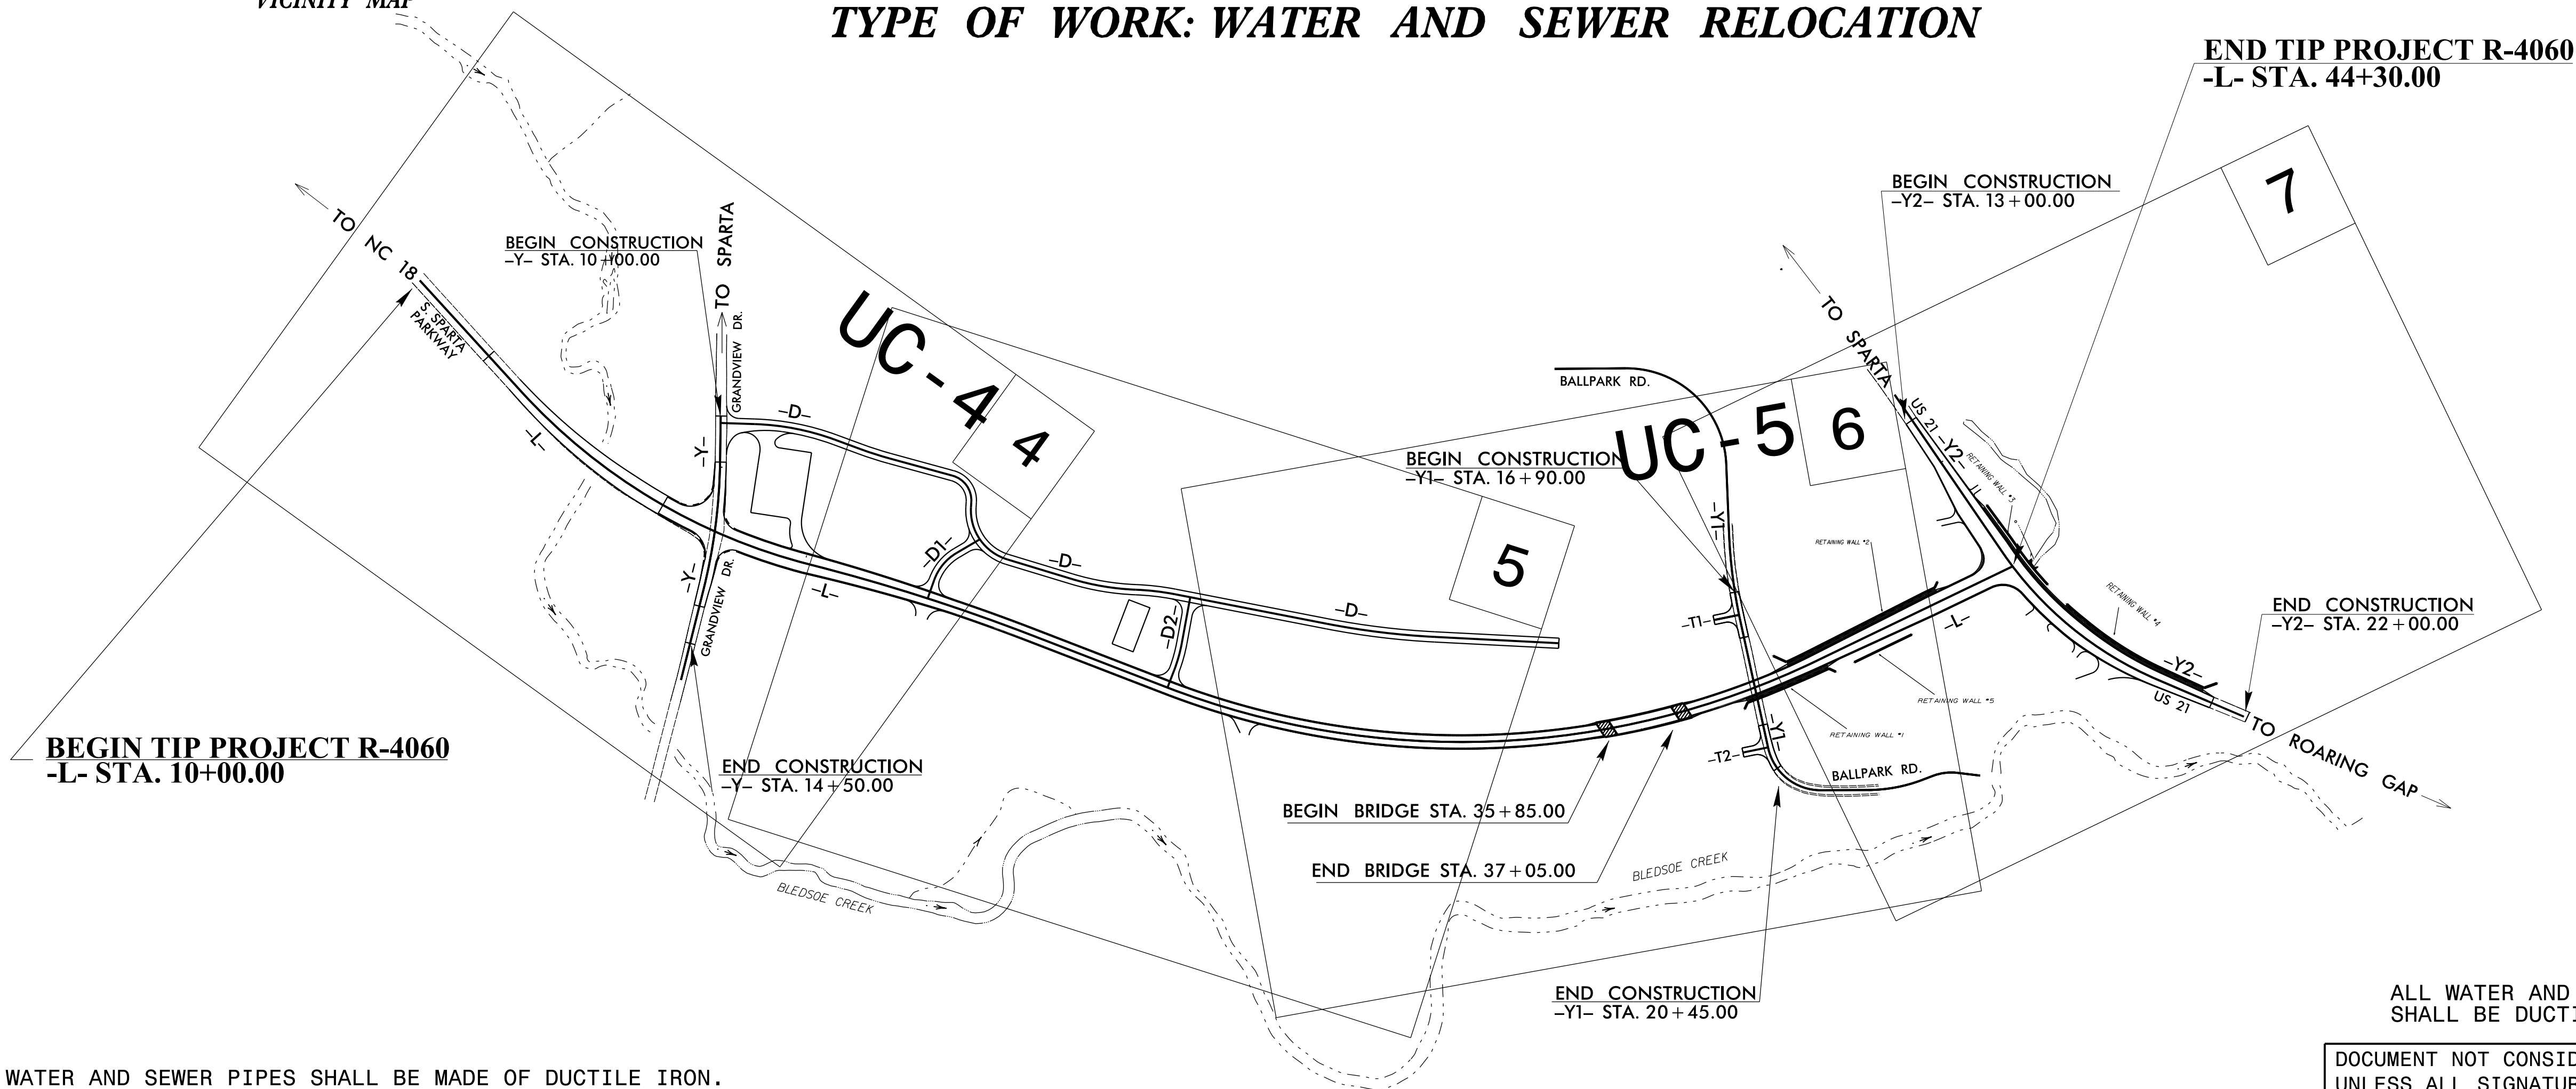


ALL WATER AND SEWER PIPES SHALL BE MADE OF DUCTILE IRON.

ALL WATER AND SEWER PIPES SHALL BE DUCTILE IRON.

DOCUMENT NOT CONSIDERED FINAL
UNLESS ALL SIGNATURES ARE COMPLETED

GRAPHIC SCALES

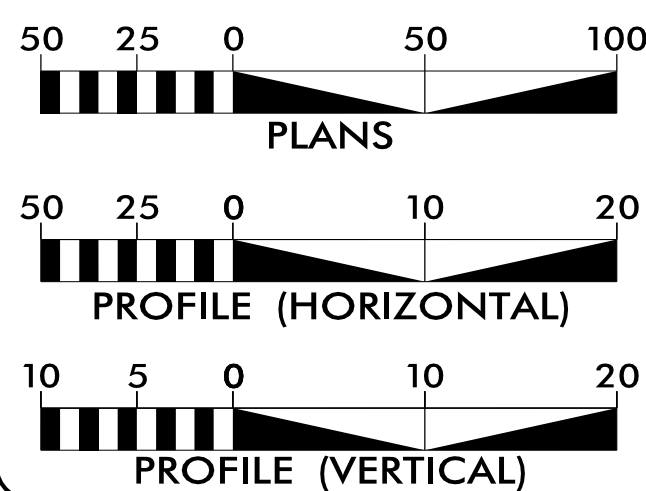


INDEX OF SHEETS

SHEET NO.	DESCRIPTION
UC-1	TITLE SHEET
UC-2	UTILITY SYMBOLOGY
UC-3	NOTES
UC-4 THRU UC-5	UTILITY CONSTRUCTION SHEETS
UC-6 THRU UC-10	PROFILE SHEETS

WATER AND SEWER OWNERS ON PROJECT

- (1) WATER TOWN OF SPARTA
- (2) SANITARY SEWER TOWN OF SPARTA

SEAL

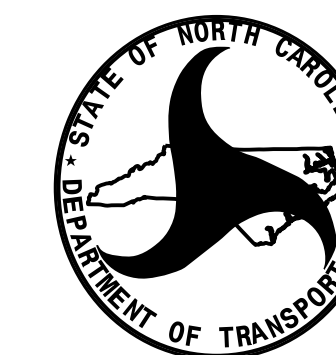

PREPARED IN THE OFFICE OF:
DIVISION OF HIGHWAYS
UTILITIES UNIT
UTILITIES ENGINEERING

1555 MAIL SERVICES CENTER
RALEIGH NC 27699-1555
PHONE (919) 707-6690
FAX (919) 250-4151

Roger Worthington, P.E. UTILITIES SECTION ENGINEER
Carl Barclay, P.E. UTILITIES SQUAD LEADER PROJECT ENGINEER
Ali Koucheki, P.E. UTILITIES PROJECT DESIGNER

30-JUN-2016 14:28 R:\Utilities\Engineering\UC\Proj\R-4060\ddc.tsh_uc1.dgn

