


NOTES:
 THE NORTH CAROLINA DEPARTMENT OF TRANSPORTATION SHALL FURNISH AND INSTALL THE PERMANENT NAVIGATIONAL LIGHTING.
 PRIOR TO ANY WORK COMMENCING IN THE WATERWAY, TEMPORARY NAVIGATIONAL LIGHTING WILL BE REQUIRED BY THE COAST GUARD. ADDITIONAL LIGHTING OR OBSTRUCTION LIGHTING MAY ALSO BE REQUIRED. ALL TEMPORARY NAVIGATIONAL LIGHTING SHOULD BE COORDINATED WITH THE DISTRICT COMMANDER OF THE COAST GUARD.
 NO SEPARATE PAYMENT WILL BE MADE FOR THE COST FOR FURNISHING, INSTALLING, AND MAINTAINING THE TEMPORARY NAVIGATIONAL LIGHTING.

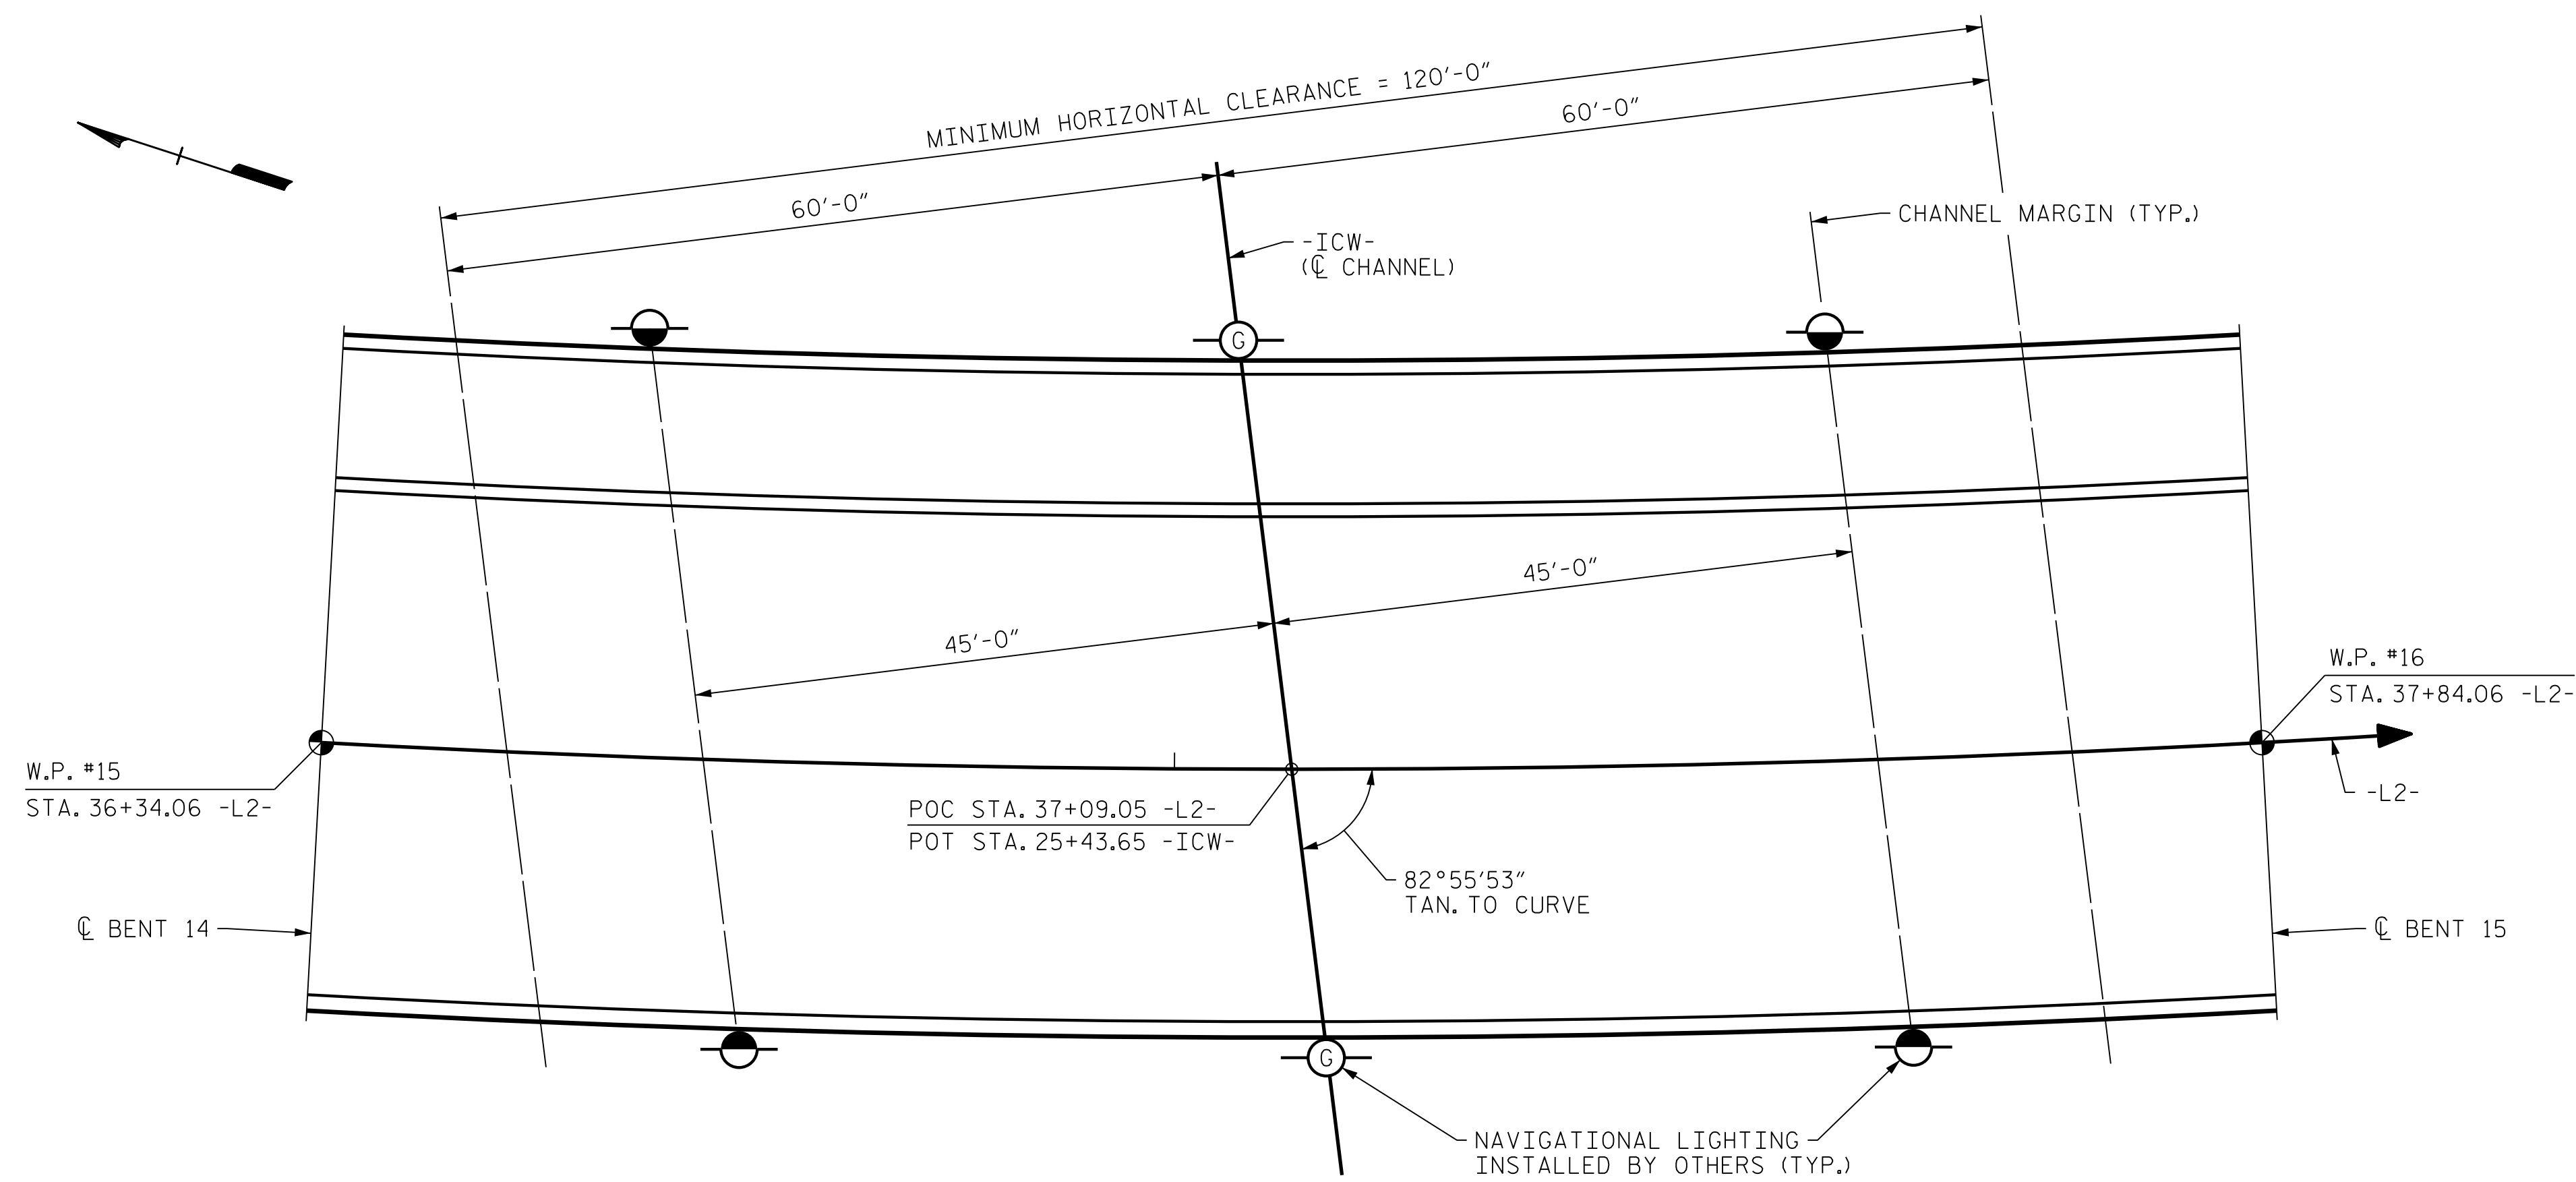

PLAN


- ⊙ 360° GREEN NAVIGATIONAL LIGHT - CHANNEL CENTERLINE
- 180° RED NAVIGATIONAL LIGHT - CHANNEL MARGIN

PROJECT NO. B-4929
PENDER COUNTY
 STATION: 38+13.81 -L2-

8/10/2016 400_271_B4929_SMU_SAP1.dgn

DESIGNED BY: J. DOUGHTY DATE: DEC 2015
 DRAWN BY: K. WHITE DATE: DEC 2015
 CHECKED BY: B. LOFLIN DATE: MAR 2016
 DESIGN ENGINEER OF RECORD: J. SHERMAN DATE: AUG 2016

PARSONS BRINCKERHOFF
 434 FAYETTEVILLE STREET
 SUITE 1500
 RALEIGH, NC 27601
 LICENSE NO. F-0165

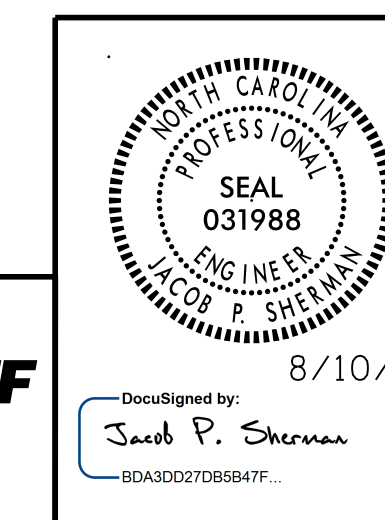

DocuSigned by: Jacob P. Sherman 8/10/16

STATE OF NORTH CAROLINA
 DEPARTMENT OF TRANSPORTATION
 RALEIGH

NAVIGATIONAL LIGHTING LAYOUT

REVISIONS						SHEET NO.
NO.	BY:	DATE:	NO.	BY:	DATE:	TOTAL SHEETS
1			3			278
2			4			

S-137

DOCUMENT NOT CONSIDERED FINAL UNLESS ALL SIGNATURES COMPLETED