


09/08/99

TIP PROJECT: B-5546

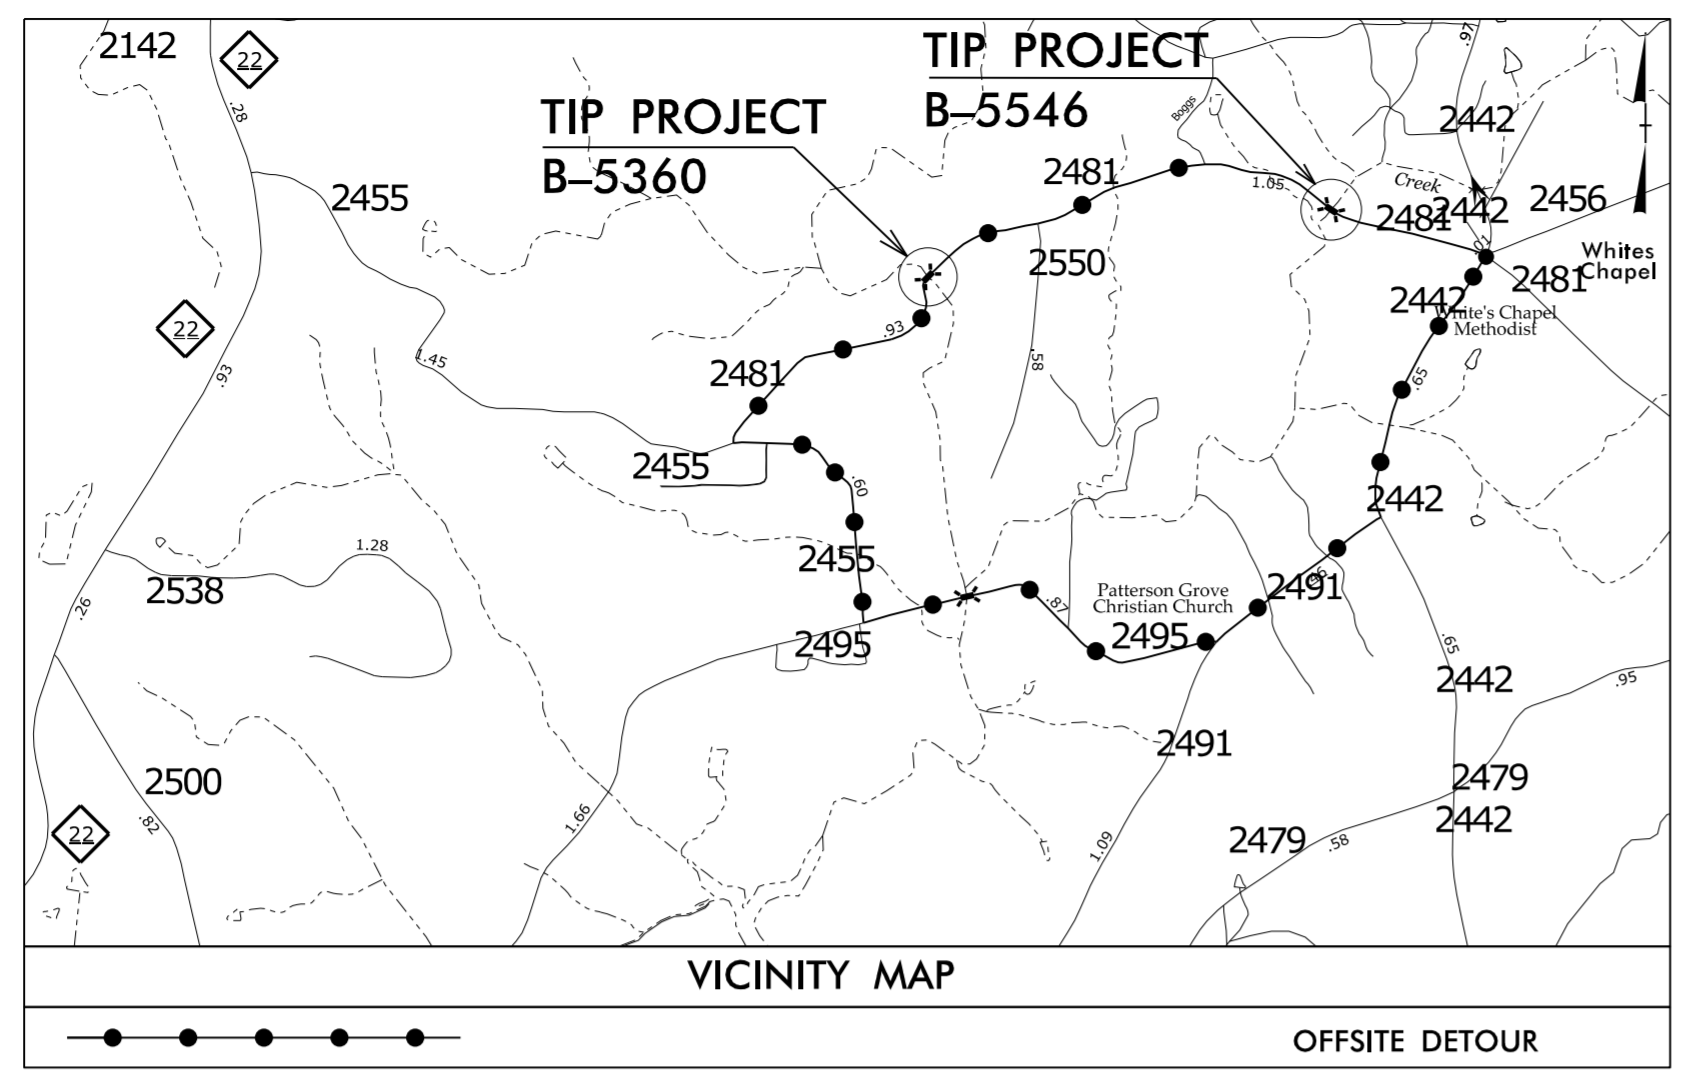



STATE OF NORTH CAROLINA
DIVISION OF HIGHWAYS

T.I.P. NO.	SHEET NO.
B-5546	UO-1


UTILITY PLANS BY OTHERS RANDOLPH COUNTY

**LOCATION: BRIDGE NO. 307 OVER MOUNT PLEASANT CREEK
ON SR 2481 (LOW BRIDGE RD.)**

TYPE OF WORK: AERIAL AND BURIED UTILITIES

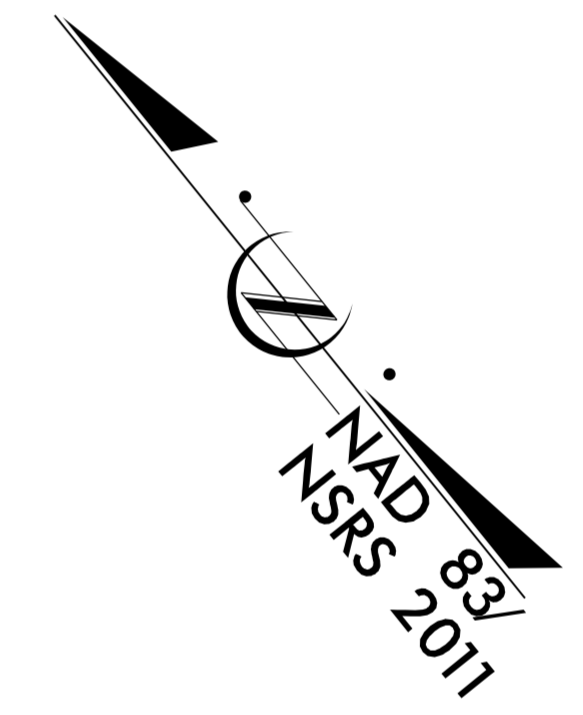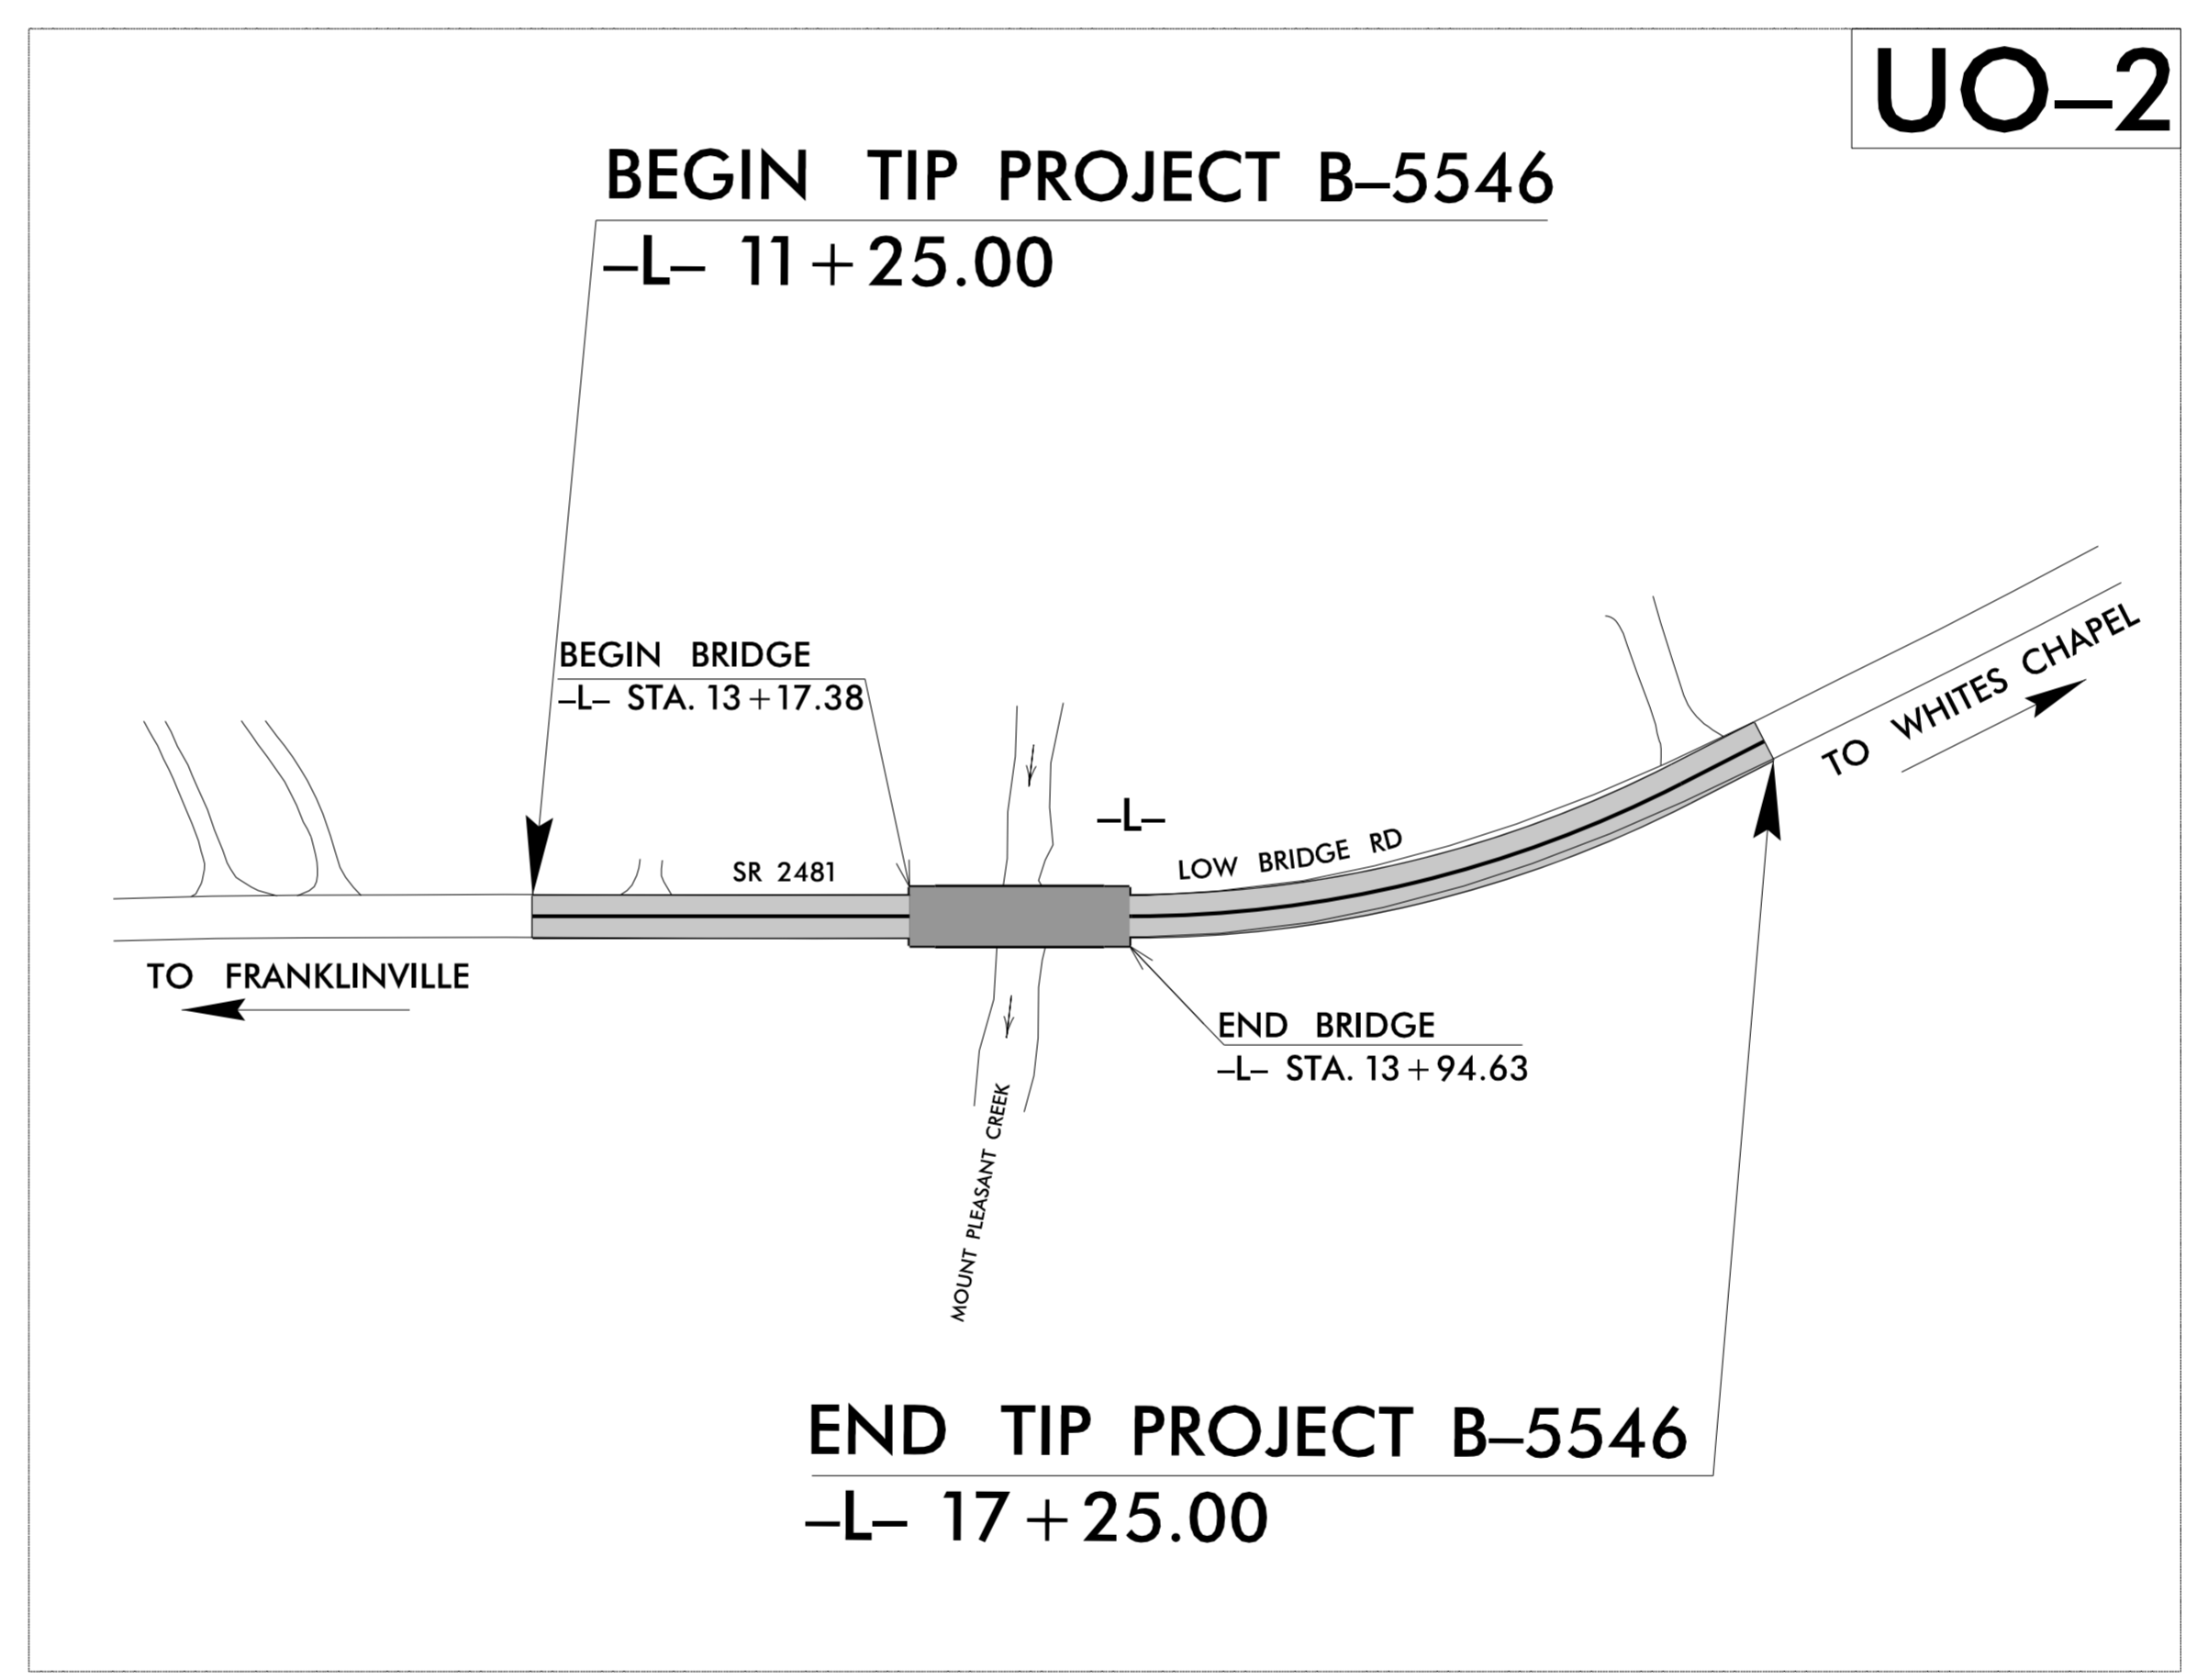

GRAPHIC SCALES

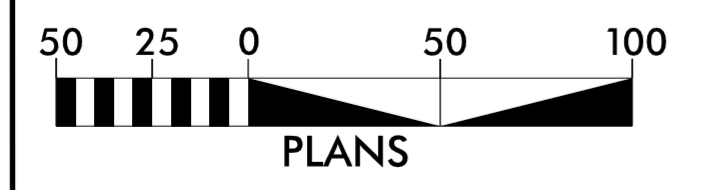

INDEX OF SHEETS

SHEET NO.	DESCRIPTION
UO-1	TITLE SHEET
UO-2	UTILITY BY OTHERS PLAN SHEET

UTILITY OWNERS ON PROJECT

- (A) RANDOLPH EMC POWER
- (B) CENTURYLINK TELEPHONE

PLANS PREPARED BY:

CH ENGINEERING

3220 GLEN ROYAL RD. RALEIGH, NC 27617
TELE 919.788.0224 FAX 919.788.0232
NC LICENSE #P-0189

UTILITIES PROJECT ENGINEER
Mary Jo Lee, P.E.



PREPARED FOR:
**DIVISION OF HIGHWAYS
UTILITIES UNIT
UTILITIES ENGINEERING**

1555 MAIL SERVICES CENTER
RALEIGH NC 27699-1555
PHONE (919) 707-6690
FAX (919) 250-4151

- Roger Worthington, P.E. UTILITIES SECTION ENGINEER
- Donna Jackson, P.E. UTILITIES SQUAD LEADER PROJECT ENGINEER
- Jamshid Hafshejani UTILITIES PROJECT DESIGNER

7/5/2016
R:\Utilities\Engineering\UBO\Proj\B-5546-ut-fsh-U001.dgn
USERNAME