


**This electronic collection of documents is provided
for the convenience of the user
and is Not a Certified Document –**

**The documents contained herein were originally issued
and sealed by the individuals whose names and license
numbers appear on each page, on the dates appearing
with their signature on that page.**

**This file or an individual page
shall not be considered a certified document.**

09/08/99

TIP PROJECT: B-5546

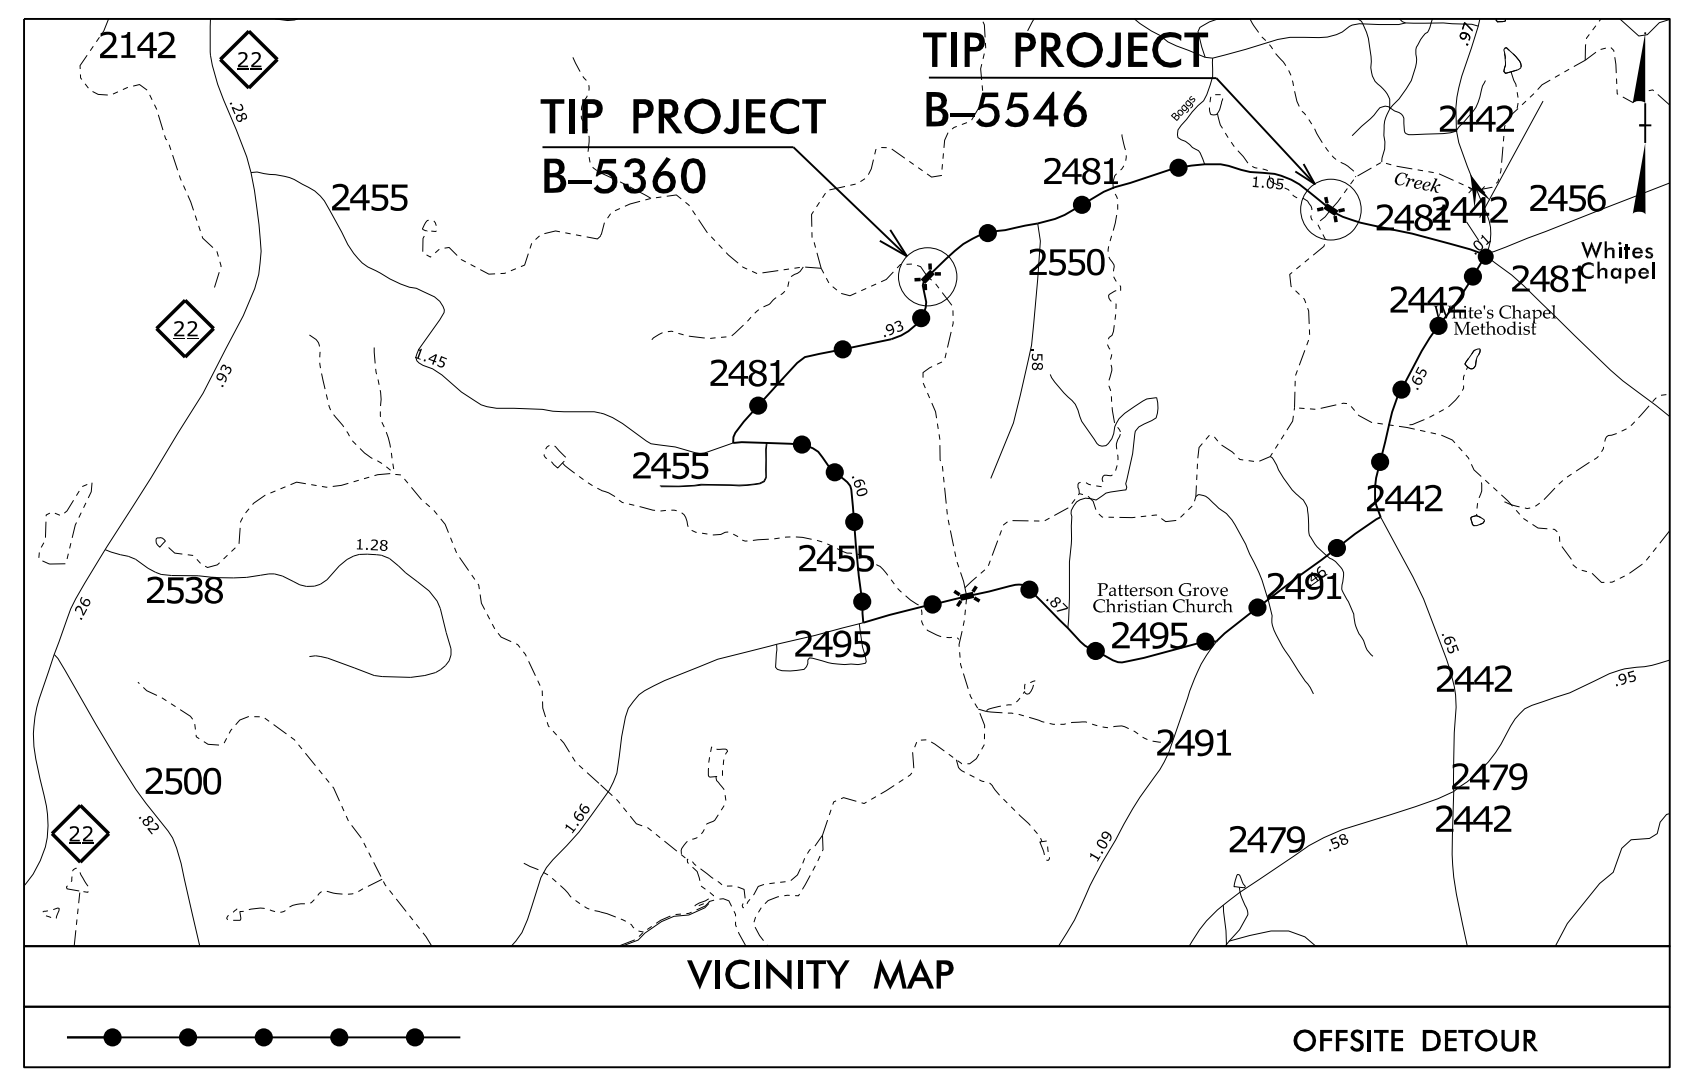



STATE OF NORTH CAROLINA
DIVISION OF HIGHWAYS

T.I.P. NO.	SHEET NO.
B-5546	UO-1


UTILITY PLANS BY OTHERS RANDOLPH COUNTY

**LOCATION: BRIDGE NO. 307 OVER MOUNT PLEASANT CREEK
ON SR 2481 (LOW BRIDGE RD.)**

TYPE OF WORK: AERIAL AND BURIED UTILITIES

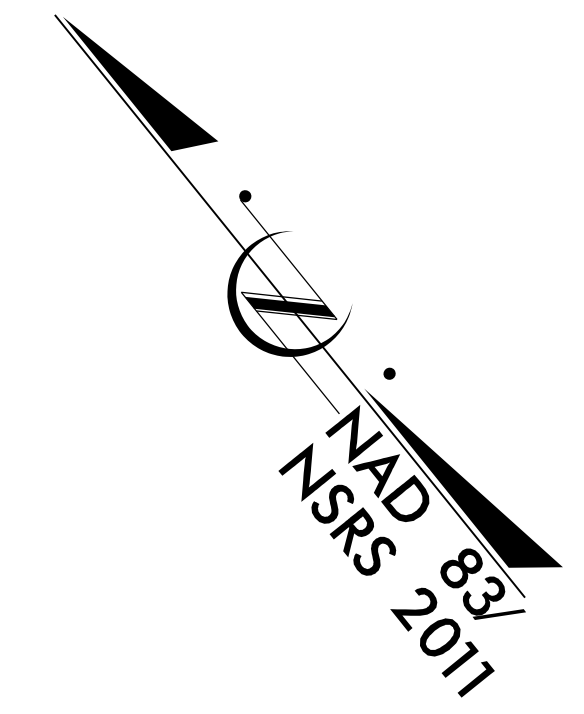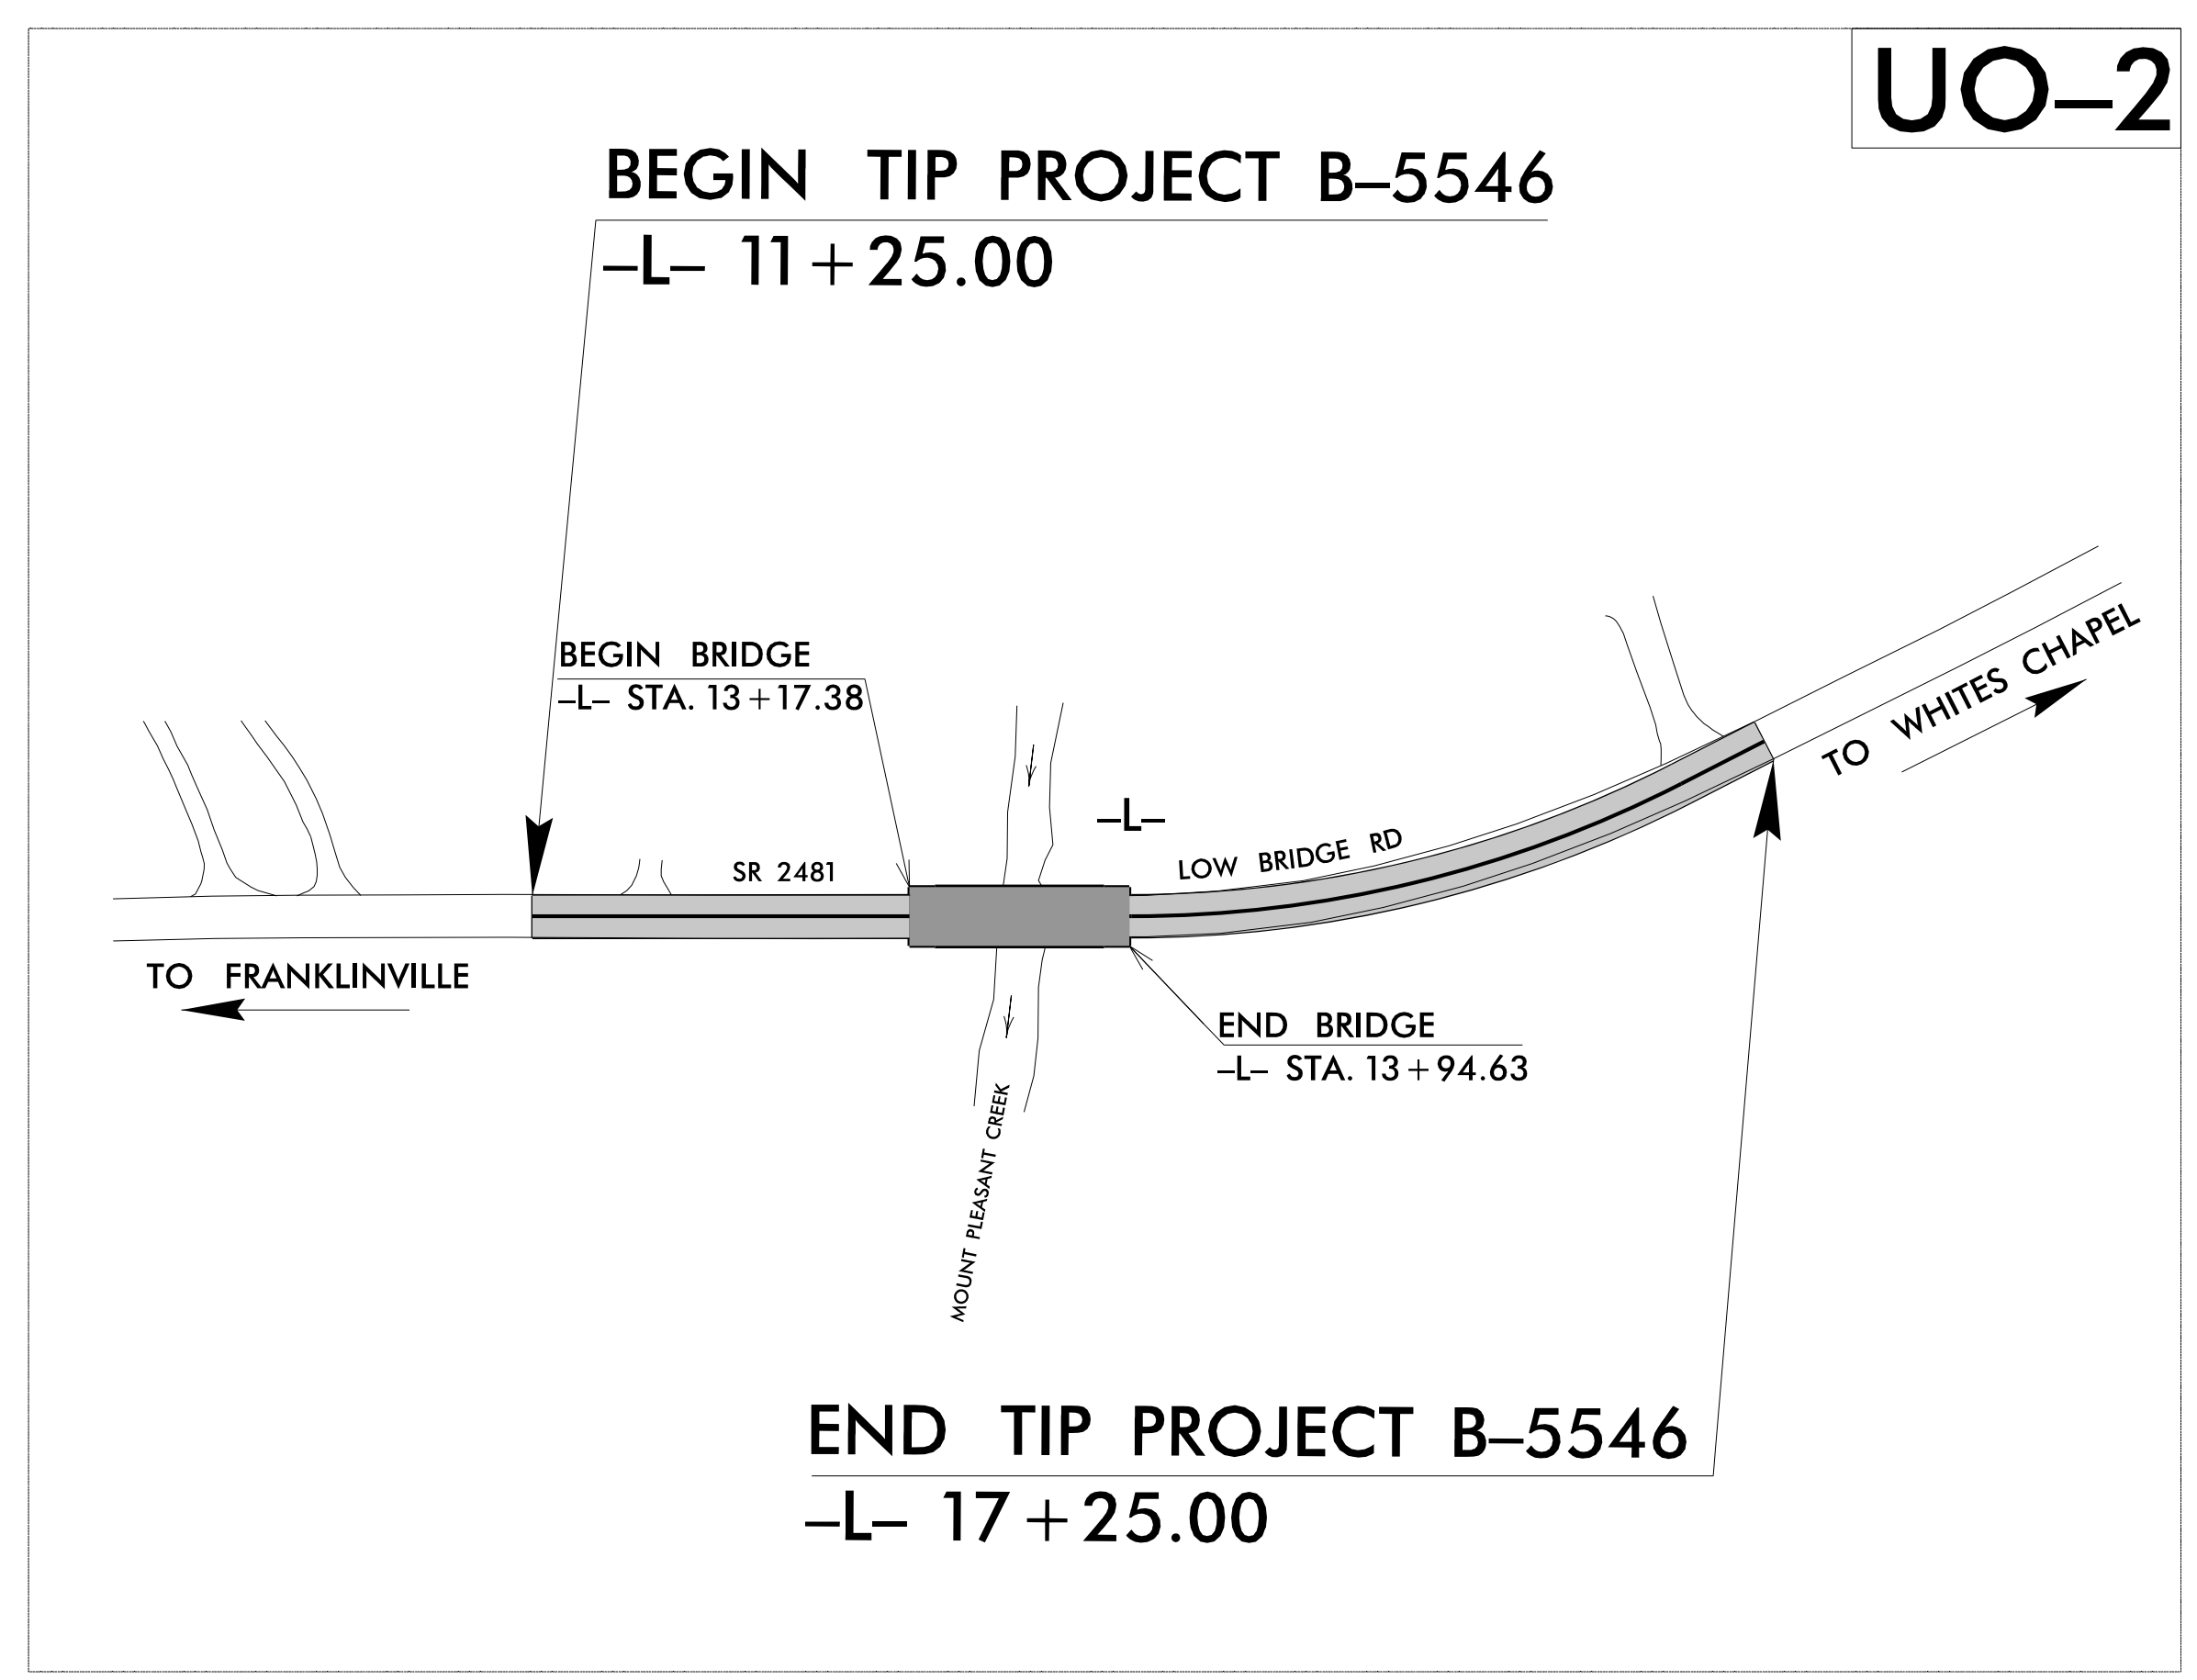

GRAPHIC SCALES

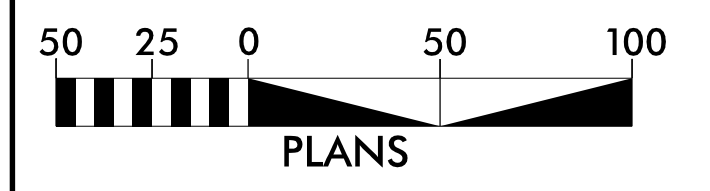

INDEX OF SHEETS

SHEET NO.	DESCRIPTION
UO-1	TITLE SHEET
UO-2	UTILITY BY OTHERS PLAN SHEET

UTILITY OWNERS ON PROJECT


- (A) RANDOLPH EMC POWER
- (B) CENTURYLINK TELEPHONE

PLANS PREPARED BY:

CH ENGINEERING

3220 GLEN ROYAL RD. RALEIGH, NC 27617
TELE 919.788.0224 FAX 919.788.0232
NC LICENSE #P-0189

UTILITIES PROJECT ENGINEER
Mary Jo Lee, P.E.

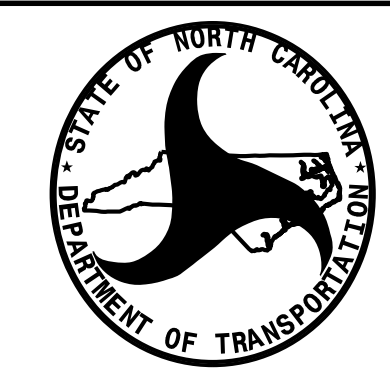

PREPARED FOR:
**DIVISION OF HIGHWAYS
UTILITIES UNIT
UTILITIES ENGINEERING**

1555 MAIL SERVICES CENTER
RALEIGH NC 27699-1555
PHONE (919) 707-6690
FAX (919) 250-4151

- Roger Worthington, P.E. UTILITIES SECTION ENGINEER
- Donna Jackson, P.E. UTILITIES SQUAD LEADER PROJECT ENGINEER
- Jamshid Hafshejani UTILITIES PROJECT DESIGNER

7/5/2016
R:\Utilities\Engineering\UBO\Proj\B-5546-ut-fsh-U001.dgn
USERNAME

