


STATE OF NORTH CAROLINA  
DIVISION OF HIGHWAYS

STATE	STATE PROJECT REFERENCE NO.	SHEET NO.	TOTAL SHEETS
N.C.	I-5833	1	
STATE PROJ. NO.	F.A. PROJ. NO.	DESCRIPTION	
53039.1.1	NHPP-0040(026)	PE	
53039.3.1	NHPP-0040(026)	CONST.	

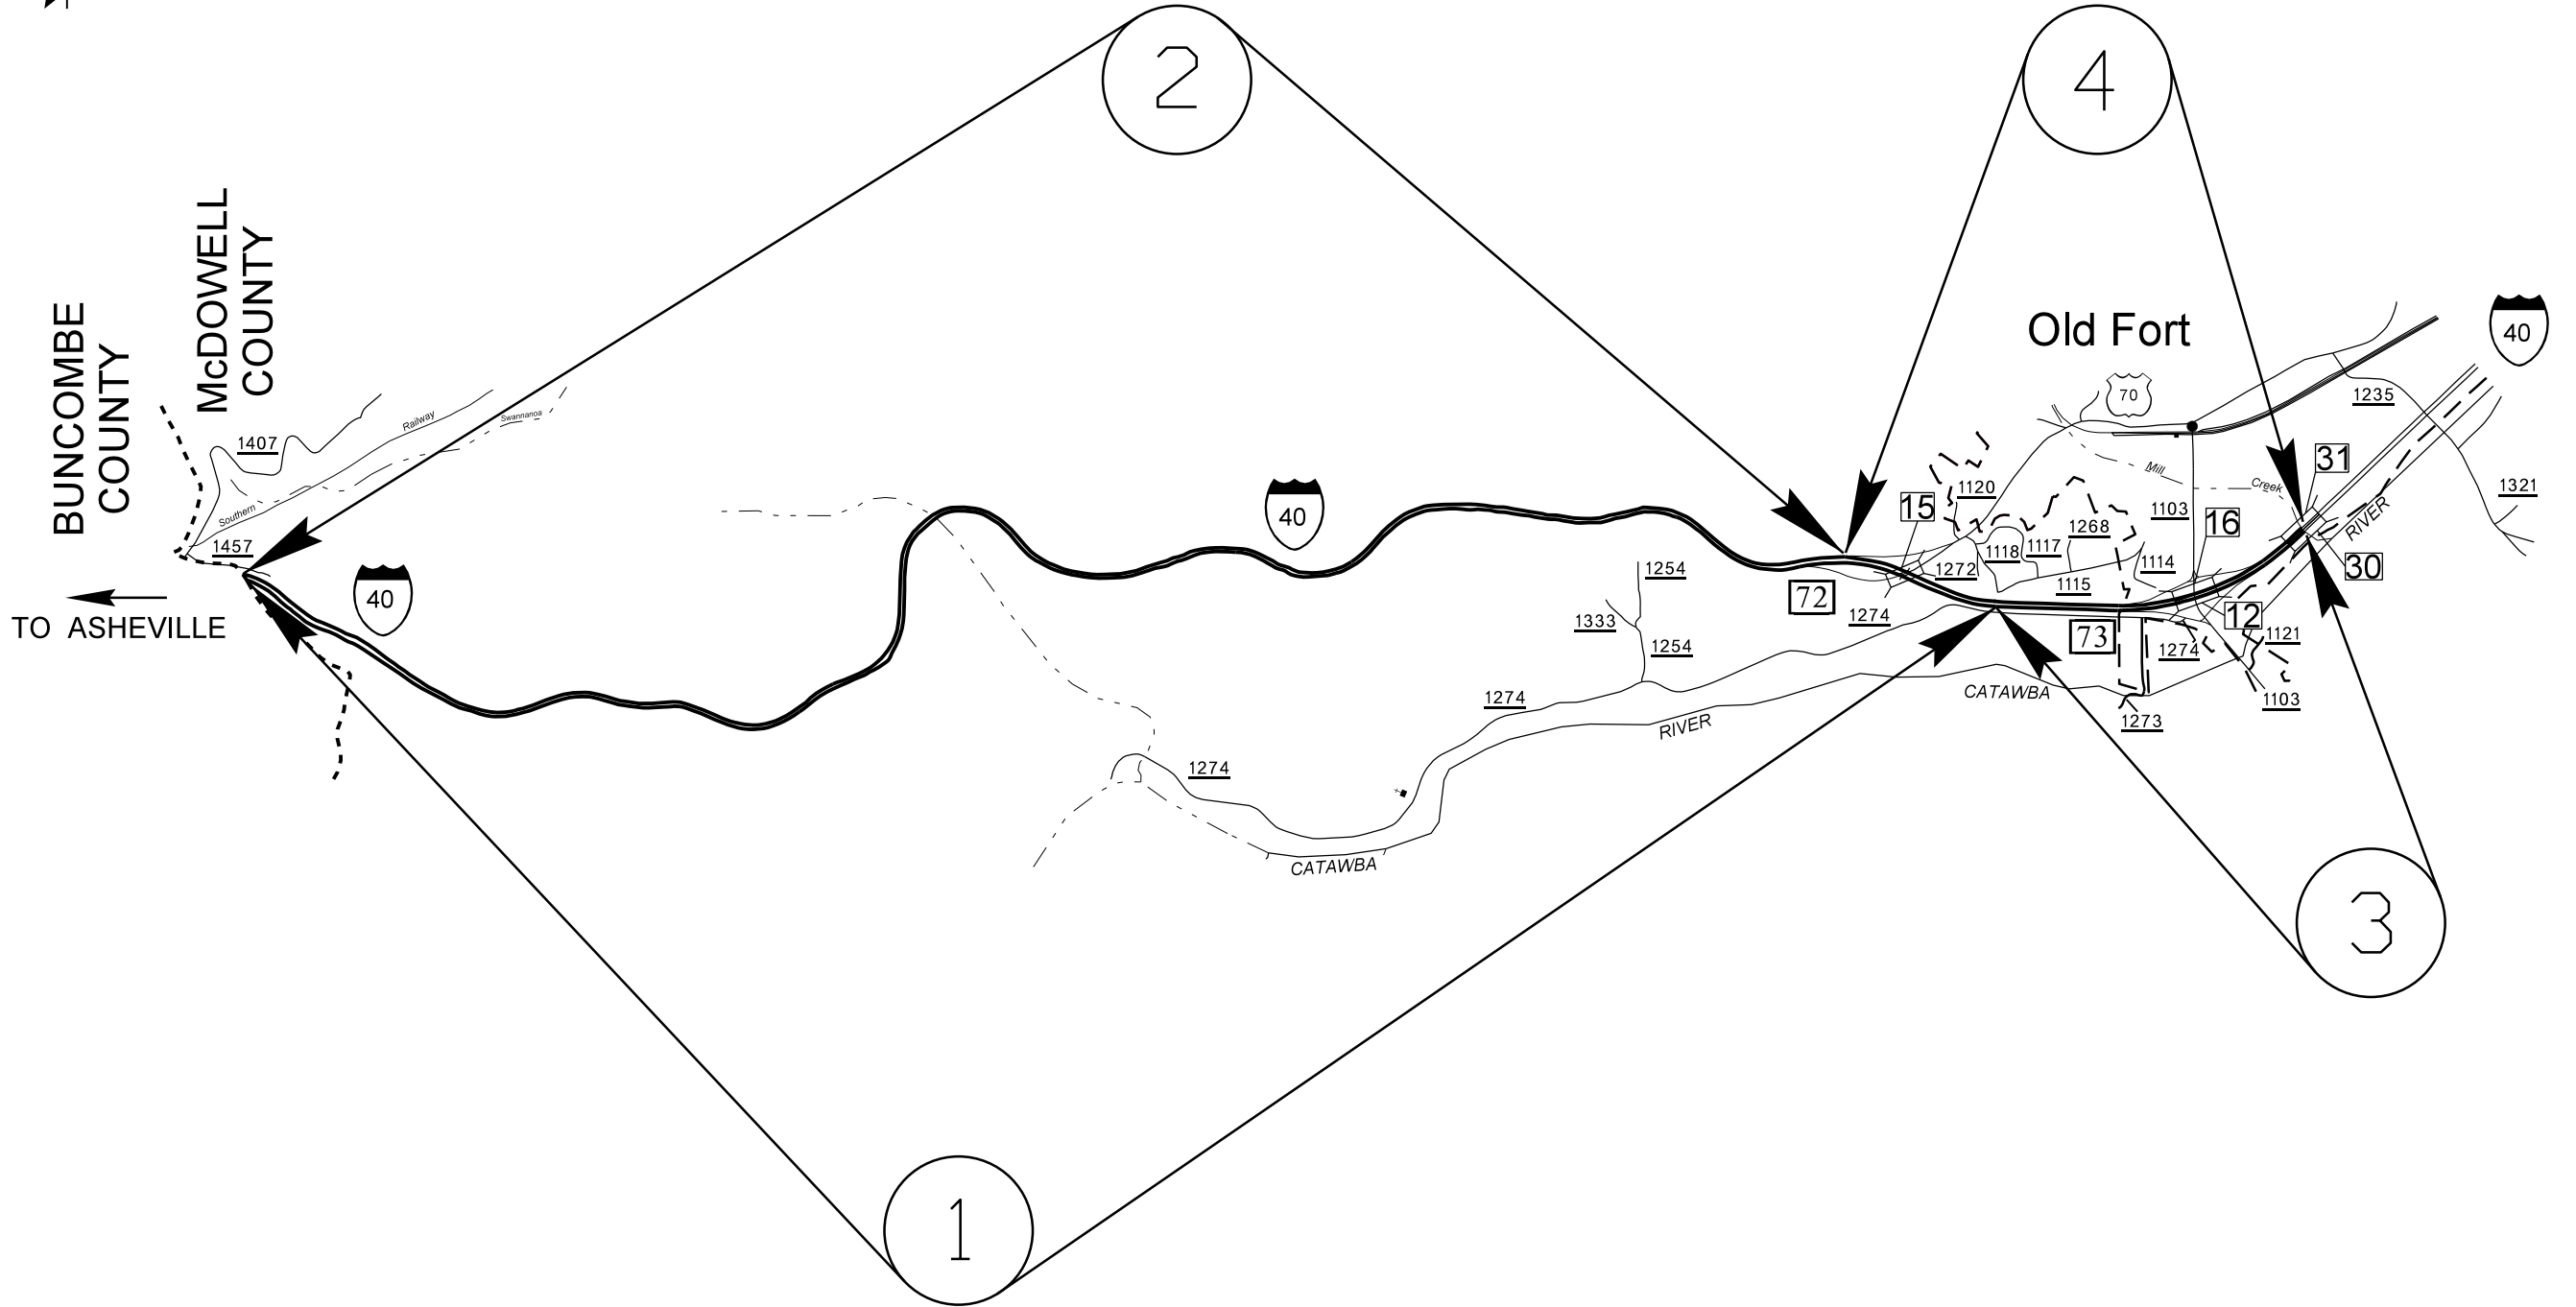

**McDOWELL COUNTY**

10-OCT-2016 11:09  
 S:\DDC\rdy\Interstate Maintenance Preservation Program\McDowell\I-5833\Revisions\I-5833 Location Maps.dgn  
 \$\$\$USERNAME\$\$\$

**TIP PROJECT: I-5833**

**CONTRACT: C203871**

09/08/99