


PROJECT REFERENCE NO.	SHEET NO.
I-5765	4
RW SHEET NO.	
ROADWAY DESIGN ENGINEER	HYDRAULICS ENGINEER
	
DocuSigned by: 1/5/2017 William A. Blanton	
DOCUMENT NOT CONSIDERED FINAL UNLESS ALL SIGNATURES COMPLETED	

5/14/99



BEGIN TIP PROJECT I-5765

BEGIN RESURFACING

-L1- POT Sta. 865 + 000

M.P. 169.14

-L1- POT Sta. 922 + 76.31 LB =

-L2- POT Sta. 0 + 00.00 LA

END TIP PROJECT I-5765


-L2- POT Sta. 277 + 86.07

M.P. 175.50

END RESURFACING

-L2- POC Sta. 251 + 40

M.P. 175.00

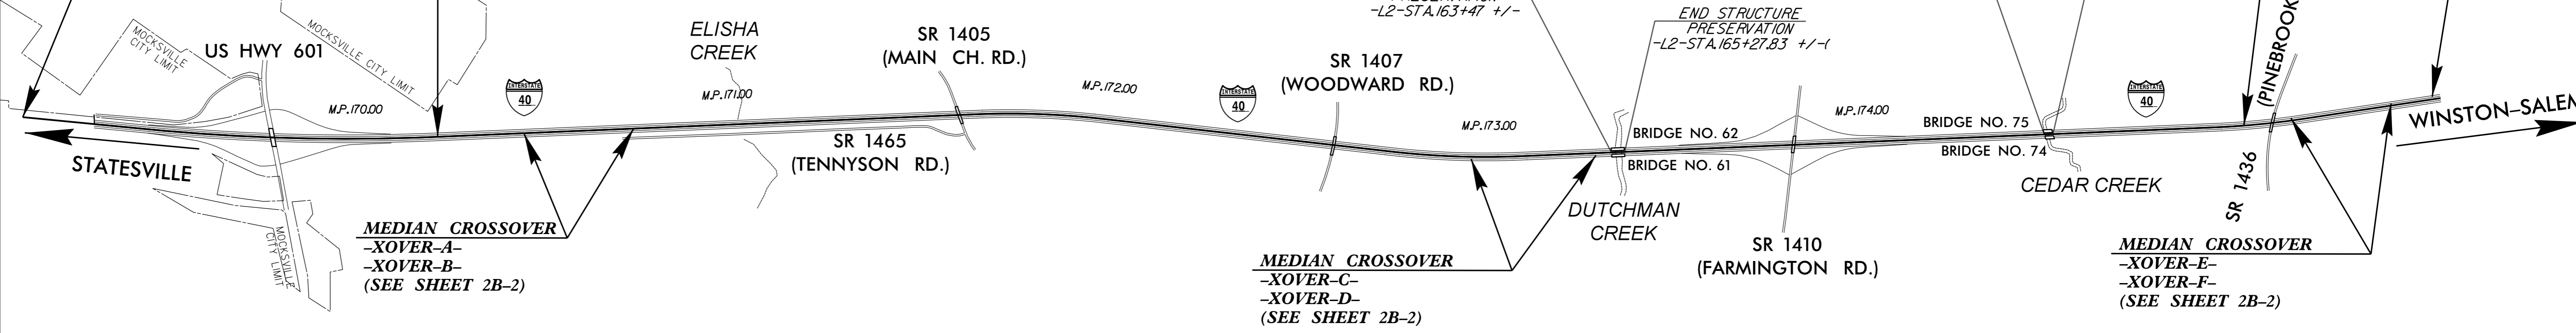

S:\DDC\28-Nov-2016_0545\g_d\pave\15765_ddc_dsn.dgn
 1/5/2017 11:18:54 AM
 15765-59-50