
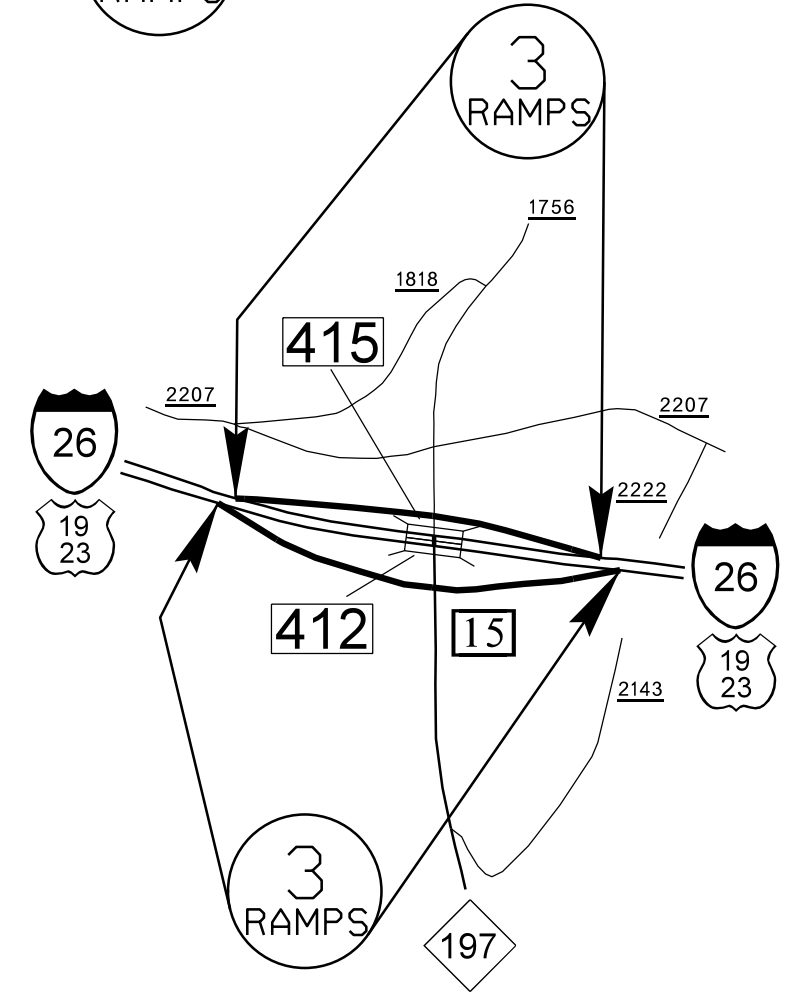
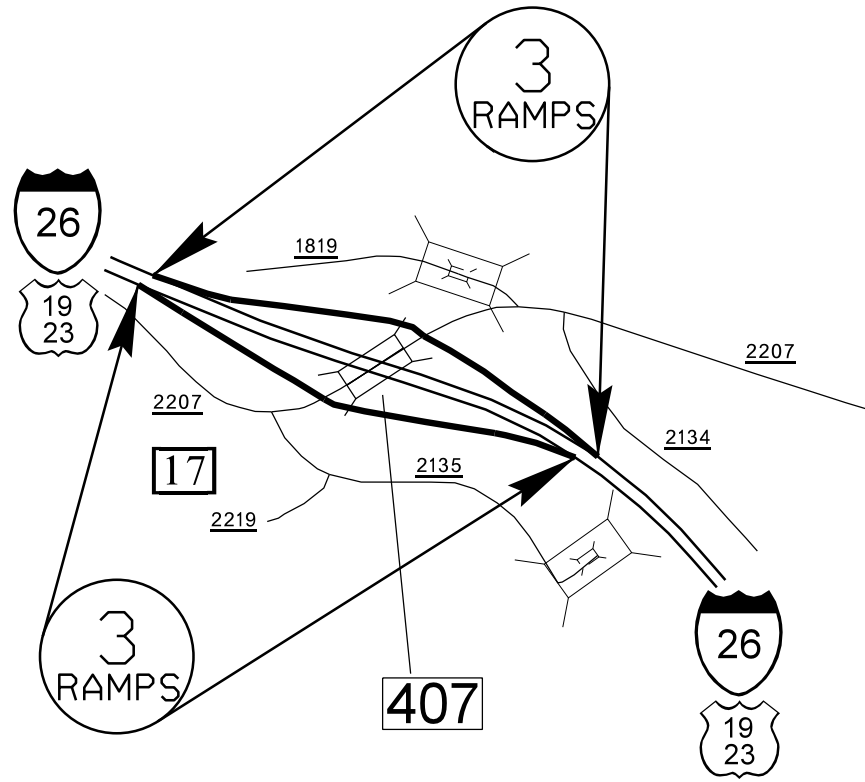
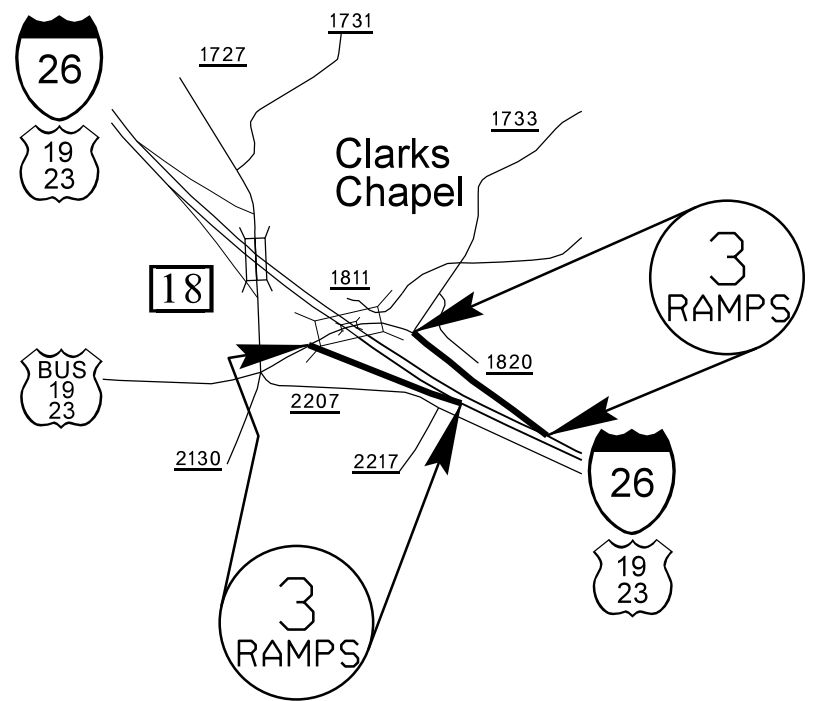
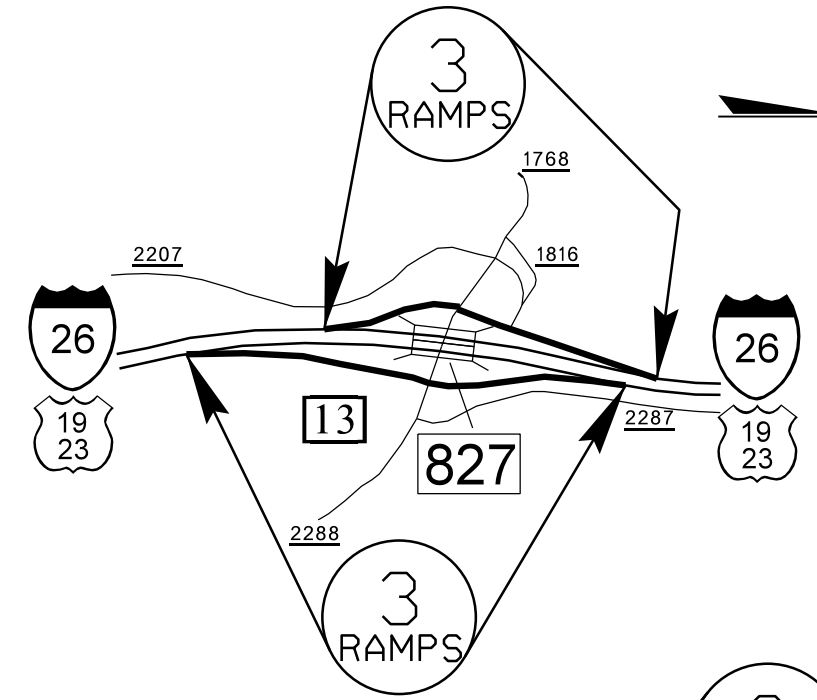


STATE	STATE PROJECT REFERENCE NO.	SHEET NO.	TOTAL SHEETS
N.C.	I-5892	2	

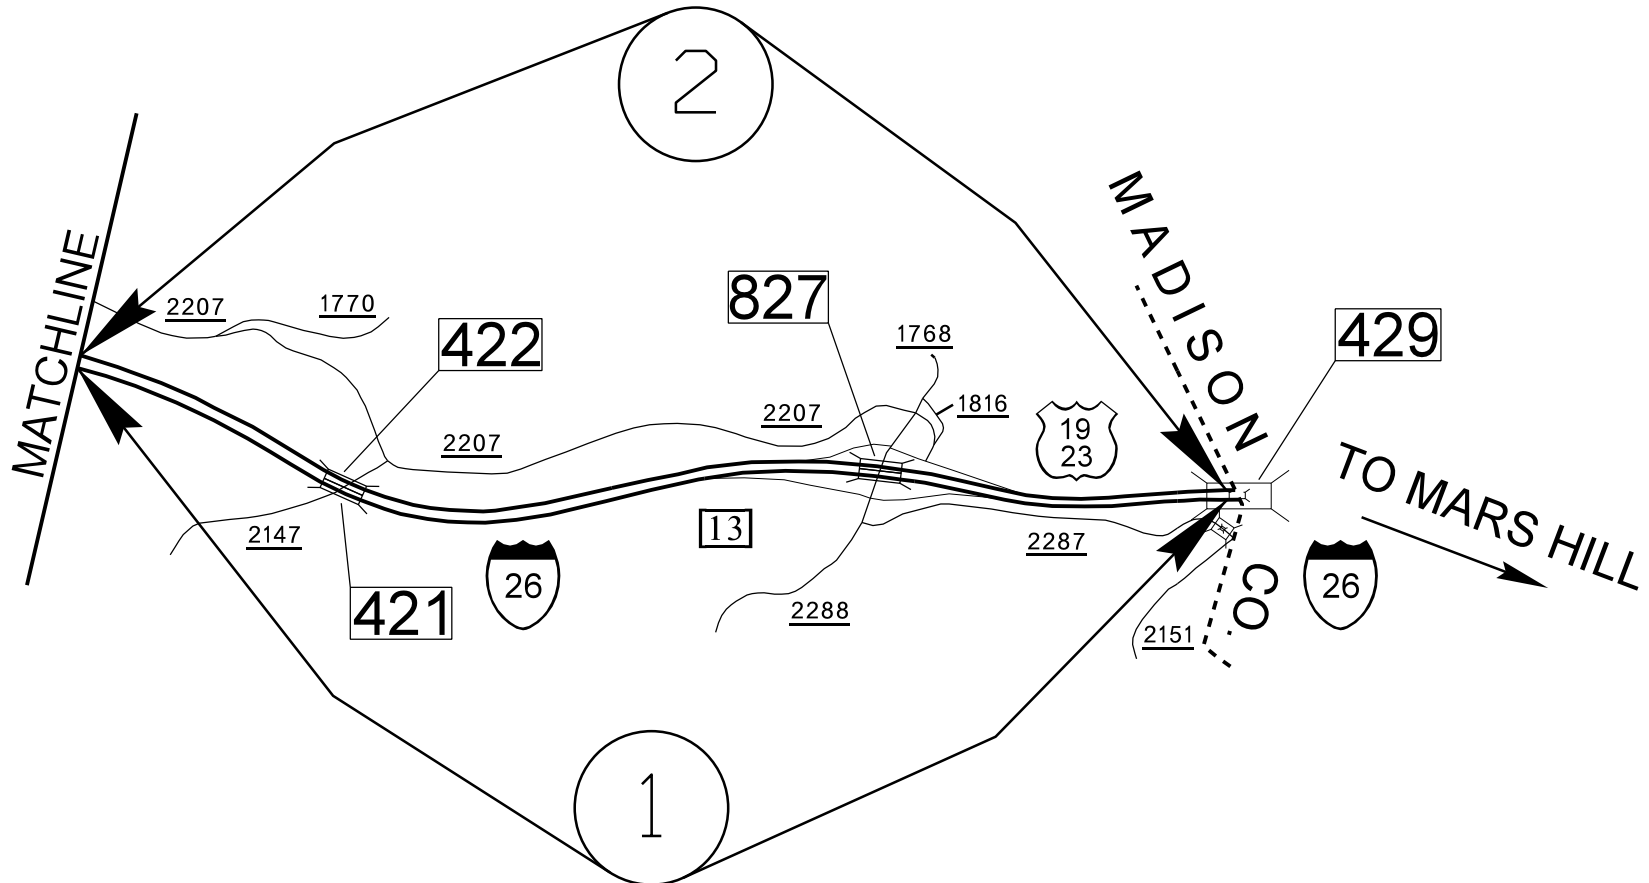

# BUNCOMBE COUNTY

I:\DEC-2016 15:38  
 S:\DDC\rdy\interstate Maintenance Preservation Program\Buncombe\I-5892 Vicinity Maps\I-5892\_Location\_Map.dgn  
 \$\$\$USERNAME\$\$\$

09/08/99