

CONFIDENTIAL AND PROPRIETARY PROPERTY OF
Elliott Bay Design Group North Carolina, PLLC
 MAY NOT BE USED FOR CONSTRUCTION OR PROVIDED TO
 ANY THIRD PARTIES WITHOUT PRIOR WRITTEN CONSENT.
 © 2017 ELLIOTT BAY DESIGN GROUP.

EQUIPMENT LIST			
ITEM	QTY	DESCRIPTION	MANUFACTURER, MODEL, NOTES
01	1	50" FLAT SCREEN TELEVISION	SEE REFERENCE 1
02	1	BUILDER'S PLAQUE	SEE REFERENCE 1
⊙	18	RECEPTACLE	DUPLEX, 120V, GFCI

REVISION HISTORY

REV	ZONE	DESCRIPTION	DWN	DATE	APVD

GENERAL NOTES

- ALL MATERIALS AND WORKMANSHIP SHALL BE IN ACCORDANCE WITH 46 CFR SUBCHAPTER T REGULATIONS.
- WHEELCHAIR TIE DOWNS SHALL BE PROVIDED WITH STAINLESS STEEL HARDWARE AND LOCATED AS SHOWN IN THE PASSENGER SPACE. PROVIDE TWO ADDITIONAL WHEELCHAIR TIE DOWN LOCATIONS ON THE EXTERIOR MAIN DECK PER OWNER'S GUIDANCE.
- LIFE JACKETS MOUNTED NEAR WHEELCHAIR TIE DOWNS ARE TO BE LOCATED CLEAR OF WHEELCHAIR SWING RADIUS.

REFERENCES


- 16109-003-802-0 CONTRACT SPECIFICATIONS
- 16109-003-101-1 PROFILES AND ARRANGEMENTS
- 16109-003-130-0 SUPERSTRUCTURE
- 16109-003-601-2 FOOD SERVICES ARRANGEMENT
- 16109-003-635-1 CEILING AND LIGHTING PLAN



Elliott Bay Design Group
 North Carolina, PLLC

CLIENT: NORTH CAROLINA D.O.T.
 RALEIGH, NORTH CAROLINA

PROJECT: PEDESTRIAN FERRY

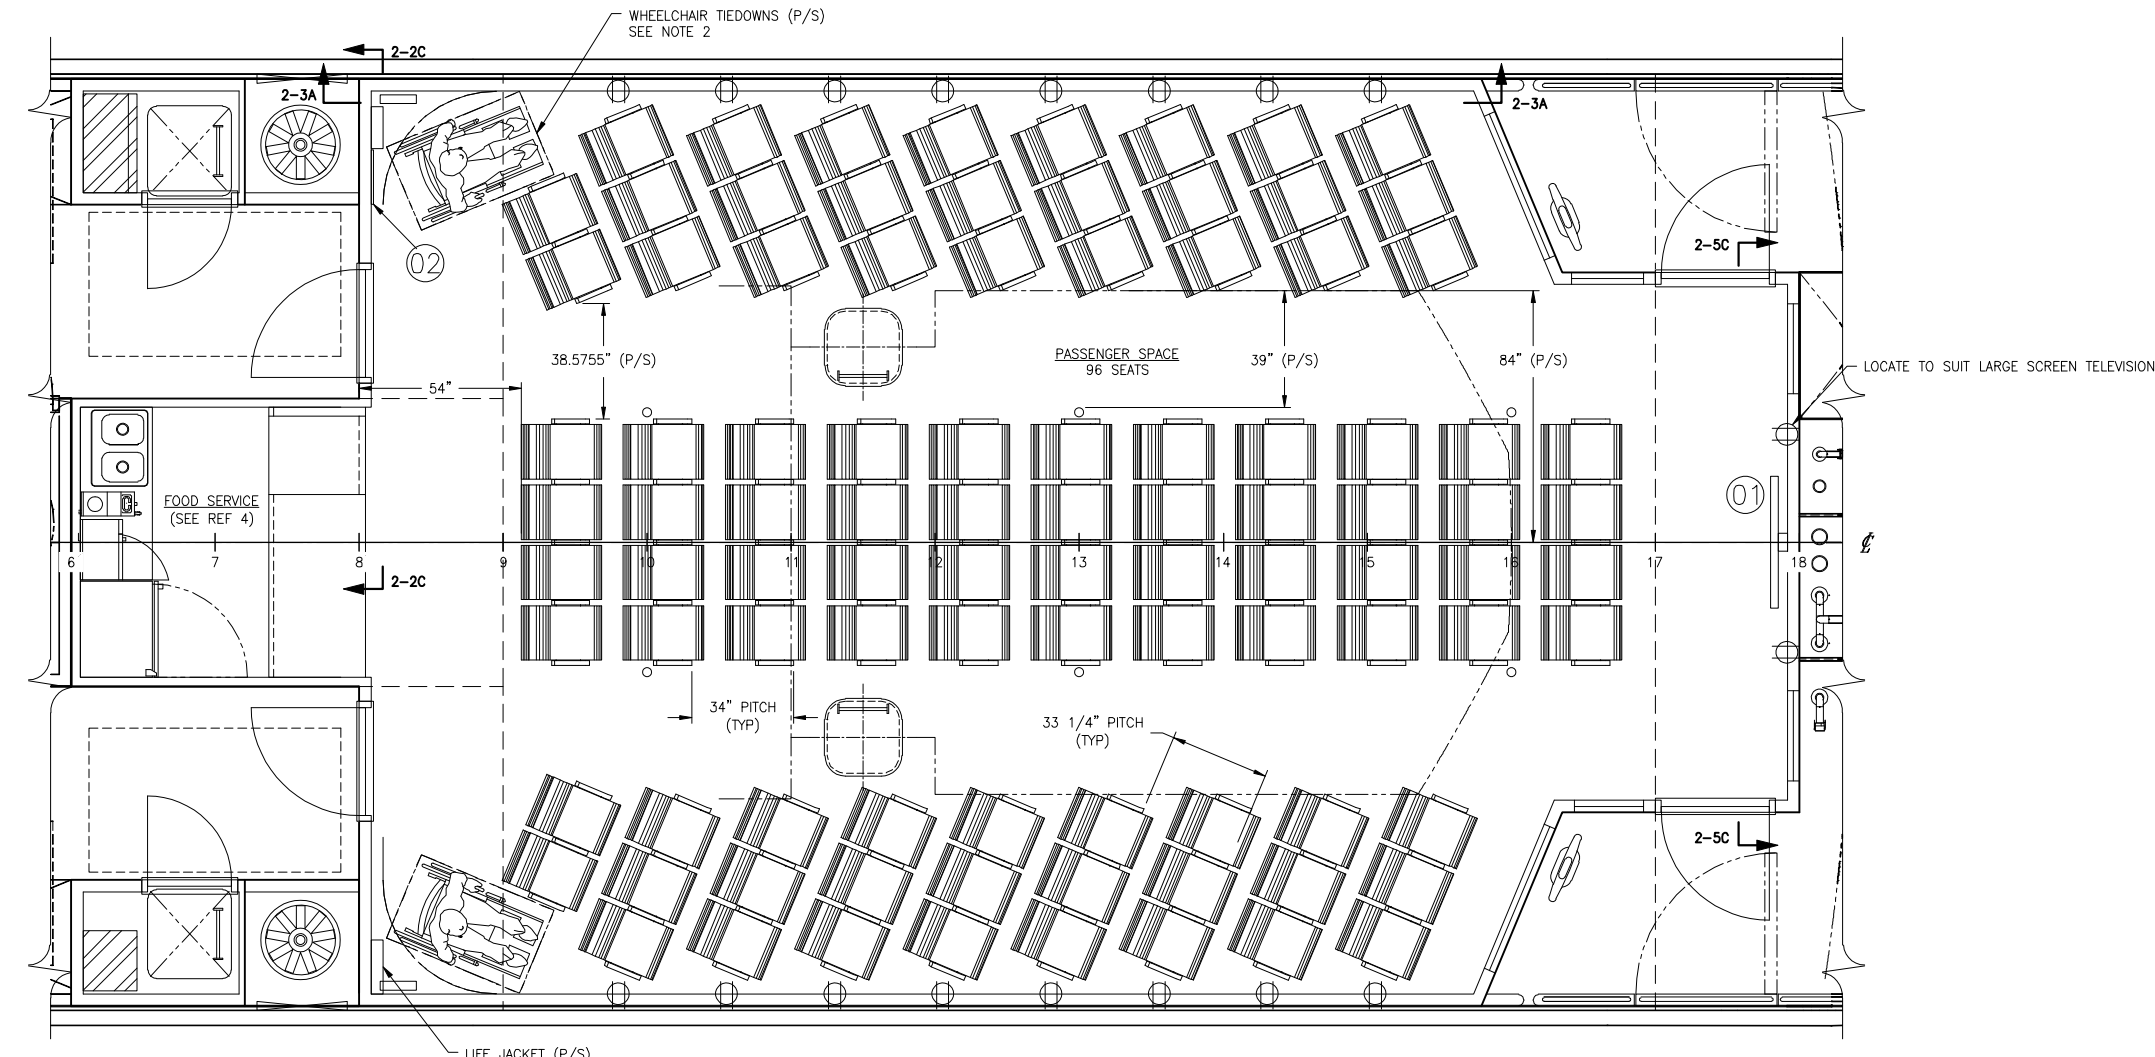

PLAN 1-4A
 MAIN DECK
 SCALE: 3/8"=1'-0"


PASSENGER SPACE ARRANGEMENT

SIZE	D	DWG NO.	16109-003-601-0	REV	-
SCALE	AS NOTED	FILE NAME	16109-003-601-0-	SHEET	1 OF 2
DWN	NJB	MOD		APVD	JAT
				APVD DATE	3/3/2017


3/2/2017 4:16:04 PM

CONFIDENTIAL AND PROPRIETARY PROPERTY OF
Elliott Bay Design Group North Carolina, PLLC
 MAY NOT BE USED FOR CONSTRUCTION OR PROVIDED TO
 ANY THIRD PARTIES WITHOUT PRIOR WRITTEN CONSENT.
 © 2017 ELLIOTT BAY DESIGN GROUP.


6 | 5 | 4 | 3 | 2 | 1

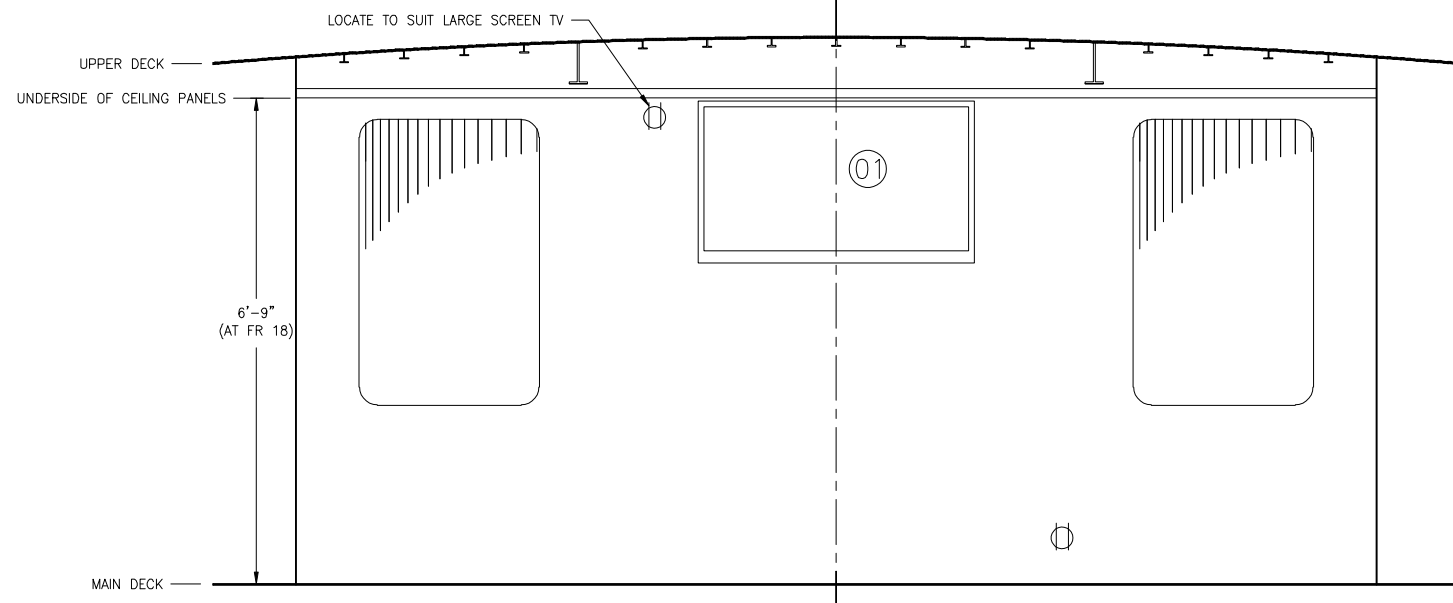

SECTION 2-5C
 FRAME 18 LOOKING FWD
 SCALE: 3/4"=1'-0"

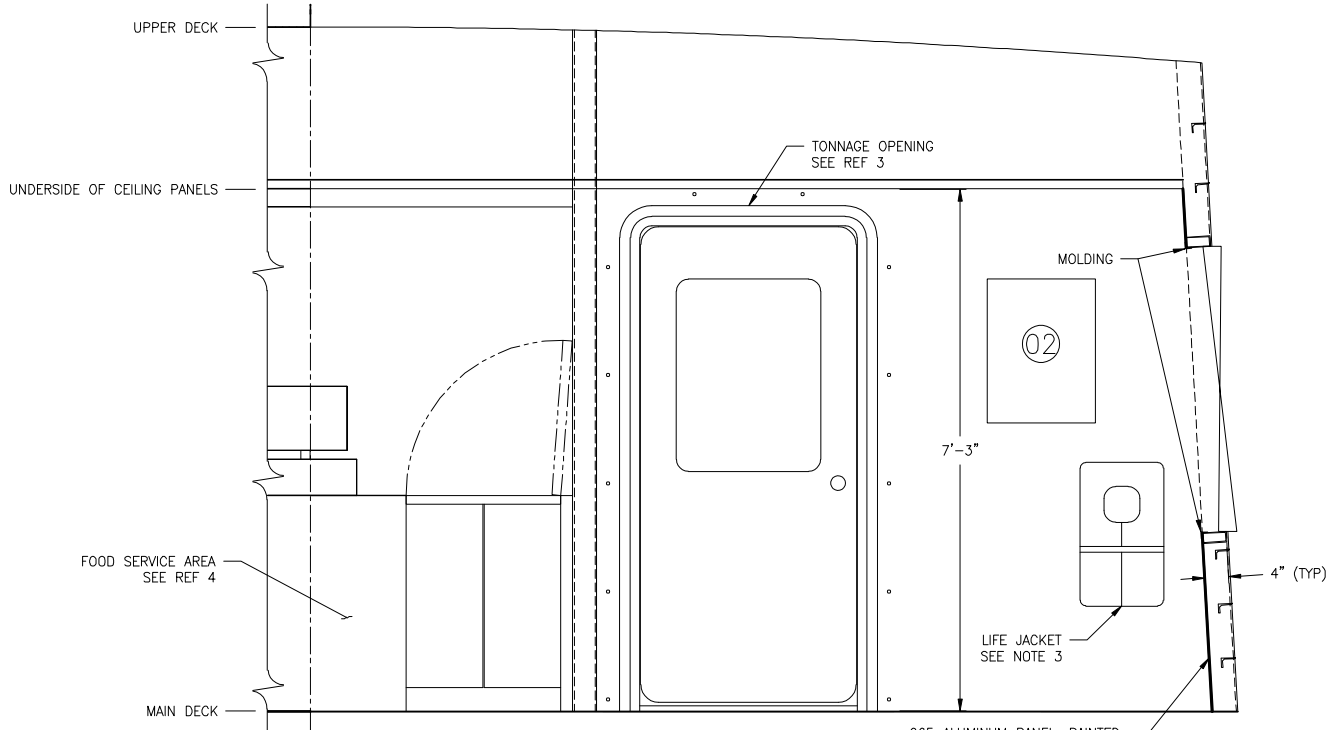

SECTION 2-2C
 FRAME 8 LOOKING AFT
 PORT SIDE SHOWN, STBD SIMILAR
 SCALE: 3/4"=1'-0"

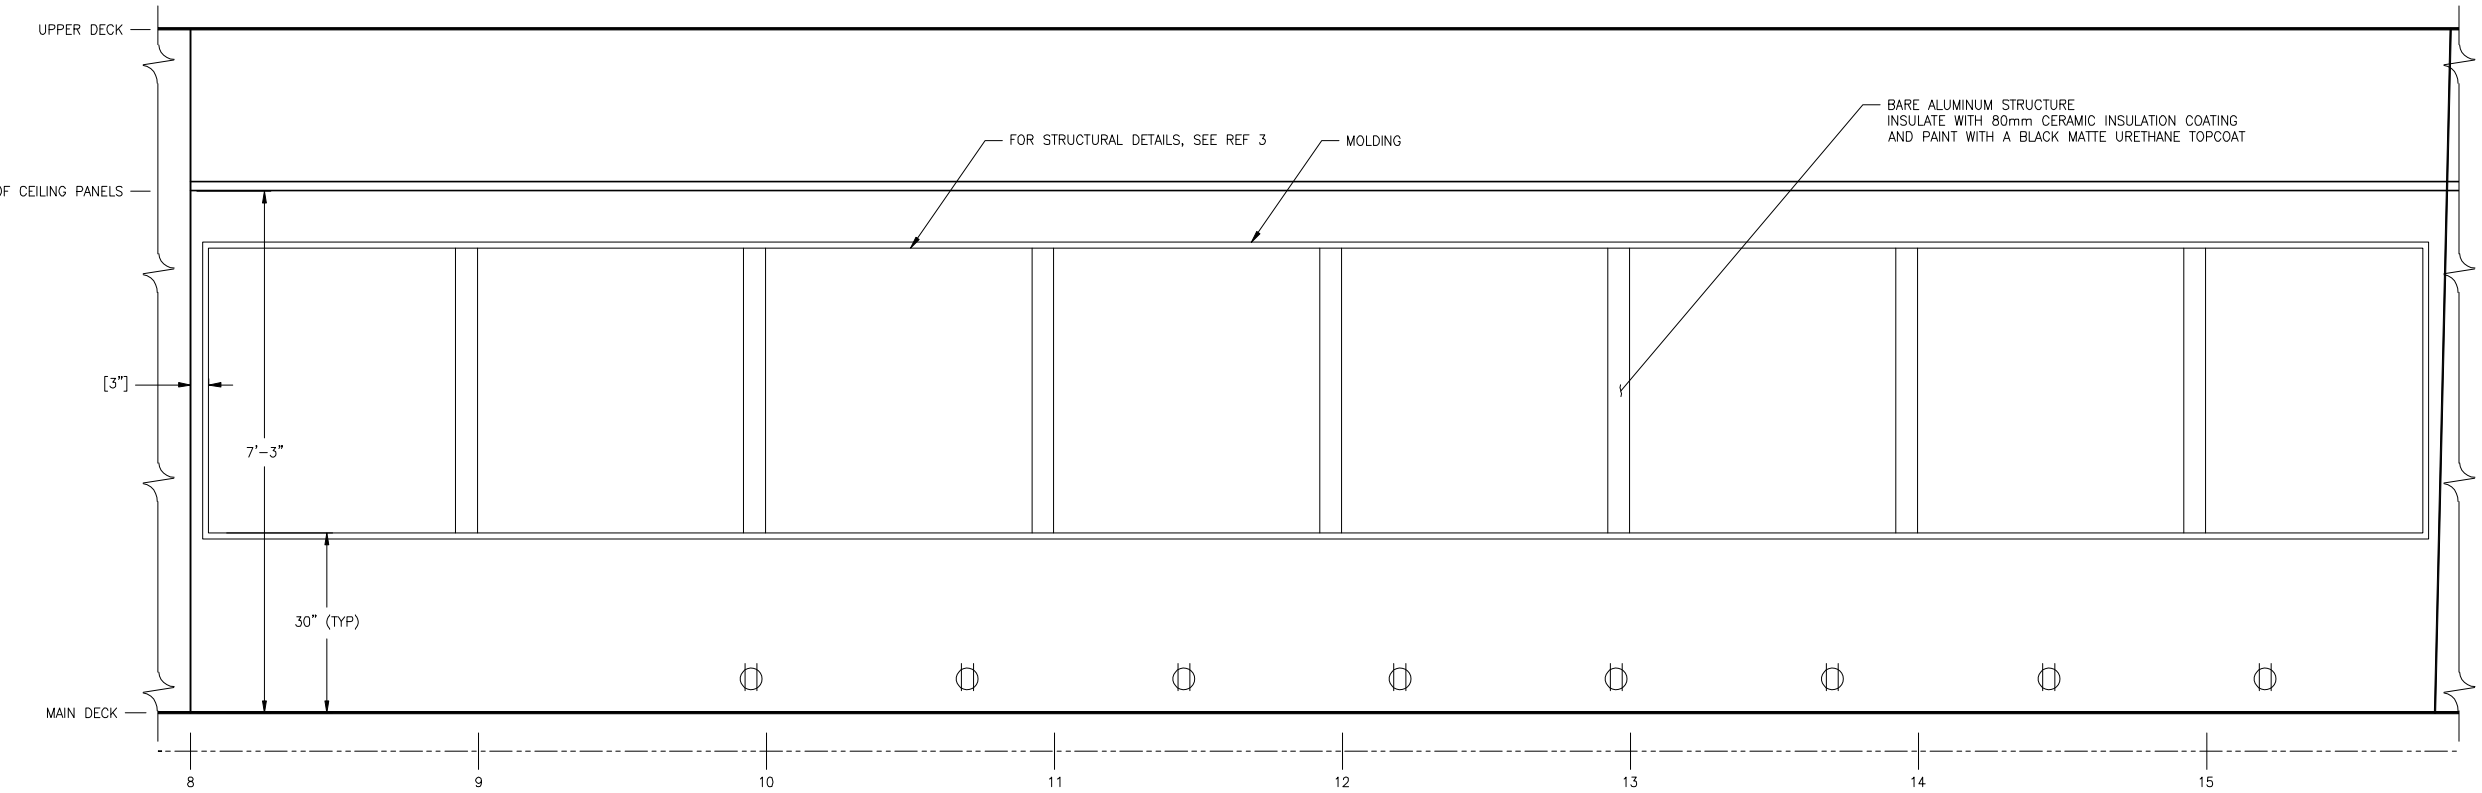

ELEVATION 2-3A
 PORT BHD LOOKING OUTBOARD
 STBD SIDE SIMILAR
 SCALE: 3/4"=1'-0"

6 | 5 | 4 | 3 | 2 | 1



SIZE	D	DWG NO.	16109-003-601-0	REV	-
SCALE	AS NOTED	FILE NAME	16109-003-601-0-	SHEET	2 OF 2

3/2/2017 4:18:15 PM