




5121 Kingdom Way,  
Suite 100  
Raleigh, NC 27607  
NC License No: F-0258

PROJECT REFERENCE NO.	SHEET NO.
R-5311A	EC-8/CONST.06
RW SHEET NO.	
ROADSIDE ENVIRONMENTAL PROJECT ENGINEER	

LEVEL III CERTIFIED BY:  
STACEY H. BAILEY, PE  
CERTIFICATION NUMBER: 3074  
ISSUED: JANUARY 13, 2017

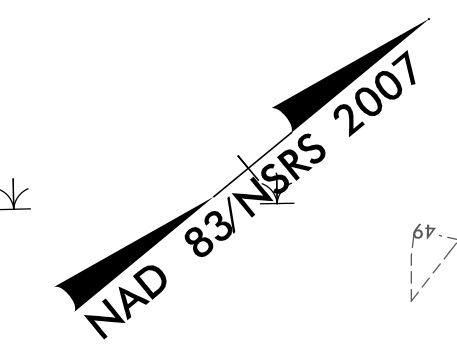


JAMES E. PIERCE, JR.  
AND JOCELYN P. BAGELY  
PIN: 5984-94-6822  
DB 687 PG 754  
DB 137 PG 245 (MAP)

SEE SHEET 7  
MATCHLINE

REVISIONS

MATCHLINE -EL- STA 334+00  
SEE SHEET 5

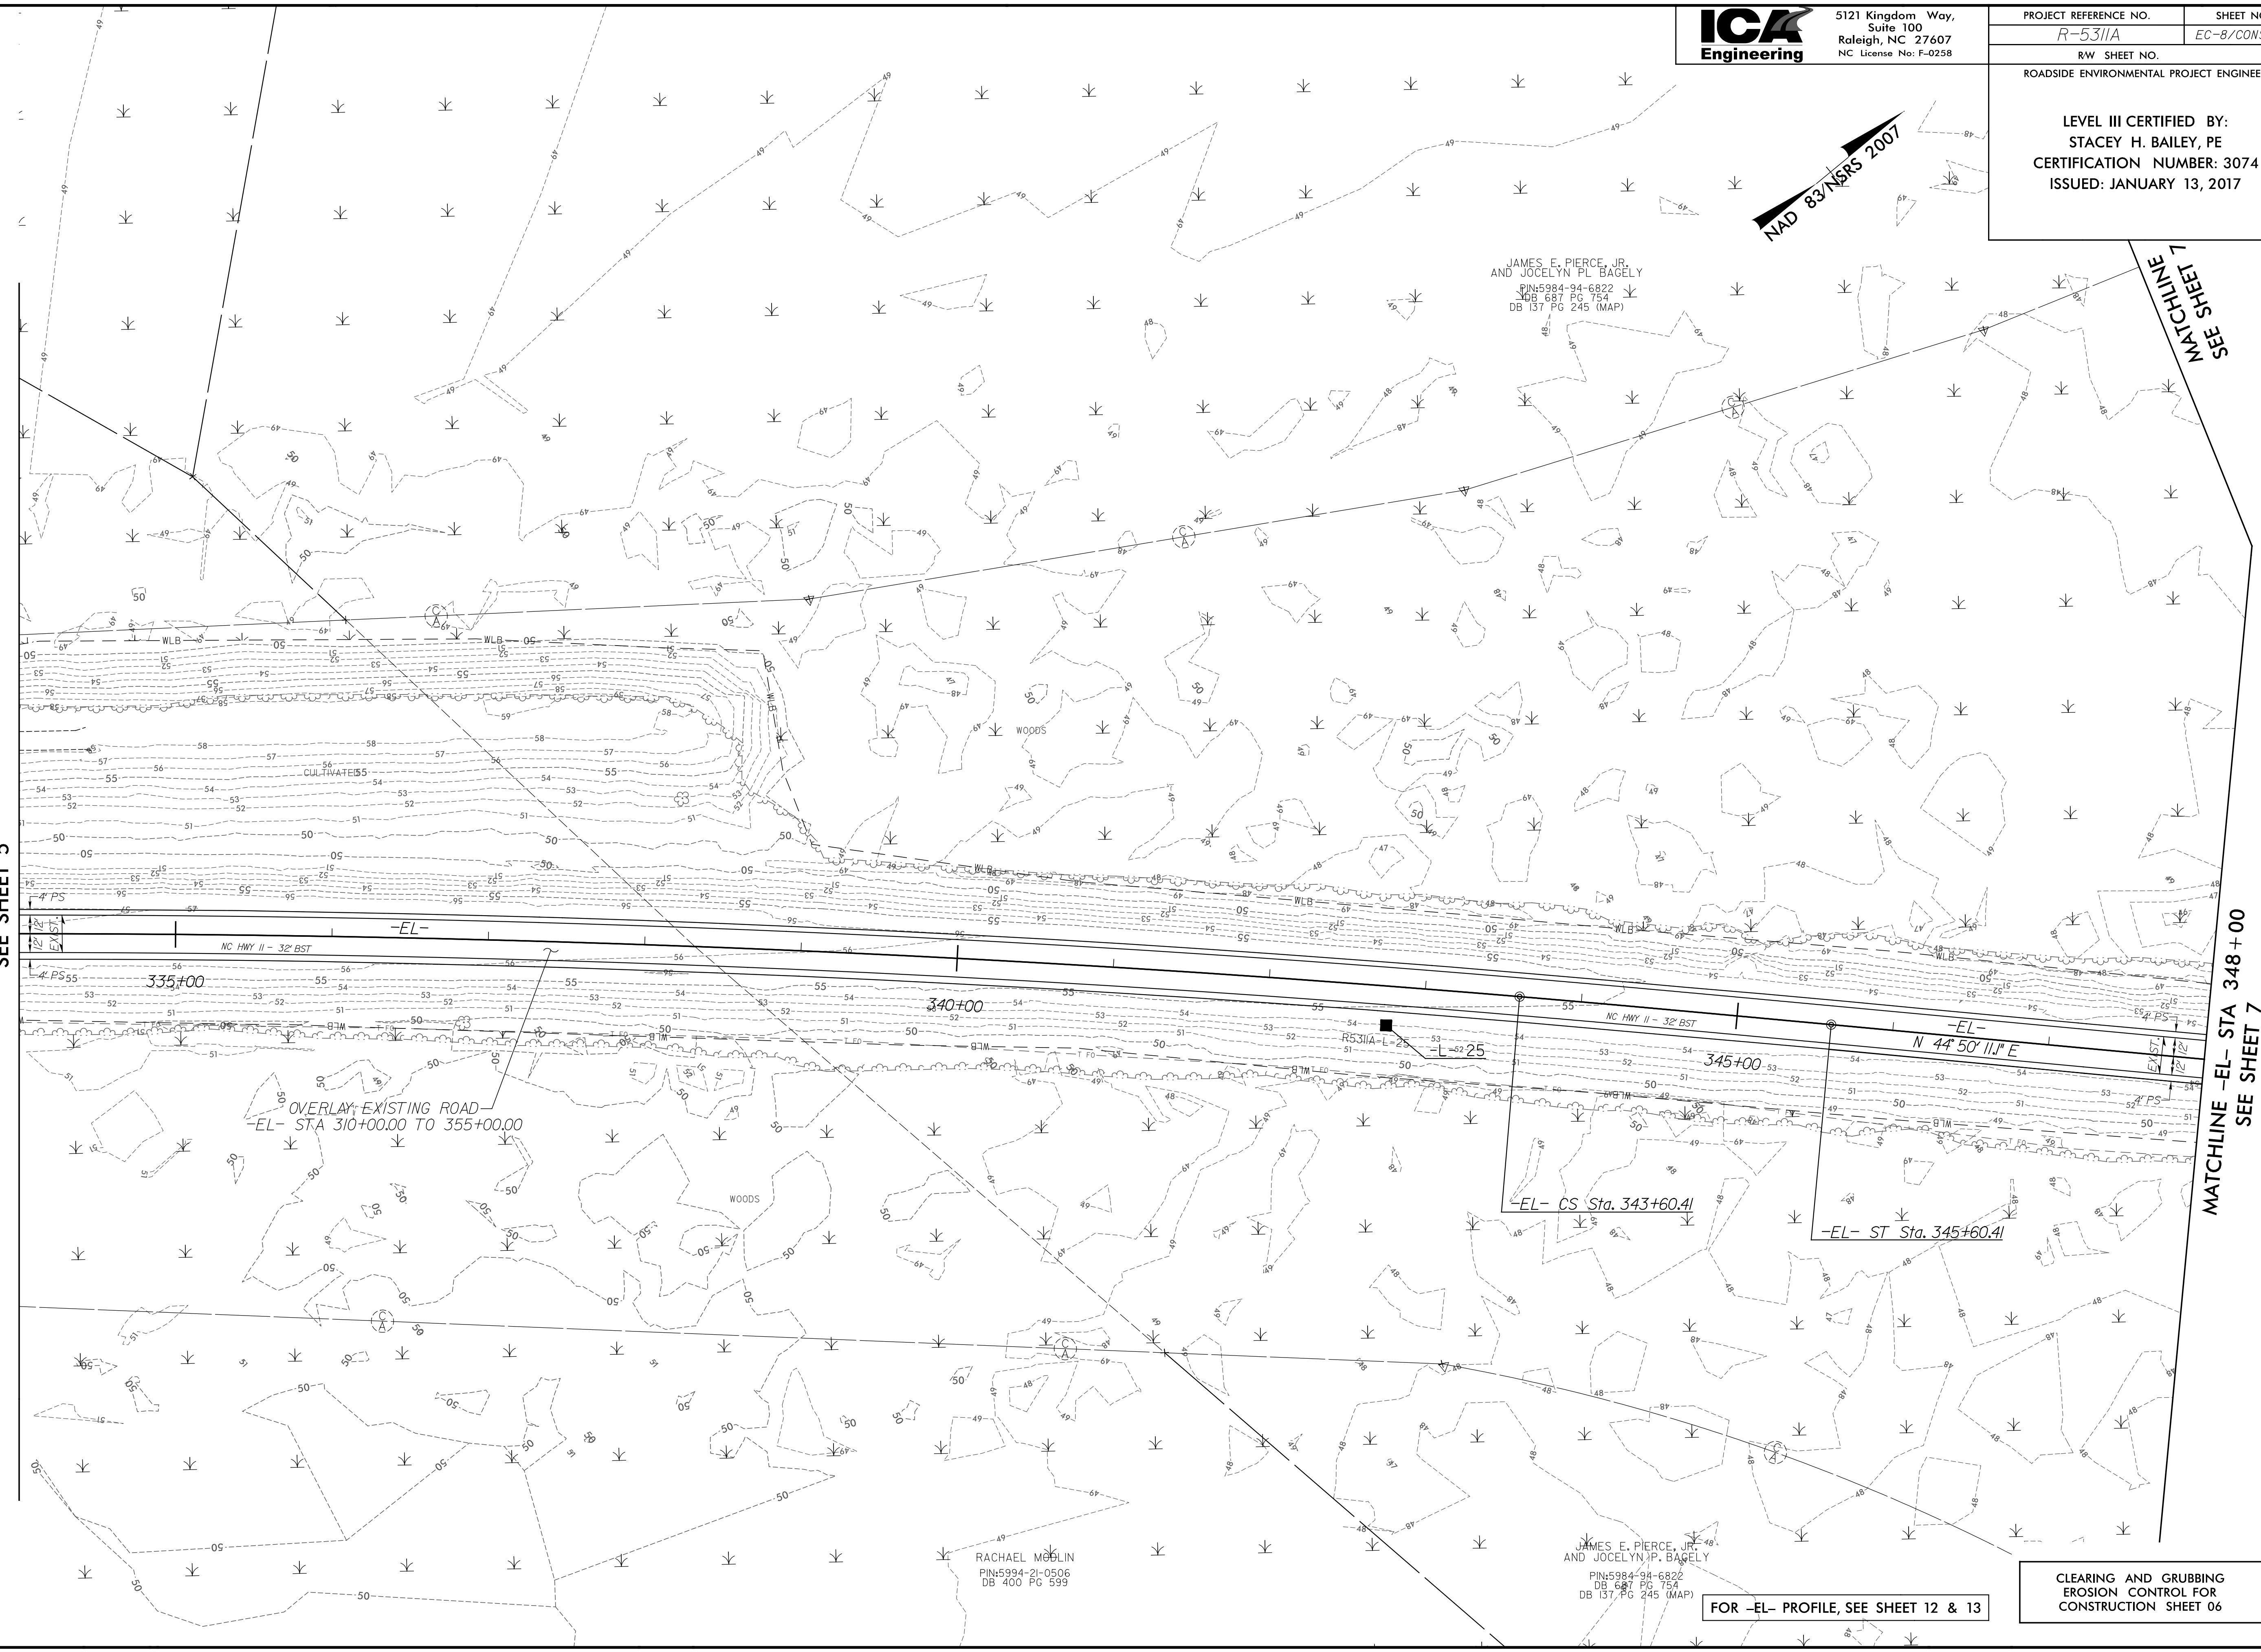

MATCHLINE -EL- STA 348+00  
SEE SHEET 7

RACHAEL MOULIN  
PIN: 5994-21-0506  
DB 400 PG 599

JAMES E. PIERCE, JR.  
AND JOCELYN P. BAGELY  
PIN: 5984-94-6822  
DB 687 PG 754  
DB 137 PG 245 (MAP)

FOR -EL- PROFILE, SEE SHEET 12 & 13

CLEARING AND GRUBBING  
EROSION CONTROL FOR  
CONSTRUCTION SHEET 06

1/13/2017  
R-5311A - hvd\_erosion\_e&g\_psh\_06.dgn  
ICA ENGINEERING, INC.