


5121 Kingdom Way,
Suite 100
Raleigh, NC 27607
NC License No: F-0258


PROJECT REFERENCE NO.	SHEET NO.
R-5311A	EC-18/CONST.06
RW SHEET NO.	
ROADSIDE ENVIRONMENTAL PROJECT ENGINEER	

LEVEL III CERTIFIED BY:
STACEY H. BAILEY, PE
CERTIFICATION NUMBER: 3074
ISSUED: JANUARY 13, 2017

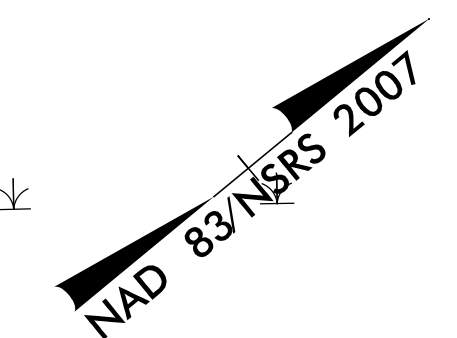

JAMES E. PIERCE, JR.
AND JOCELYN PL BAGELY
PIN: 5984-94-6822
DB 687 PG 754
DB 137 PG 245 (MAP)

SEE SHEET 7
MATCHLINE

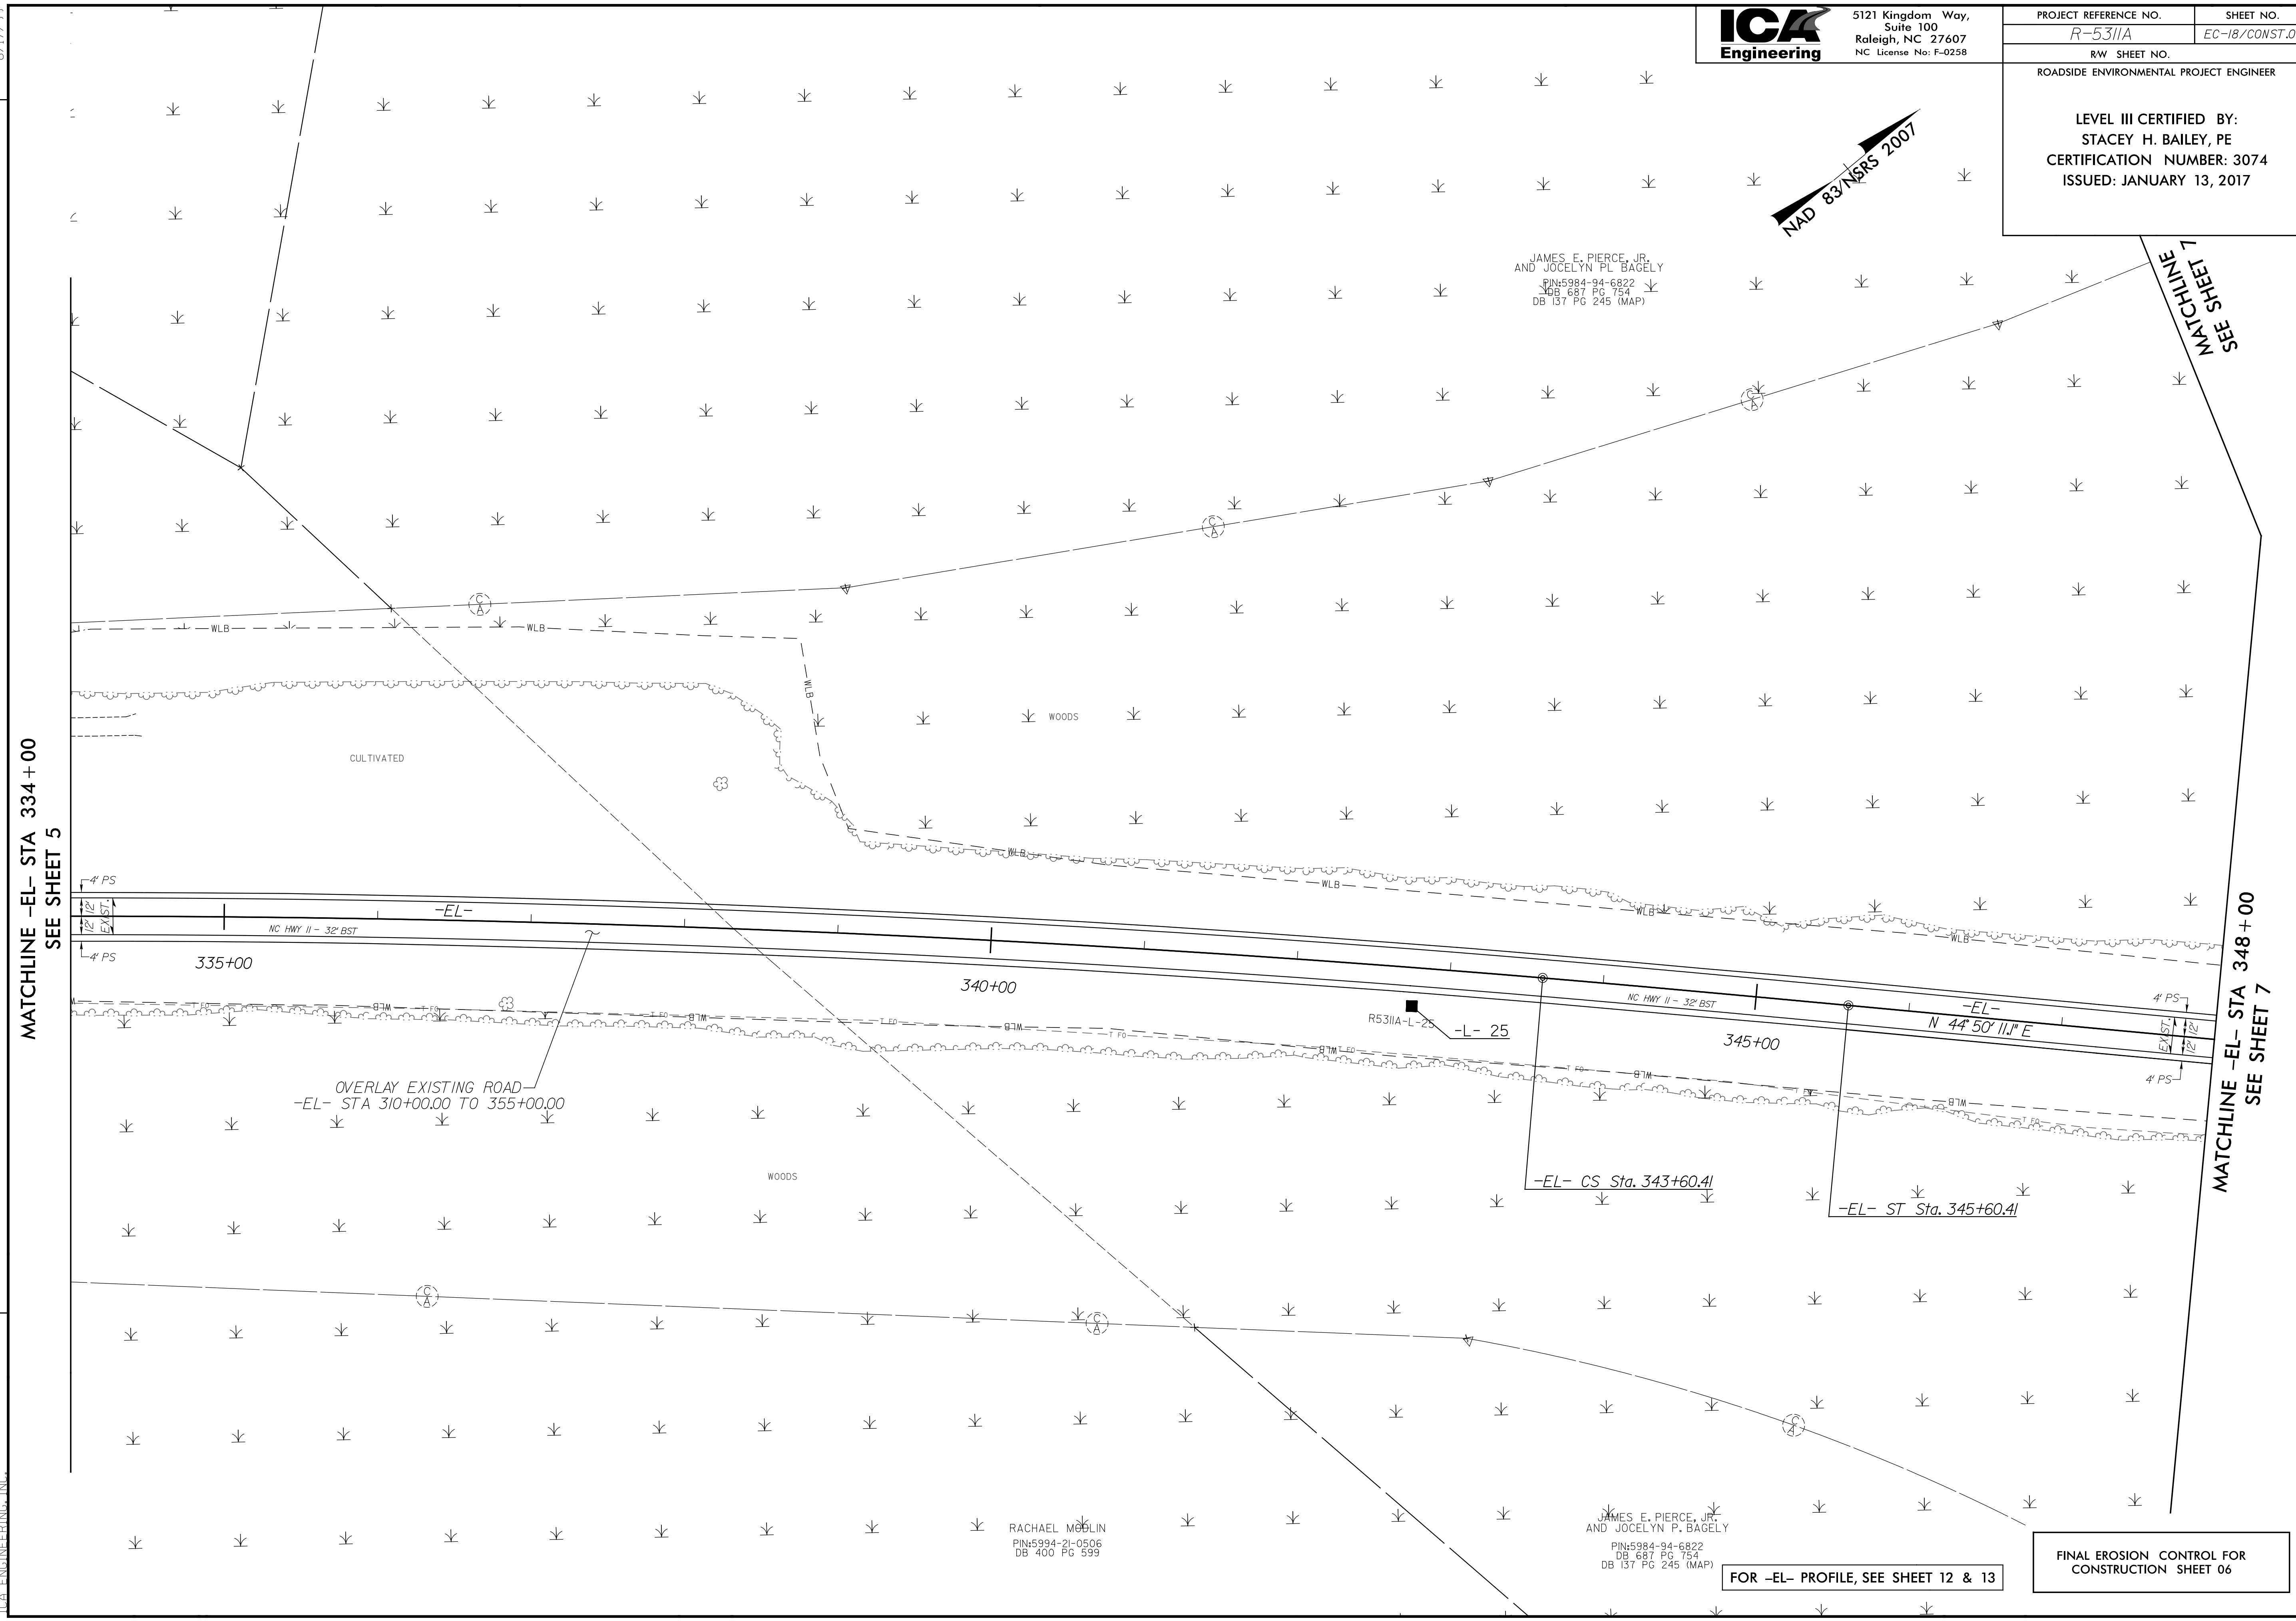

REVISIONS

MATCHLINE -EL- STA 334+00
SEE SHEET 5

MATCHLINE -EL- STA 348+00
SEE SHEET 7

OVERLAY EXISTING ROAD
-EL- STA 310+00.00 TO 355+00.00

-EL- CS Sta. 343+60.41

-EL- ST Sta. 345+60.41

RACHAEL MOULIN
PIN: 5994-21-0506
DB 400 PG 599

JAMES E. PIERCE, JR.
AND JOCELYN P. BAGELY
PIN: 5984-94-6822
DB 687 PG 754
DB 137 PG 245 (MAP)

FOR -EL- PROFILE, SEE SHEET 12 & 13

FINAL EROSION CONTROL FOR
CONSTRUCTION SHEET 06

8/17/99
1/13/2017
R-5311A final revision f.m.a.l.psh.06.dgn
ICA ENGINEERING, INC.