

09/28/2017

**TIP PROJECT: U-3621A**


T.I.P. NO.	SHEET NO.
U-3621A	UC-1

STATE OF NORTH CAROLINA  
DIVISION OF HIGHWAYS

**UTILITY CONSTRUCTION PLANS  
NASH COUNTY**



**LOCATION: ROCKY MOUNT - SR 1604 (HUNTER HILL ROAD)  
FROM SR 1613 (NORTH WINSTEAD AVE)  
TO SR 1616 (COUNTRY CLUB ROAD)**

**TYPE OF WORK: WATER LINE AND SANITARY SEWER RELOCATION**

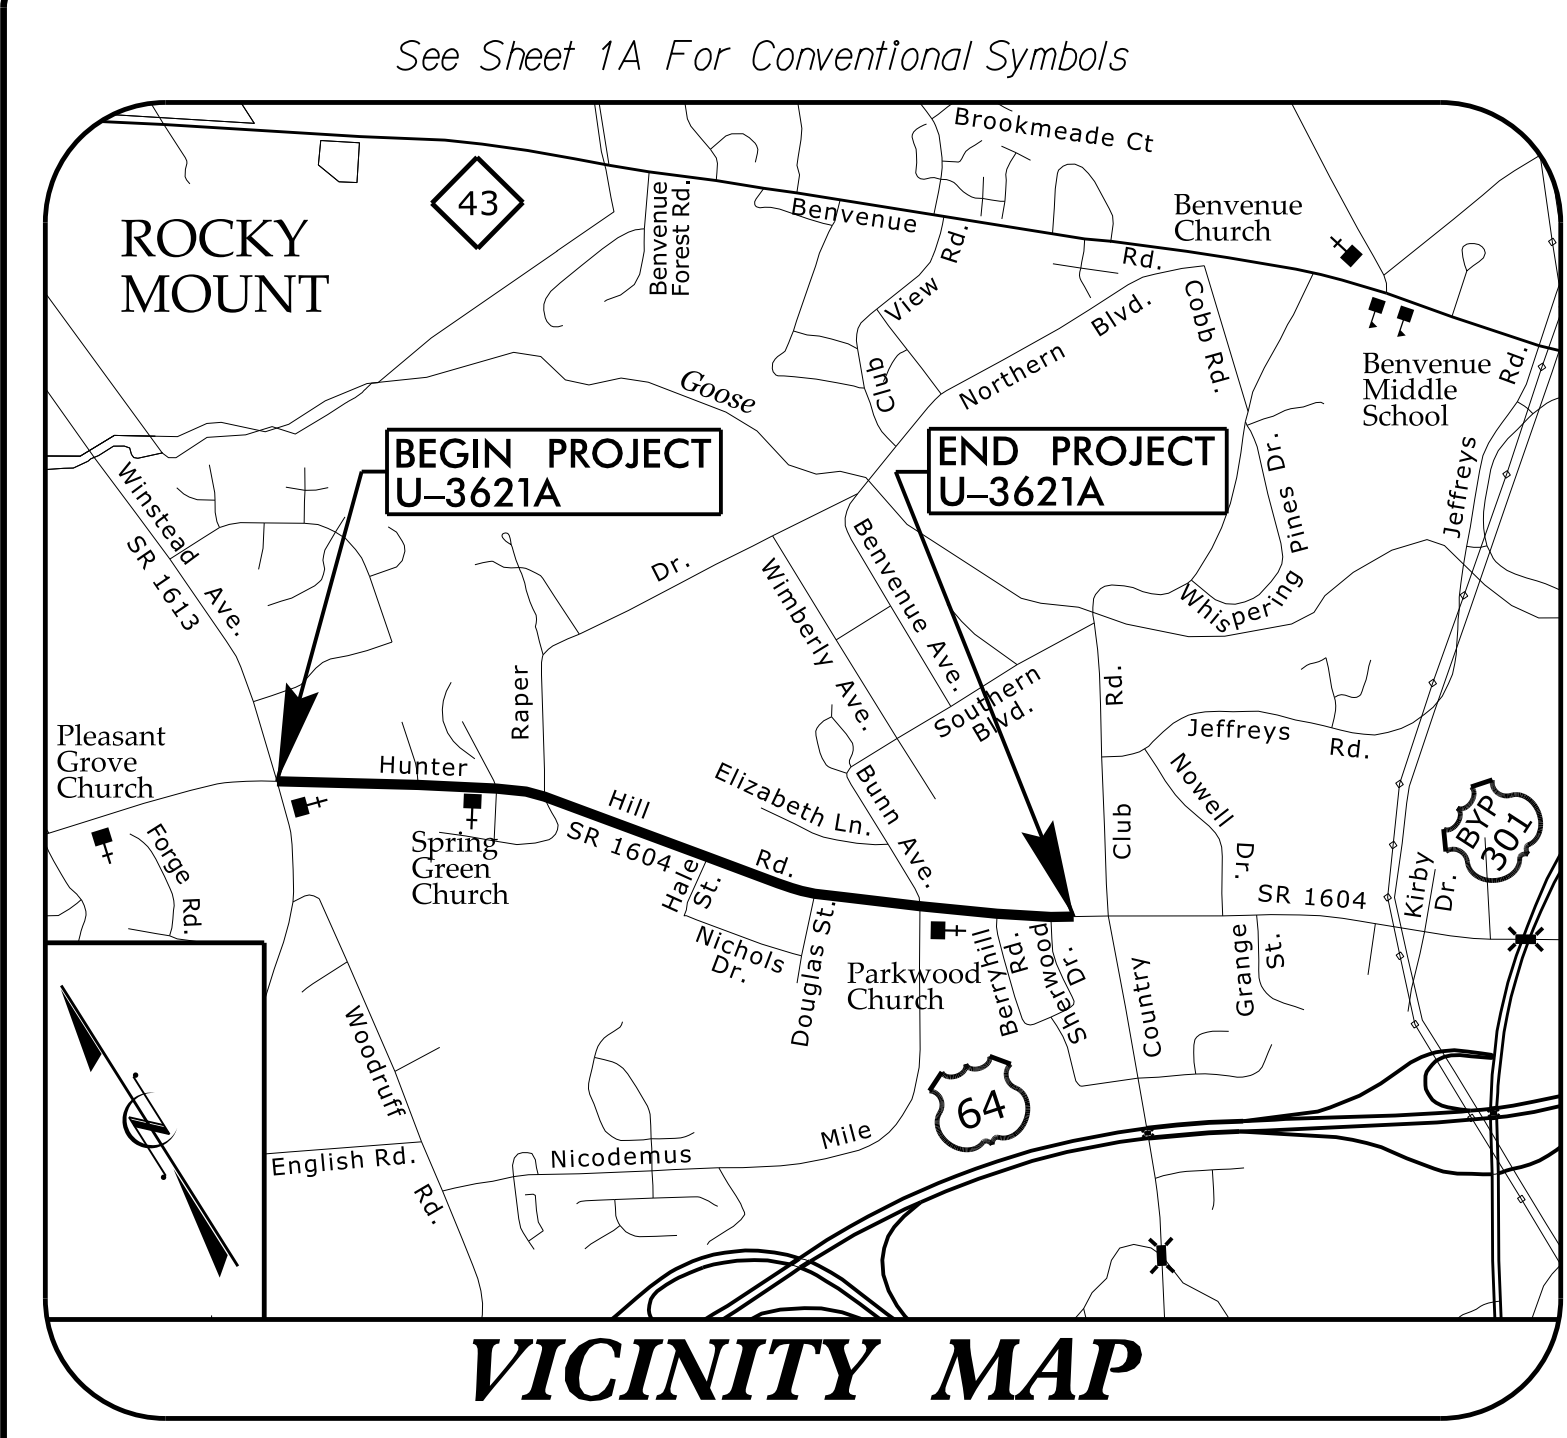

**BEGIN TIP PROJECT U-3621A**

**-L- POC STA. 25 + 75.00**

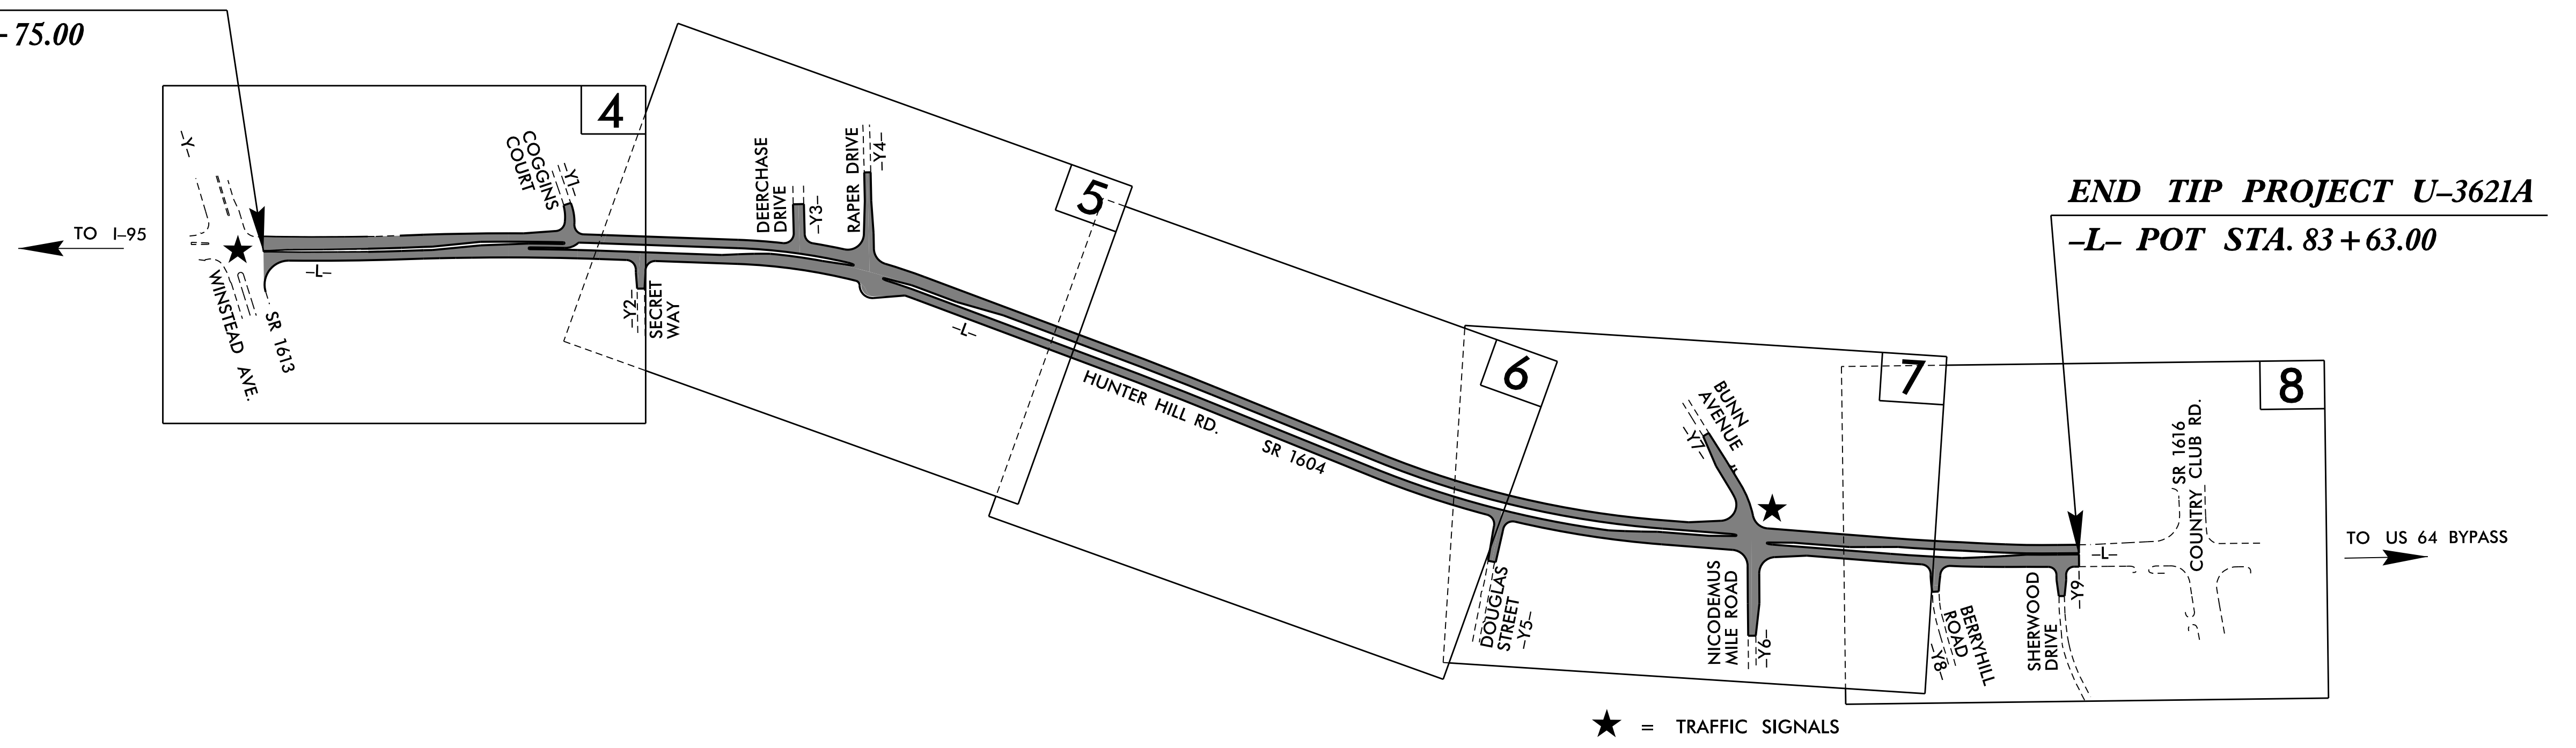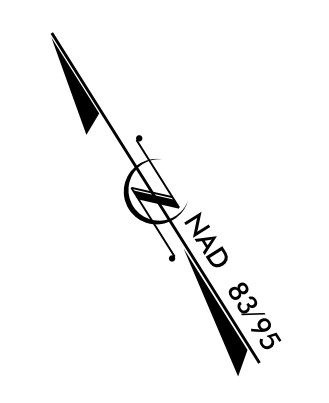

**END TIP PROJECT U-3621A**


**-L- POT STA. 83 + 63.00**

★ = TRAFFIC SIGNALS

NOTE:

- 1. THIS PROJECT IS WITHIN THE MUNICIPAL BOUNDARIES OF THE CITY OF ROCKY MOUNT.

DOCUMENT NOT CONSIDERED FINAL  
UNTIL ALL SIGNATURES ARE COMPLETED

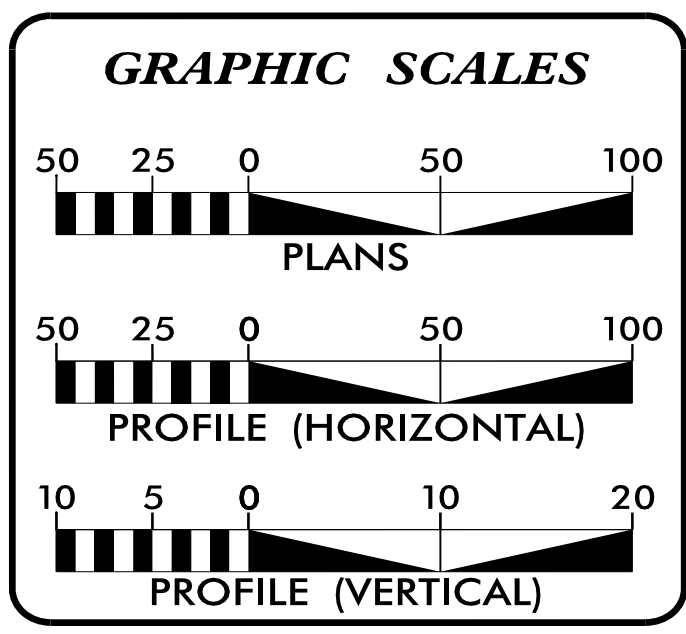

SHEET NO.:	DESCRIPTION:
UC-1	TITLE SHEET
UC-2	UTILITY SYMBOLOLOGY
UC-3 THRU UC-3A	UTILITY NOTES
UC-3B THRU UC-3J	UTILITY DETAILS
UC-4 THRU UC-8	UTILITY PLAN SHEETS
UC-9 THRU UC-10	UTILITY PROFILE SHEETS

WATER AND SEWER OWNERS ON PROJECT
(A) WATER - CITY OF ROCKY MOUNT
(B) SANITARY SEWER - CITY OF ROCKY MOUNT

PREPARED IN THE OFFICE OF

**M A Engineering Consultants, Inc.** NC License: F-0160  
598 East Chatham Street Suite 137 Cary, NC 27511  
Phone: 919.297.0220 Fax: 919.297.0221

**KEVIN ZDEB, PE** PROJECT ENGINEER  
**GARY BLUE** PROJECT DESIGNER

SEAL

3/21/2017

**DIVISION OF HIGHWAYS UTILITIES UNIT**  
1555 MAIL SERVICES CENTER  
RALEIGH, NC 27699-1555  
PHONE (919) 707-6690  
FAX (919) 250-4151

**BO HEMPHILL, PE** UTILITIES REGIONAL ENGINEER  
**KIFAH KAMIL** UTILITIES ENGINEER  
**KYLE PLEASANT** AREA UTILITY AGENT  
**LARRY M. JAMES, JR.** UTILITY AGENT

\$\$\$\$\$ SYSTEM TIME\$\$\$\$\$  
\$\$\$\$\$ DGN\$\$\$\$\$  
\$\$\$\$\$ USERNAME\$\$\$\$\$