



**EXISTING CONDITIONS PHOTOGRAPH #6**  
NOT TO SCALE




**EXISTING CONDITIONS PHOTOGRAPH #7**  
NOT TO SCALE



**EXISTING CONDITIONS PHOTOGRAPH #8**  
NOT TO SCALE



**2 TOWER PLAN - PLUMBING DEMOLITION**  
1/4" = 1'-0"

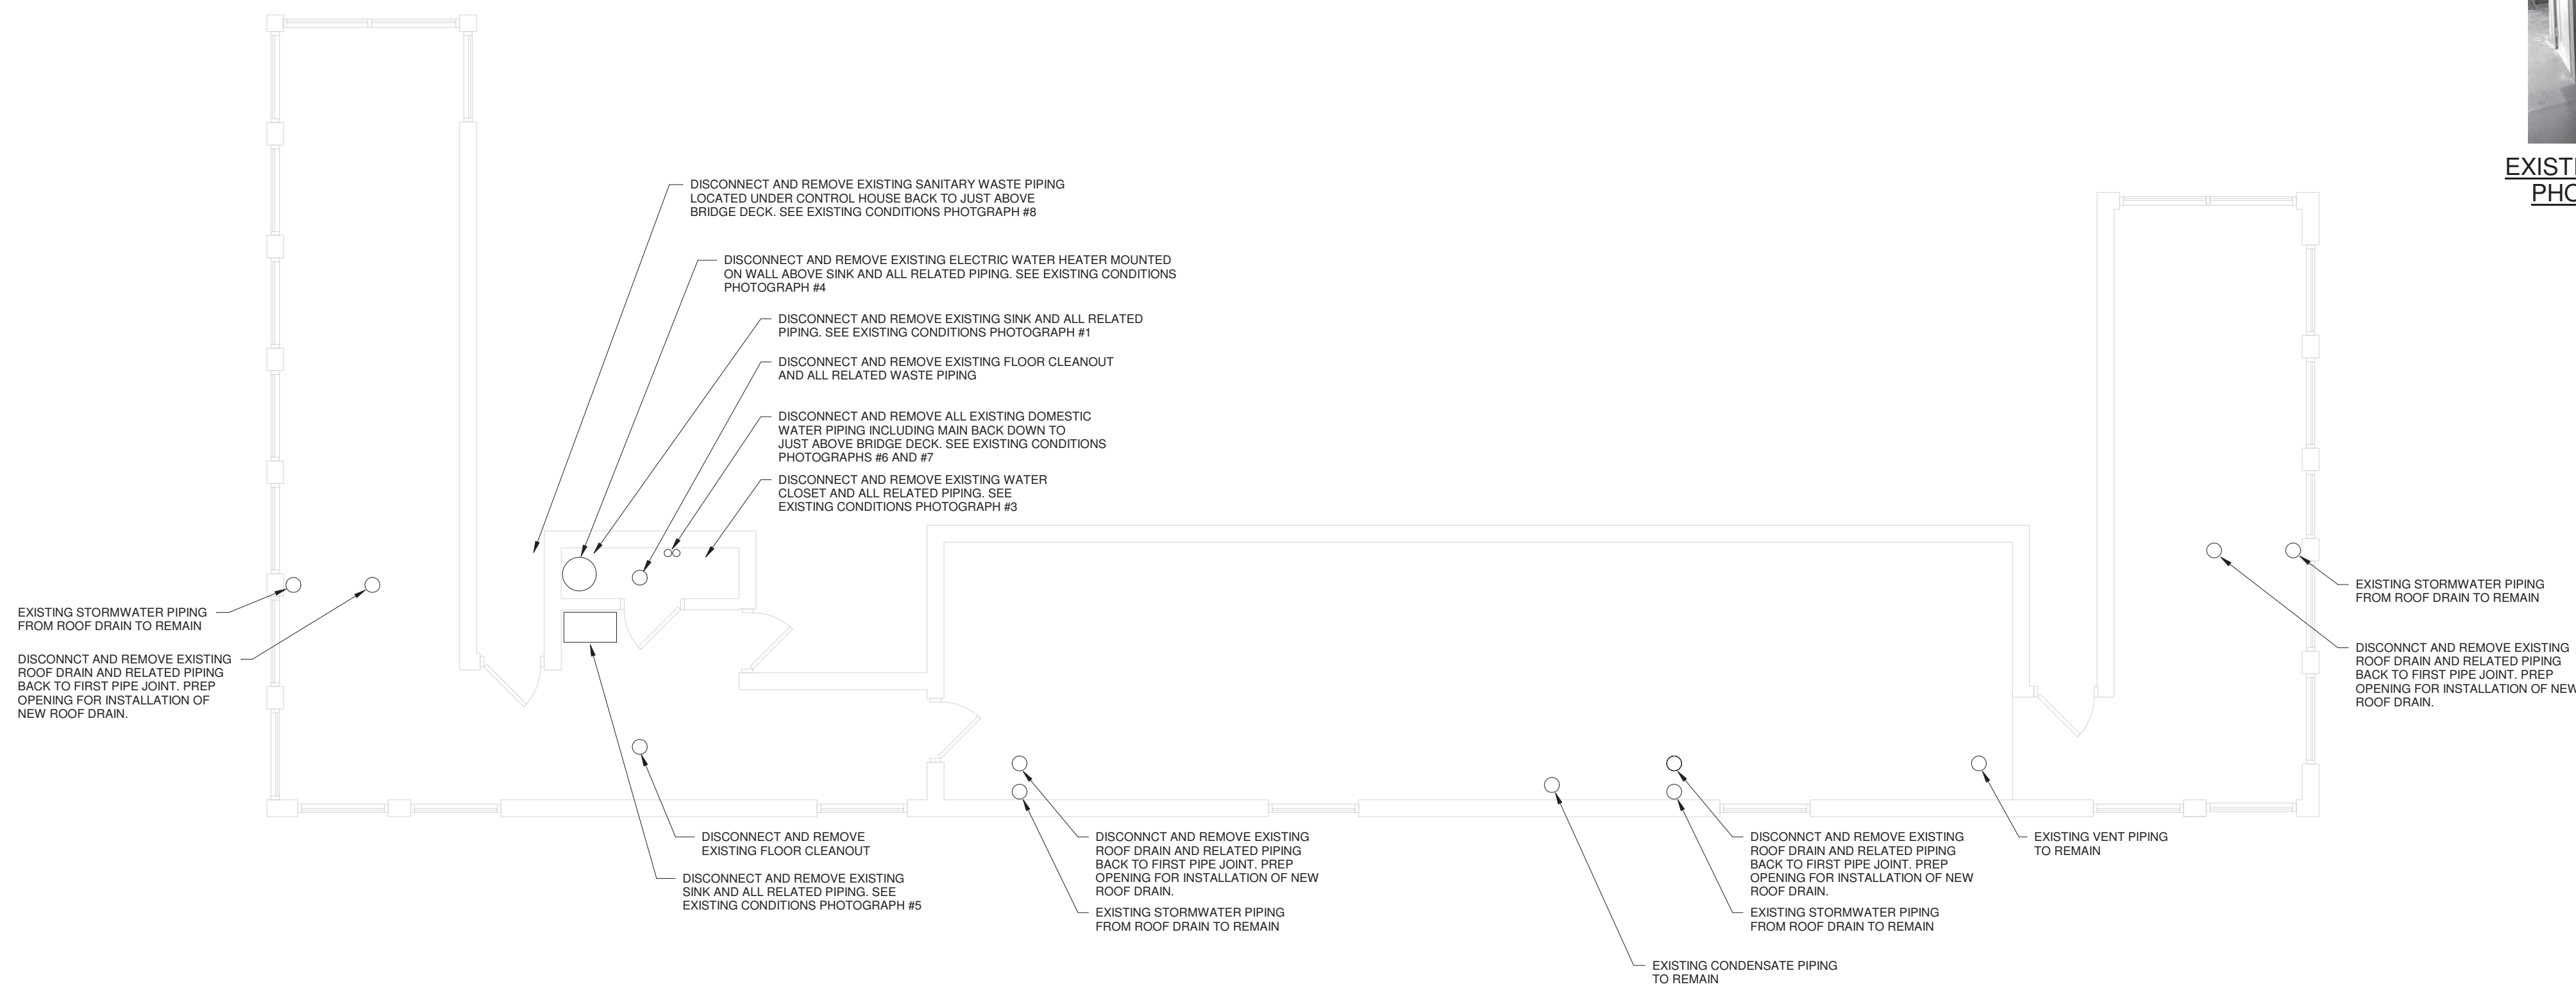


**1 CONTROL HOUSE PLAN - EAST TOWER - PLUMBING DEMOLITION**  
1/4" = 1'-0"



**EXISTING CONDITIONS PHOTOGRAPH #2**  
NOT TO SCALE



**EXISTING CONDITIONS PHOTOGRAPH #1**  
NOT TO SCALE

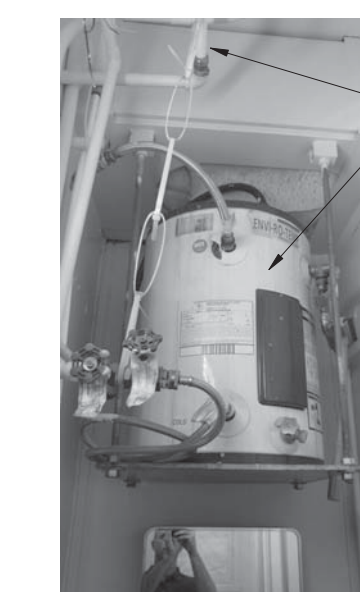

**EXISTING CONDITIONS PHOTOGRAPH #4**  
NOT TO SCALE



**EXISTING CONDITIONS PHOTOGRAPH #3**  
NOT TO SCALE



**EXISTING CONDITIONS PHOTOGRAPH #5**  
NOT TO SCALE

**100% CONSTRUCTION DOCUMENTS**

ALL REPORTS, PLANS SPECIFICATIONS AND COMPUTER FILES RELATING TO THIS PROJECT ARE THE PROPERTY OF CENTERPOINT ENGINEERING, INC. CENTERPOINT ENGINEERING, INC. RETAINS ALL COMMON LAW, STATUTE AND OTHER RESERVED RIGHTS INCLUDING THE COPYRIGHT. THESE TO REPRODUCTION OF THE MATERIAL HEREIN OR SUBSTANTIAL USE WITHOUT WRITTEN PERMISSION OF CENTERPOINT ENGINEERING, INC. VIOLATION OF THE COPYRIGHT LAWS OF THE UNITED STATES AND WILL BE SUBJECT TO LEGAL PROSECUTION. © CENTERPOINT ENGINEERING, INC. 2017


**REVISIONS**

NO.	DATE	NAME	DESCRIPTION OF CHANGES

**CRABTREE ROHRBAUGH & ASSOCIATES - ARCHITECTS**  
 250 WEST MAIN STREET, SUITE 200  
 CHARLOTTESVILLE, VA 22902  
 434-975-7262 FAX 434-975-7263  
[www.cra-architects.com](http://www.cra-architects.com)

**401 EAST WINDING HILL ROAD**  
**MECHANICSBURG, PA 17055**  
**717-458-0272 FAX 717-458-0047**

RENOVATIONS TO  
**CAPE FEAR RIVER MEMORIAL LIFT BRIDGE**  
 NORTH CAROLINA DEPT. OF TRANSPORTATION

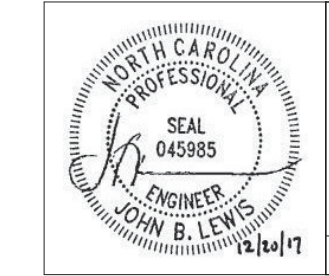

**CENTERPOINT ENGINEERING, INC.**  
 ENGINEERING, INC. COPYRIGHT © 2017  
 2 MARKET PLAZA WAY  
 MECHANICSBURG, PA 17055  
 PHONE: (717) 795-8575  
 FAX: (717) 795-9110  
 DESIGNED BY: BFL FUNCTIONAL LEAD: JBL PROJECT NO. 17096

FLOOR PLANS AND EXISTING CONDITIONS PHOTOGRAPHS - DEMOLITION PLUMBING  
 PLOT SCALE: 1/4" = 1'-0"  
 FILENAME: 15BPR Memorial Bridge NC Rev01.rvt  
 PLSB.rvt  
 DATE: DECEMBER 20, 2017

**PROJECT 15BPR.15**  
**P8.1**