

 
USE FOR LIGHTING CONSTRUCTION ONLY

PROJECT REFERENCE NO. I-5506	SHEET NO. E4
---------------------------------	-----------------





DocuSigned by:
Paul Chan 11/17/2017

**DOCUMENT NOT CONSIDERED FINAL
UNLESS ALL SIGNATURES COMPLETED**



SEE SHEET "E1" FOR
LEGEND & △ NOTES

MATCHLINE WITH SHEET E3

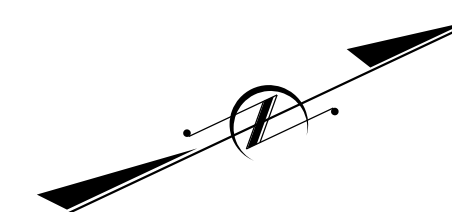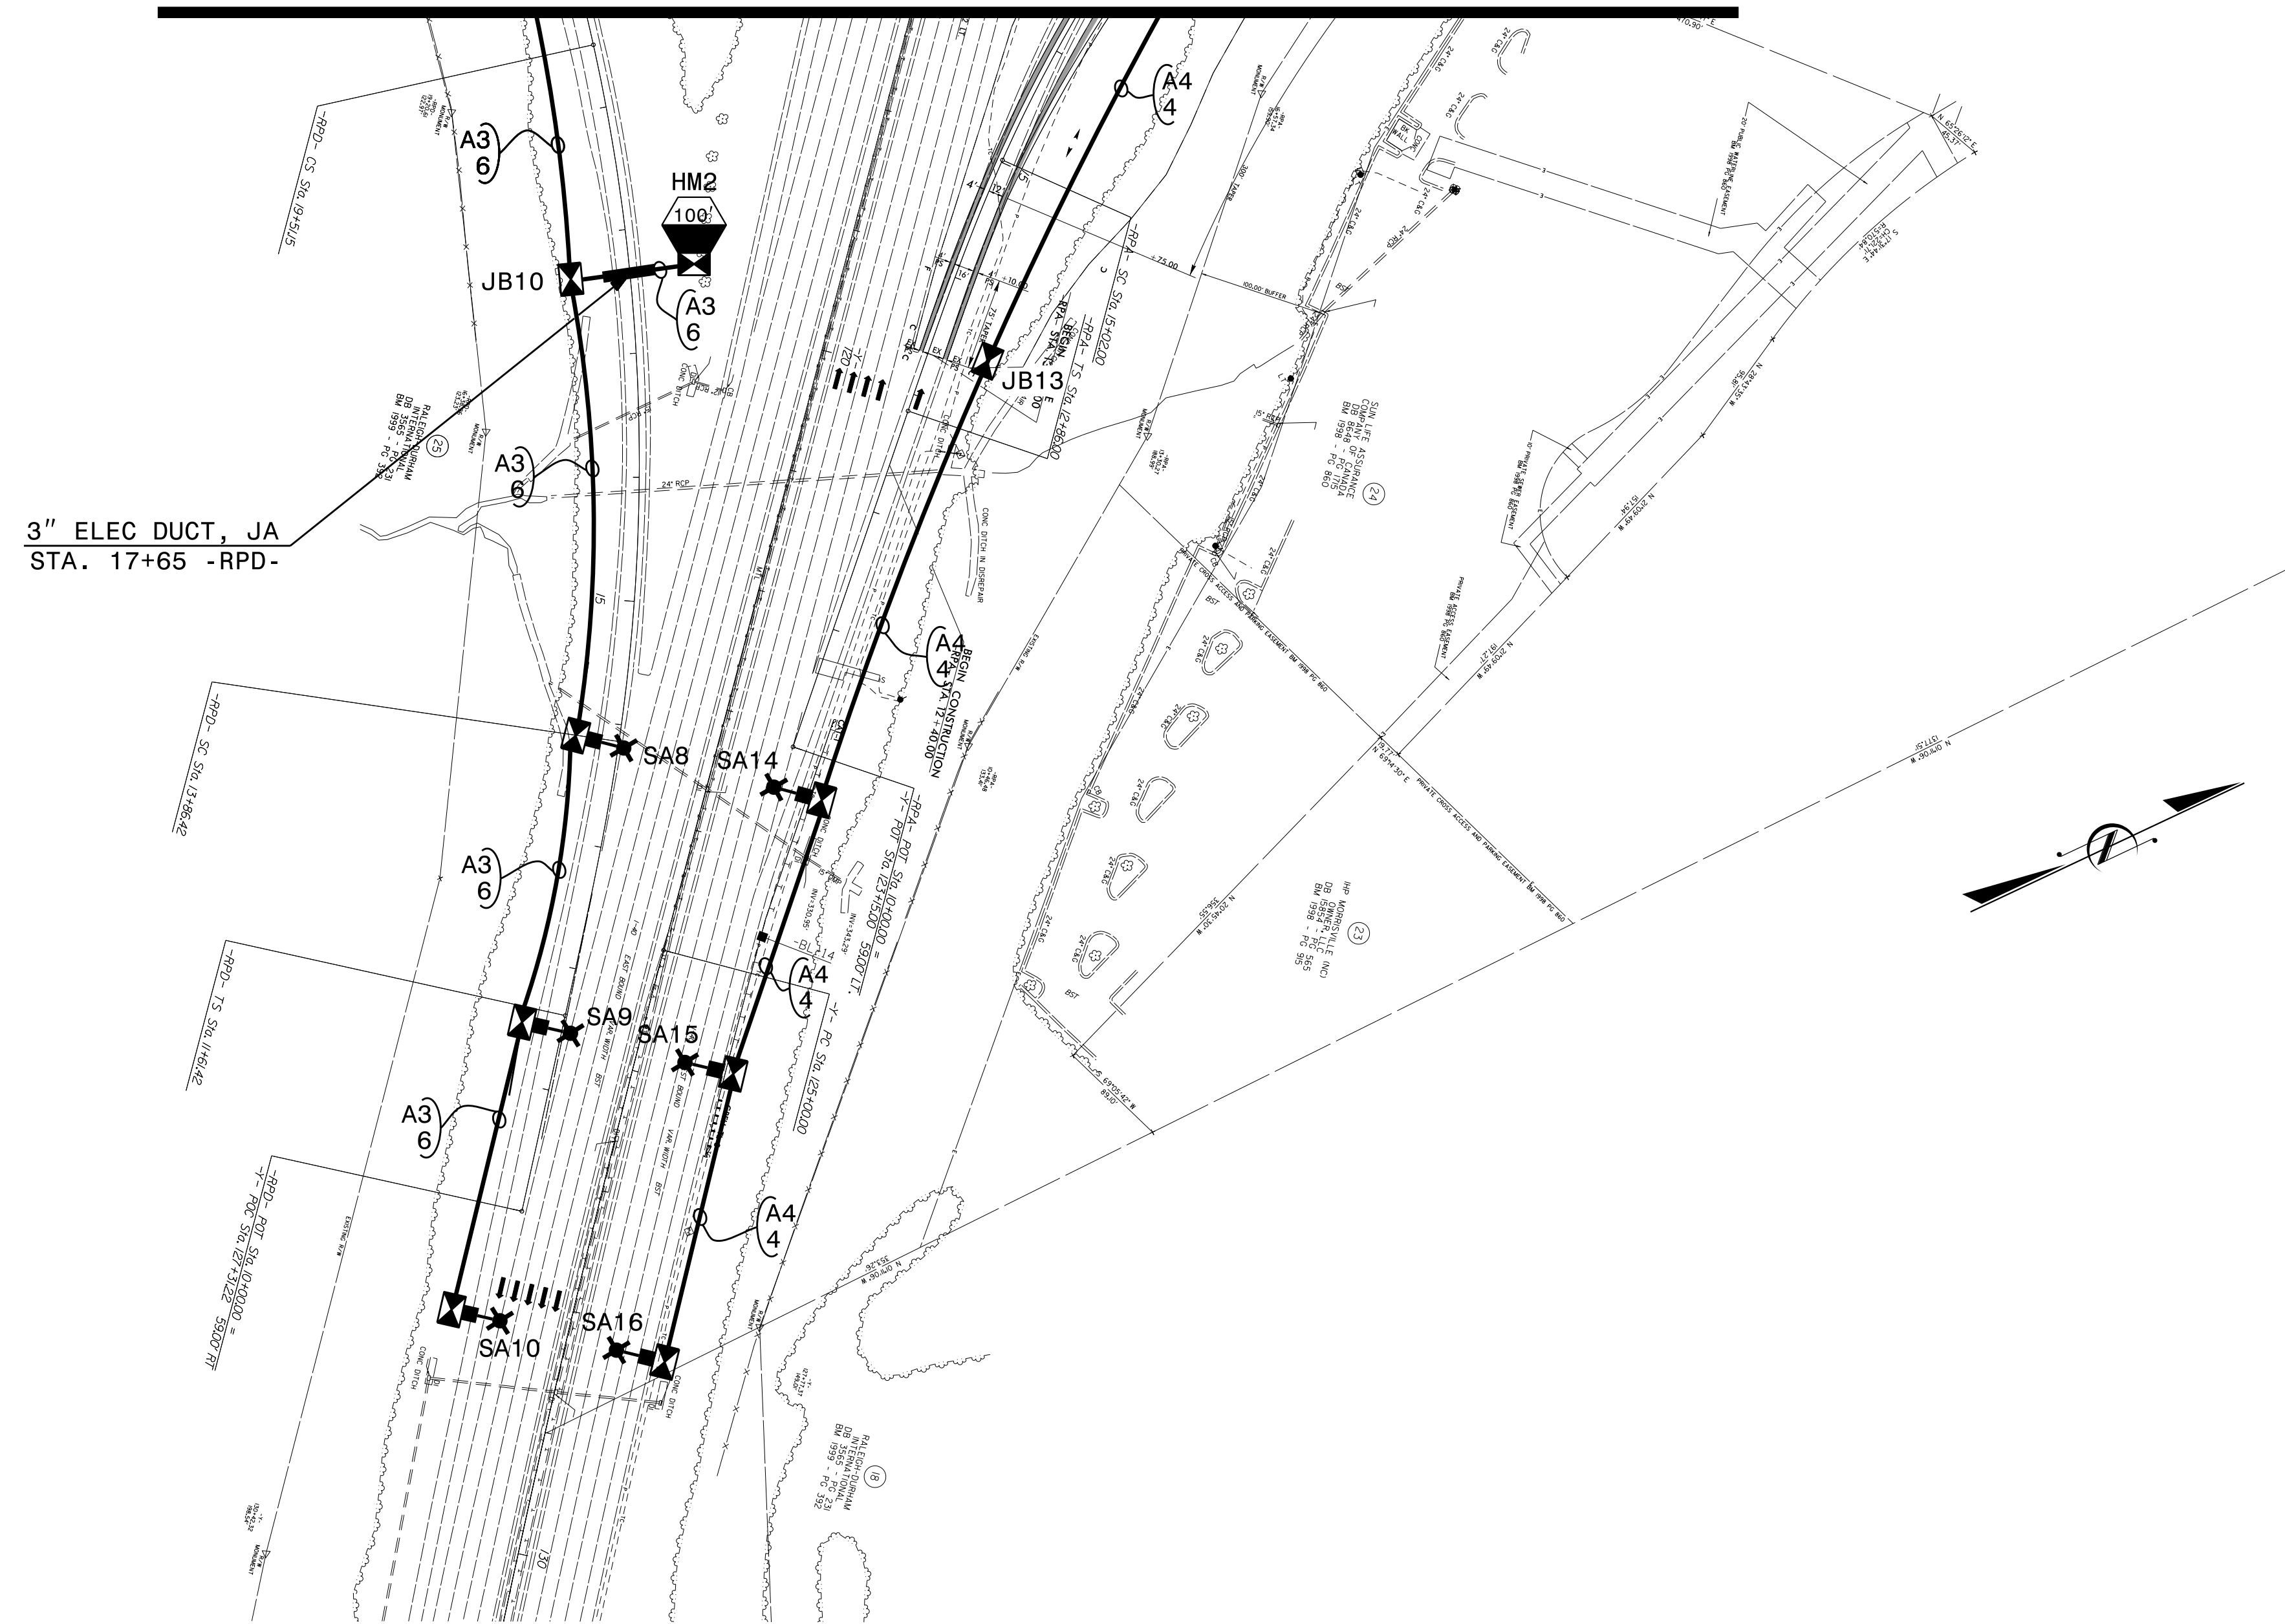

I7-NOV-2017 10:19
F:\Lighting\Lighting Design\I5506.l&e.psh_E4.dgn
labrown AT 02-293515

2			
1			
Rev.	Date	Description	Approved
NORTH CAROLINA DEPARTMENT OF TRANSPORTATION ROADWAY DESIGN LIGHTING/ELECTRICAL SECTION LIGHTING LAYOUT I-40/AVIATION BLVD. INTERCHANGE WAKE COUNTY			
Drawn By:	AB	Approved By:	Dwg No.: