
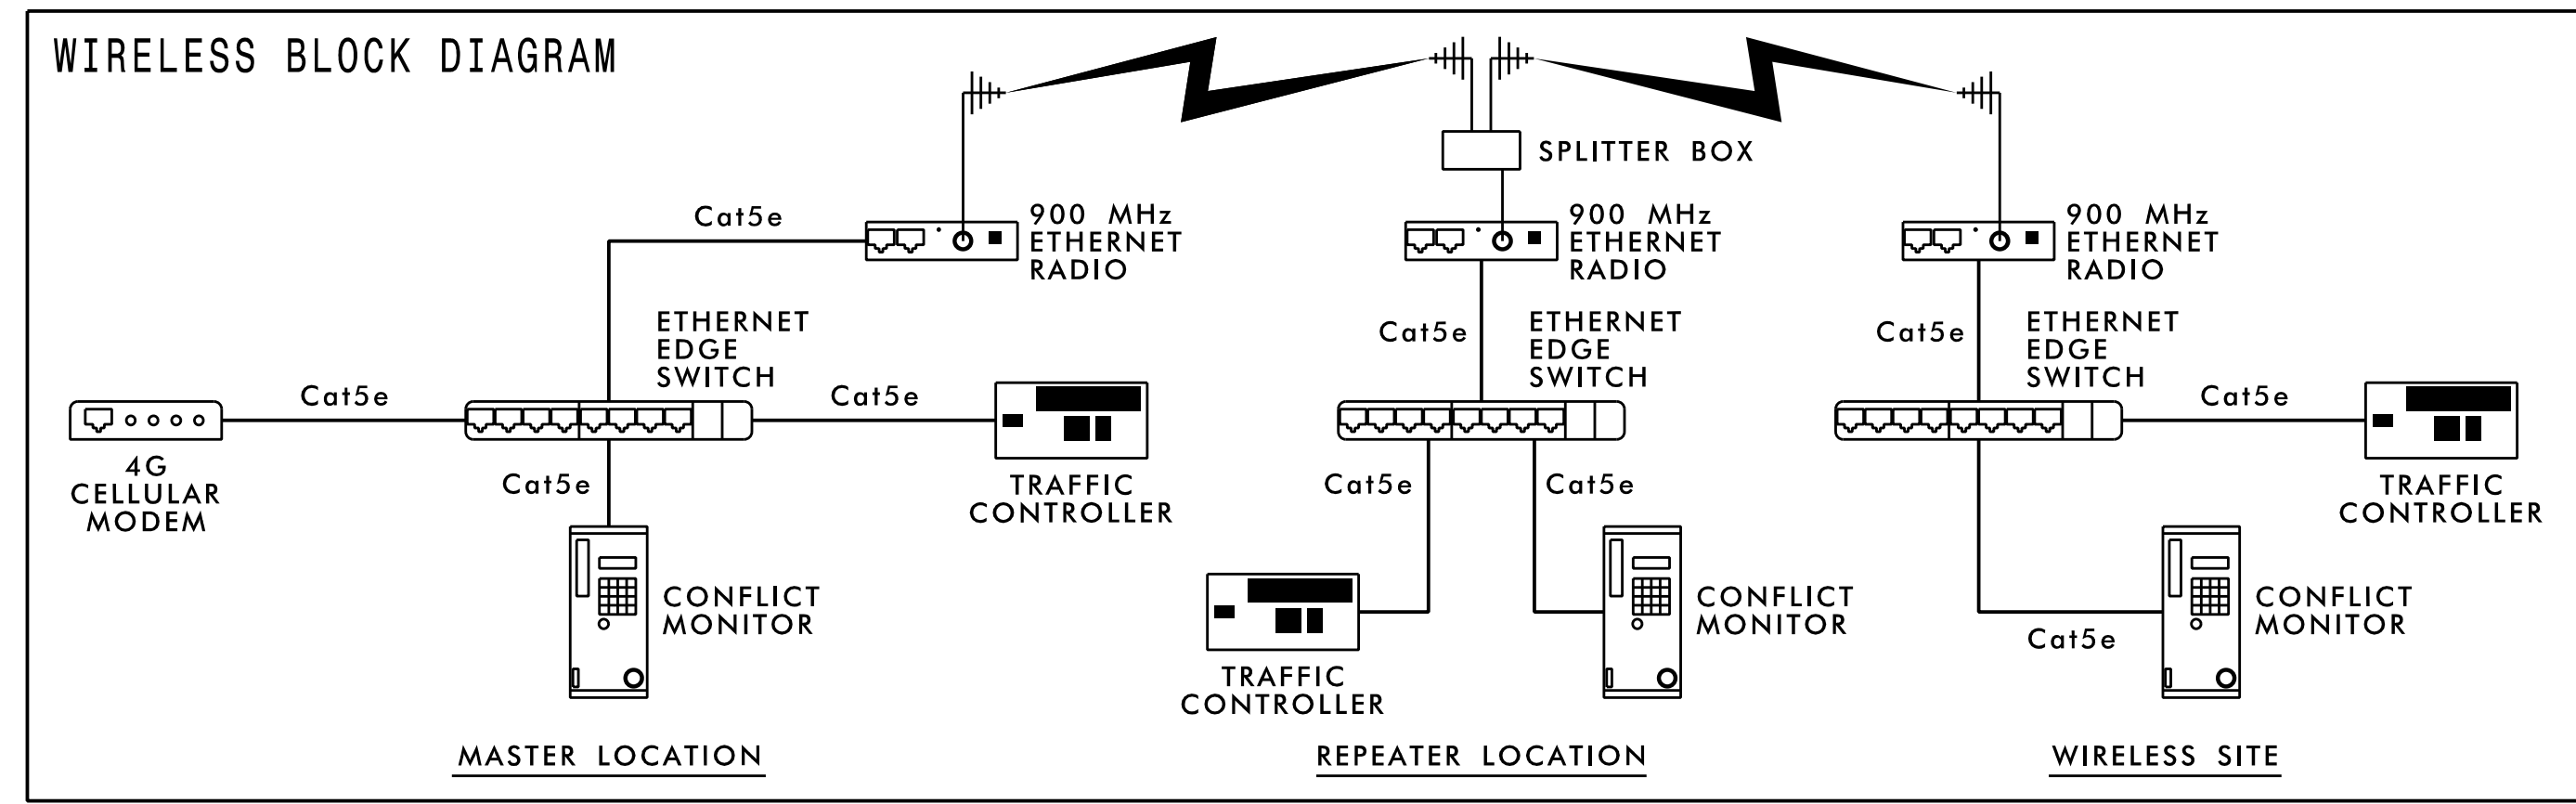
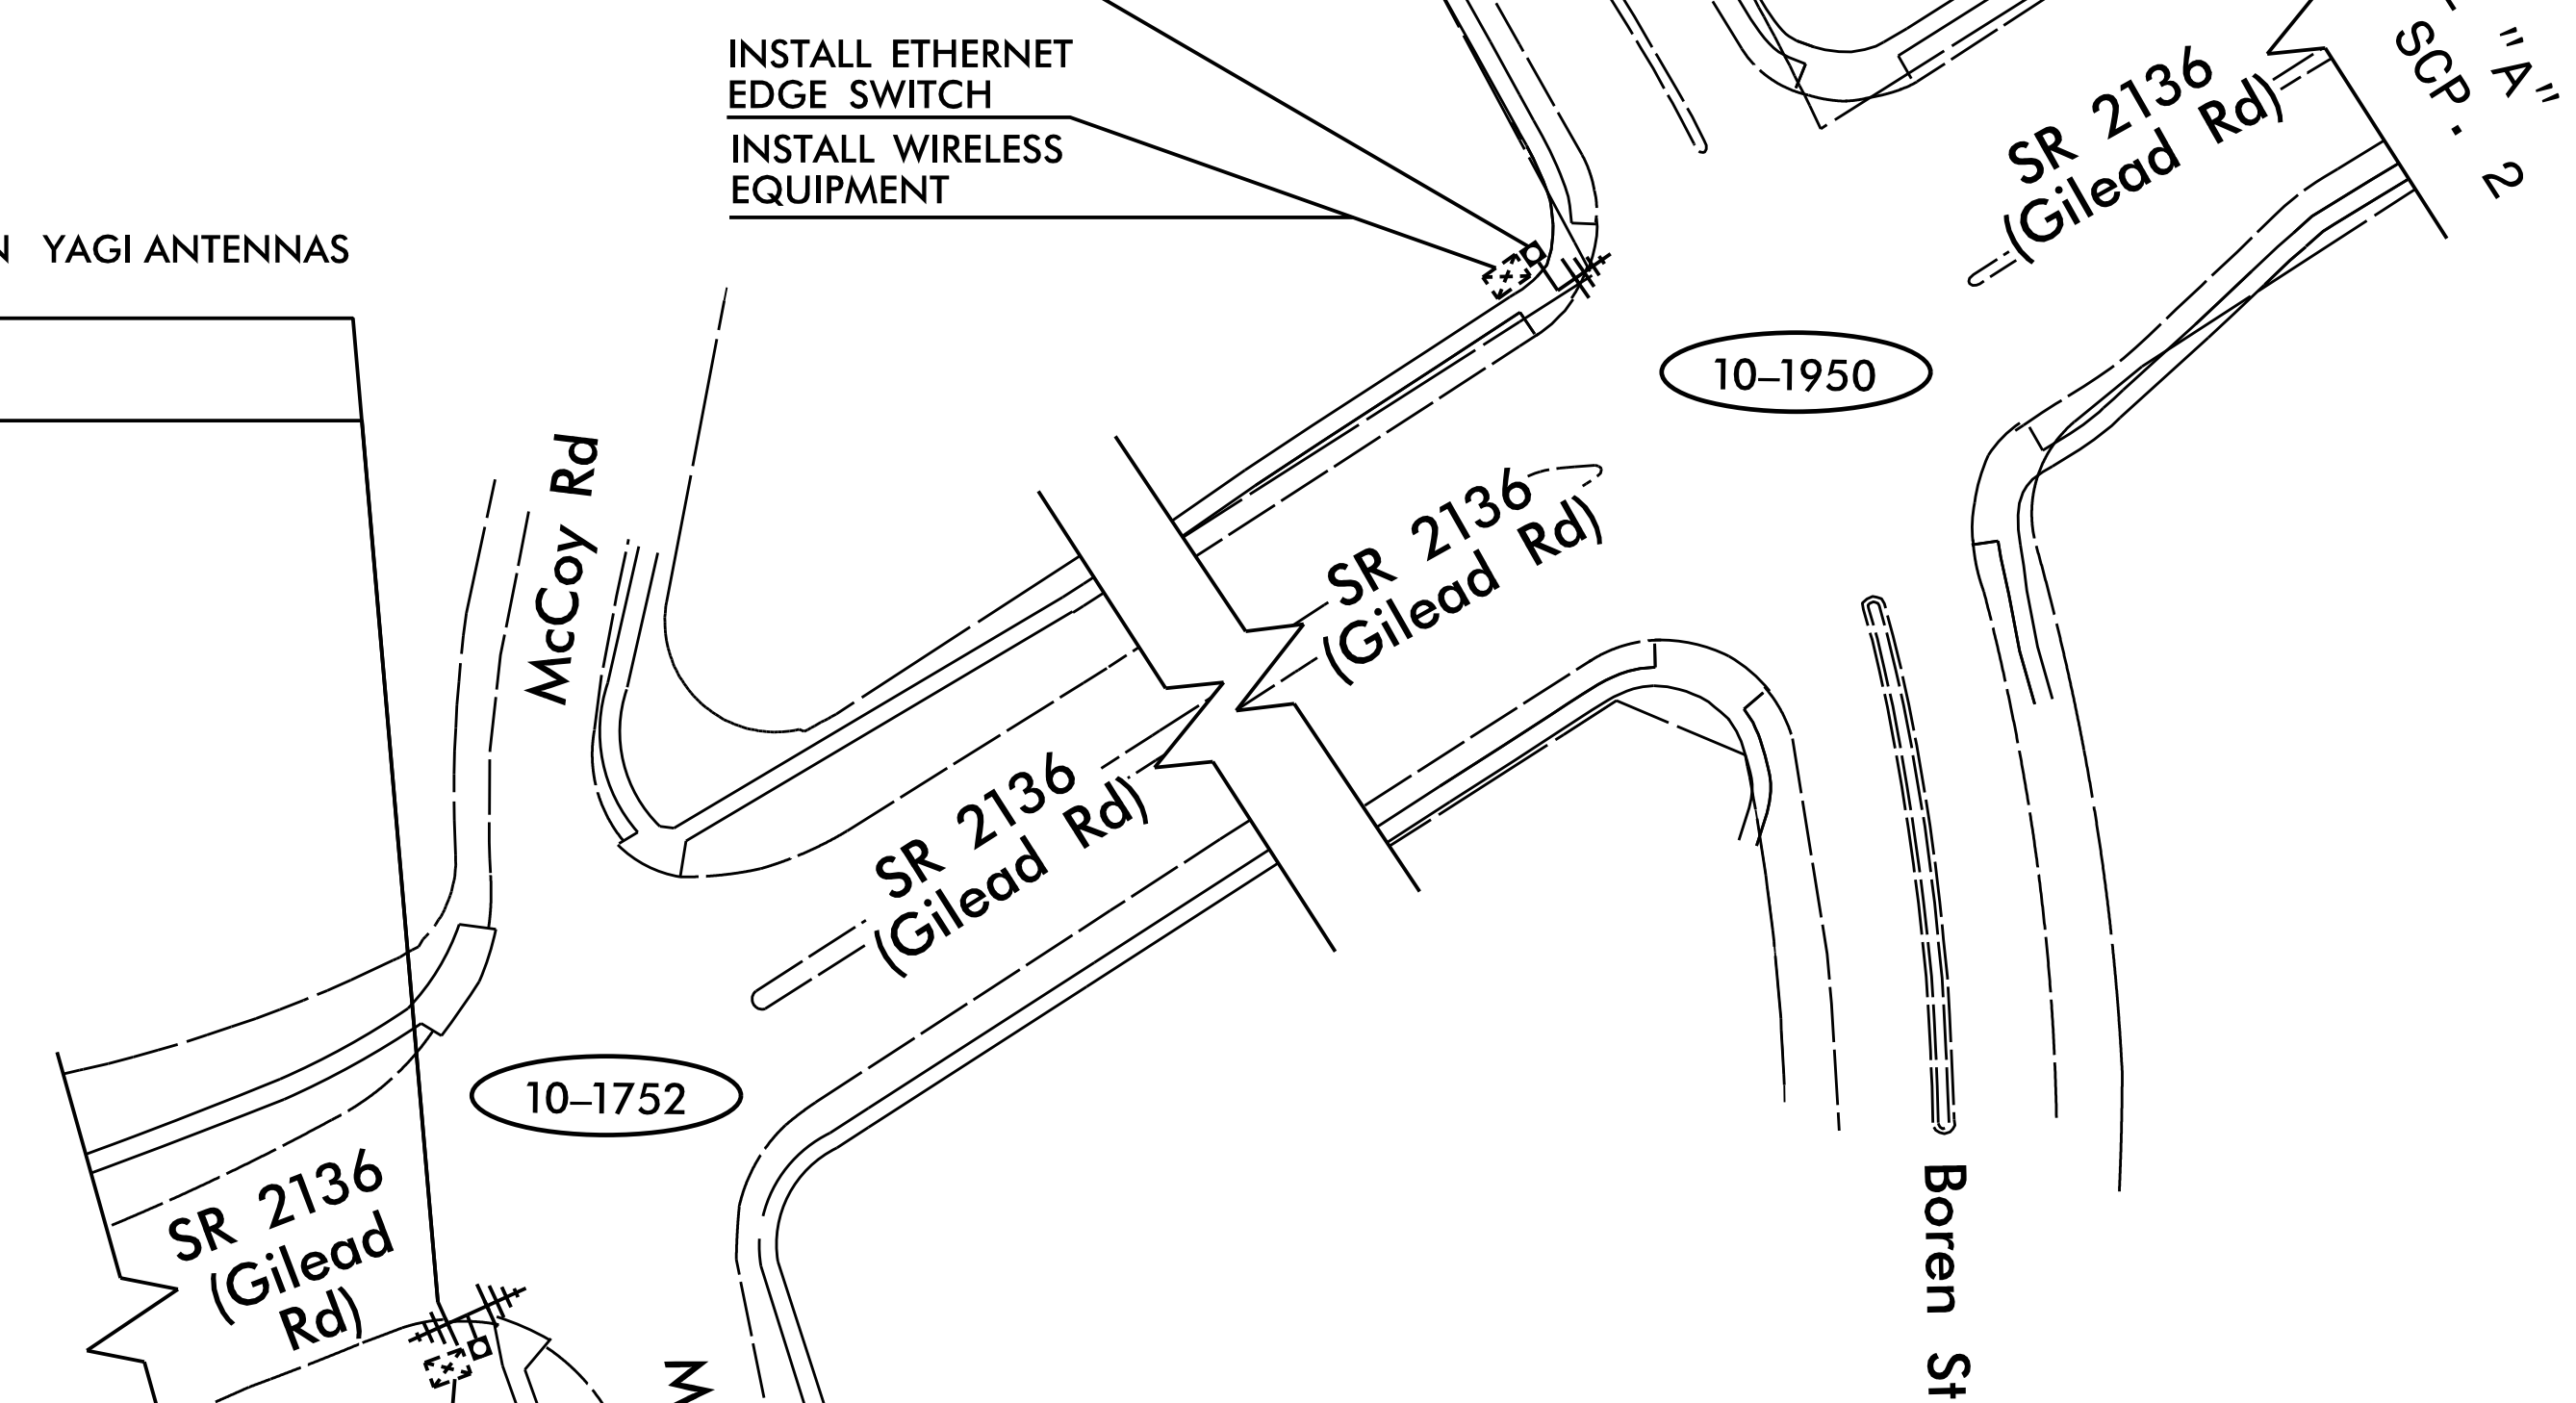


INSTALL 8.5 DB GAIN YAGI ANTENNA VERTICALLY POLARIZED
ATTACH ANTENNA 12" ABOVE SIGNAL CABLE

INSTALL 8.5 DB GAIN YAGI ANTENNA VERTICALLY POLARIZED
ATTACH ANTENNA 12" ABOVE FIBER OPTIC CABLE

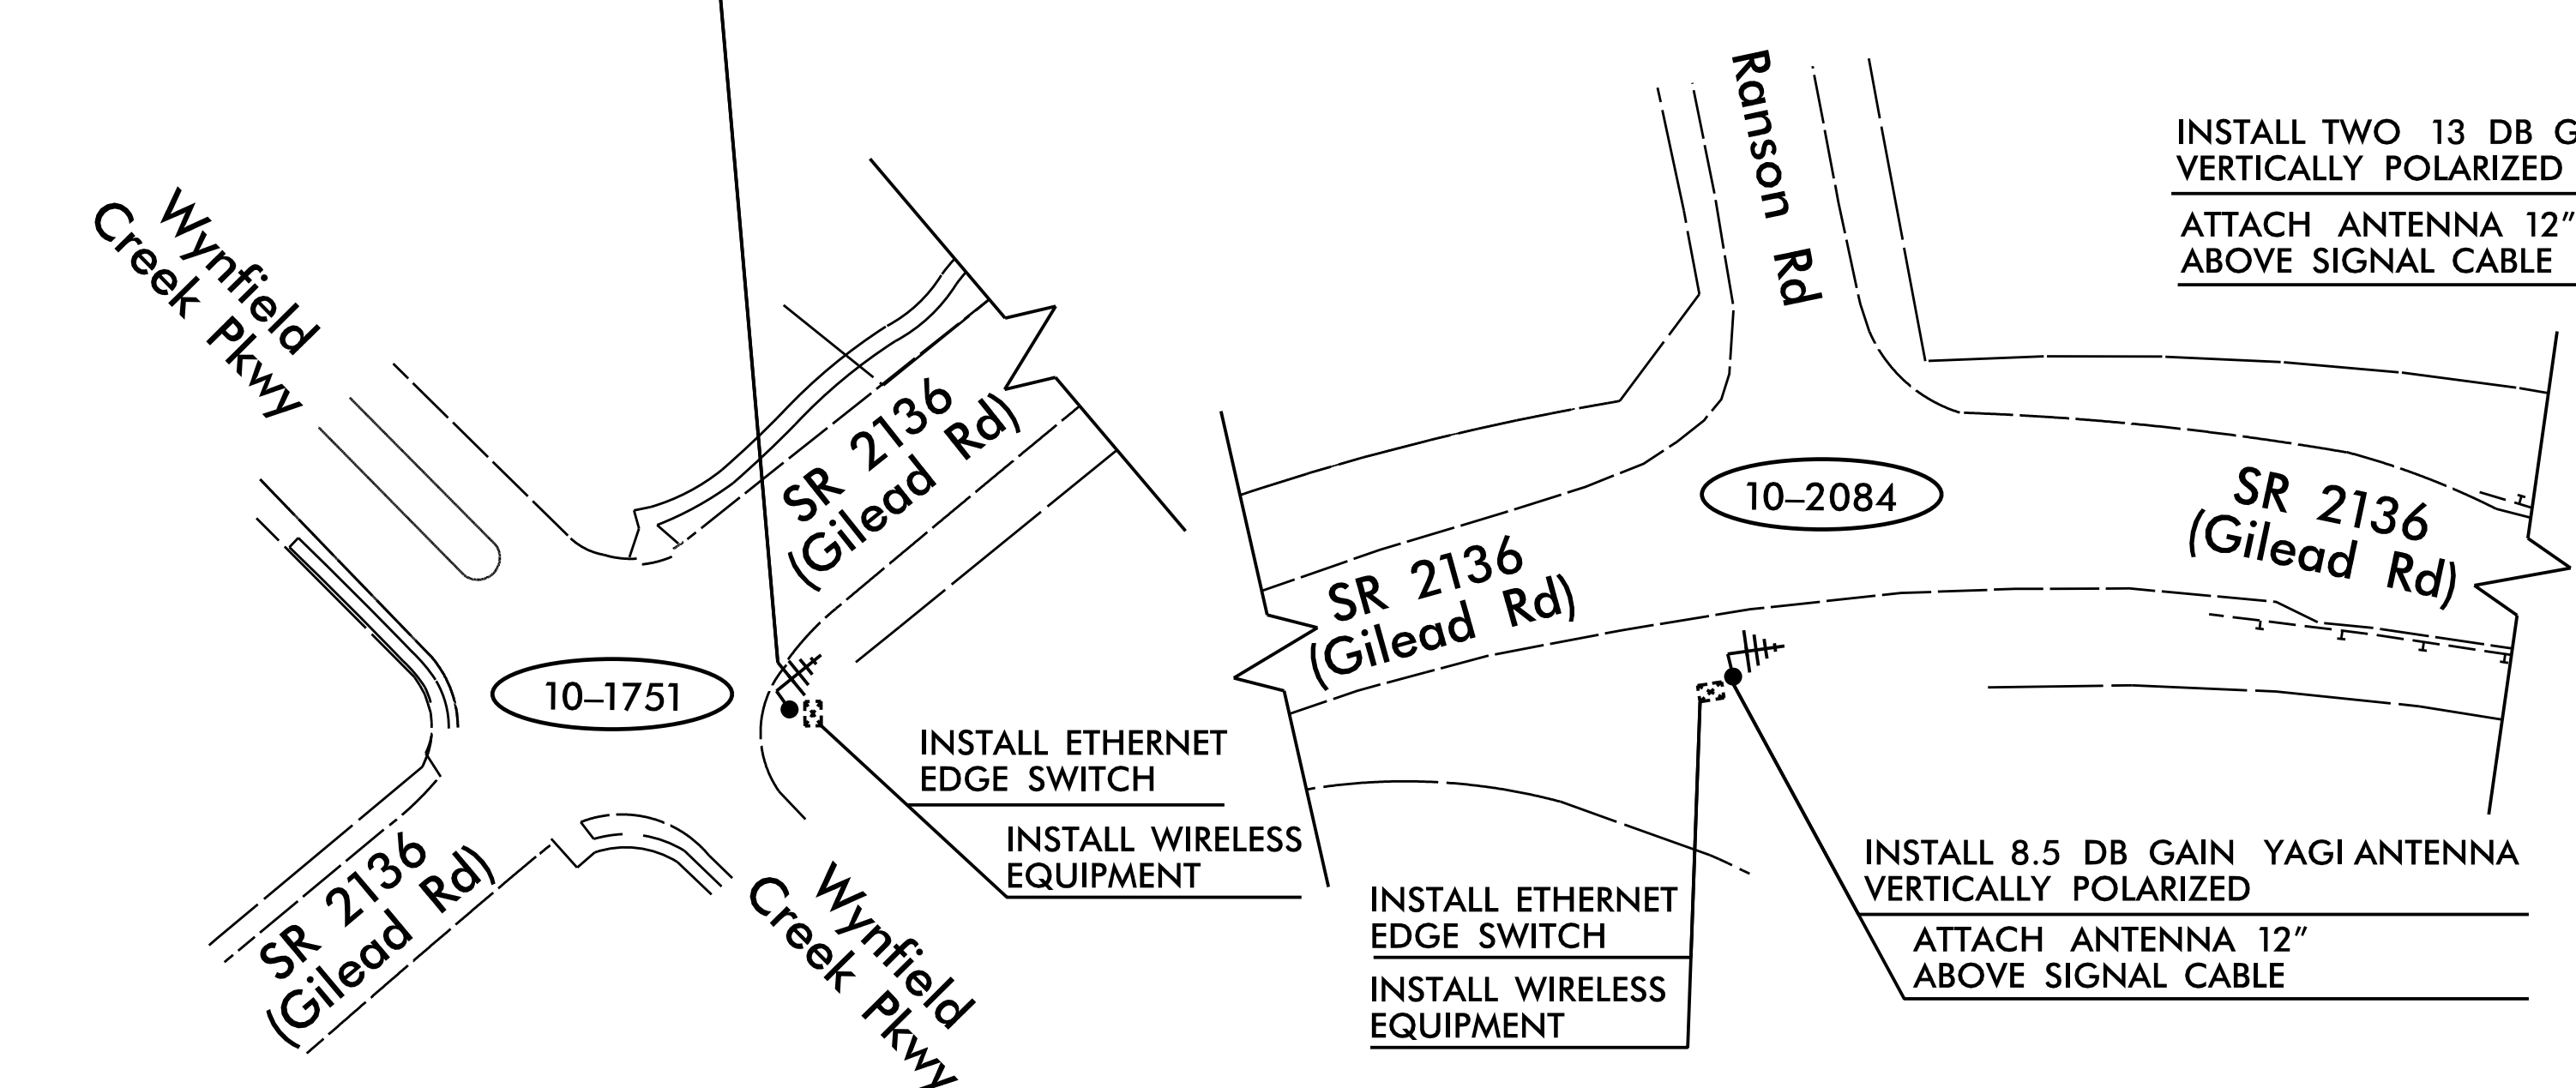

LEGEND

	YAGI ANTENNA (DOUBLE) FOR REPEATER OPERATION
	YAGI ANTENNA (SINGLE)
	NEW CONTROLLER AND CABINET
	NEW MASTER CONTROLLER AND CABINET
	EXISTING CONTROLLER AND CABINET
	SIGNAL INVENTORY NUMBER
	NEW METAL POLE W/MAST ARM
	EXISTING METAL POLE W/MAST ARM
	NEW METAL STRAIN POLE
	EXISTING METAL STRAIN POLE
	NEW WOOD POLE
	EXISTING WOOD POLE

- NOTES FOR EXISTING COMMUNICATIONS CABLE:**
- REMOVE ALL EXISTING COMMUNICATIONS CABLE FROM INSIDE THE CONTROLLER CABINET AND THE RISER ASSEMBLY. LEAVE RISER ASSEMBLY IN PLACE.
- NOTES FOR WIRELESS COMMUNICATIONS:**
- INSTALL COAXIAL CABLE:
 - ON WOOD POLES, REQUIRING A NEW RIGID GALVANIZED STEEL RISER, INSTALL A 2" RISER WITH WEATHERHEAD AND ROUTE THE COAXIAL CABLE TO THE ANTENNA.
 - ON METAL POLES WITH MAST ARMS, RUN COAXIAL CABLE UP THROUGH THE POLE AND OUT THE MAST ARM; FIELD DRILL A 1/2" HOLE UP THROUGH THE BOTTOM OF MAST ARM FOR INSTALLATION OF THE COAXIAL CABLE TO THE ANTENNA.
 - ON METAL STRAIN POLES, RUN COAXIAL CABLE UP THROUGH THE POLE AND OUT THE WEATHERHEAD AND ROUTE THE COAXIAL CABLE TO THE ANTENNA.
 - BETWEEN THE POINT OF EXITING THE RISER, METAL POLE, OR MAST ARM AND THE ANTENNA, SECURE THE COAXIAL CABLE TO THE STRUCTURE USING 3/4" STAINLESS STEEL STRAPS EVERY 12".
 - IF AN EXISTING 2" SPARE RIGID GALVANIZED STEEL RISER IS AVAILABLE, INSTALL THE COAXIAL CABLE IN THE SPARE RISER.
 - INSTALL WIRELESS ANTENNA ON POLE WITH RF WARNING SIGN.
(NOTE: RF WARNING SIGN NOT REQUIRED WHEN ANTENNA IS INSTALLED ON AN NCDOT-OWNED POLE.)
 - MAINTAIN PROPER CLEARANCE FROM ALL UTILITIES PER THE NATIONAL ELECTRICAL SAFETY CODE.
 - REFERENCE "WIRELESS RADIO ANTENNA TYPICAL DETAILS" IN THE 2018 NCDOT ROADWAY STANDARD DRAWINGS.
 - RETURN EXISTING WIRELESS RADIO EQUIPMENT TO THE DIVISION 10 SIGNAL SHOP. THE DIVISION 10 OFFICE CAN BE REACHED AT 704-983-4400.
 - FIVE (5) DAYS PRIOR TO BEGINNING WORK ON THE SIGNAL SYSTEM, CONTACT THE DIVISION 10 DEPUTY TRAFFIC ENGINEER, LAURA JEAN, AT (704) 983-4400 TO ARRANGE FOR THE DIVISION TO PROGRAM THE NEW FIELD ETHERNET SWITCHES WITH THE NECESSARY NETWORK CONFIGURATION DATA, INCLUDING BUT NOT LIMITED TO: THE PROJECT IP ADDRESS, DEFAULT GATEWAY, SUBNET MASK AND VLAN ID INFORMATION. NOTIFY THE DEPUTY TRAFFIC ENGINEER AFTER ALL WORK IS PERFORMED TO ENSURE THAT ALL FIBER CIRCUITS ARE FUNCTIONING PROPERLY. WORK IS NOT COMPLETE UNTIL THE SIGNAL SYSTEM IS BACK UP AND FUNCTIONAL.

HNTB
HNTB NORTH CAROLINA, P.C.
343 E. Six Forks Road, Suite 200
Raleigh, North Carolina 27609
NC License No: C-1554
(919) 546-8997

TEMPORARY PLAN 1

DOCUMENT NOT CONSIDERED FINAL UNLESS ALL SIGNATURES COMPLETED

	SR 2136 (GILEAD RD) WIRELESS COMMUNICATIONS PLANS		
	Division 10 Mecklenburg Co. Huntersville	PLAN DATE: December 2017 REVIEWED BY: T.R. Terrell	
250 N. Greenfield Place, Garner, NC 27529		SCALE: 0 50 1" = 50'	DocuSigned by: Natasha R. Simmons/23/2018 PREPARED BY SIGNATURE DATE CADD File name: I5714_U5114_SCP-1.dgn