

09/08/99

STATE OF NORTH CAROLINA
DIVISION OF HIGHWAYS


ROBESON COUNTY

LOCATION: I-74 FROM NC 710 (MILE MARKER 199.9)
TO EAST OF NC 41 (MILE MARKER 215)

TYPE OF WORK: PAVEMENT REHABILITATION

STATE	STATE PROJECT REFERENCE NO.	SHEET NO.	TOTAL SHEETS
N.C.	I-5938B	1	
STATE PROJ. NO.	F.A. PROJ. NO.	DESCRIPTION	
45881.1.1	NHPIM-0074(206)	P.E.	
45881.3.1	NHPIM-0074(206)	CONSTR	

BEGIN TIP PROJECT I-5938B
MILE MARKER 199.9

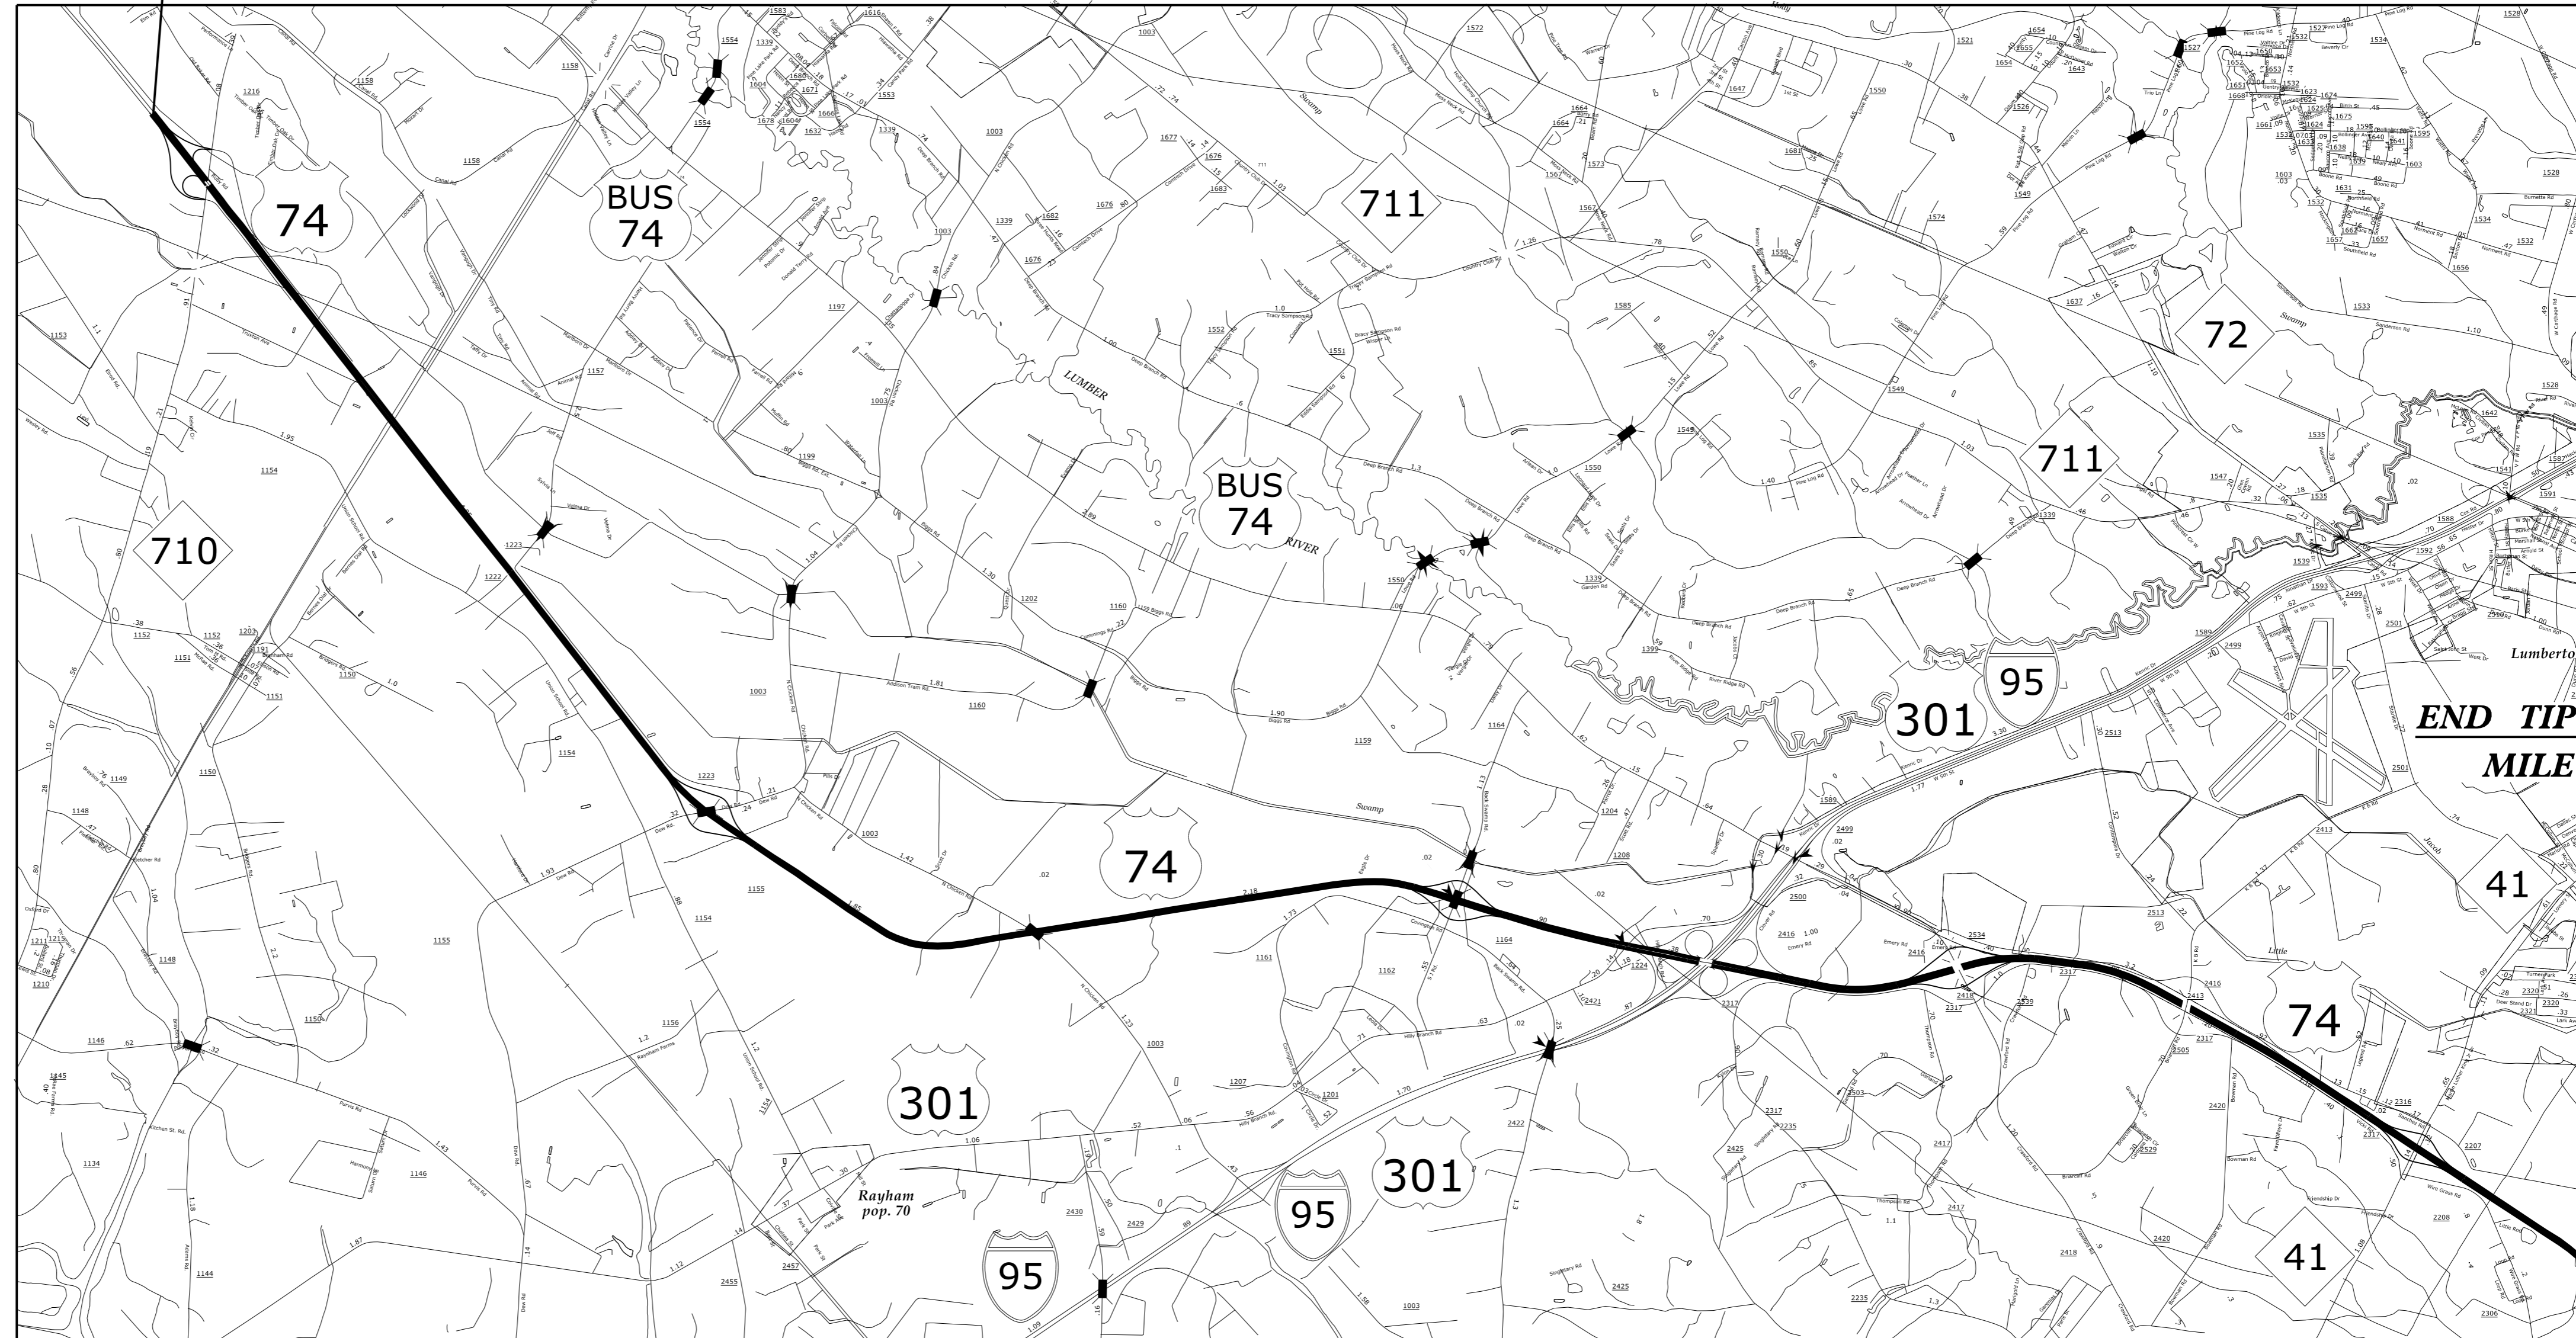

END TIP PROJECT I-5938B
MILE MARKER 215

TIP PROJECT: I-5938B

CONTRACT:

DESIGN DATA
ADT 2016 = 11,000
ADT 2036 = 20,000

PROJECT LENGTH


TOTAL PROJECT LENGTH = 15.1 mi

Prepared in the Office of:
DIVISION OF HIGHWAYS
1000 Birch Ridge Dr., Raleigh NC, 27610

2018 STANDARD SPECIFICATIONS

RIGHT OF WAY DATE:
NA

LETTING DATE:
OCTOBER 16, 2018

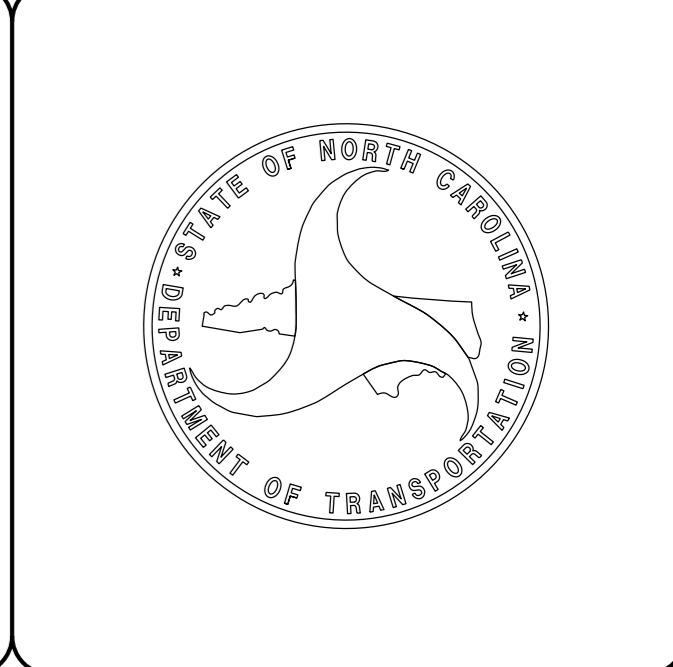

07-AUG-2018 15:07
H:\DDC\Projects\I-5938B I-74 from NC 710 to NC 41-Pv+ Rehab\Submit\I-5938B_Rdy_Tsh.dgn
\$\$\$\$\$USERNAME\$\$\$\$\$