


VESSEL NAME: 45.5 FT SUPPORT TUG
 CONTRACT NO.:
 TIP NUMBER: F-5703B
 WBS NUMBER: 47256.3.2
 PROJECT: 45'-6" SUPPORT TUG

VESSEL PARTICULARS
 LENGTH OVERALL HULL 45'-6"
 BEAM - MOLDED 20'-0"
 DEPTH AT SIDE 6'-6"
 LIGHTSHIP DISPLACEMENT 51 LT
 FULL LOAD DISPLACEMENT 85 LT

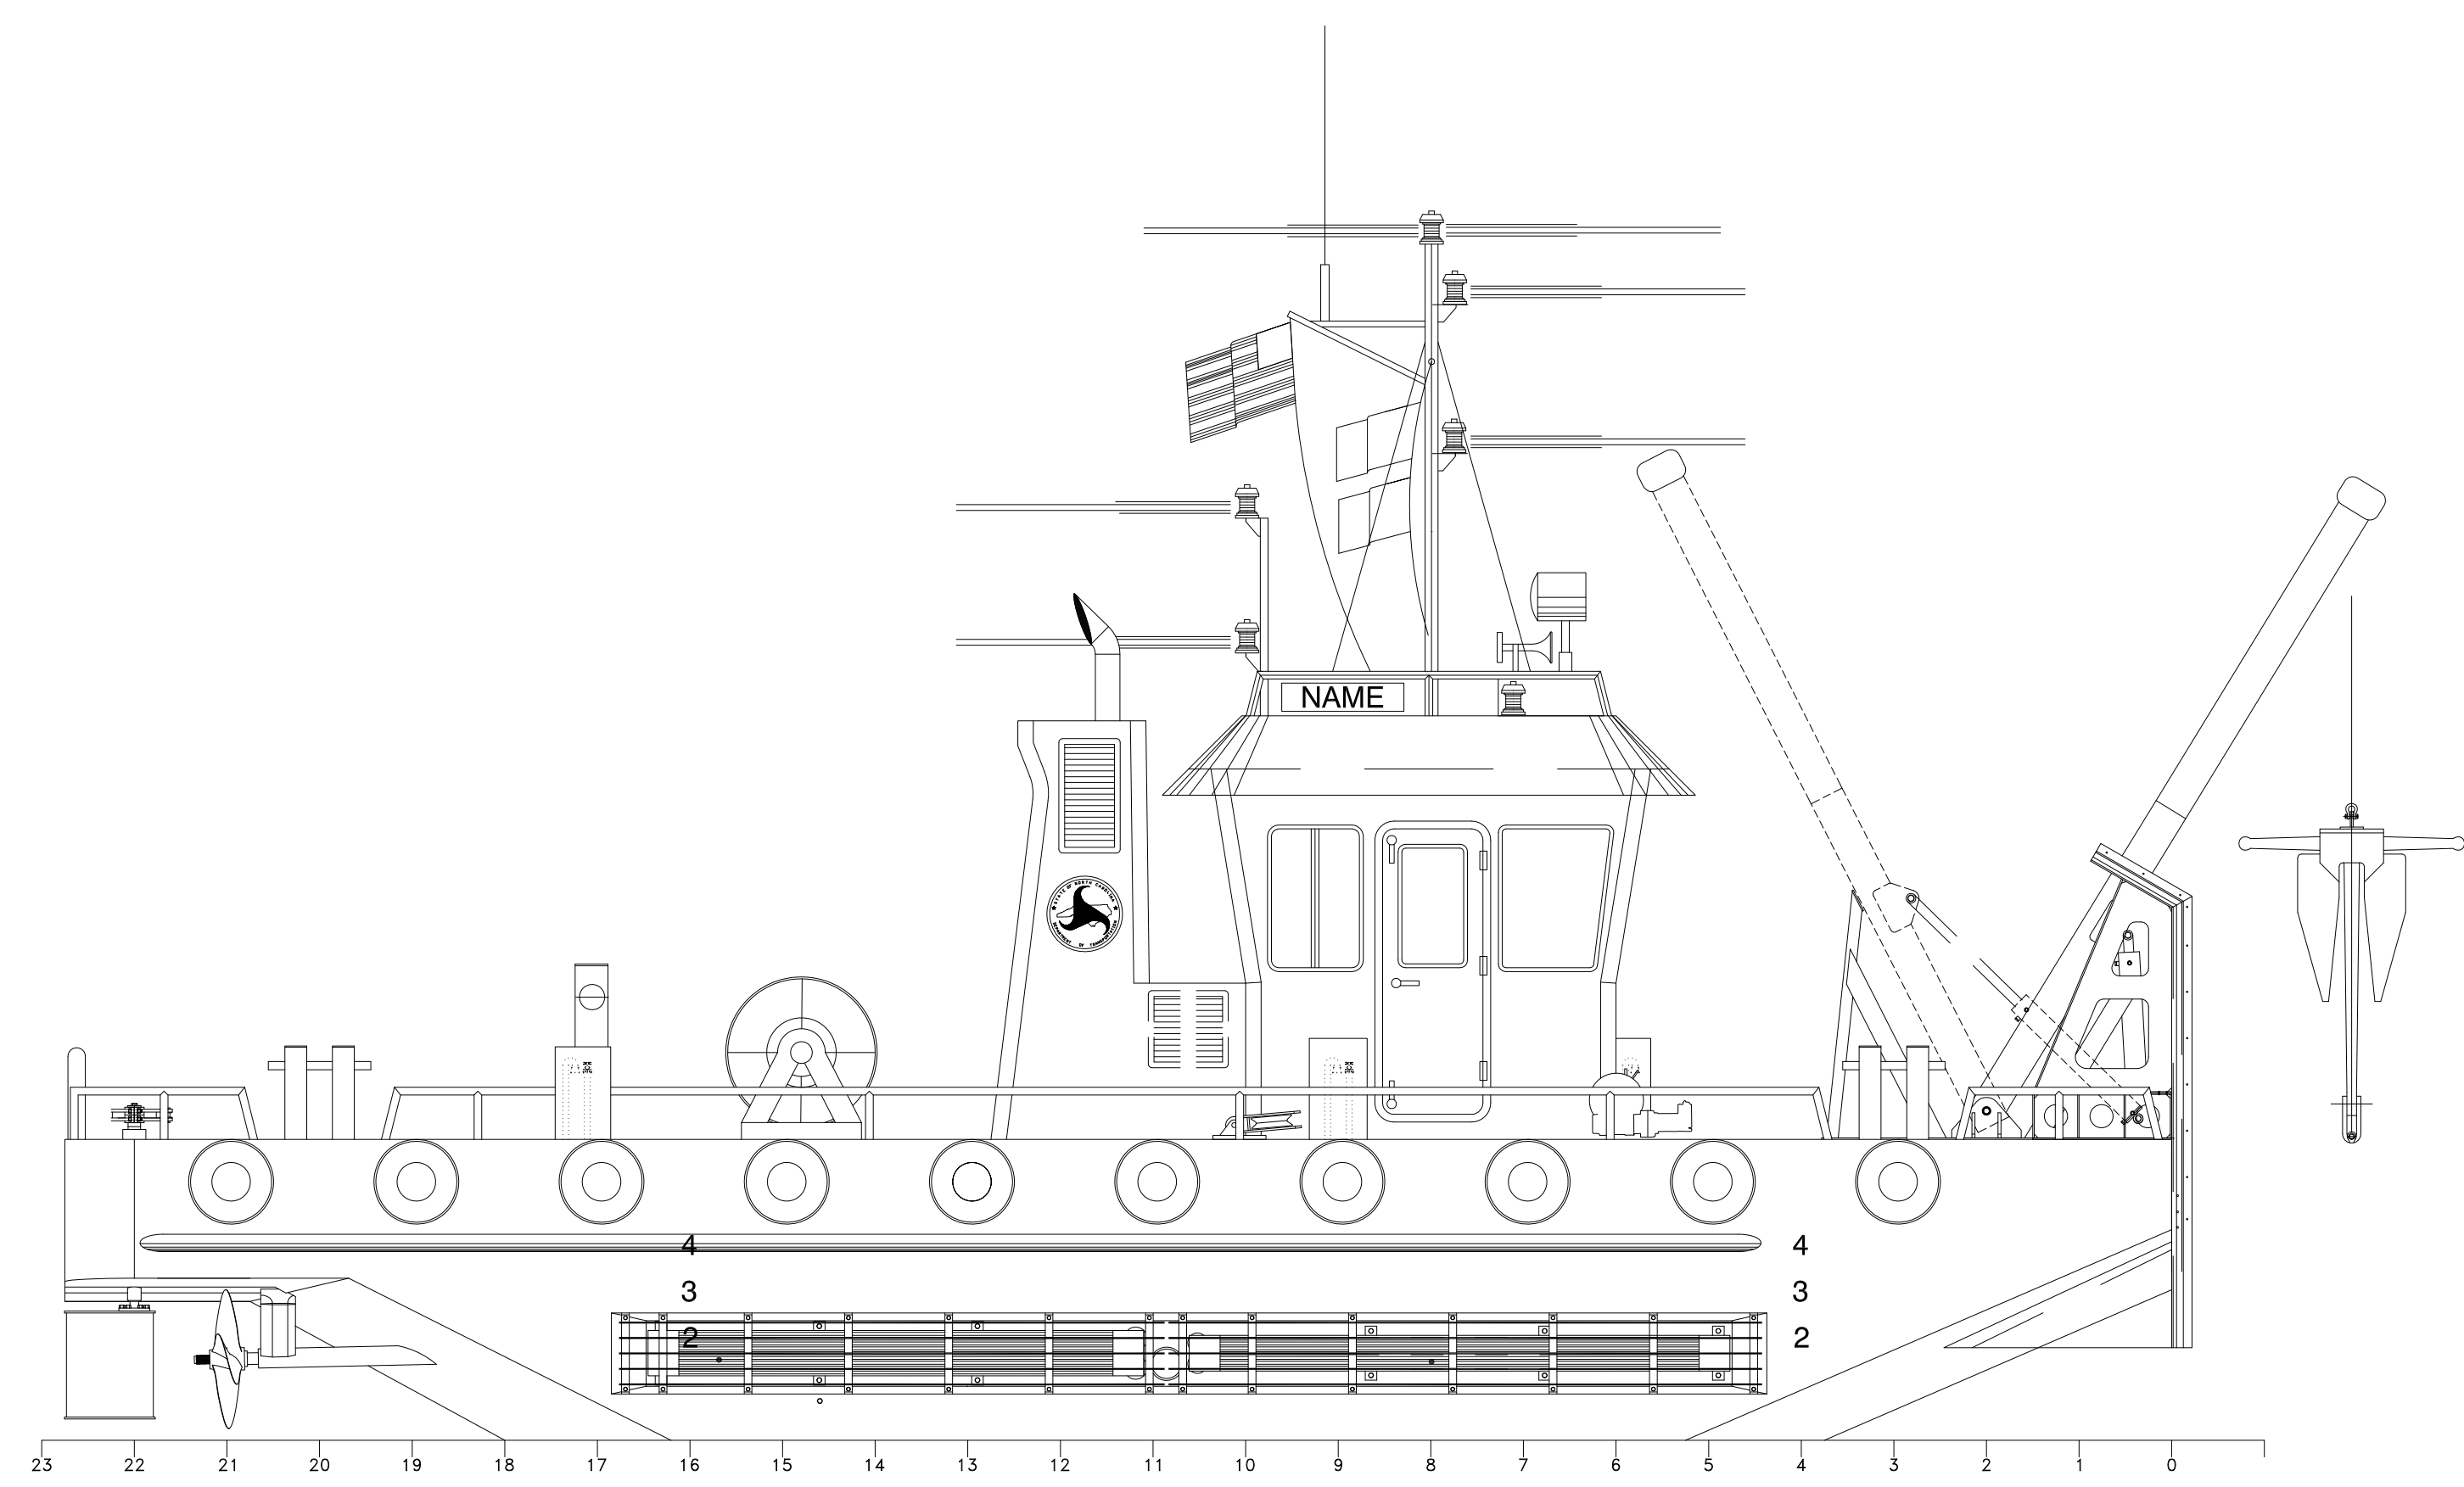

LIST OF DRAWINGS:

DRAWING NUMBER:	DRAWING TITLE:	DRAWING NUMBER:	DRAWING TITLE:
1. 1393-100	GENERAL ARRANGEMENTS	22. 1393-320	ELECTRICAL ONE-LINE DIAGRAM
2. 1393-100-3	OUTBOARD PROFILE	23. 1393-422	NAVIGATION LIGHTS DETAILS
3. 1393-101	LINESPLAN	24. 1393-423	ELECTRICAL WIRING DIAGRAM
4. 1393-110	BOTTOM & SIDESHELL STRUCTURAL DETAILS	25. 1393-506	VENTS & FILLS DETAILS
5. 1393-117	TRANSVERSE FRAME STRUCTURAL DETAILS	26. 1393-625	WINDOWS & DOORS SCHEDULE
6. 1393-120	LONGITUDINAL SECTIONS	27. 1393-680	SAFETY PLAN
7. 1393-130	MAIN DECK STRUCTURAL DETAILS	28. 1393-684	PUSH KNEE & FENDERING DETAILS
8. 1393-152	PILOTHOUSE & STACK STRUCTURAL DETAILS	29. 1393-685	DECK CAPSTAN & HAWSER REEL DETAILS
9. 1393-167	HATCHES & MANHOLES SCHEDULE		
10. 1393-171	MAST DETAILS		
11. 1393-182	SHAFTING PLAN		
12. 1393-185	A-FRAME DETAILS		
13. 1393-200	MACHINERY ARRANGEMENTS		
14. 1393-201	MAIN DECK OUTFITTING		
15. 1393-253	STEERING SYSTEM DETAILS		
16. 1393-255	COOLING SYSTEM DETAILS		
17. 1393-259	ENGINE EXHAUST DETAILS		
18. 1393-261	FUEL OIL PIPING DETAILS		
19. 1393-263	BILGE, BALLAST & FIRE PIPING DETAILS		
20. 1393-264	SHAFT FLUSHING PIPING DETAILS		
21. 1393-265	HYDRAULIC SYSTEM DETAILS		



PROSPECTIVE RIGHTS

This document discloses matter in which DeJong & Lebet, Incorporated has proprietary rights. Neither receipt nor possession thereof confers or transfers any right to reproduce, disclose or use in any manner this document in whole or in part or any information contained herein, except by written permission, or unless agreed upon with DeJong & Lebet, Incorporated.

In the event of a purchase of this document the purchaser is authorized to construct no more than one device in accord herewith, unless otherwise signed to in writing by DeJong & Lebet, Incorporated.

© 2018 by DeJong & Lebet, Inc.

DeJong & Lebet, Inc.
 Naval Architects
 Marine Engineers
 Consultants
 Surveyors

1734 Emerson Street
 Jacksonville, Florida 32207
 www.dejongandlebet.com

Phone: (904) 599-3673
 Fax: (904) 599-1522
 info@dejongandlebet.com

Title: 45.5'x20'x6.5' NCDOT TOWBOAT

COVER PAGE

Dwg. No. 17-1393-001 Alt. No. 0 Sht. 1 of 1

Drawn By: JACOB CONNALLY Date: DECEMBER 31, 2018
 Checked By: Date:
 App'd By: Scale: NONE
 ABS App'r: USCG App'r: