
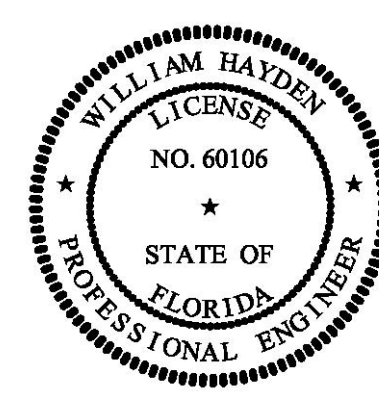
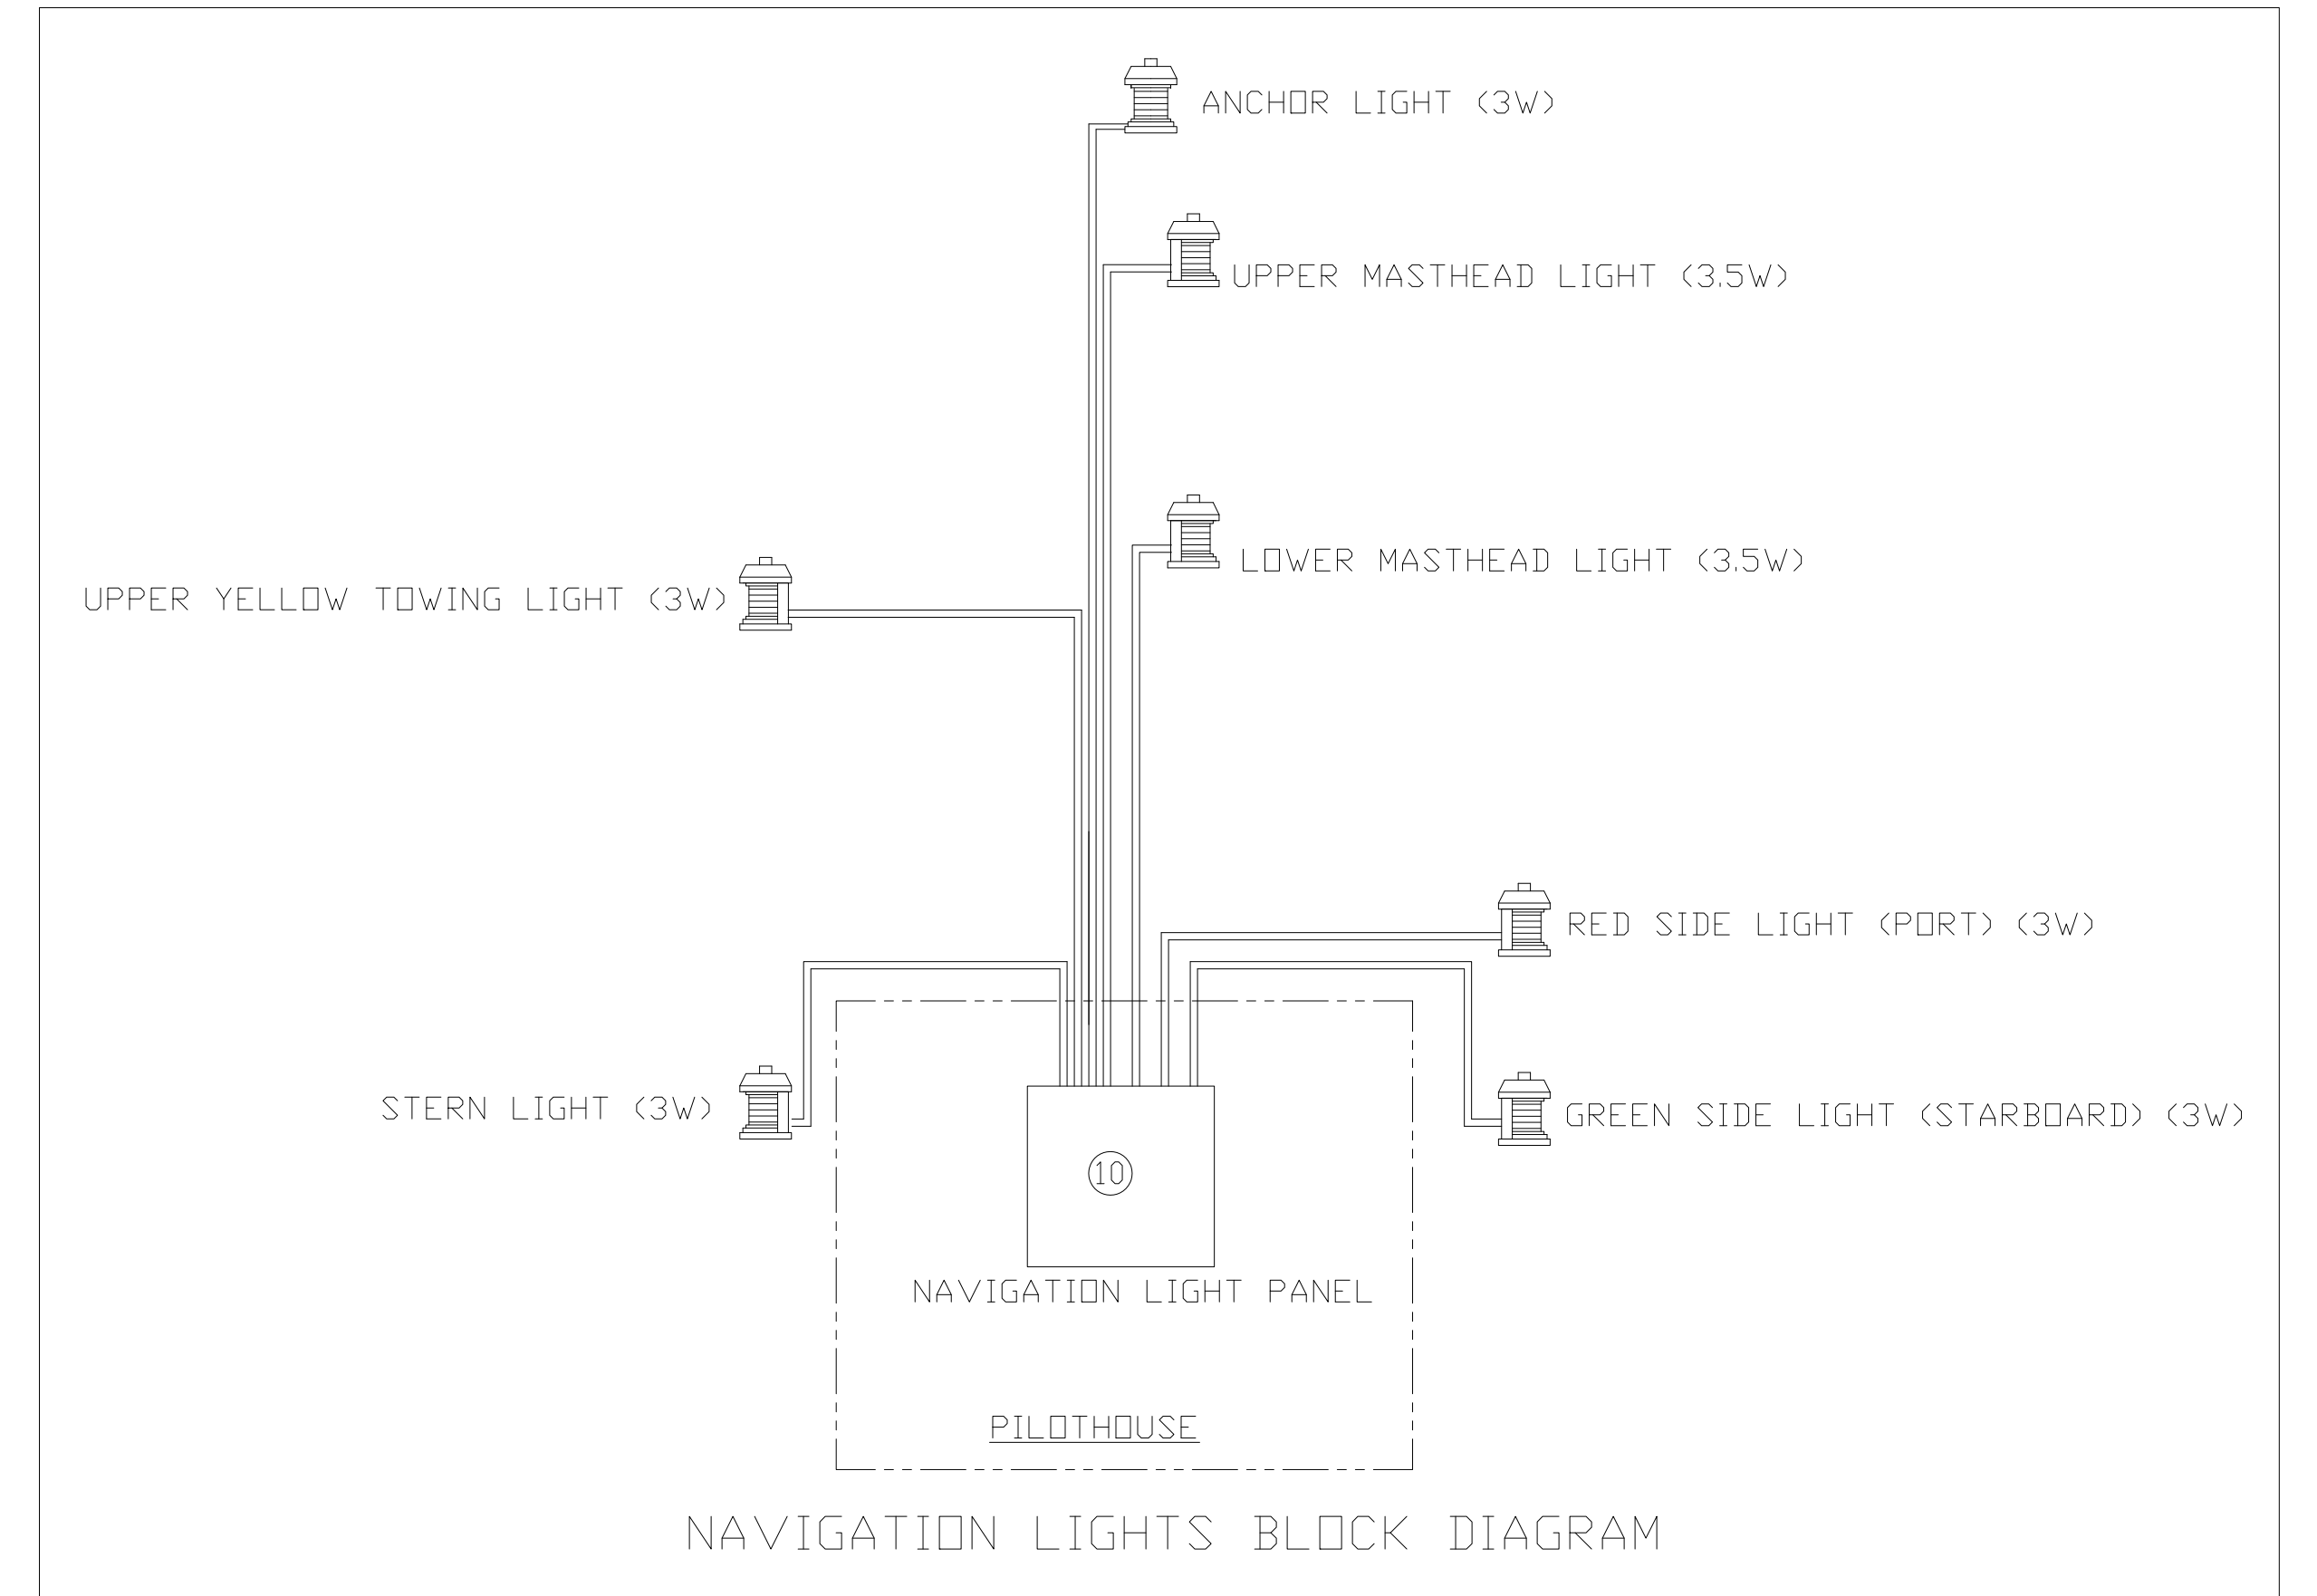


BILL OF MATERIALS						
LIGHTING FIXTURE SCHEDULE						
ITEM	QTY.	DESCRIPTION	MANUFACTURER #	ARC	VISIBILITY	REMARKS
1	1	ANCHOR LIGHT - WHT ALL AROUND	PERKO 0210SWBDP1	360°	2 MILES	OR EQUAL
2	1	UPPER MASTHEAD LIGHT, LED	PERKO 0210MBDDP1	225°	3 MILES	OR EQUAL
3	1	LOWER MASTHEAD LIGHT, LED	PERKO 0210MBDDP1	225°	3 MILES	OR EQUAL
4	1	GREEN SIDE LIGHT, LED	PERKO 0210SDBDP1	112.5°	2 MILES	OR EQUAL
5	1	RED SIDE LIGHT, LED	PERKO 0210PDBDP1	112.5°	2 MILES	OR EQUAL
6	1	YELLOW TOWING LIGHTS, SINGLE LENS ,LED	PERKO 0210PDBDP1	135°	2 MILES	OR EQUAL
7	1	WHITE STERN LIGHT, LED	PERKO 0210SNBDP1	135°	2 MILES	OR EQUAL
8	1	SEARCHLIGHT, 8", 12 VOLT, SEALED BEAM CHROME PLATED, LEVER CONTROL	PERKO 0314C0812V			
9	2	FLOODLIGHT, LED, 1000 LUMEN	LUMITEC 101334			OR EQUAL
10	1	NAVIGATION LIGHT PANEL, 7 SINGLE LAMP CIRCUITS	J-BOX NLFM7S24VDC-PFA			OR EQUAL
11	1	HORN LIGHT - WHT ALL AROUND	PERKO 0210SWBDP1	360°	2 MILES	OR EQUAL
12	1	FREEZE WARNING LT - BLUE ALL AROUND	-	360°	2 MILES	24 VDC

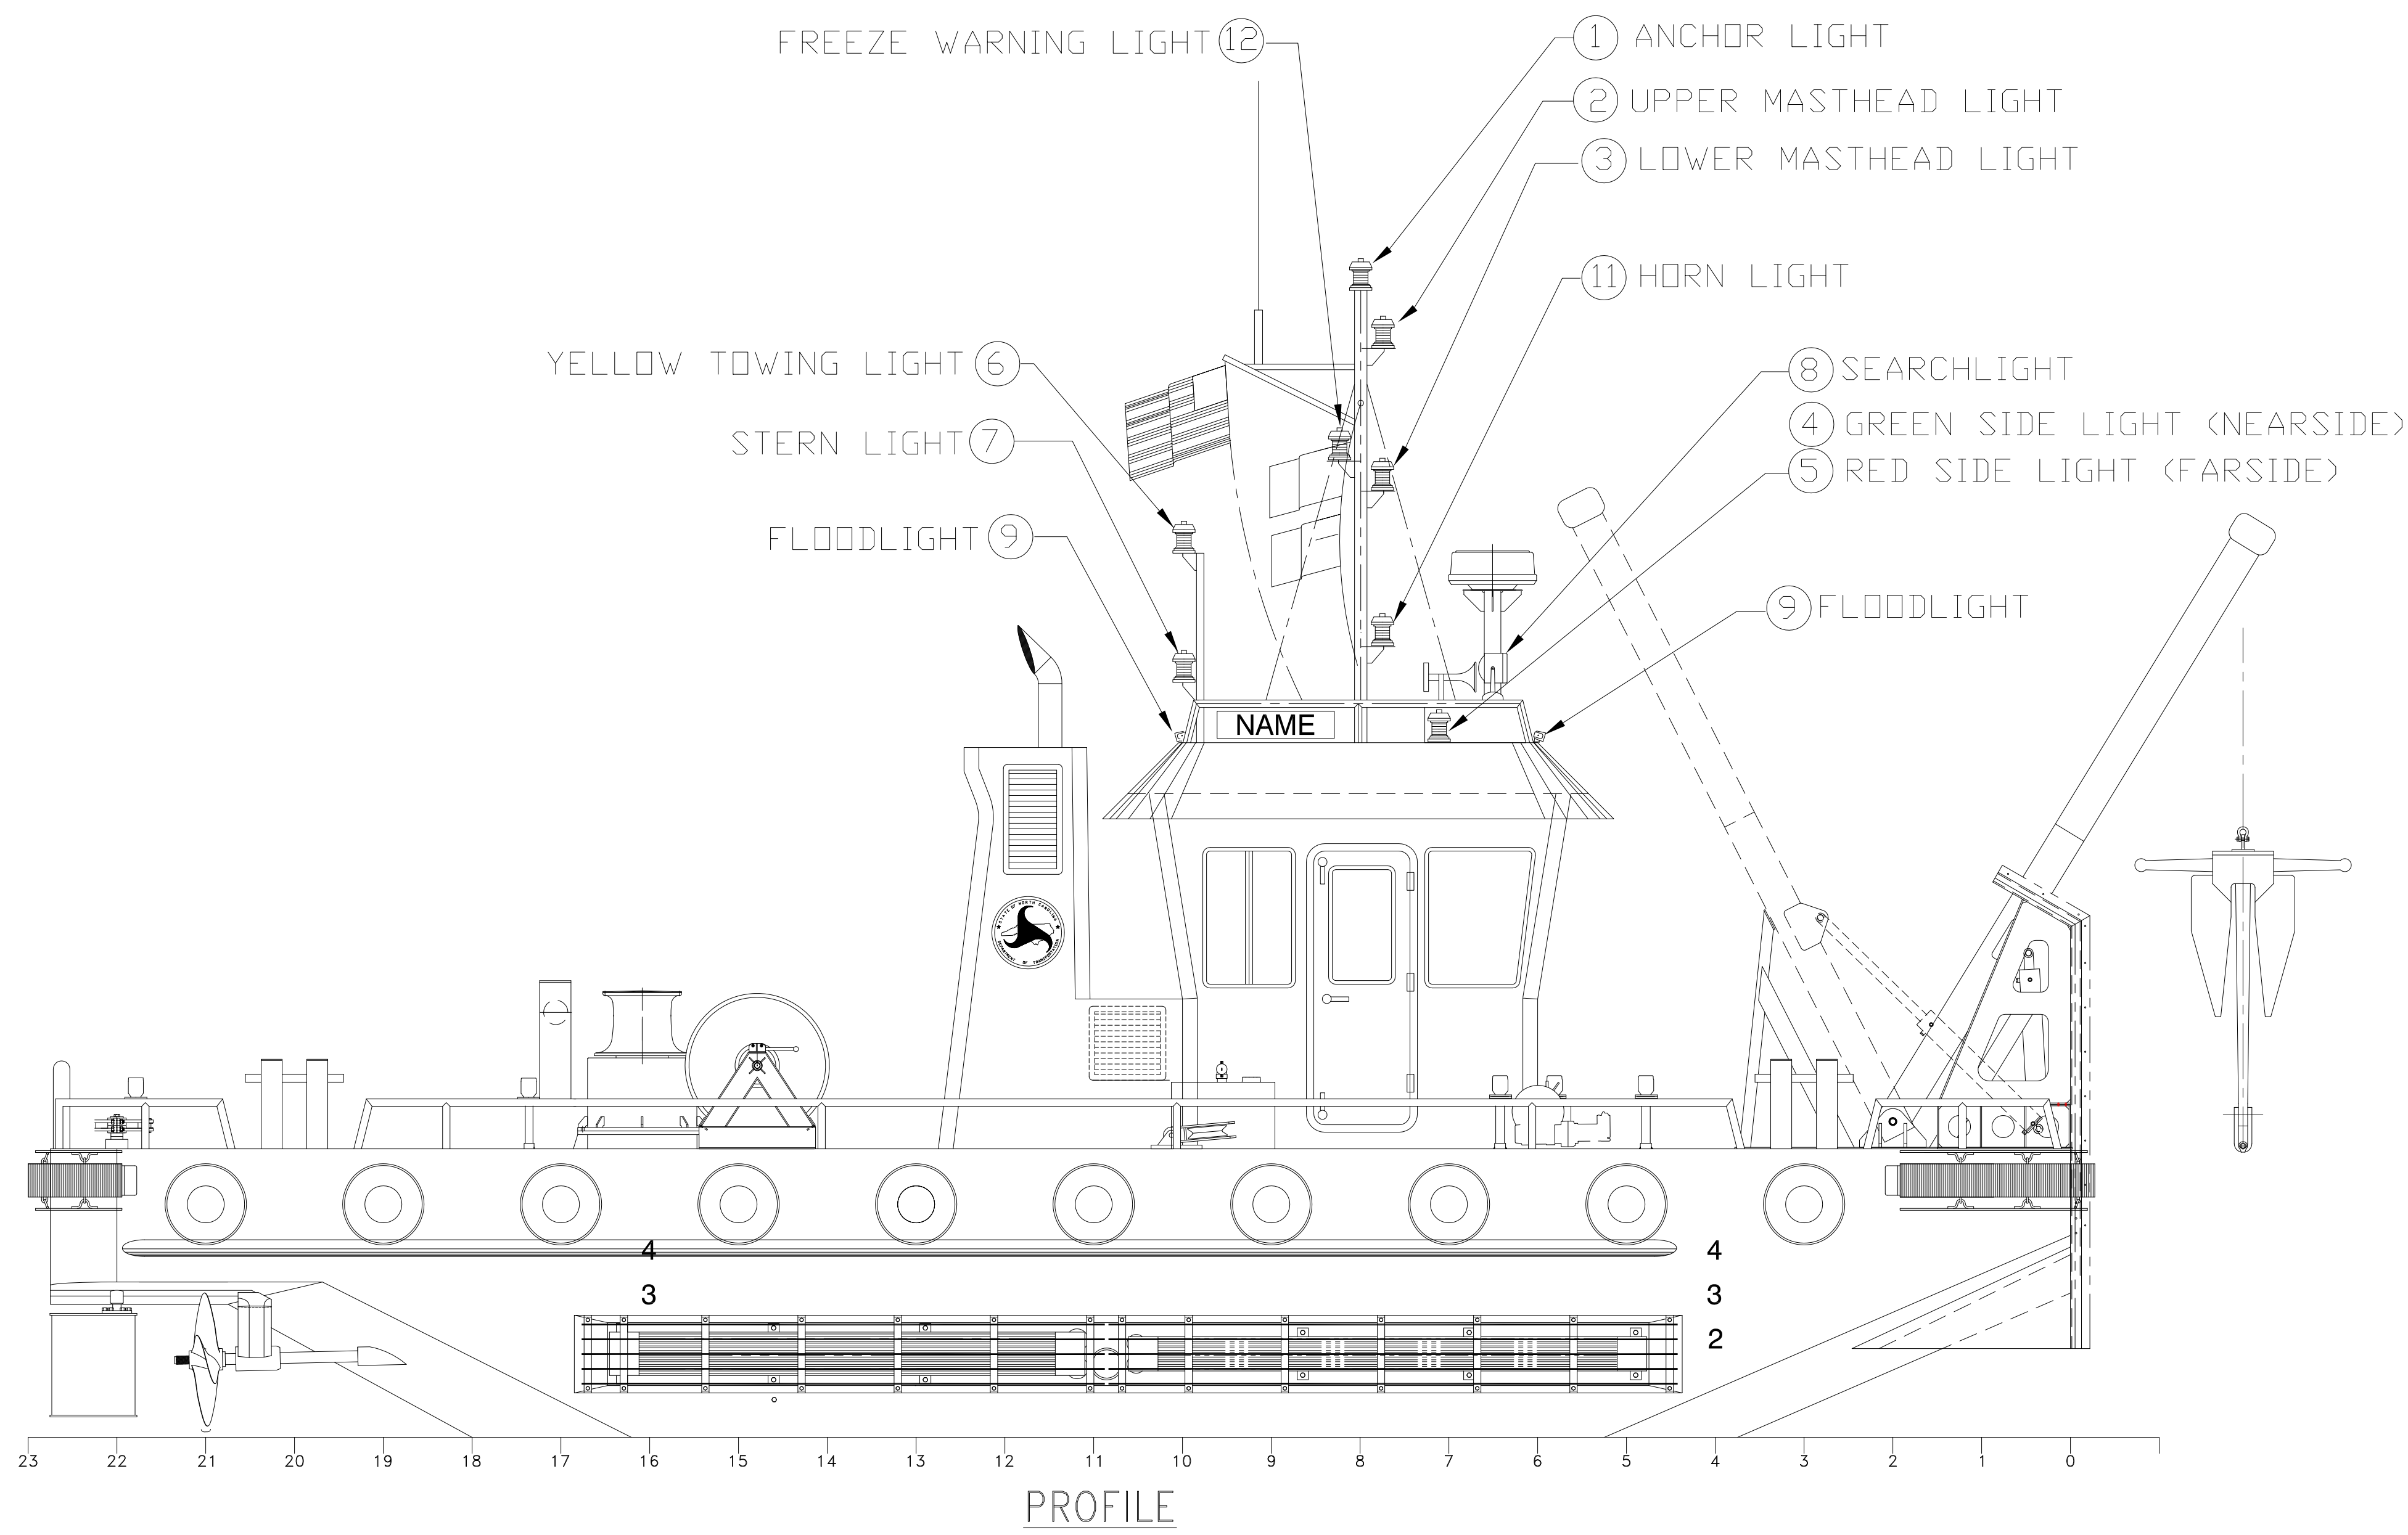

PROFESSIONAL ENGINEER

This document discloses matter in which DeJong & Lebet, Incorporated has proprietary rights. Neither receipt nor possession thereof confers or transfers any right to reproduce, disclose or use in any manner this document in whole or in part or any information contained herein, except by written permission, or written agreement with DeJong & Lebet, Incorporated.

In the event of a purchase of this document the purchaser is authorized to construct no more than one device in accord herewith, unless otherwise agreed to in writing by DeJong & Lebet, Incorporated.

© 2018 DeJong & Lebet, Inc.

DeJong & Lebet, Inc.
 Naval Architects
 Marine Engineers
 Consultants
 Surveyors

1734 Emerson Street
 Jacksonville, Florida 32207
 www.dejongandlebet.com

Phone: (904) 599-3673
 Fax: (904) 599-1522
 info@dejongandlebet.com

Title: 45.5'x20'x6.5' NCDOT PUSHBOAT

**NAVIGATION/SEARCH/FLOODLIGHTS
 & NAV. LTS. BLOCK DIAGRAM**

Dwg. No. 17-1393-422 Alt. No. 0 Sht. 1 of 1

Drawn By: JAH Date: DECEMBER 19, 2018
 Checked By: _____ Date: _____
 App'd By: _____ Scale: 1/4" = 1'-0"
 ABS App'l: _____ USCG App'l: _____