



UNIT 3 - FRAMING PLAN

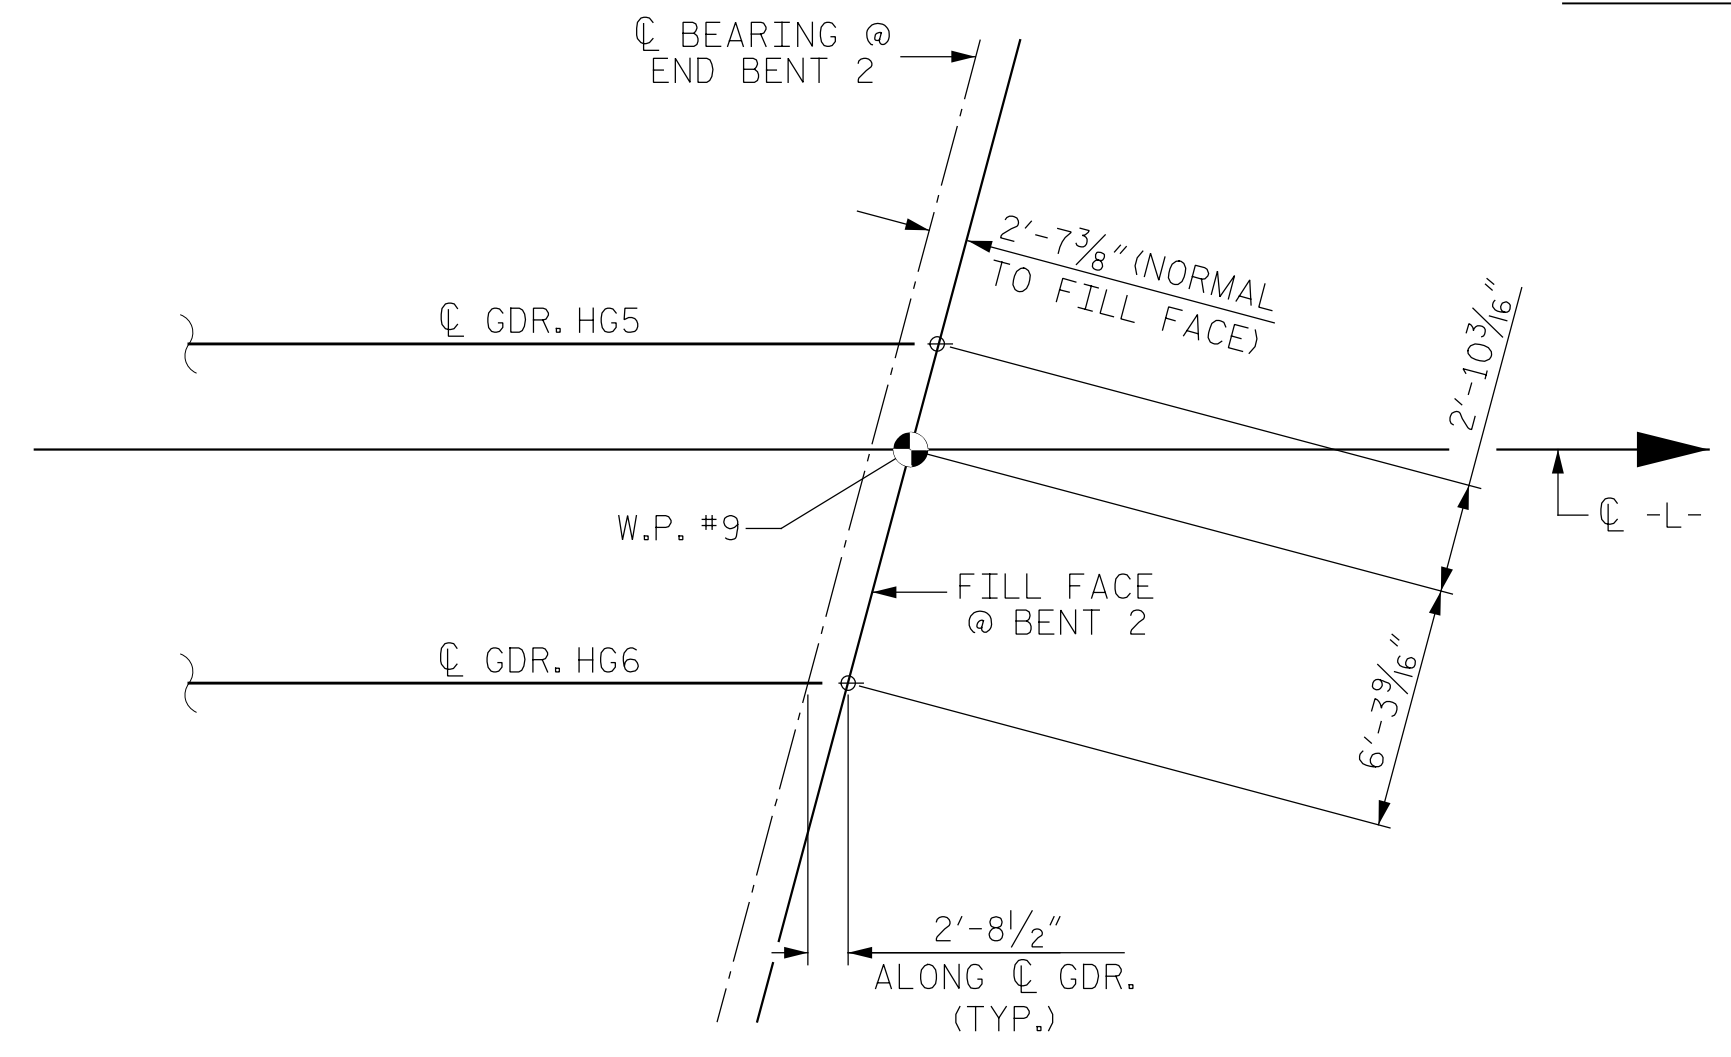

DETAIL D

PROJECT NO. 48793.3.1
 BLADEN COUNTY
 STATION: 118+81.78 -L-
 SHEET 3 OF 3

STATE OF NORTH CAROLINA
 DEPARTMENT OF TRANSPORTATION
 RALEIGH
 SUPERSTRUCTURE
 FRAMING PLAN
 UNIT 3

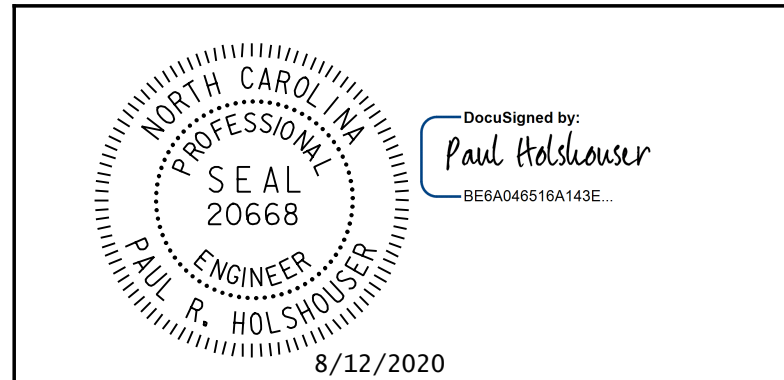

ICE of Carolinas, PLLC
 4505 Falls of Neuse Road, Suite 110
 Raleigh, North Carolina 27609
 Phone: 919-822-0333
 License #: P-0999

REVISIONS						SHEET NO.	
NO.	BY:	DATE:	NO.	BY:	DATE:	S-27	
1			3			TOTAL SHEETS	
2			4			107	

DOCUMENT NOT CONSIDERED FINAL
 UNLESS ALL SIGNATURES COMPLETED

Pen Table: \\192.168.64.12\icerd\RDUCAD\Plotting\Pen Tables\ICE_NC_Struct.tbl
 Print Driver: \\192.168.64.12\icerd\RDUCAD\Plotting\NGD001\22x34_PDF-ICE.plt
 User: jmaustin
 Plot Date: 8/11/2020 10:08:08 PM
 File Name: R:\Projects\19-77 Division 6 On Call\02 US 701 over Cape Fear River\NC001\Structures\Drawings\Final\401-02T_US_701_SWL_FP_03.dgn
 DRAWN BY: B. J. MANTEI DATE: 7-09-20
 CHECKED BY: P. R. HOLSHOUSER DATE: 7-16-20
 DESIGN E.O.R.: P. R. HOLSHOUSER DATE: 7-23-20