


LEGEND

- YAGI ANTENNA (DOUBLE) FOR REPEATER OPERATION
- YAGI ANTENNA (SINGLE)
- OMNI ANTENNA
- EXISTING CONTROLLER AND CABINET
- EXISTING MASTER CONTROLLER AND CABINET
- SIGNAL INVENTORY NUMBER
- EXISTING METAL POLE W/MAST ARM
- EXISTING WOOD POLE
- NEW METAL POLE
- SIGNAL POLE
- EXISTING METAL POLE
- NEW OVERSIZED JUNCTION BOX
- EXISTING OVERSIZED JUNCTION BOX
- EXISTING CONDUIT
- NEW CONDUIT
- EXISTING COMMUNICATIONS CABLE

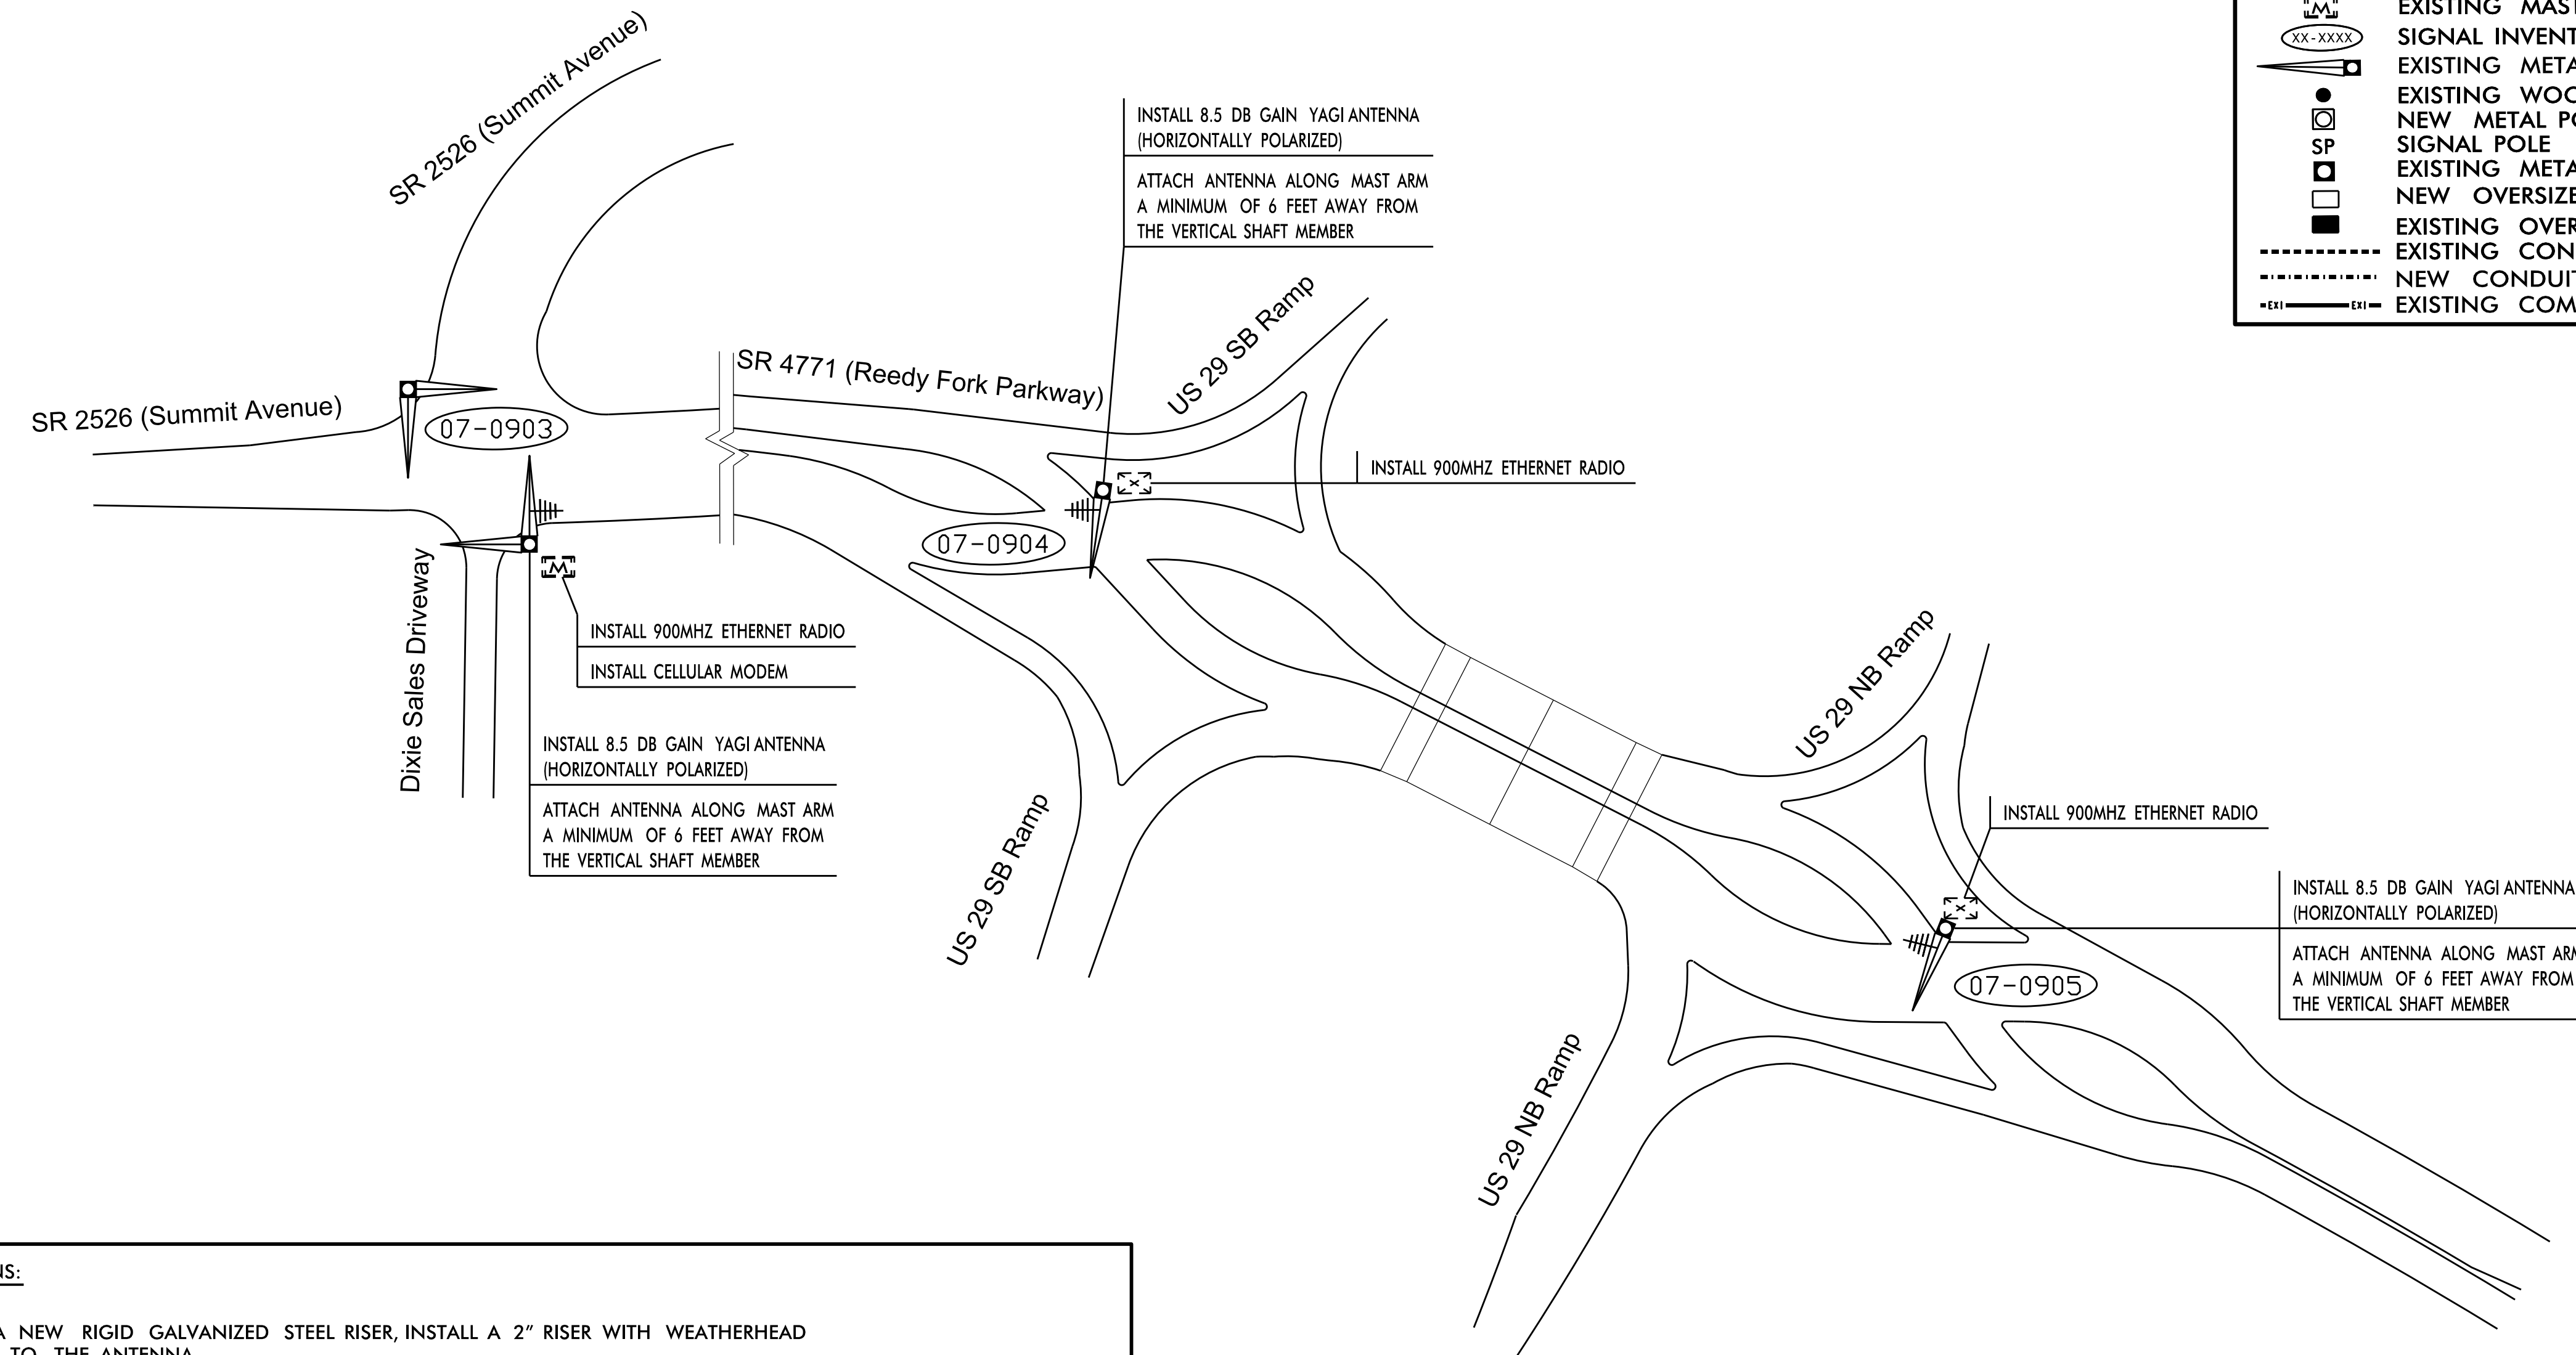

NOTES FOR WIRELESS COMMUNICATIONS:

- INSTALL COAXIAL CABLE:
 - ON WOOD POLES, REQUIRING A NEW RIGID GALVANIZED STEEL RISER, INSTALL A 2" RISER WITH WEATHERHEAD AND ROUTE THE COAXIAL CABLE TO THE ANTENNA.
 - ON METAL POLES WITH MAST ARMS, RUN COAXIAL CABLE UP THROUGH THE POLE AND OUT THE MAST ARM; FIELD DRILL A 1/2" HOLE UP THROUGH THE BOTTOM OF MAST ARM FOR INSTALLATION OF THE COAXIAL CABLE TO THE ANTENNA.
 - ON METAL STRAIN POLES, RUN COAXIAL CABLE UP THROUGH THE POLE AND OUT THE WEATHERHEAD AND ROUTE THE COAXIAL CABLE TO THE ANTENNA.
 - BETWEEN THE POINT OF EXITING THE RISER, METAL POLE OR MAST ARM AND THE ANTENNA, SECURE THE COAXIAL CABLE TO THE STRUCTURE USING 3/4" STAINLESS STEEL STRAPS EVERY 12".
- IF AN EXISTING 2" SPARE RIGID GALVANIZED STEEL RISER IS AVAILABLE, INSTALL THE COAXIAL CABLE IN THE SPARE RISER AND SEAL RISER WITH HEAT SHRINK TUBING RETROFIT KIT.
- INSTALL WIRELESS ANTENNA ON POLE WITH RF WARNING SIGN.
(NOTE: RF WARNING SIGN NOT REQUIRED WHEN ANTENNA IS INSTALLED ON AN NCDOT-OWNED POLE.)
- MAINTAIN PROPER CLEARANCE FROM ALL UTILITIES PER THE NATIONAL ELECTRICAL SAFETY CODE.
- INSTALL WIRELESS RADIO MODEM WITH EXTERIOR DISCONNECT SWITCH LOCATED ON CABINET.
(NOTE: RF ANTENNA DISCONNECT SWITCH AND DECAL ARE NOT REQUIRED WHEN THE ANTENNA IS INSTALLED ON AN NCDOT-OWNED POLE.)
- REFERENCE "WIRELESS RADIO ANTENNA TYPICAL DETAILS."
- CELL MODEM TO BE SUPPLIED BY THE DIVISION. CONTACT THE ASSISTANT DIVISION TRAFFIC ENGINEER AT (336) 487-0175 TO REQUEST THE CELL MODEM. ALLOW 8 WEEK LEAD TIME AFTER REQUESTING THE CELL MODEM.

Project #: 180914

DAVENPORT
HOME OFFICE:
119 BROOKSTOWN AVENUE, SUITE PH1
WINSTON-SALEM, NC 27101
336.744.1636 www.davenportworld.com
NCBELS FIRM LICENSE NO. C-2522

Prepared for:

 750 N. Greenfield Pkwy, Garner, NC 27529

WIRELESS COMMUNICATION PLAN

Division 7 Guilford County Greensboro

PLAN DATE: April 2020 REVIEWED BY: L. Boyer

PREPARED BY: A. HAYES REVIEWED BY: R. Hinshaw

REVISIONS	INIT.	DATE

SCALE: 1" = 100'

DOCUMENT NOT CONSIDERED FINAL UNLESS ALL SIGNATURES COMPLETED

SEAL

DocuSigned by:

 R. ROYAL HINSHAW
 DATE: 4/20/2020