

TIP NO.	SHEET NO.
B-5980	SIGN-01
APPROVED:	
DATE:	
<b>DOCUMENT NOT CONSIDERED FINAL UNLESS ALL SIGNATURES COMPLETED</b>	

**STATE OF NORTH CAROLINA  
DEPARTMENT OF TRANSPORTATION**

**SIGNING PLAN  
NASH COUNTY**

**LOCATION: I-95 INTERCHANGE IMPROVEMENTS AT HALIFAX ROAD (SR 1544)**

**T.I.P.: B-5980**

**CONTRACT: C204350**

**ROADWAY STANDARD DRAWING**

THE FOLLOWING ROADWAY STANDARDS AS APPEAR IN "ROADWAY STANDARD DRAWINGS" - PROJECT SERVICES UNIT - N.C. DEPARTMENT OF TRANSPORTATION - RALEIGH, N.C., DATED JANUARY 2018 ARE APPLICABLE TO THIS PROJECT AND BY REFERENCE HEREBY ARE CONSIDERED A PART OF THESE PLANS:

STD. NO.	TITLE
901.10	TYPE 'A' SIGNS
901.50	ARROWS AND SHIELDS
901.70	SIGN STRINGERS AND SUPPORT SPACING
901.80	SIGN MOUNTING DETAILS - FOR TYPE A AND TYPE B SIGNS
903.10	GROUND MOUNTED SIGN SUPPORTS
904.10	ORIENTATION OF GROUND MOUNTED SIGNS
904.40	MILEPOST AND PLACEMENT
904.50	MOUNTING OF TYPE 'D', 'E' AND 'F' SIGNS ON 'U' CHANNEL POSTS
910.40	SINGLE/TWO LANE ROUNDABOUT WITH PEDESTRIAN

**GENERAL NOTES**

- . ALL TYPE 'D' SIGNS SHALL BE MOUNTED ON TWO U-CHANNEL POSTS UNLESS OTHERWISE INDICATED ON THE PLANS.
- . IF REMOVAL OR RELOCATION OF SIGNS ON PRIVATE STREET (NON-STATE MAINTAINED) IS REQUIRED DUE TO CONSTRUCTION, THE CONTRACTOR SHALL INFORM THE ENGINEER. THE WORK WILL BE COMPLETED BY OTHERS.
- . WHEN NOT STATIONED OR DIMENSIONED ON PLANS, ALL 'E' AND 'F' SIGNS SHALL BE FIELD LOCATED BY THE ENGINEER
- . ALL EXISTING SIGNS ON "U" CHANNEL POST WITHIN THE PROJECT LIMITS SHALL BE REMOVED AND DISPOSED OF UNLESS OTHERWISE NOTED ON PLANS.
- . THE BACKGROUND FOR TYPE E & F SIGNS SHALL BE TYPE C REFLECTIVE SHEETING.

**SUMMARY OF QUANTITIES**

ITEM NO.		ITEM DESCRIPTION	QUANTITY	UNIT
DESC. NO.	SECT. NO.			
4025000000	901	CONTRACTOR FURNISHED, TYPE A SIGN	626	S.F.
4025000000	901	CONTRACTOR FURNISHED, TYPE D SIGN	422	S.F.
4025000000	901	CONTRACTOR FURNISHED, TYPE E SIGN	397	S.F.
4025000000	901	CONTRACTOR FURNISHED, TYPE F SIGN	203	S.F.
4025000000	901	CONTRACTOR FURNISHED, MILEMARKER SIGN	4	S.F.
4048000000	902	REINFORCED CONCRETE SIGN FOUNDATION	1	C.Y.
4060000000	903	SUPPORTS, BREAKAWAY STEEL BEAM	1,452	LB.
4072000000	903	SUPPORTS, 3 LB STEEL U-CHANNEL	2,350	L.F.
4096000000	904	SIGN ERECTION, TYPE D	12	EA.
4102000000	904	SIGN ERECTION, TYPE E	54	EA.
4108000000	904	SIGN ERECTION, TYPE F	62	EA.
4109000000	904	SIGN ERECTION, TYPE A (OVERHEAD)	2	EA.
4110000000	904	SIGN ERECTION, TYPE A (GROUND MOUNTED)	4	EA.
4114000000	904	SIGN ERECTION, MILEMARKERS	2	EA.
4116100000	904	SIGN ERECTION, RELOCATE TYPE E (GROUND MOUNTED)	1	EA.
4155000000	907	DISPOSAL OF SIGN SYSTEM, U-CHANNEL	46	EA.
4234000000	907	DISPOSAL OF SIGN, A OR B (OVERHEAD)	5	EA.
4238500000	907	DISPOSAL OF SIGN, MILEMARKERS	2	EA.
4251000000	907	DISPOSAL OF LIGHTING SYSTEM	5	EA.

**PROJECT NOTES**


1. DISPOSAL OF SIGN SYSTEM, U-CHANNEL
  2. NOT USED
  3. RELOCATE SIGN, TYPE E
  4. DISPOSAL OF SIGN, MILEMARKERS
  5. DISPOSAL OF SIGN, A OR B (OVERHEAD)
  6. DISPOSAL OF LIGHTING SYSTEM
  7. CONTACT DOUG DRAKE, DIVISION 4 LOGO COORDINATOR 252-640-6534
- ★ SIGNALIZED INTERSECTION

**INDEX**


SHEET NO.	DESCRIPTION
SIGN-01	TITLE SHEET
SIGN-02	TYPE "A" AND "B" GROUND MOUNTED SIGNS
SIGN-03 - 3A	TYPE "A" SIGNS
SIGN-3B - 3D	TYPE "D" SIGNS
SIGN-04	TYPE "E" SIGNS
SIGN-05	TYPE "F" SIGNS
SIGN-06 - 12	EXISTING SIGNS
SIGN-13 - 19	PROPOSED SIGNS

PLAN PREPARED BY: **AECOM** 701 Corporate Center Drive, Suite 475  
Raleigh, NC 27607  
(919) 854-6200 - (919) 854-6259 (FAX)

JEFFREY KOONTZ, PE PROJECT ENGINEER  
KASEY MCCOY PROJECT DESIGNER

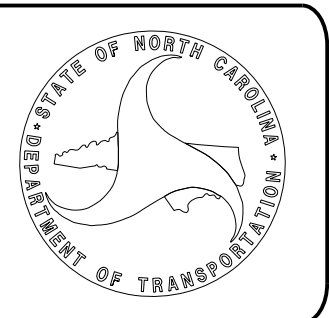



5/3/2021 P:\Projects\260557176 - B-5980\900-CAD-GIS\910-CAD\70-NCDDOT-TIP\TrafficControl\TCPN\B5980\_sign\_01\_TSH.dgn

TIP NO. B-5980	SHEET NO. SIGN-02
APPROVED: <i>Jeffrey A. Kootz</i> <small>DocuSigned by: Jeffrey A. Kootz B6BFECC02384F7</small>	
DATE: 4/15/2020	
	
<b>DOCUMENT NOT CONSIDERED FINAL UNLESS ALL SIGNATURES COMPLETED</b>	

NUMBER	TYPE	SIGN SIZE (in.)			ROADWAY STATION	NUMBER OF SUPPORTS	BEAM SECTION	SUPPORT TYPE BA or S	OMNI COUPLER	ATTACHMENT METHOD	MOUNTING METHOD	HORIZONTAL CLEARANCE* (ft.)	SUPPORT SPACING	LENGTH (ft)			LEFT SUPPORT (ft)			CENTER SUPPORT (ft)			RIGHT SUPPORT (ft)			SUPPORT WEIGHTS		FOOTINGS				FIELD VERIFIED SEE NOTE 2 (mm/dd/yy)																				
		SNS HT	MTG HT	EMBED-MENT										S	L	LENGTH	S	L	LENGTH	S	L	LENGTH	B/A (lbs.)	SIMPLE (lbs.)	DIAMETER (ft.)	DEPTH (ft.)	REINFORCED (c.y.)	PLAIN (c.y.)																								
		"H"	"C"																																																	
101	A	84	x	78	Y1 51+00	2	S4x7.7	BA	N/A	N/A	N/A	24.00	4.10	6.50	7.00	3.0	2.63	16.13	19.13	0.00	0.00	0.00	3.72	17.22	20.22	343.00	0	1.0	3.5	0.00	0.20	_____																				
102	A	78	x	78	Y1 28+85	2	S3x5.7	BA	N/A	N/A	N/A	40.00	3.81	6.50	7.00	2.5	0.13	13.63	16.13	0.00	0.00	0.00	0.29	13.79	16.29	220.79	0	1.0	3	0.00	0.17	_____																				
103	A	102	x	78	Y1 44+78	2	W6x9	BA	N/A	N/A	N/A	24.00	4.98	6.50	7.00	3.0	3.35	16.85	19.85	0.00	0.00	0.00	5.48	18.98	21.98	440.47	0	1.5	3.5	0.46	0.00	_____																				
104	A	96	x	78	Y1 41+38	2	W6x9	BA	N/A	N/A	N/A	24.00	4.69	6.50	7.00	3.0	5.11	18.61	21.61	0.00	0.00	0.00	4.50	18.00	21.00	447.49	0	1.5	3.5	0.46	0.00	_____																				
																								TOTAL	TOTAL	TOTAL	TOTAL																									
																								1451.75	0.00	0.92	0.38																									
																								USE:	1452.00	0.00	1.00	1.00																								

**NOTES**


- DIMENSION "S" REPRESENTS AN INCREASE (+), OR A DECREASE (-) IN POLE LENGTH, RELATIVE TO THE ELEVATION OF THE EDGE OF TRAVEL LANE.
- FIELD VERIFICATIONS SHALL BE REQUIRED FOR ALL SUPPORTS, SEE (\*) ARTICLE 903-3. FABRICATORS SHALL BE AISC CERTIFIED IN CATEGORY 1, SEE (\*) ARTICLE 1072-1. (\*) = N.C.D.O.T. STANDARD SPECIFICATIONS FOR ROADS AND STRUCTURES
- PLAN LOCATIONS FOR EXISTING UTILITIES ARE BASED ON THE BEST AVAILABLE INFORMATION AND, THEREFORE MAY NOT BE PRECISELY ACCURATE. THEREFORE, IT IS INCUMBENT UPON THE CONTRACTOR TO DETERMINE THE EXACT LOCATION OF UTILITIES BEFORE BEGINNING WORK IN A LOCATION.

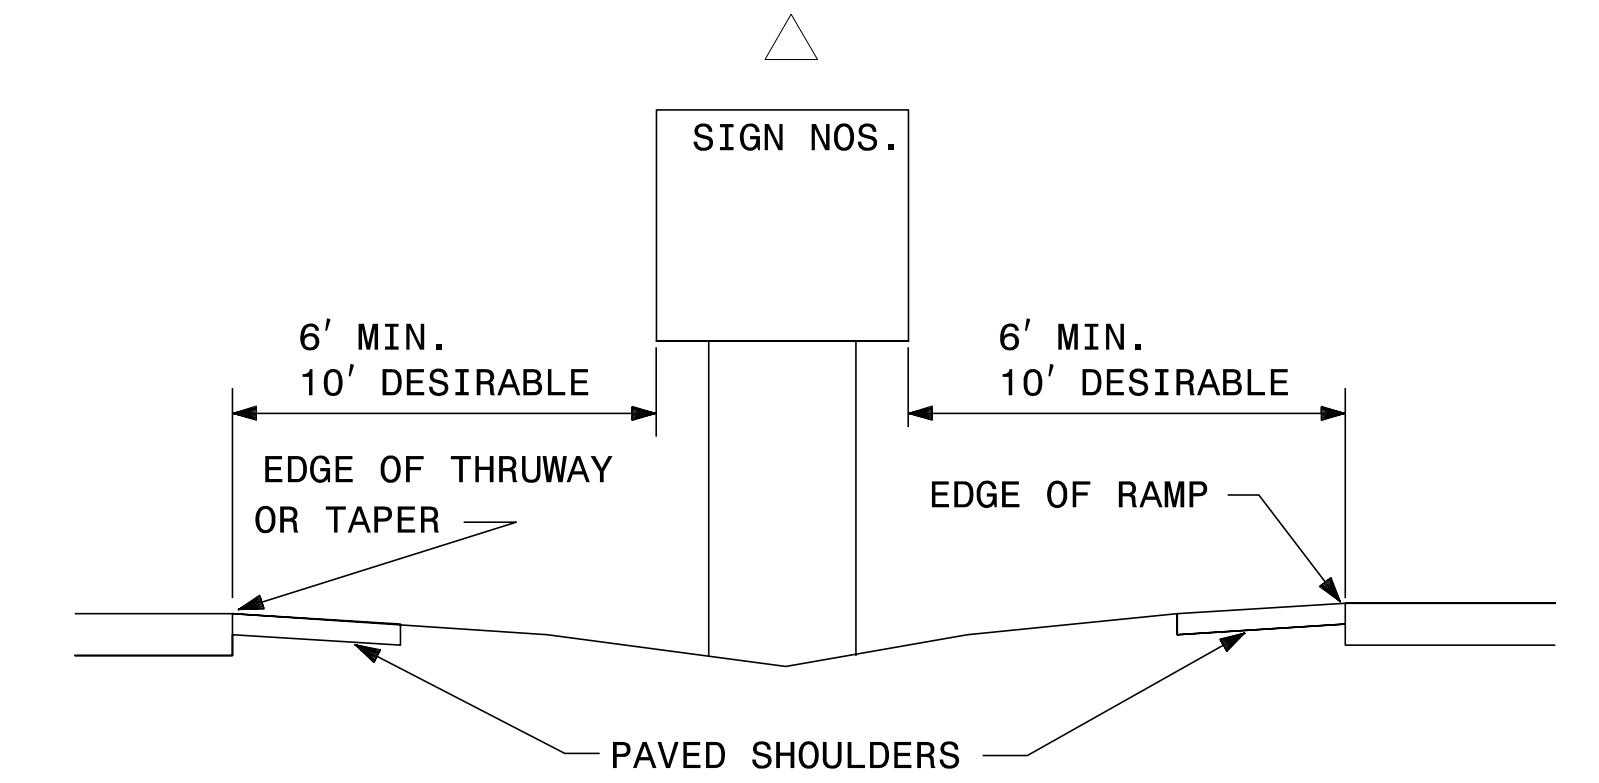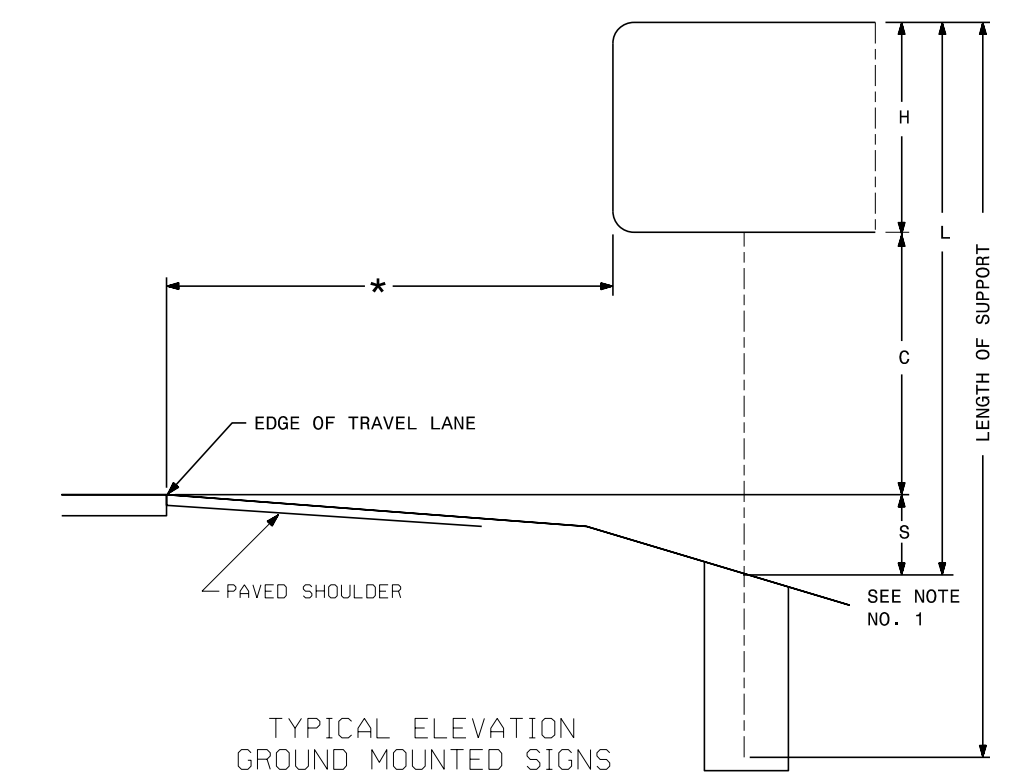


**TYPE "A" AND TYPE "B" GROUND MOUNTED SIGNS**

2/20/2020 10:00:00 AM  
 C:\Users\jeff.koontz\Documents\TrafficControl\TCP\B5980\_sign\_02\_OVERHEAD.dgn  
 User: jeff.koontz



TIP NO. B-5980	SHEET NO. SIGN-3A
APPROVED: <i>Jeffrey A. Kootz</i> <small>DocuSigned by: Jeffrey A. Kootz B4EBFECCD284F7...</small>	
DATE: 4/15/2020	
SEAL	
	
<b>DOCUMENT NOT CONSIDERED FINAL UNLESS ALL SIGNATURES COMPLETED</b>	

SIGN NUMBER: 105  
SIGN DETAIL  
1:70

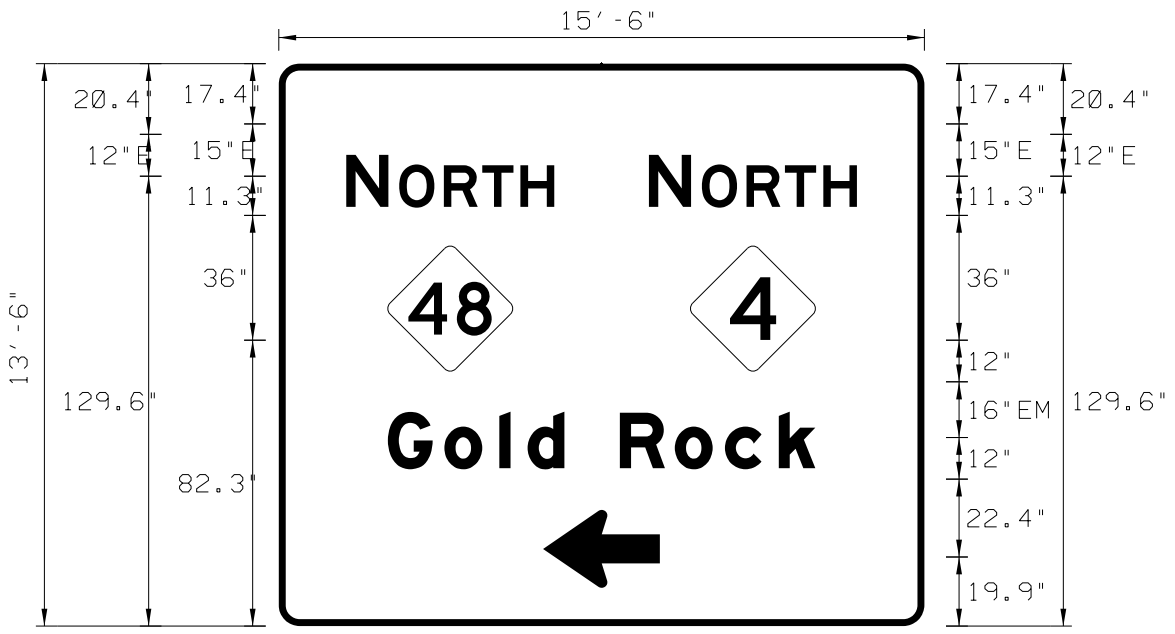


SIGN NUMBER	105
WIDTH x HGHT.	15'-6" x 13'-6"
BORDER WIDTH	2"
CORNER RADIUS	6"
MOUNTING	Overhead
BACKGROUND	TYPE: Reflective COLOR: Green
LEGEND/BORDER	TYPE: Reflective COLOR: White/White

SYMBOL	ROT	X	Y	WID	HT
NC362	0	31.4	82.3	36	36
NC361	0	118.682.3	36	36	
AR_TYPE D	90	76.2	19.9	22.4	33.6

Panel Style: Standard 16 Inch.ssi  
Dimensions are inches, tenths  
Letter locations are panel edge to lower left corner

LETTER POSITIONS (X)										LENGTH	SERIES/SIZE
N	O	R	T	H						59.9	E 2000
19.4	34.7	47.6	58.6	69.7							15.12
N	O	R	T	H						59.9	E 2000
106.6	121.9	134.8	145.8	156.9							15.12
G	O	L	D		R	O	C	K		123.2	EM 2000
31.4	47.7	63.6	71.7	82.3	98.3	114.1	128.5	144			16/12

SIGN NUMBER: 106  
SIGN DETAIL  
1:70

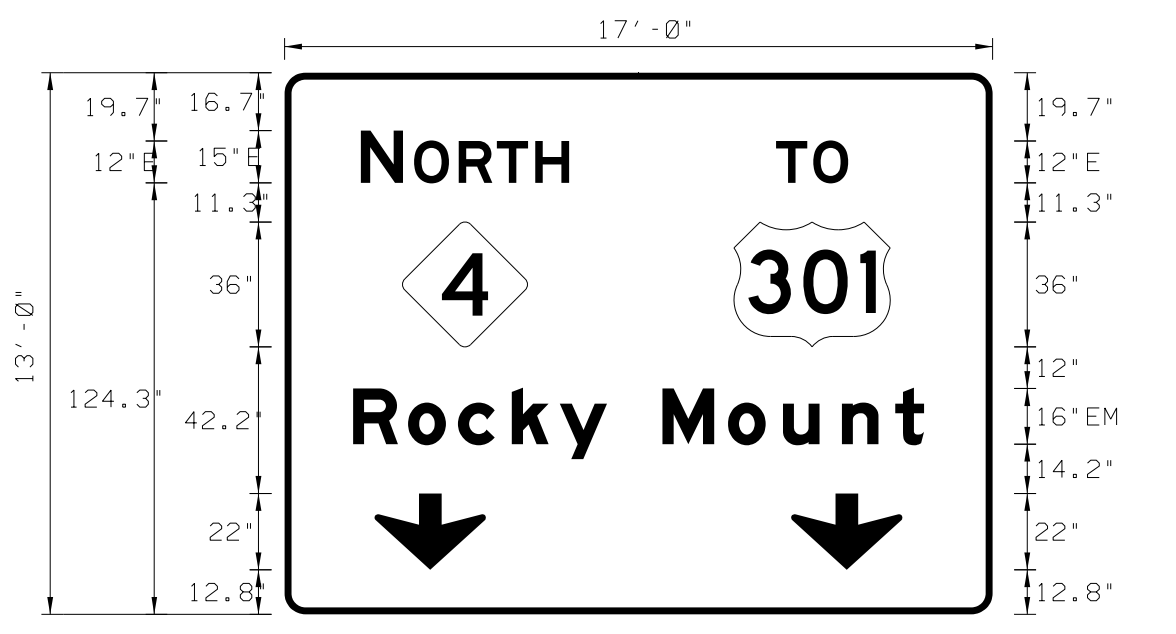

SIGN NUMBER	106
WIDTH x HGHT.	17'-0" x 13'-0"
BORDER WIDTH	2"
CORNER RADIUS	6"
MOUNTING	Overhead
BACKGROUND	TYPE: Reflective COLOR: Green
LEGEND/BORDER	TYPE: Reflective COLOR: White/White

SYMBOL	ROT	X	Y	WID	HT
NC361	0	34	77	36	36
M1_4	0	129.577	45	36	
ARDOWN	0	26	12.8	32.1	22
ARDOWN	0	146	12.8	32.1	22

Panel Style: Standard 16 Inch.ssi  
Dimensions are inches, tenths  
Letter locations are panel edge to lower left corner

LETTER POSITIONS (X)										LENGTH	SERIES/SIZE	
N	O	R	T	H						59.9	E 2000	
22	37.3	50.2	61.2	72.3							15.12	
T	O									20.8	E 2000	
141.6	152.3										12	
R	O	C	K	Y		M	O	U	N	T	164.5	EM 2000
19.8	35.6	50	65.5	79.3	92.9	108.9	127.8	143.6	160.6	175.9		16/12

2/20/2020 10:00 AM  
 H:\Projects\TrafficControl\TCP\B5980\_sign\_3A\_Type A.dgn  
 User: Jeffrey A. Kootz

**TYPE "A" SIGN DESIGNS**








APPROVED: *Jeffrey A. Kooftz*  
DATE: 4/15/2020




DOCUMENT NOT CONSIDERED FINAL  
UNLESS ALL SIGNATURES COMPLETED

401 QUANTITY REQ'D 1

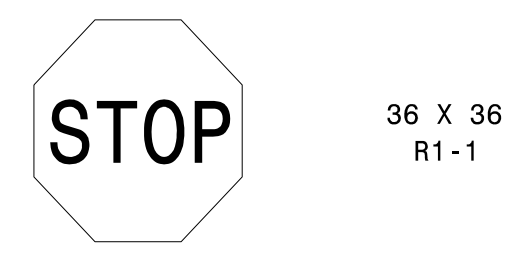


ONE "U" POST PER SIGN

406 QUANTITY REQ'D 4

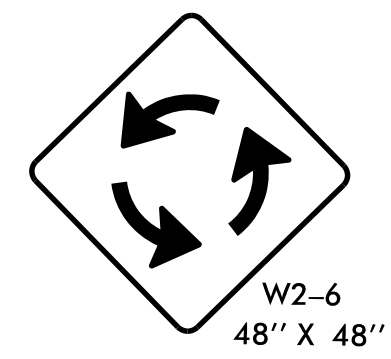


TWO "U" POST PER SIGN

411 QUANTITY REQ'D 8

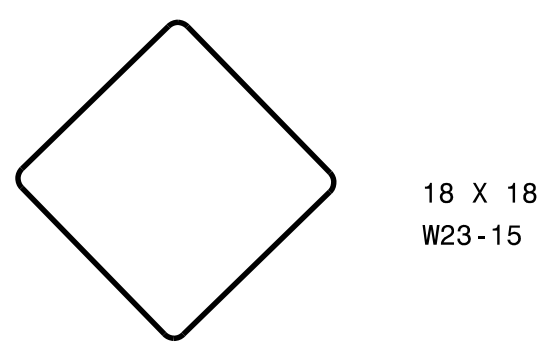


ONE "U" POSTS PER SIGN  
MOUNTED IN 2 INSTALLATIONS  
BELOW SIGN 416

416 QUANTITY REQ'D 2

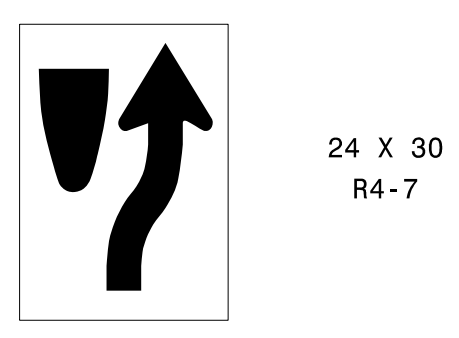

ONE "U" POST PER SIGN

402 QUANTITY REQ'D 2

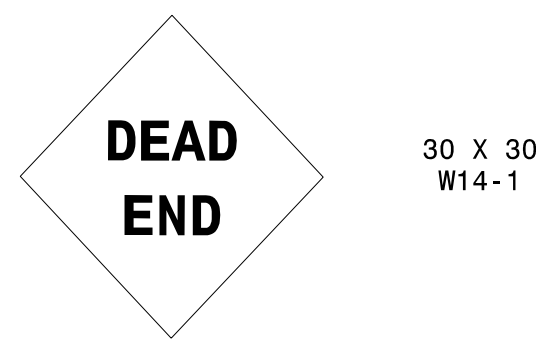


ONE "U" POST PER SIGN

407 QUANTITY REQ'D 2




ONE "U" POST PER SIGN

412 QUANTITY REQ'D 4

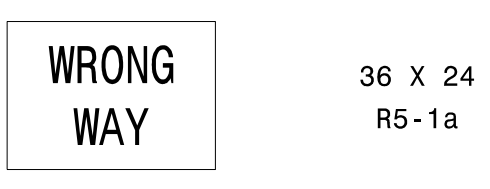


ONE "U" POST PER SIGN

417 QUANTITY REQ'D 1

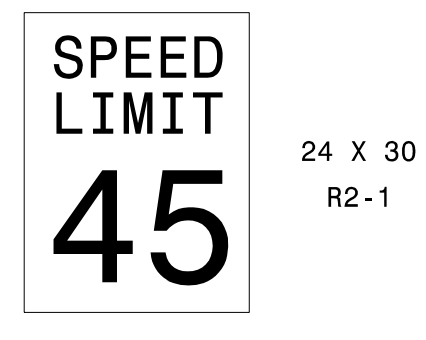


ONE "U" POSTS PER SIGN

403 QUANTITY REQ'D 6

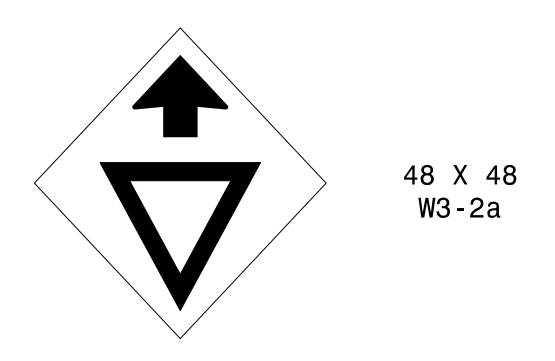


TWO "U" POST PER SIGN

408 QUANTITY REQ'D 6

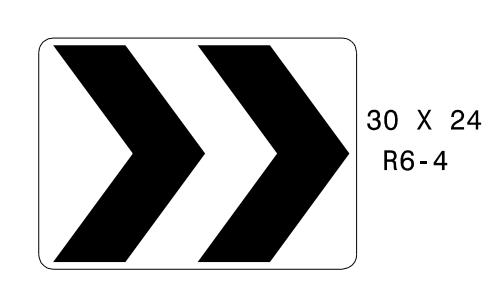


ONE "U" POST PER SIGN

413 QUANTITY REQ'D 1

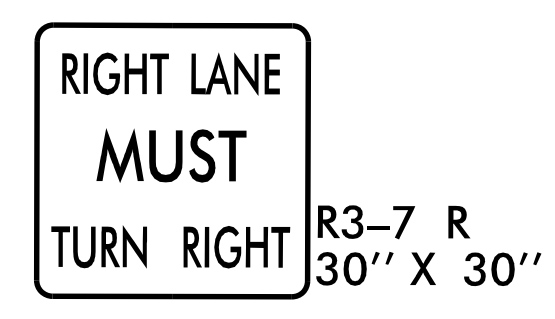


ONE "U" POST PER SIGN

418 QUANTITY REQ'D 1

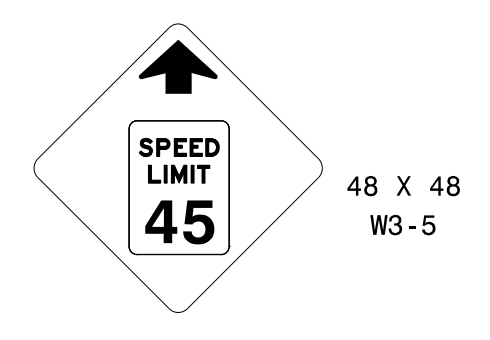


TWO "U" POSTS PER SIGN

404 QUANTITY REQ'D 6

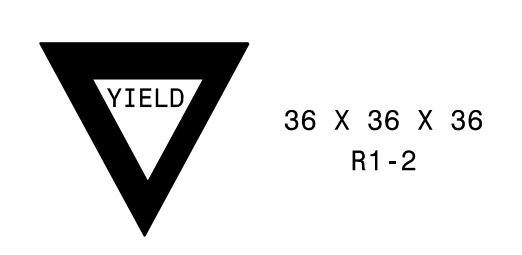


ONE "U" POST PER SIGN

409 QUANTITY REQ'D 1

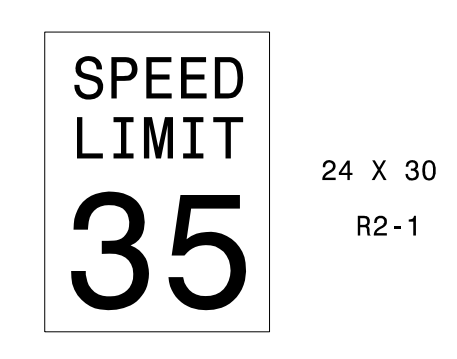


ONE "U" POSTS PER SIGN

414 QUANTITY REQ'D 6

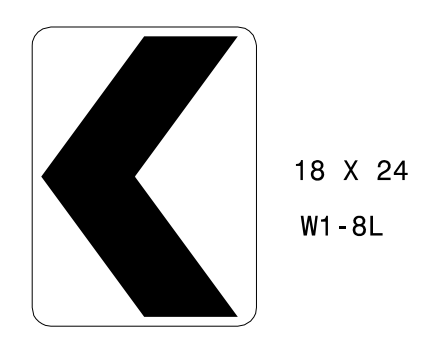


ONE "U" POSTS PER SIGN

419 QUANTITY REQ'D 1

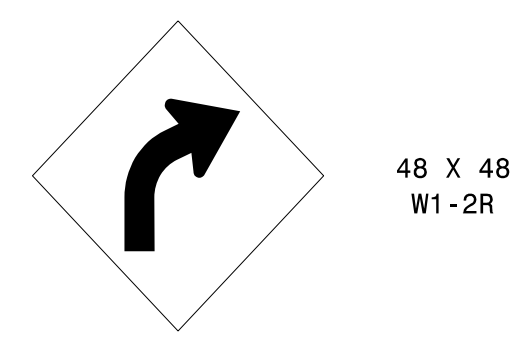


TWO "U" POST PER SIGN

405 QUANTITY REQ'D 1

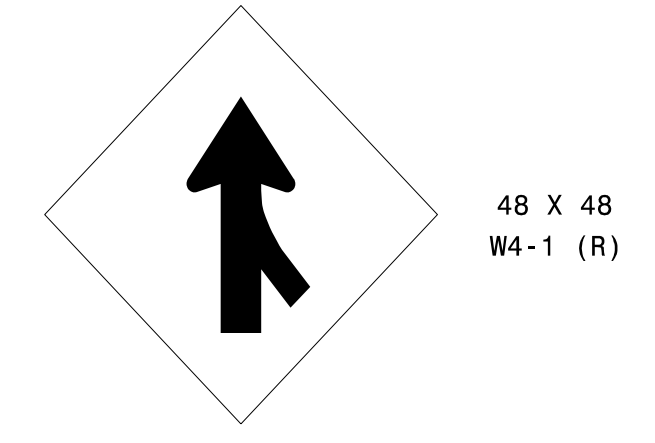


TWO "U" POSTS PER SIGN

410 QUANTITY REQ'D 2

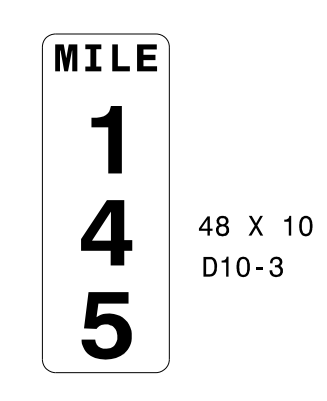

ONE "U" POSTS PER SIGN

415 QUANTITY REQ'D 1

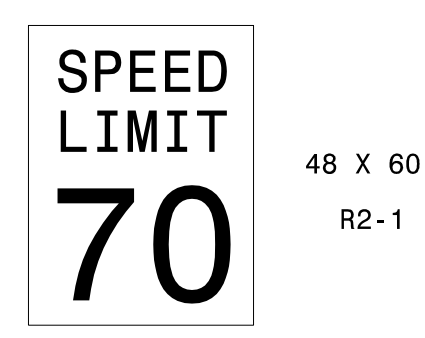

TWO "U" POSTS PER SIGN

TYPE "E" SIGNS

2/20/2020  
P:\TrafficControl\TCP\B5980\_sign\_04\_Type E.dgn  
User: jefr.koontz




APPROVED: *Jeffrey A. Koontz*  
DATE: 4/15/2020




DOCUMENT NOT CONSIDERED FINAL UNLESS ALL SIGNATURES COMPLETED

501 QUANTITY REQ'D . 1 .

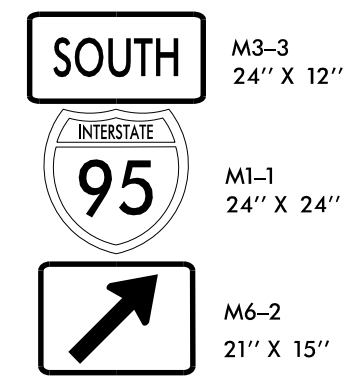


ONE "U" POSTS PER SIGN

506 QUANTITY REQ'D . 1 .

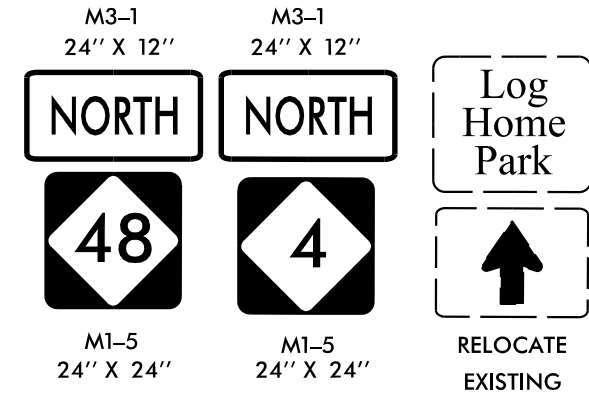


TWO "U" POSTS PER SIGN

511 QUANTITY REQ'D . 1 .

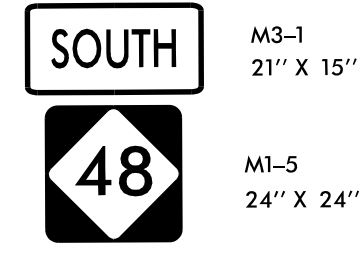


ONE "U" POSTS PER SIGN

502 QUANTITY REQ'D . 1 .

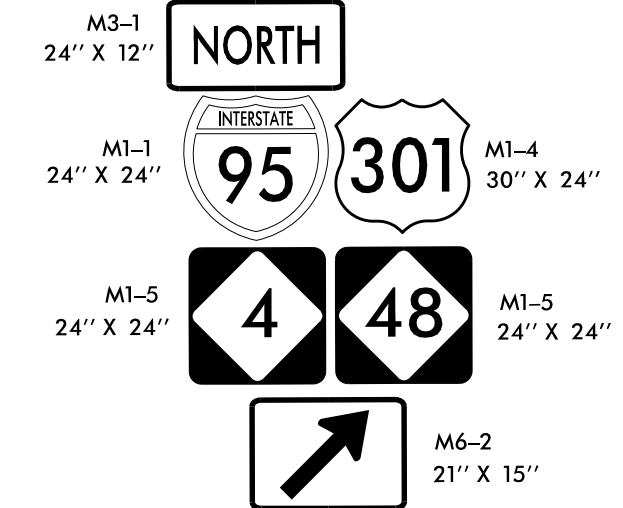


TWO "U" POSTS PER SIGN

507 QUANTITY REQ'D . 1 .

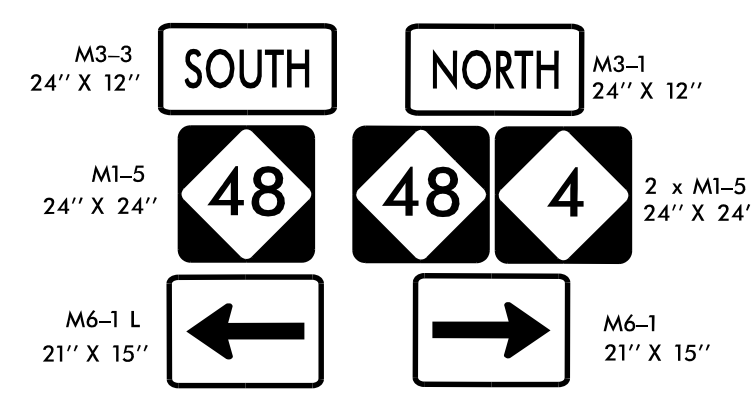


TWO "U" POSTS PER SIGN

512 QUANTITY REQ'D . 1 .

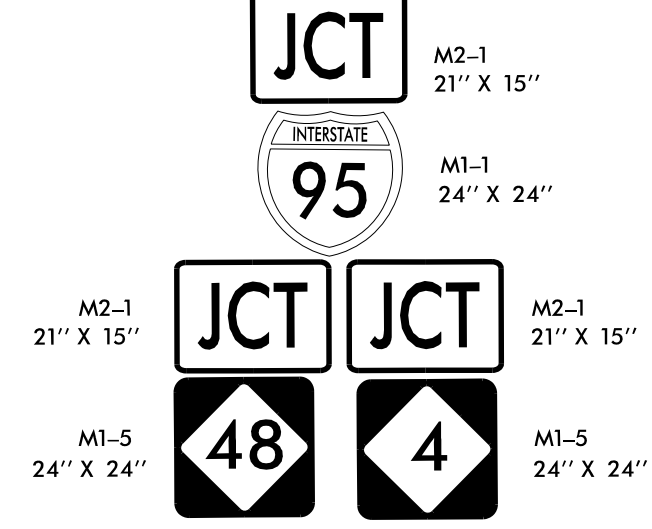


TWO "U" POSTS PER SIGN

503 QUANTITY REQ'D . 1 .

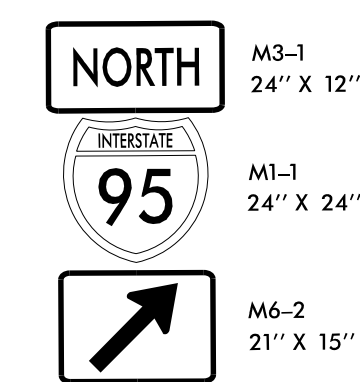


ONE "U" POSTS PER SIGN

508 QUANTITY REQ'D . 1 .

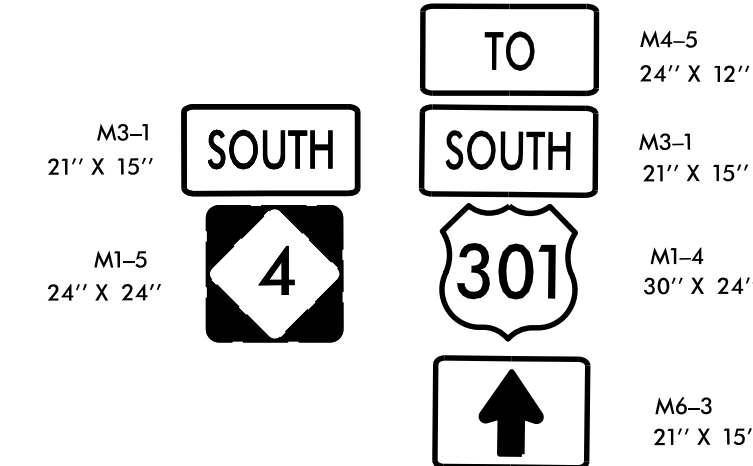


TWO "U" POSTS PER SIGN

513 QUANTITY REQ'D . 1 .

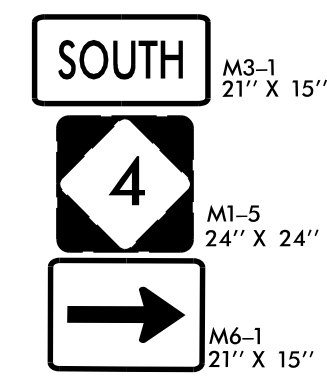


ONE "U" POSTS PER SIGN

504 QUANTITY REQ'D . 1 .

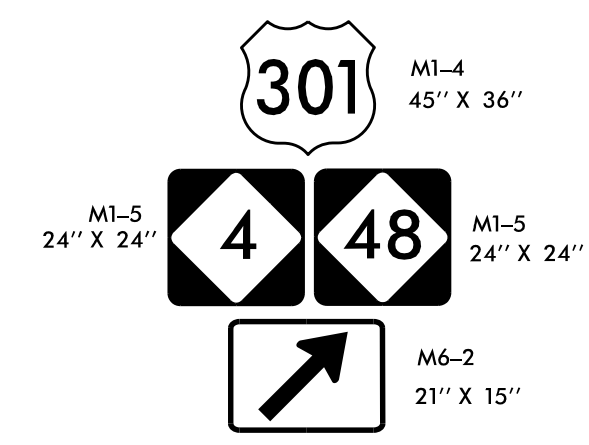


TWO "U" POSTS PER SIGN

509 QUANTITY REQ'D . 1 .

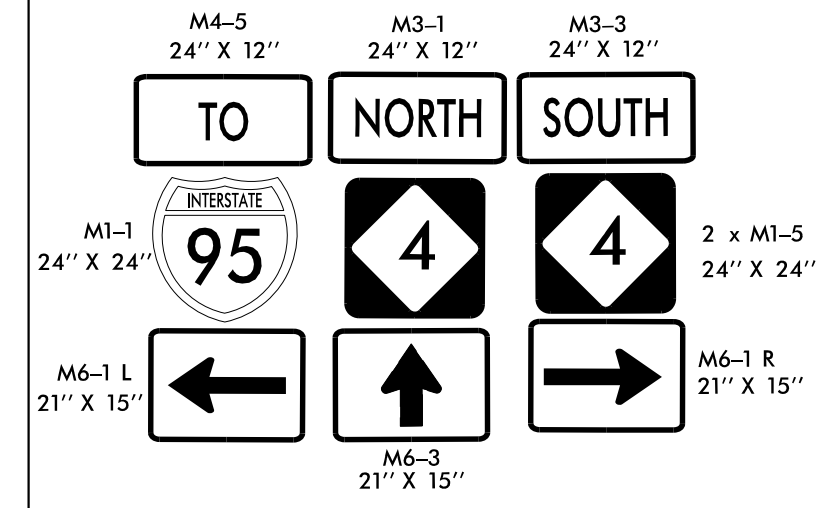


THREE "U" POSTS PER SIGN

505 QUANTITY REQ'D . 1 .

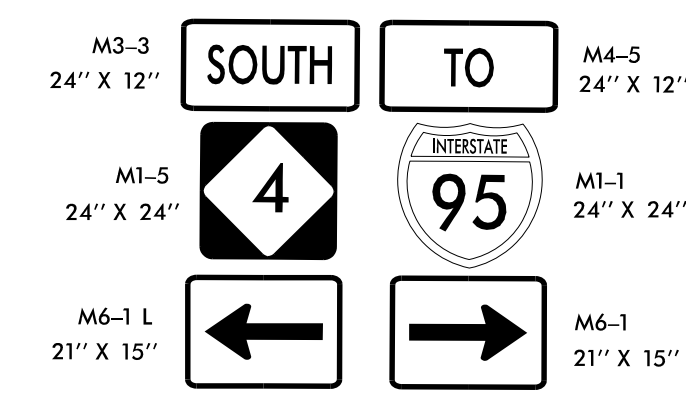

TWO "U" POSTS PER SIGN


510 QUANTITY REQ'D . 1 .


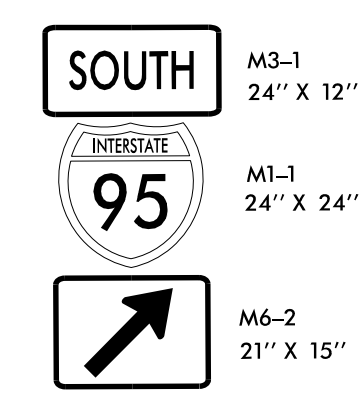


ONE "U" POSTS PER SIGN

TYPE "F" SIGNS

2/20/2020 10:11:16 AM TrafficControl\TC\B5980\_sign\_05.TYPE F.dgn User:Jeff.Koontz

TIP NO. B-5980	SHEET NO. SIGN-06
APPROVED: <i>Jeffrey A. Koonitz</i> 4/15/2020	
DATE: 4/15/2020	
SEAL	
	
<b>DOCUMENT NOT CONSIDERED FINAL UNLESS ALL SIGNATURES COMPLETED</b>	

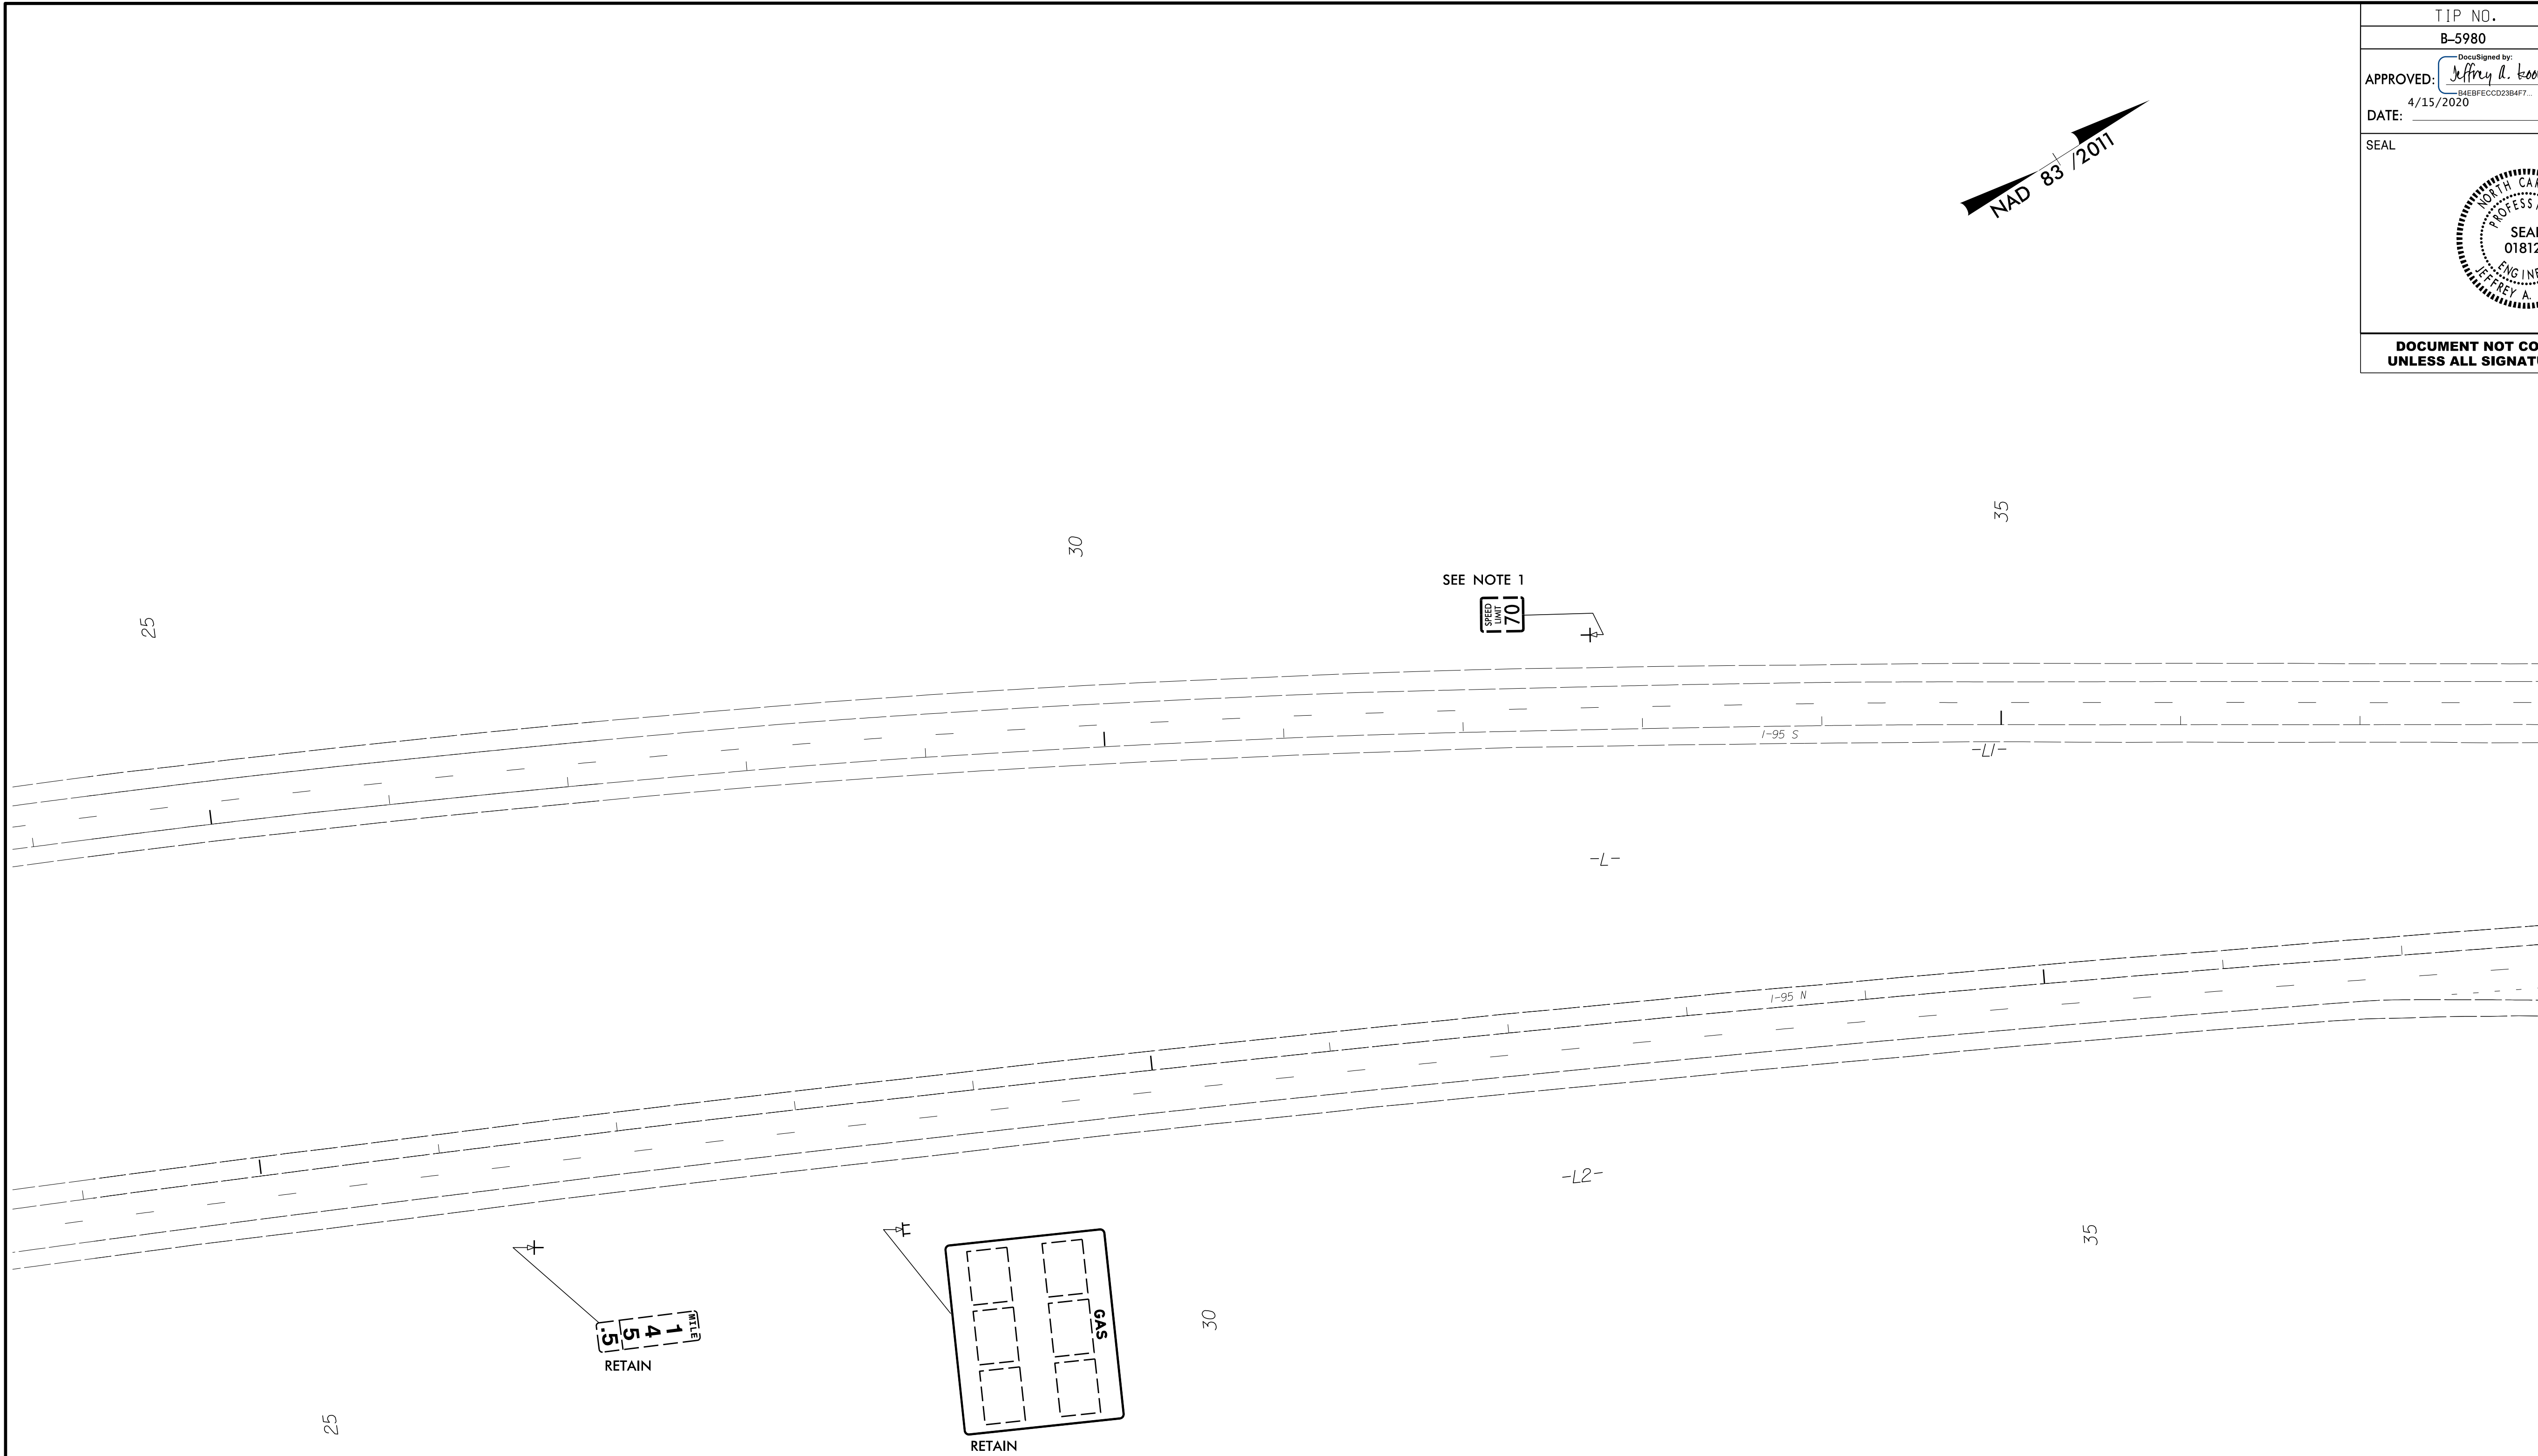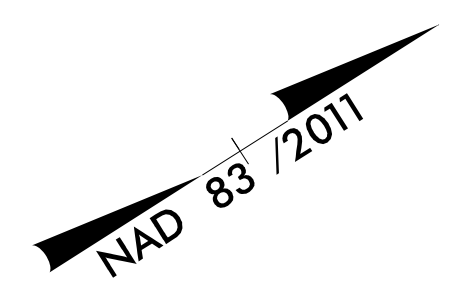

MATCHLINE -L1- STA 38+00 - SEE SHEET SIGN-07


**PROJECT NOTES**


1. DISPOSAL OF SIGN SYSTEM, U-CHANNEL
  2. NOT USED
  3. RELOCATE SIGN, TYPE E
  4. DISPOSAL OF SIGN, MILEMARKERS
  5. DISPOSAL OF SIGN, A OR B (OVERHEAD)
  6. DISPOSAL OF LIGHTING SYSTEM
  7. CONTACT DOUG DRAKE, DIVISION 4 LOGO  
COORDINATOR 252-640-6534
- ★ SIGNALIZED INTERSECTION

**EXISTING SIGNING**

-L1- 23+60 STA TO -L1- STA 38+00

2/20/2020  
R:\Traffic\TrafficControl\TCP\B5980\_sign\_06\_EXISTING.dgn  
User: jkoonitz

TIP NO. B-5980	SHEET NO. SIGN-07
APPROVED: <i>Jeffrey A. Koonitz</i> 4/15/2020	
DATE: 4/15/2020	
SEAL	
	
DOCUMENT NOT CONSIDERED FINAL UNLESS ALL SIGNATURES COMPLETED	

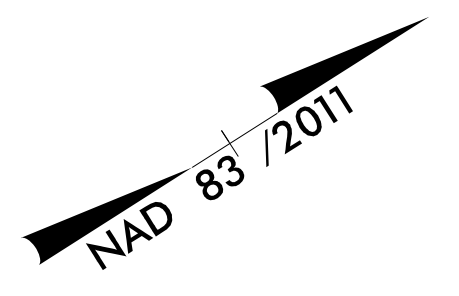






**BREAKLINE**

**MATCHLINE -L1- STA 38 + 00 - SEE SHEET SIGN-06**

**MATCHLINE -L1- STA 50 + 00  
SEE SHEET SIGN-08**

**MATCHLINE -RPC- STA 20 + 00  
SEE SHEET SIGN-17**


- PROJECT NOTES**
1. DISPOSAL OF SIGN SYSTEM, U-CHANNEL
  2. NOT USED
  3. RELOCATE SIGN, TYPE E
  4. DISPOSAL OF SIGN, MILEMARKERS
  5. DISPOSAL OF SIGN, A OR B (OVERHEAD)
  6. DISPOSAL OF LIGHTING SYSTEM
  7. CONTACT DOUG DRAKE, DIVISION 4 LOGO  
COORDINATOR 252-640-6534
- ★ SIGNALIZED INTERSECTION

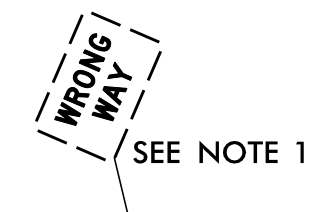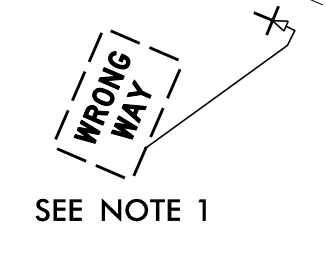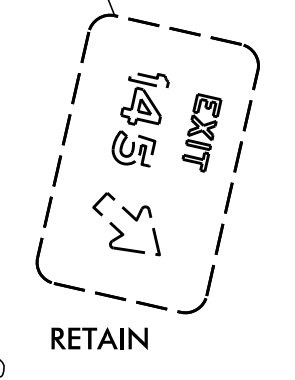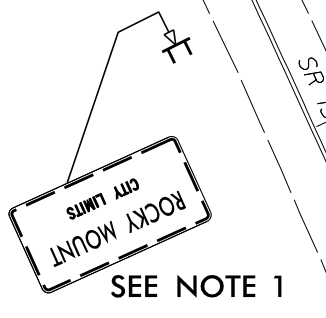
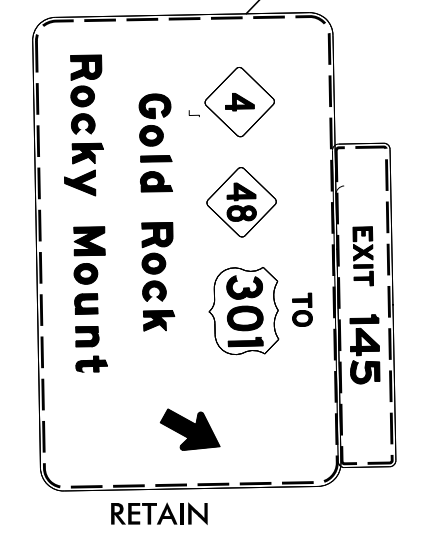


**BREAKLINE**

2/20/2020  
 R:\TrafficControl\TCP\B5980\_sign\_07\_EXISTING.dgn  
 User: jkoo12

**EXISTING SIGNING**  
-L1- 23+60 STA TO -L1- STA 50+00

TIP NO. B-5980	SHEET NO. SIGN-08
APPROVED: <i>Jeffrey A. Koomtz</i> 4/15/2020	
DATE: 4/15/2020	
SEAL 	
DOCUMENT NOT CONSIDERED FINAL UNLESS ALL SIGNATURES COMPLETED	

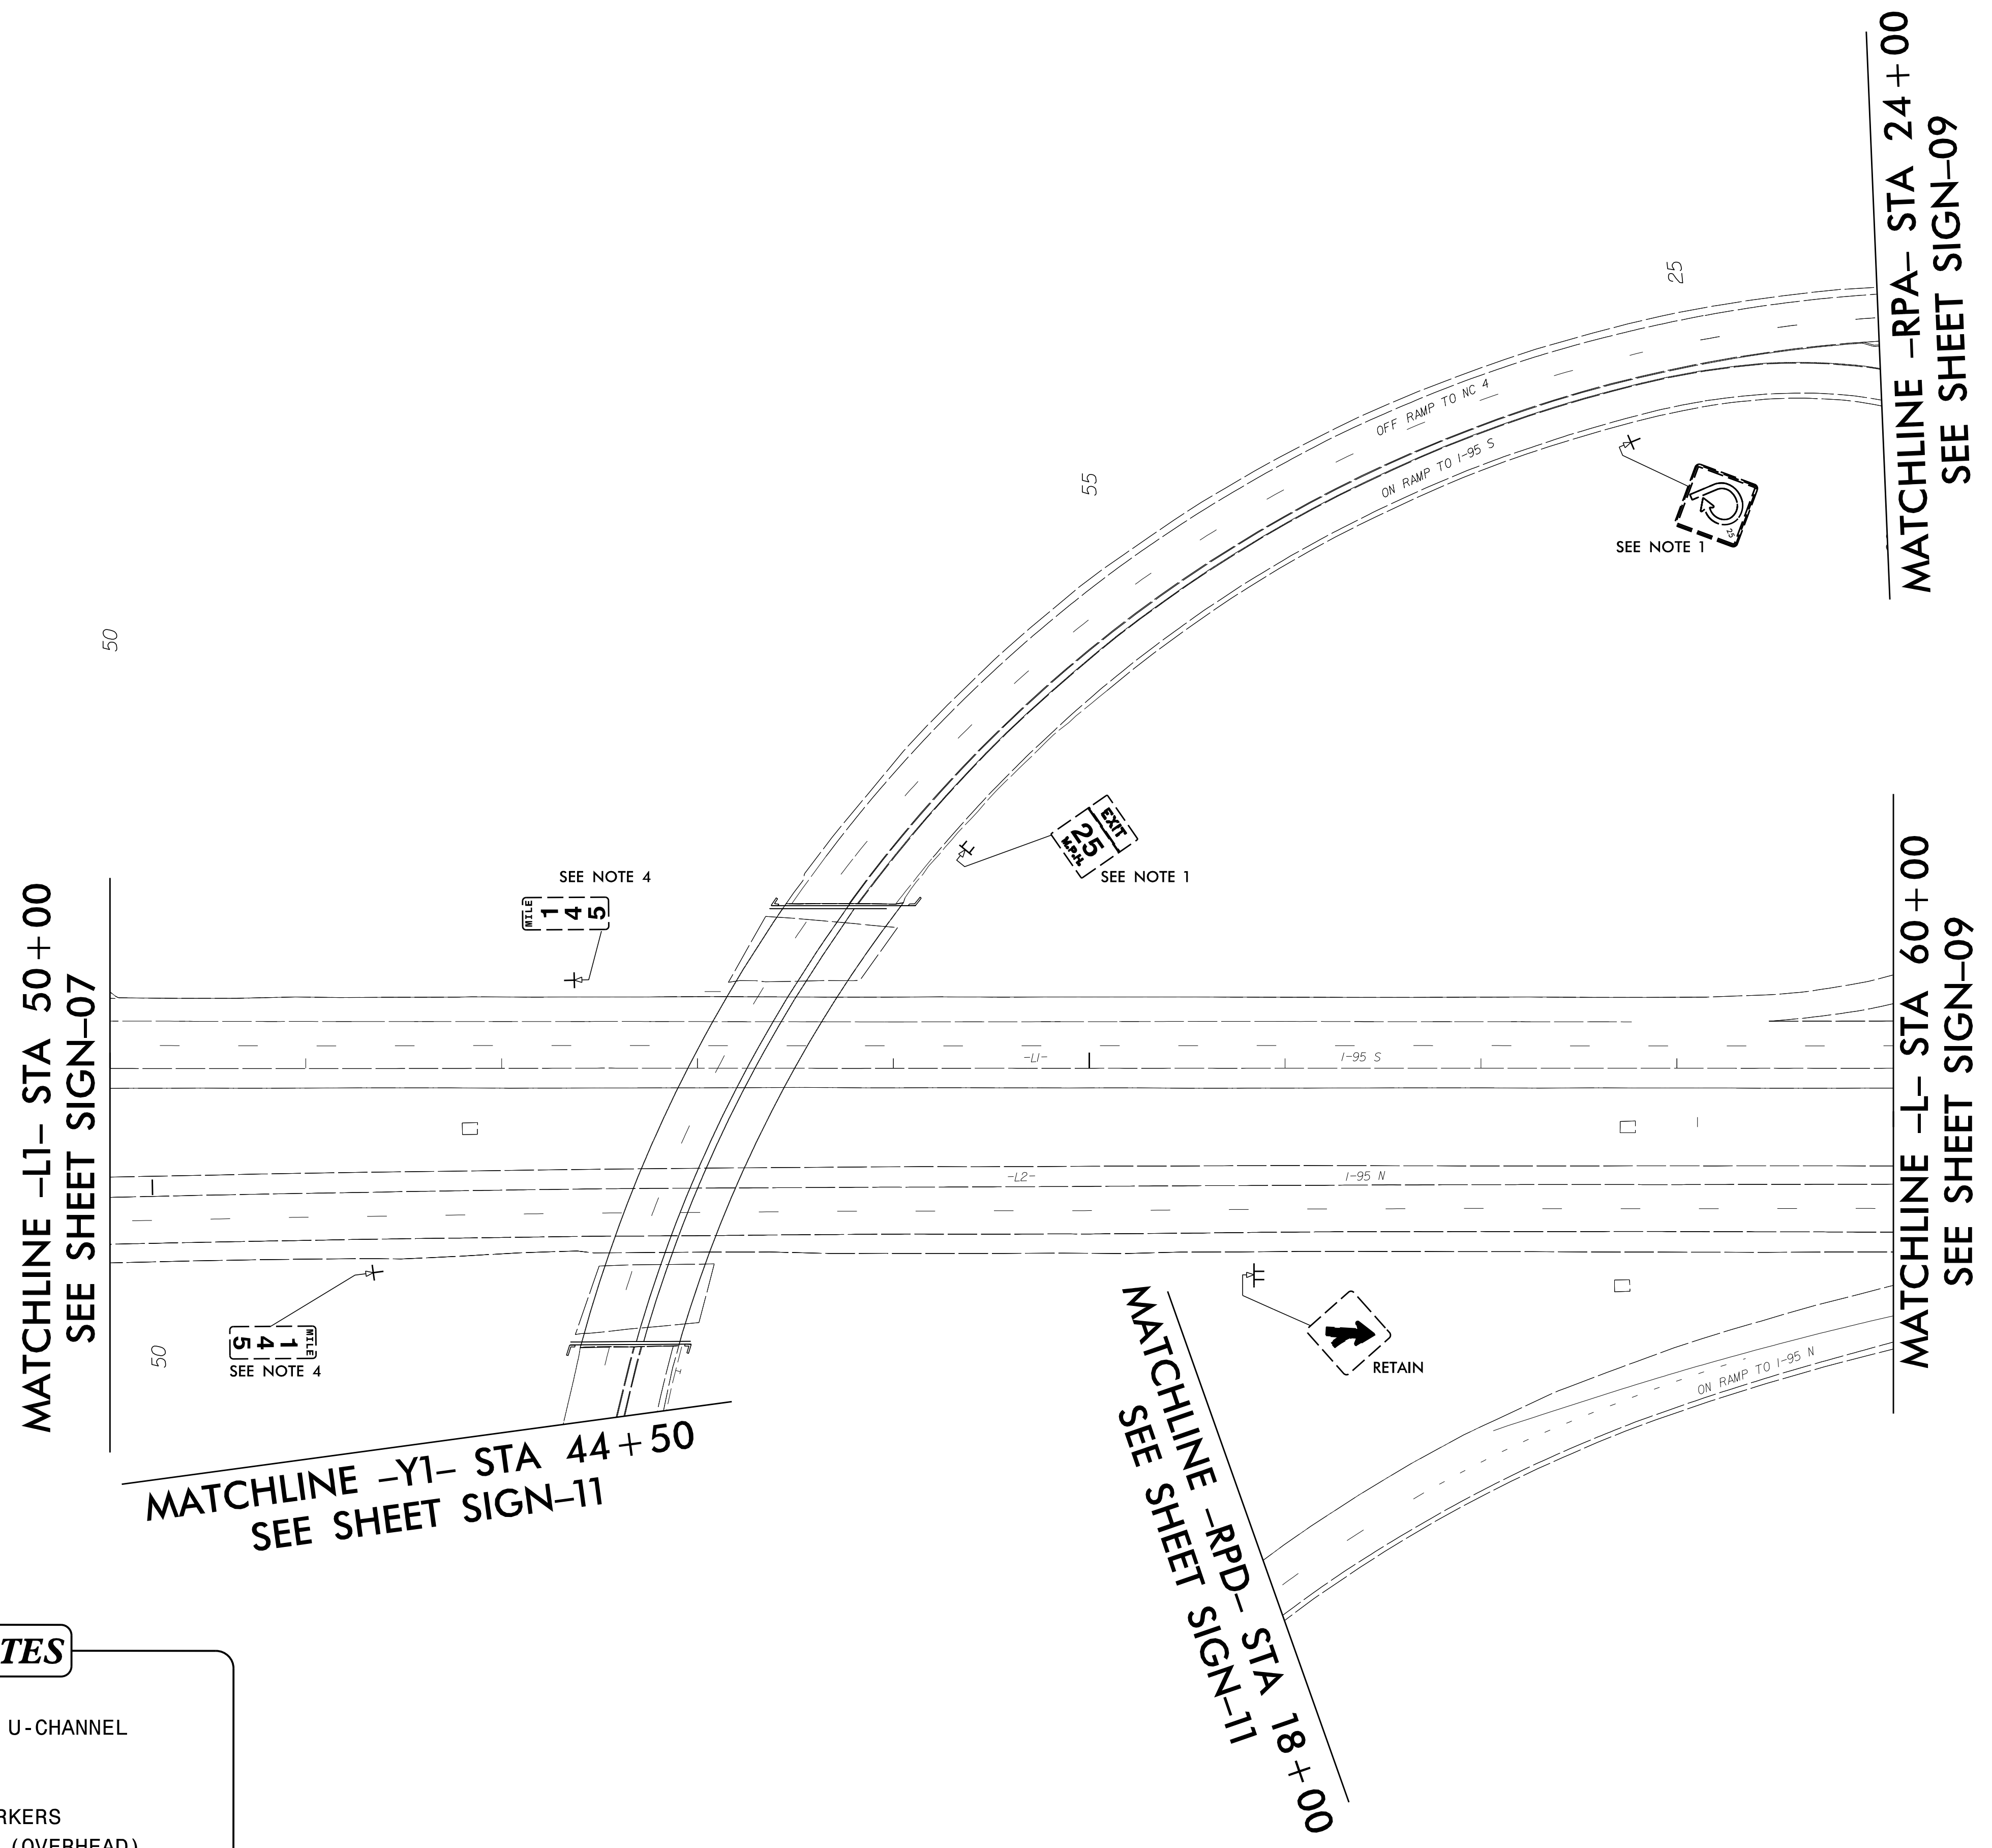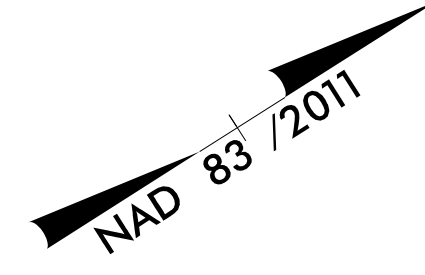

**PROJECT NOTES**

1. DISPOSAL OF SIGN SYSTEM, U-CHANNEL
  2. NOT USED
  3. RELOCATE SIGN, TYPE E
  4. DISPOSAL OF SIGN, MILEMARKERS
  5. DISPOSAL OF SIGN, A OR B (OVERHEAD)
  6. DISPOSAL OF LIGHTING SYSTEM
  7. CONTACT DOUG DRAKE, DIVISION 4 LOGO  
COORDINATOR 252-640-6534
- ★ SIGNALIZED INTERSECTION

**EXISTING SIGNING**  
-L1- 50+00 STA TO -L1- STA 60+00


2/20/2020  
 R:\TrafficControl\TCP\B5980\_sign\_08\_EXISTING.dgn  
 User: jkoomtz

TIP NO. B-5980	SHEET NO. SIGN-09
APPROVED: <i>Jeffrey A. Kootz</i> 4/15/2020	
DATE: 4/15/2020	
SEAL	
DOCUMENT NOT CONSIDERED FINAL UNLESS ALL SIGNATURES COMPLETED	

MATCHLINE -RPA- STA 24+00  
SEE SHEET SIGN-08


MATCHLINE -L- STA 60+00 - SEE SHEET SIGN-08

- PROJECT NOTES**
1. DISPOSAL OF SIGN SYSTEM, U-CHANNEL
  2. NOT USED
  3. RELOCATE SIGN, TYPE E
  4. DISPOSAL OF SIGN, MILEMARKERS
  5. DISPOSAL OF SIGN, A OR B (OVERHEAD)
  6. DISPOSAL OF LIGHTING SYSTEM
  7. CONTACT DOUG DRAKE, DIVISION 4 LOGO COORDINATOR 252-640-6534
- ★ SIGNALIZED INTERSECTION

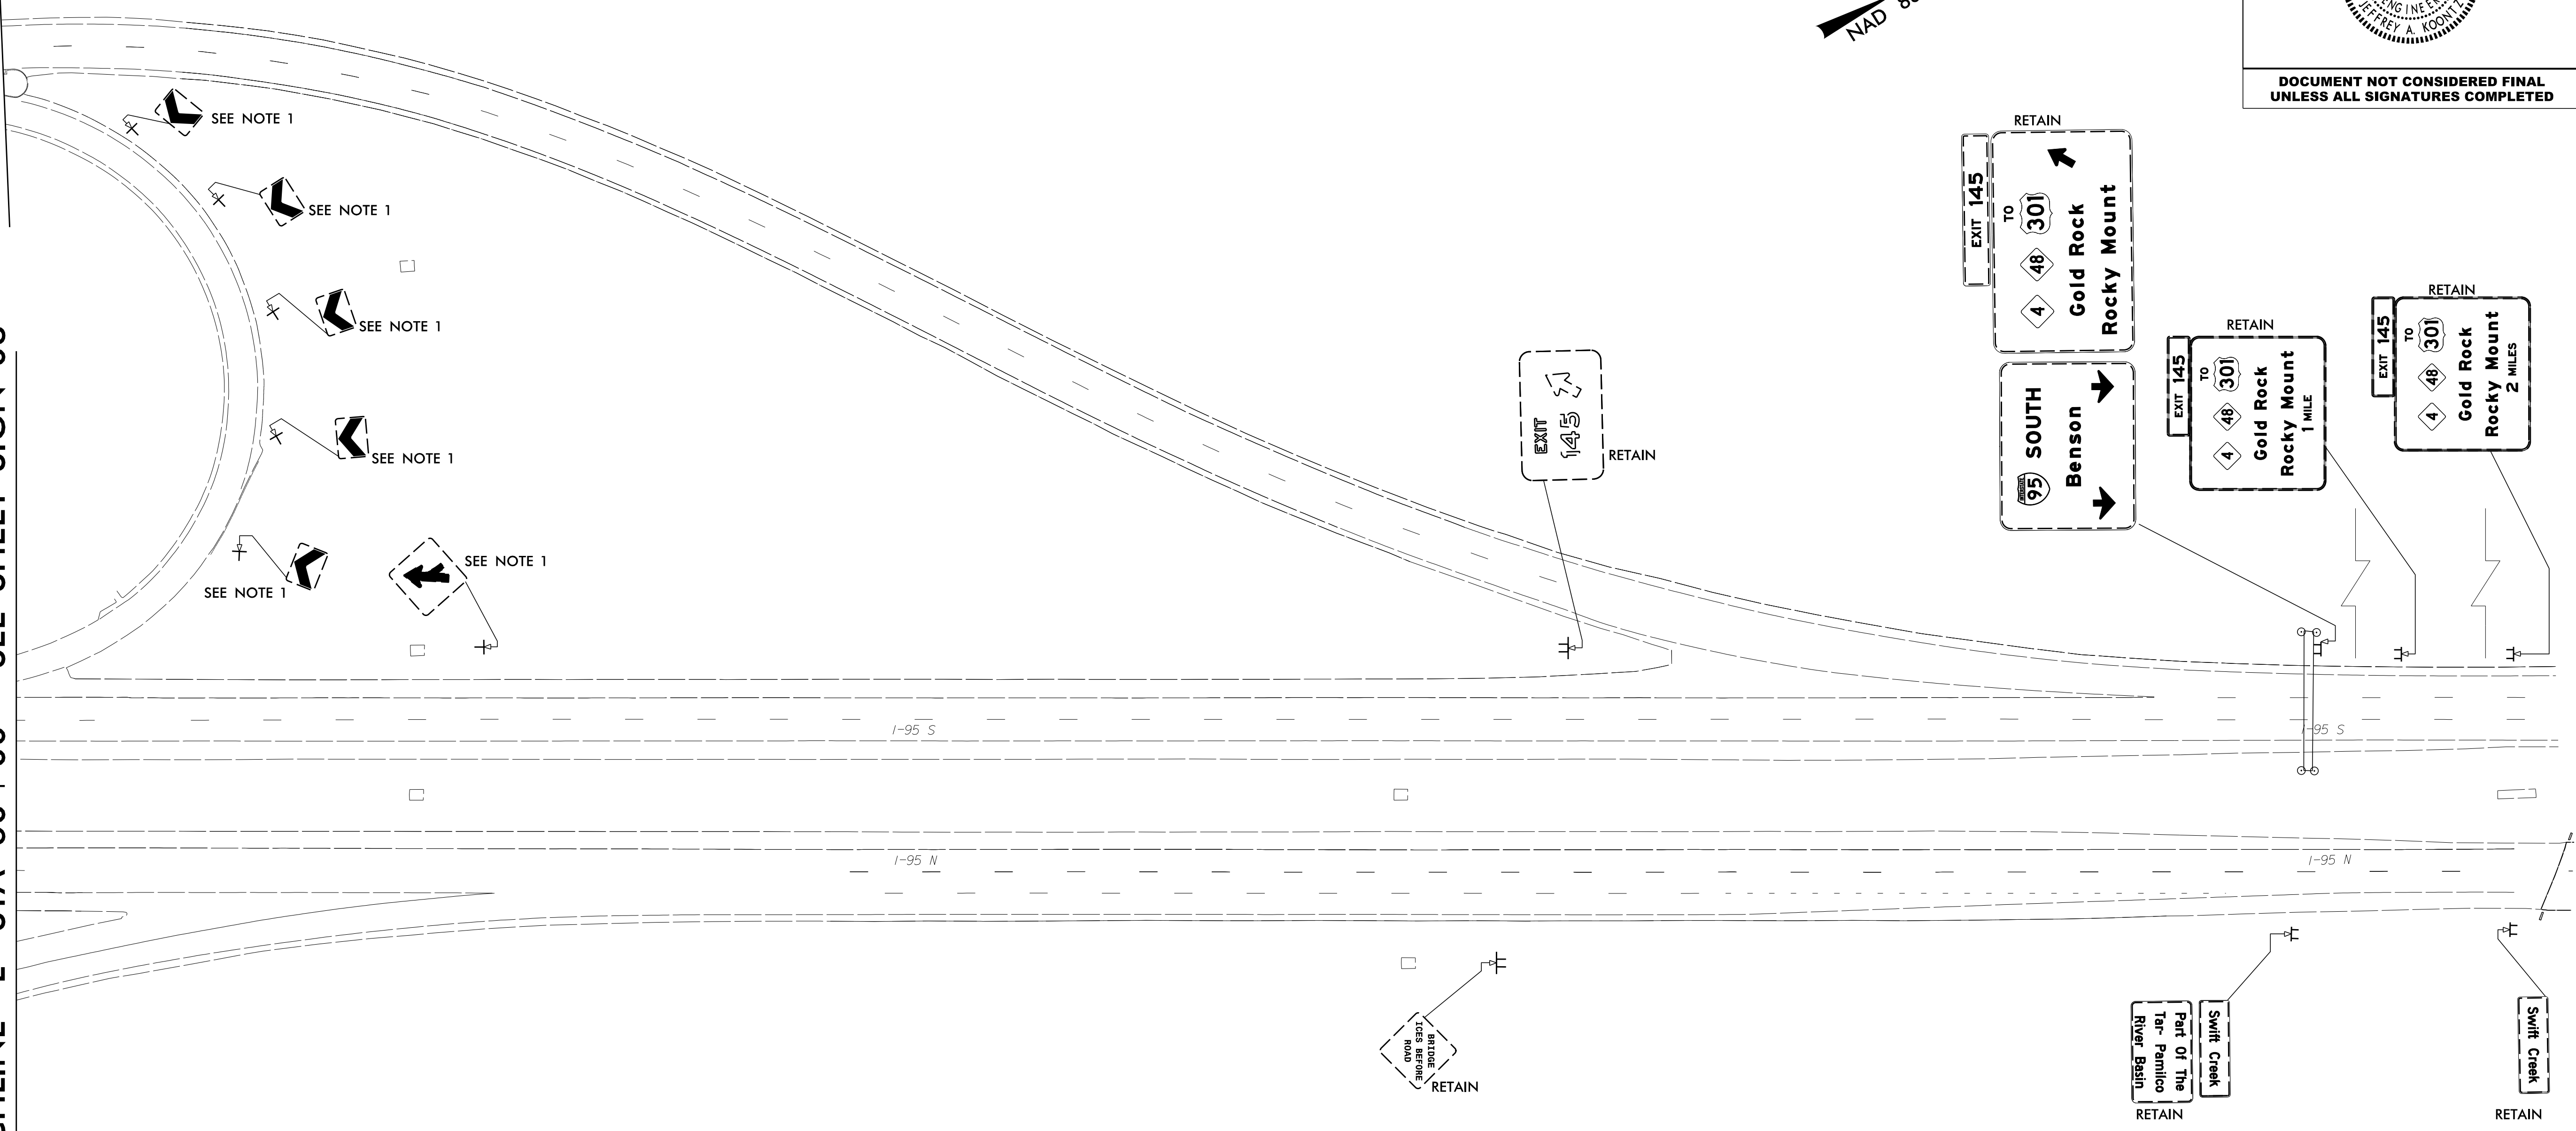


**EXISTING SIGNING**  
-L1- 60+00 STA TO -L1- STA 74+00

2/20/2020  
R:\TrafficControl\TCP\B5980\_sign\_09\_EXISTING.dgn  
User: jkootz

TIP NO.	SHEET NO.
B-5980	SIGN-10
APPROVED: <i>Jeffrey A. Koonitz</i>	
DATE: 4/15/2020	
SEAL	
	
<b>DOCUMENT NOT CONSIDERED FINAL UNLESS ALL SIGNATURES COMPLETED</b>	

SPACE PURPOSELY LEFT BLANK

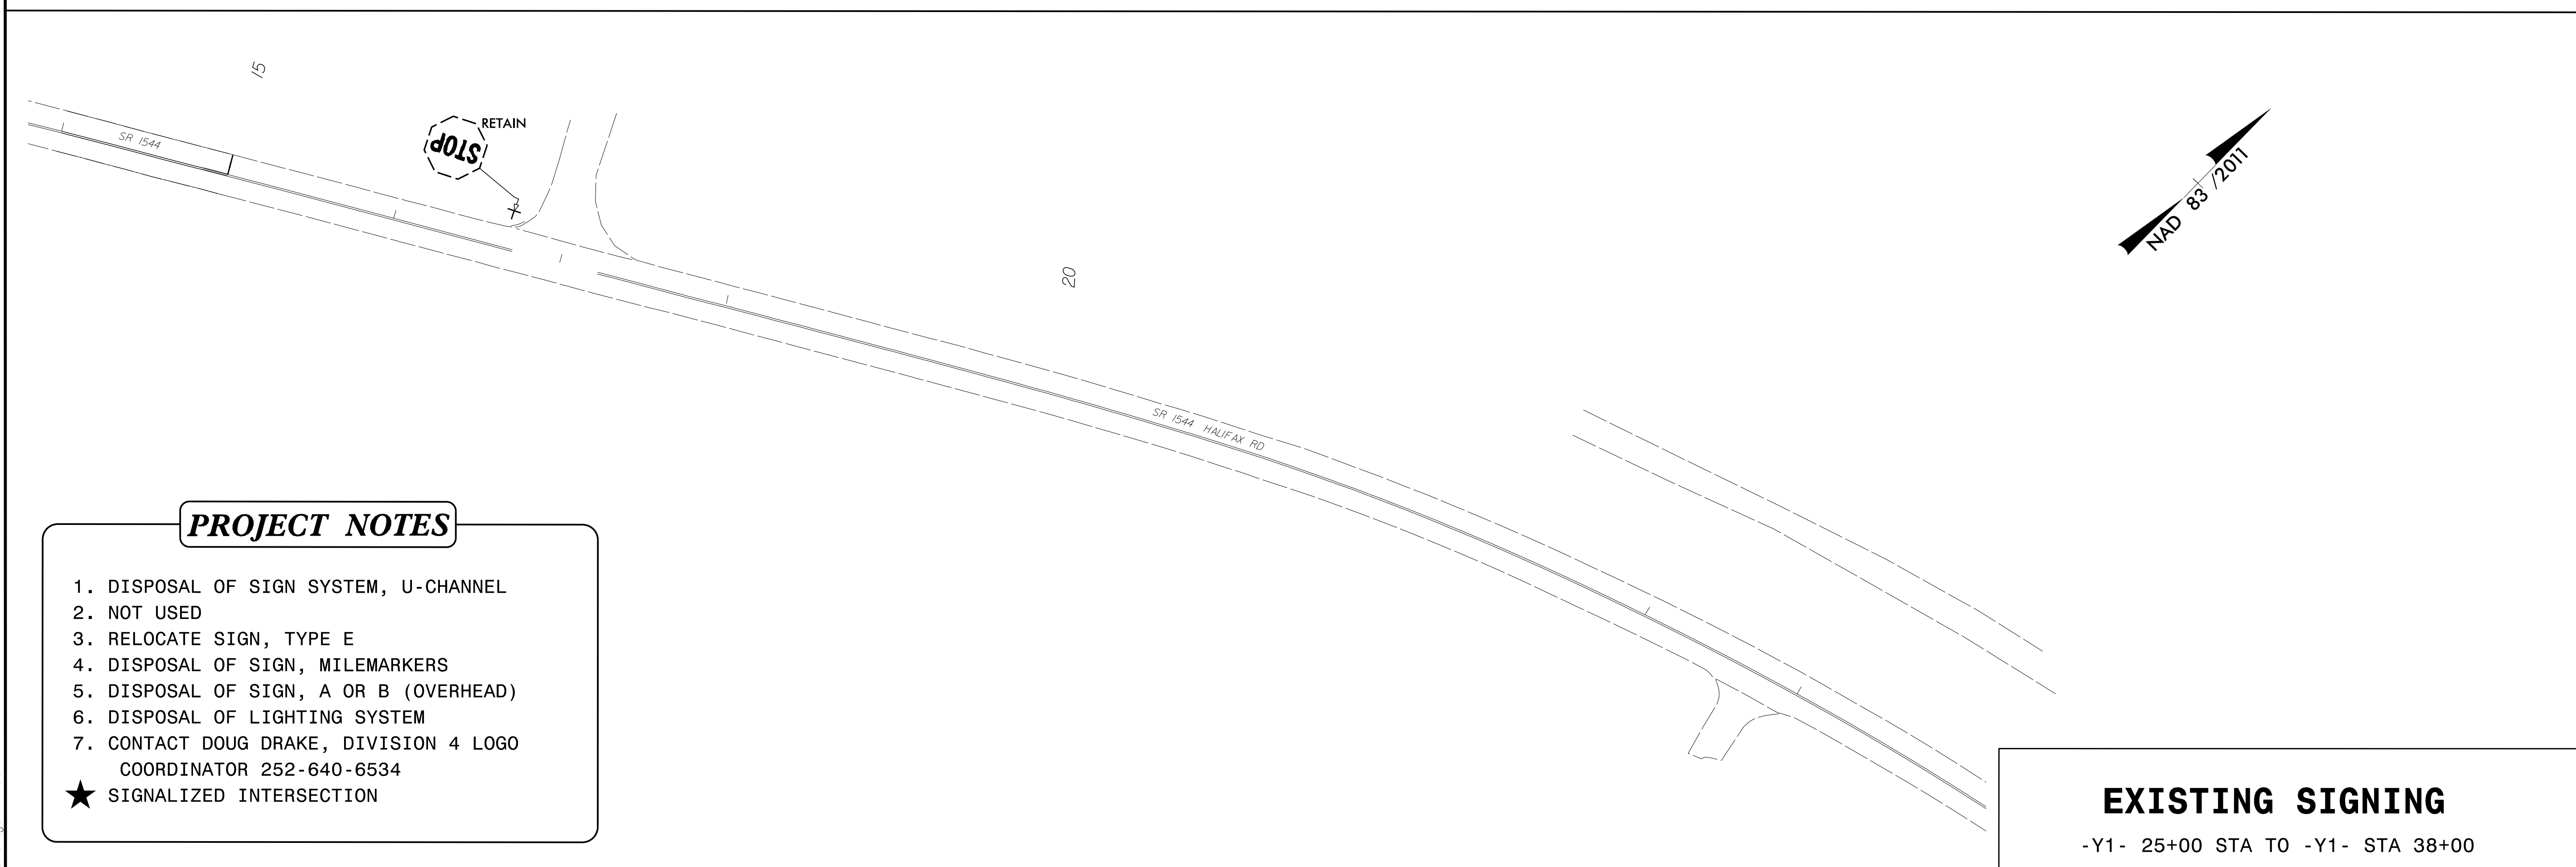


**PROJECT NOTES**

1. DISPOSAL OF SIGN SYSTEM, U-CHANNEL
  2. NOT USED
  3. RELOCATE SIGN, TYPE E
  4. DISPOSAL OF SIGN, MILEMARKERS
  5. DISPOSAL OF SIGN, A OR B (OVERHEAD)
  6. DISPOSAL OF LIGHTING SYSTEM
  7. CONTACT DOUG DRAKE, DIVISION 4 LOGO  
COORDINATOR 252-640-6534
- ★ SIGNALIZED INTERSECTION

**EXISTING SIGNING**

-Y1- 25+00 STA TO -Y1- STA 38+00

2/20/2020  
R:\Traffic\TrafficControl\TCP\B5980\_sign\_10\_EXISTING.dgn  
User: jkoonitz

TIP NO. B-5980	SHEET NO. SIGN-11
APPROVED: <i>Jeffrey A. Kootnik</i> 4/15/2020	
DATE: 4/15/2020	
SEAL	
	
DOCUMENT NOT CONSIDERED FINAL UNLESS ALL SIGNATURES COMPLETED	




MATCHLINE -RPD- STA 18+00  
SEE SHEET SIGN-08

MATCHLINE -Y1- STA 44+50  
SEE SHEET SIGN-08


MATCHLINE -RPC- STA 20+00  
SEE SHEET SIGN-07


MATCHLINE -Y1- STA 57+00  
SEE SHEET SIGN-12

- PROJECT NOTES**
1. DISPOSAL OF SIGN SYSTEM, U-CHANNEL
  2. NOT USED
  3. RELOCATE SIGN, TYPE E
  4. DISPOSAL OF SIGN, MILEMARKERS
  5. DISPOSAL OF SIGN, A OR B (OVERHEAD)
  6. DISPOSAL OF LIGHTING SYSTEM
  7. CONTACT DOUG DRAKE, DIVISION 4 LOGO COORDINATOR 252-640-6534
- ★ SIGNALIZED INTERSECTION

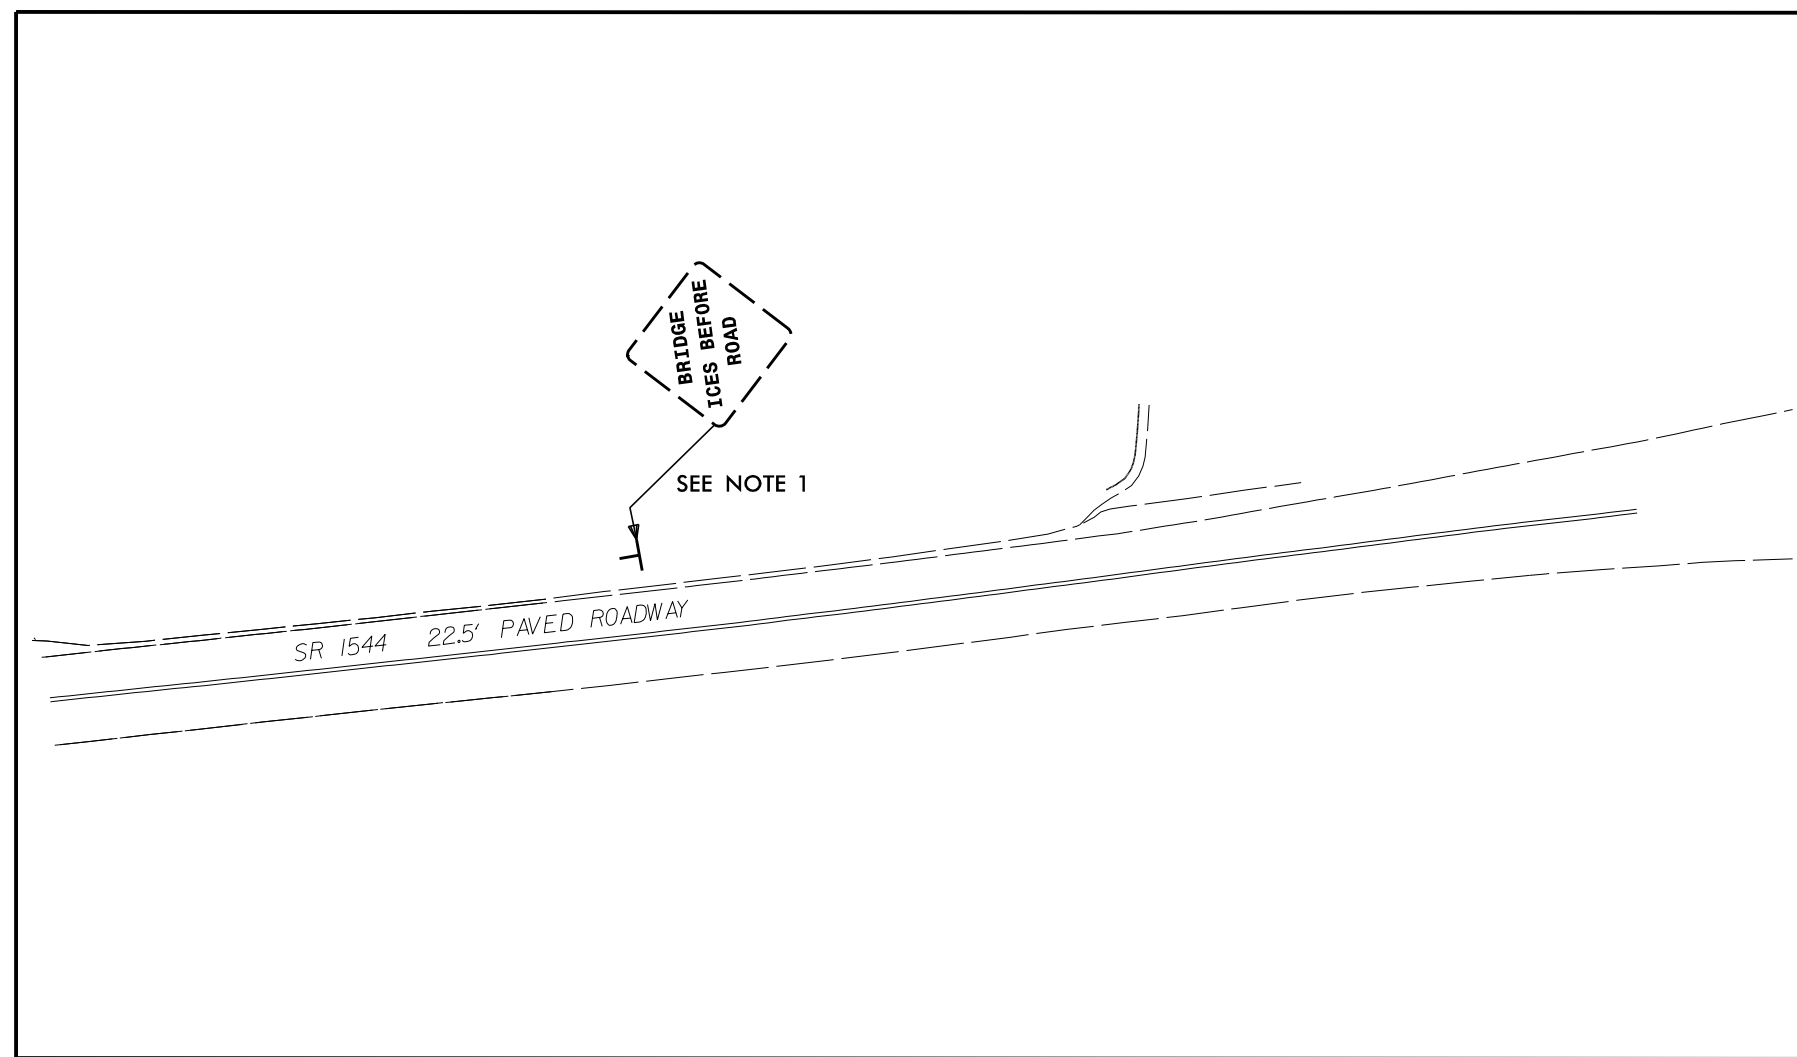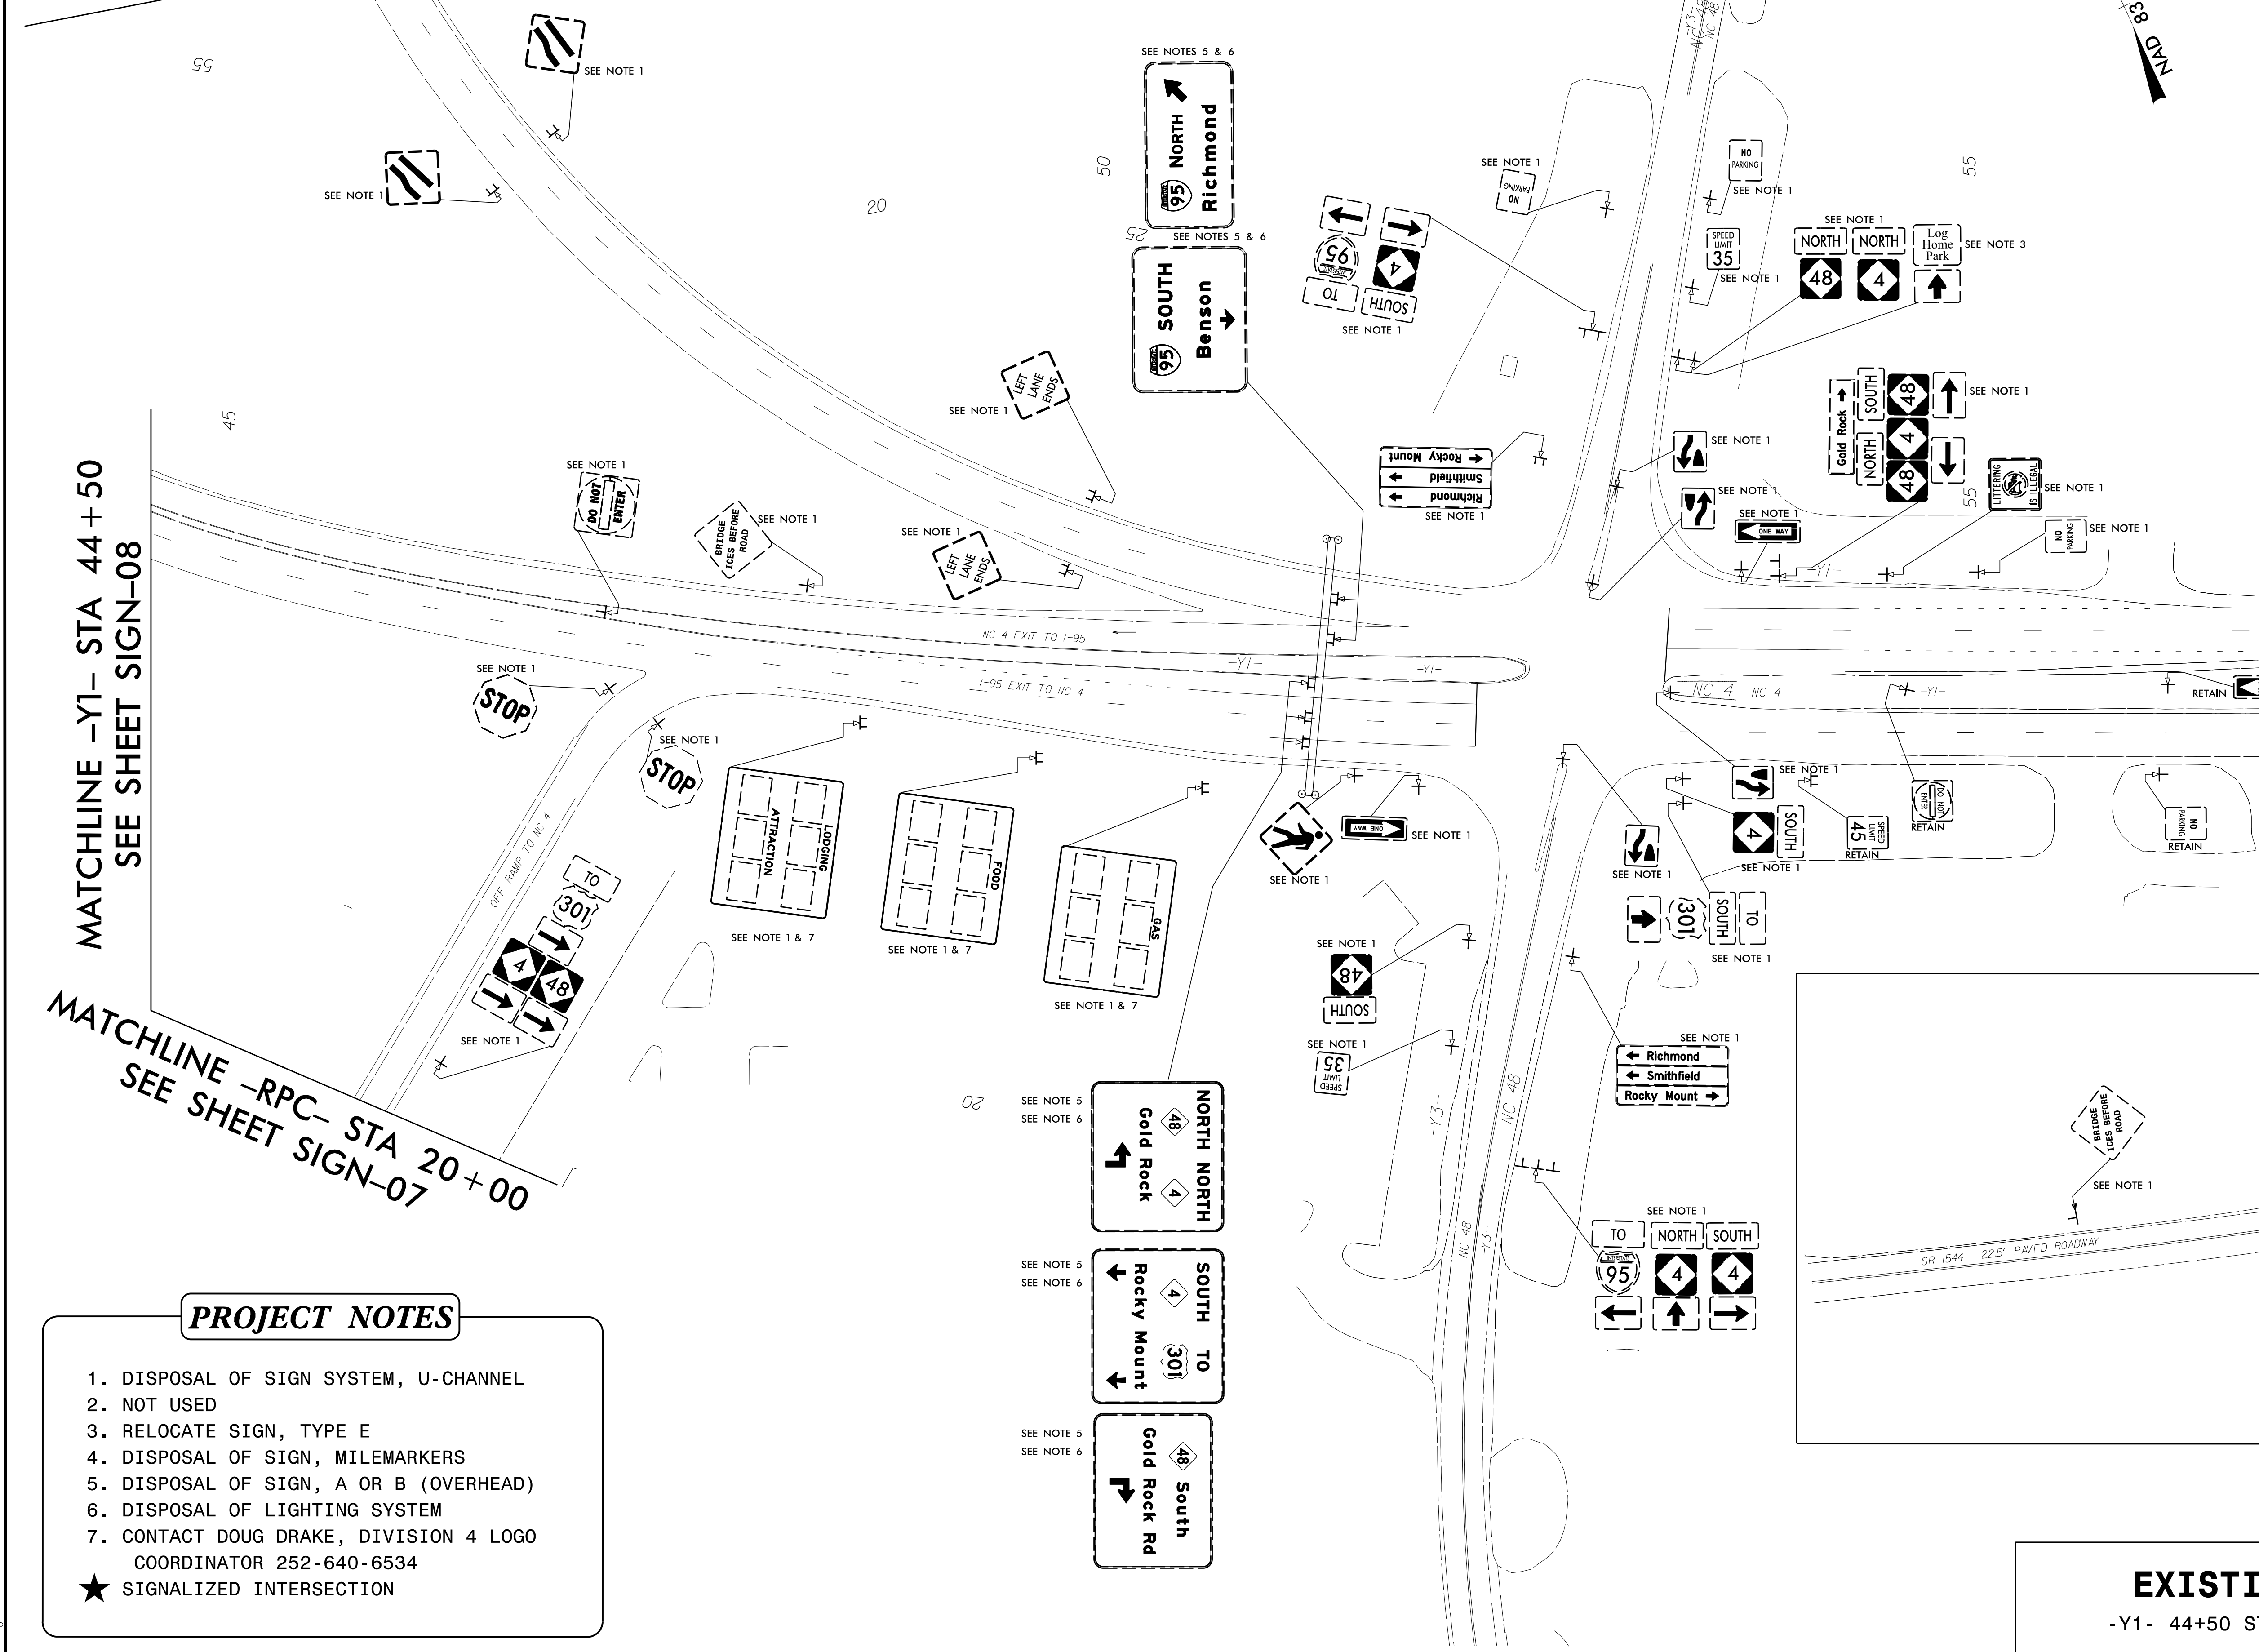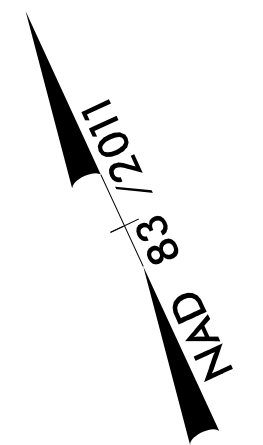


2/20/2020  
 R:\Traffic\TrafficControl\TCP\B5980\_sign\_11\_EXISTING.dgn  
 User:Jeff.Kootnik

TIP NO. B-5980	SHEET NO. SIGN-12
APPROVED: <i>Jeffrey A. Koomtz</i> 4/15/2020	
SEAL	
	
<b>DOCUMENT NOT CONSIDERED FINAL UNLESS ALL SIGNATURES COMPLETED</b>	

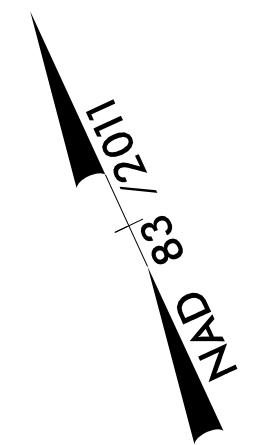

MATCHLINE -Y1- STA 57+00  
SEE SHEET SIGN-11

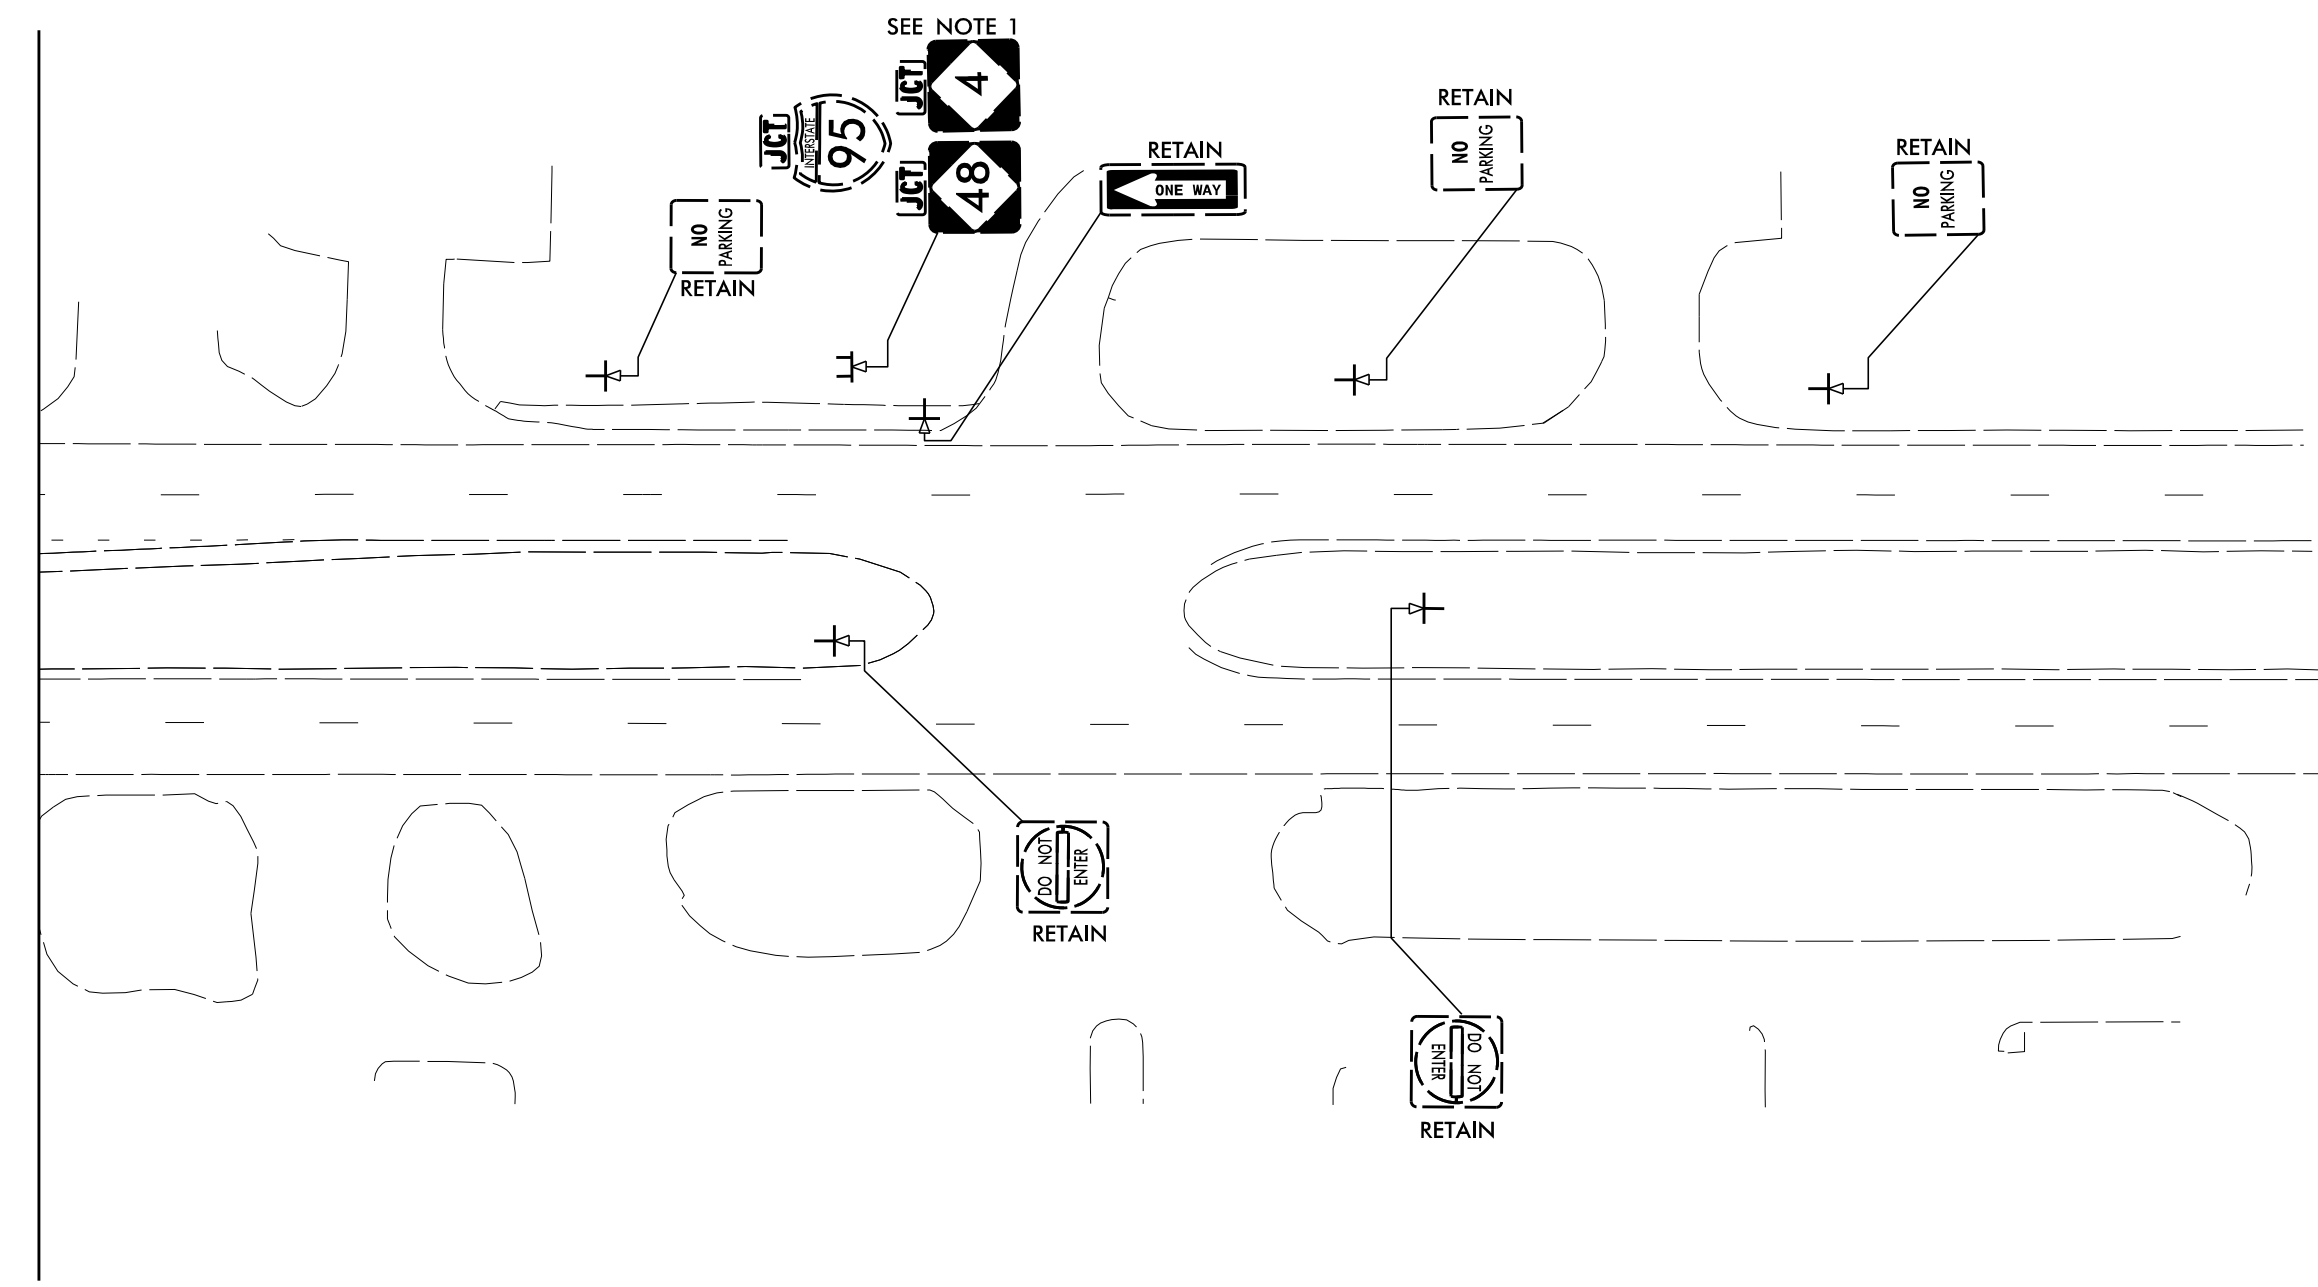

**PROJECT NOTES**



1. DISPOSAL OF SIGN SYSTEM, U-CHANNEL
  2. NOT USED
  3. RELOCATE SIGN, TYPE E
  4. DISPOSAL OF SIGN, MILEMARKERS
  5. DISPOSAL OF SIGN, A OR B (OVERHEAD)
  6. DISPOSAL OF LIGHTING SYSTEM
  7. CONTACT DOUG DRAKE, DIVISION 4 LOGO  
COORDINATOR 252-640-6534
- ★ SIGNALIZED INTERSECTION

2/20/2020  
F:\Traffic\TrafficControl\TCP\B5980\_sign\_12\_EXISTING.dgn  
User: jkoomtz

**EXISTING SIGNING**  
-Y1- 57+00 STA TO -Y1- STA 69+90



TIP NO. B-5980	SHEET NO. SIGN-13
APPROVED: <i>Jeffrey A. Kootz</i> 4/15/2020	
DATE: 4/15/2020	
SEAL	
DOCUMENT NOT CONSIDERED FINAL UNLESS ALL SIGNATURES COMPLETED	

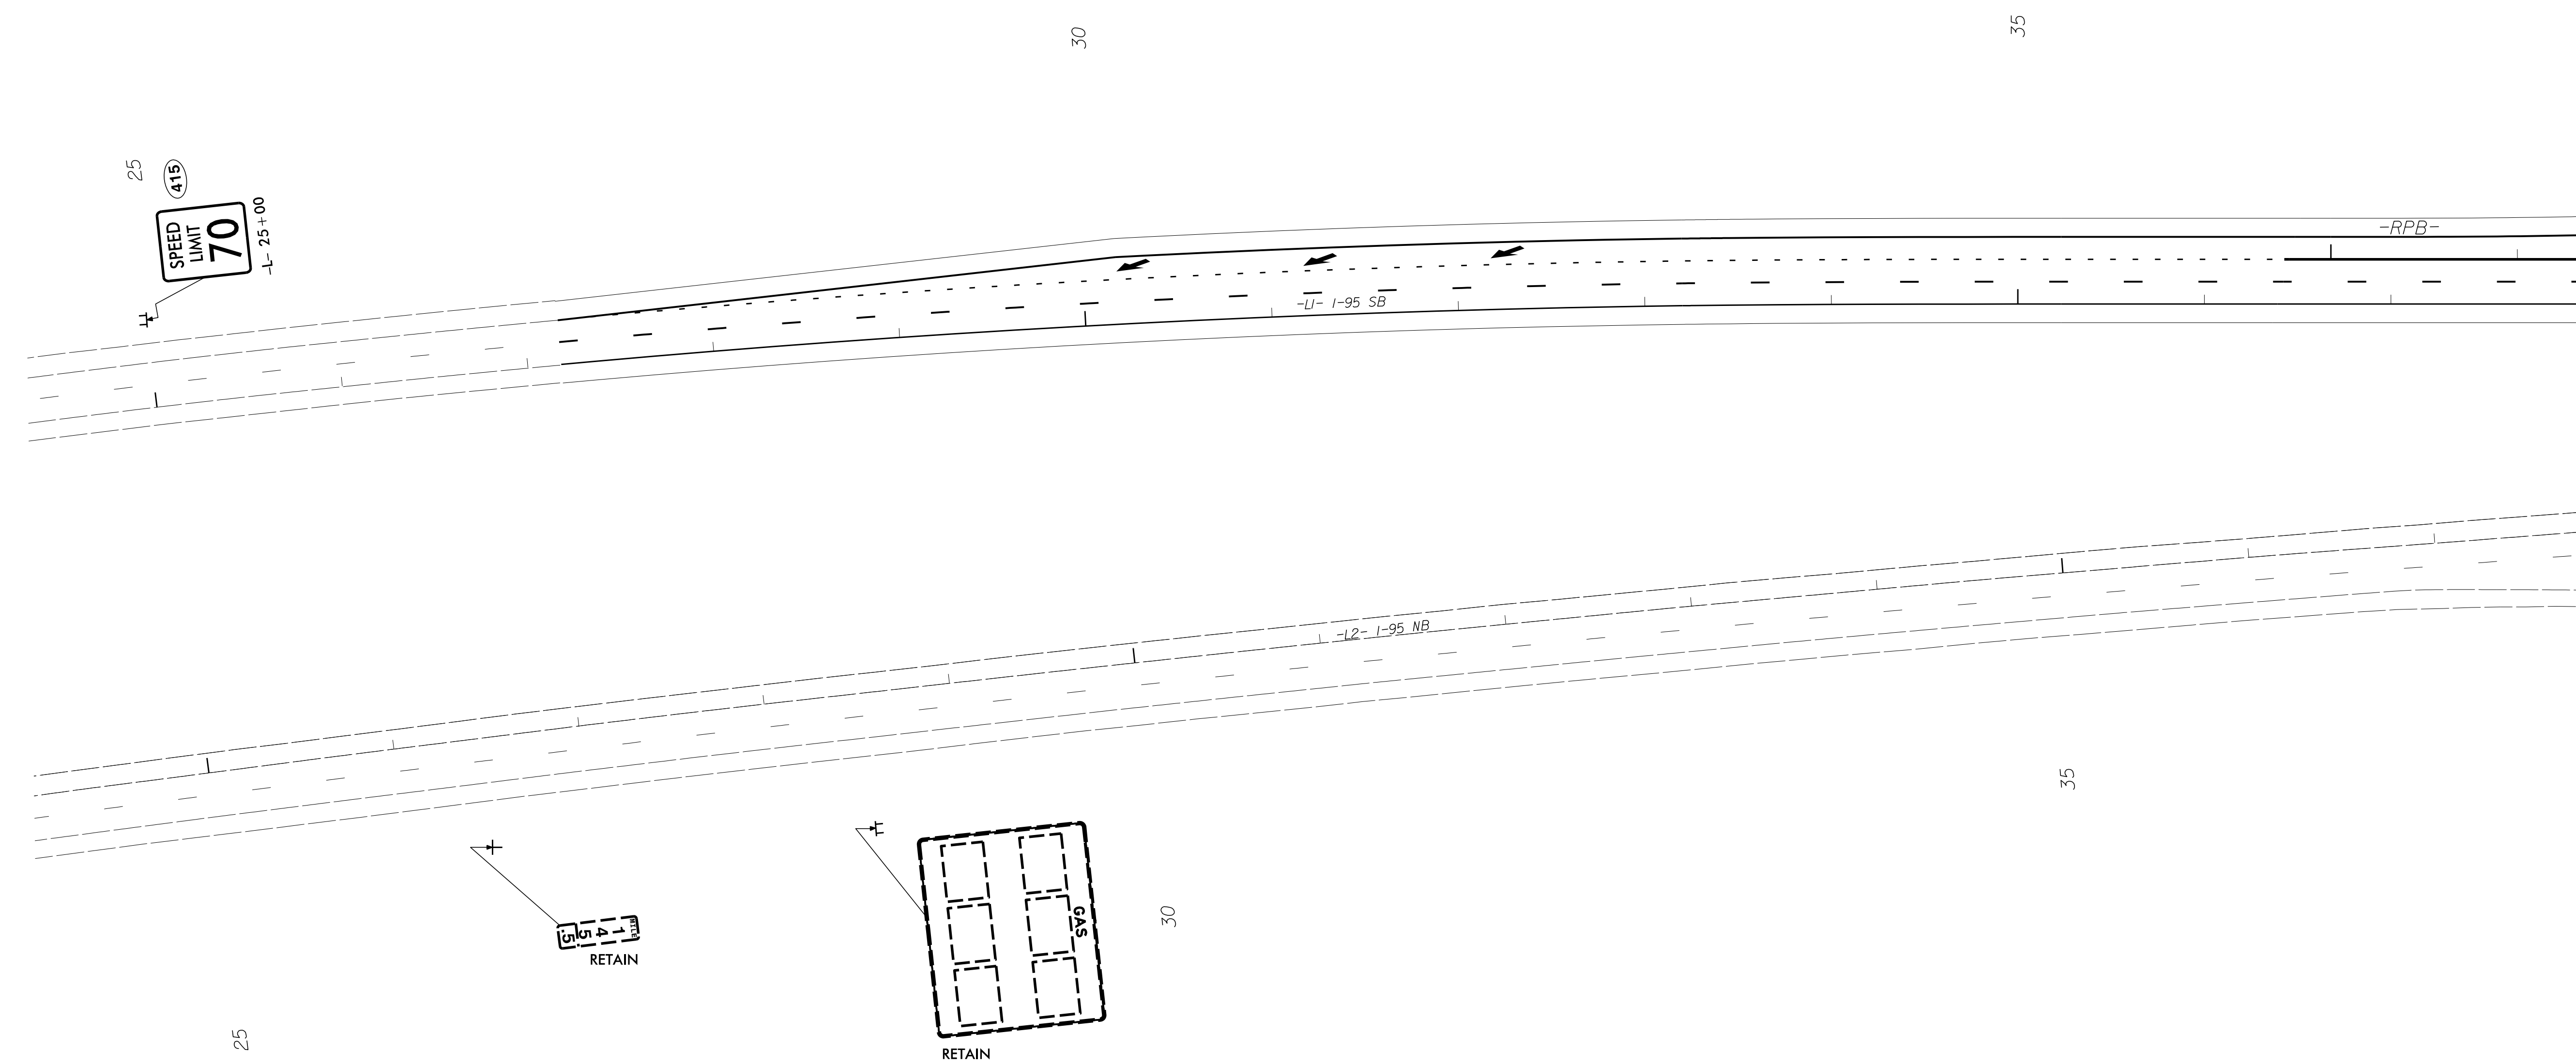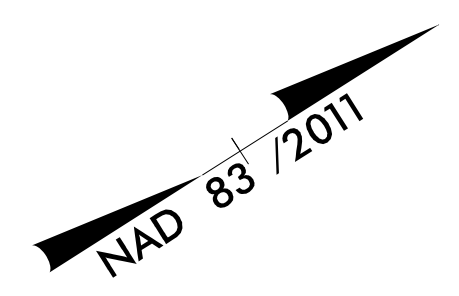


MATCHLINE -L1- STA 38+00 - SEE SHEET SIGN-14


**PROJECT NOTES**

1. DISPOSAL OF SIGN SYSTEM, U-CHANNEL
  2. NOT USED
  3. RELOCATE SIGN, TYPE E
  4. DISPOSAL OF SIGN, MILEMARKERS
  5. DISPOSAL OF SIGN, A OR B (OVERHEAD)
  6. DISPOSAL OF LIGHTING SYSTEM
  7. CONTACT DOUG DRAKE, DIVISION 4 LOGO  
COORDINATOR 252-640-6534
- ★ SIGNALIZED INTERSECTION

**PROPOSED SIGNING**  
-L1- 23+60 STA TO -L1- STA 38+00

2/20/2020  
R:\Traffic\TrafficControl\TCP\B5980\_sign\_13\_PROPOSED.dgn  
User: jkootz

TIP NO. B-5980	SHEET NO. SIGN-14
APPROVED: <i>Jeffrey A. Kootz</i> 4/15/2020	
DATE: 4/15/2020	
SEAL 	
DOCUMENT NOT CONSIDERED FINAL UNLESS ALL SIGNATURES COMPLETED	

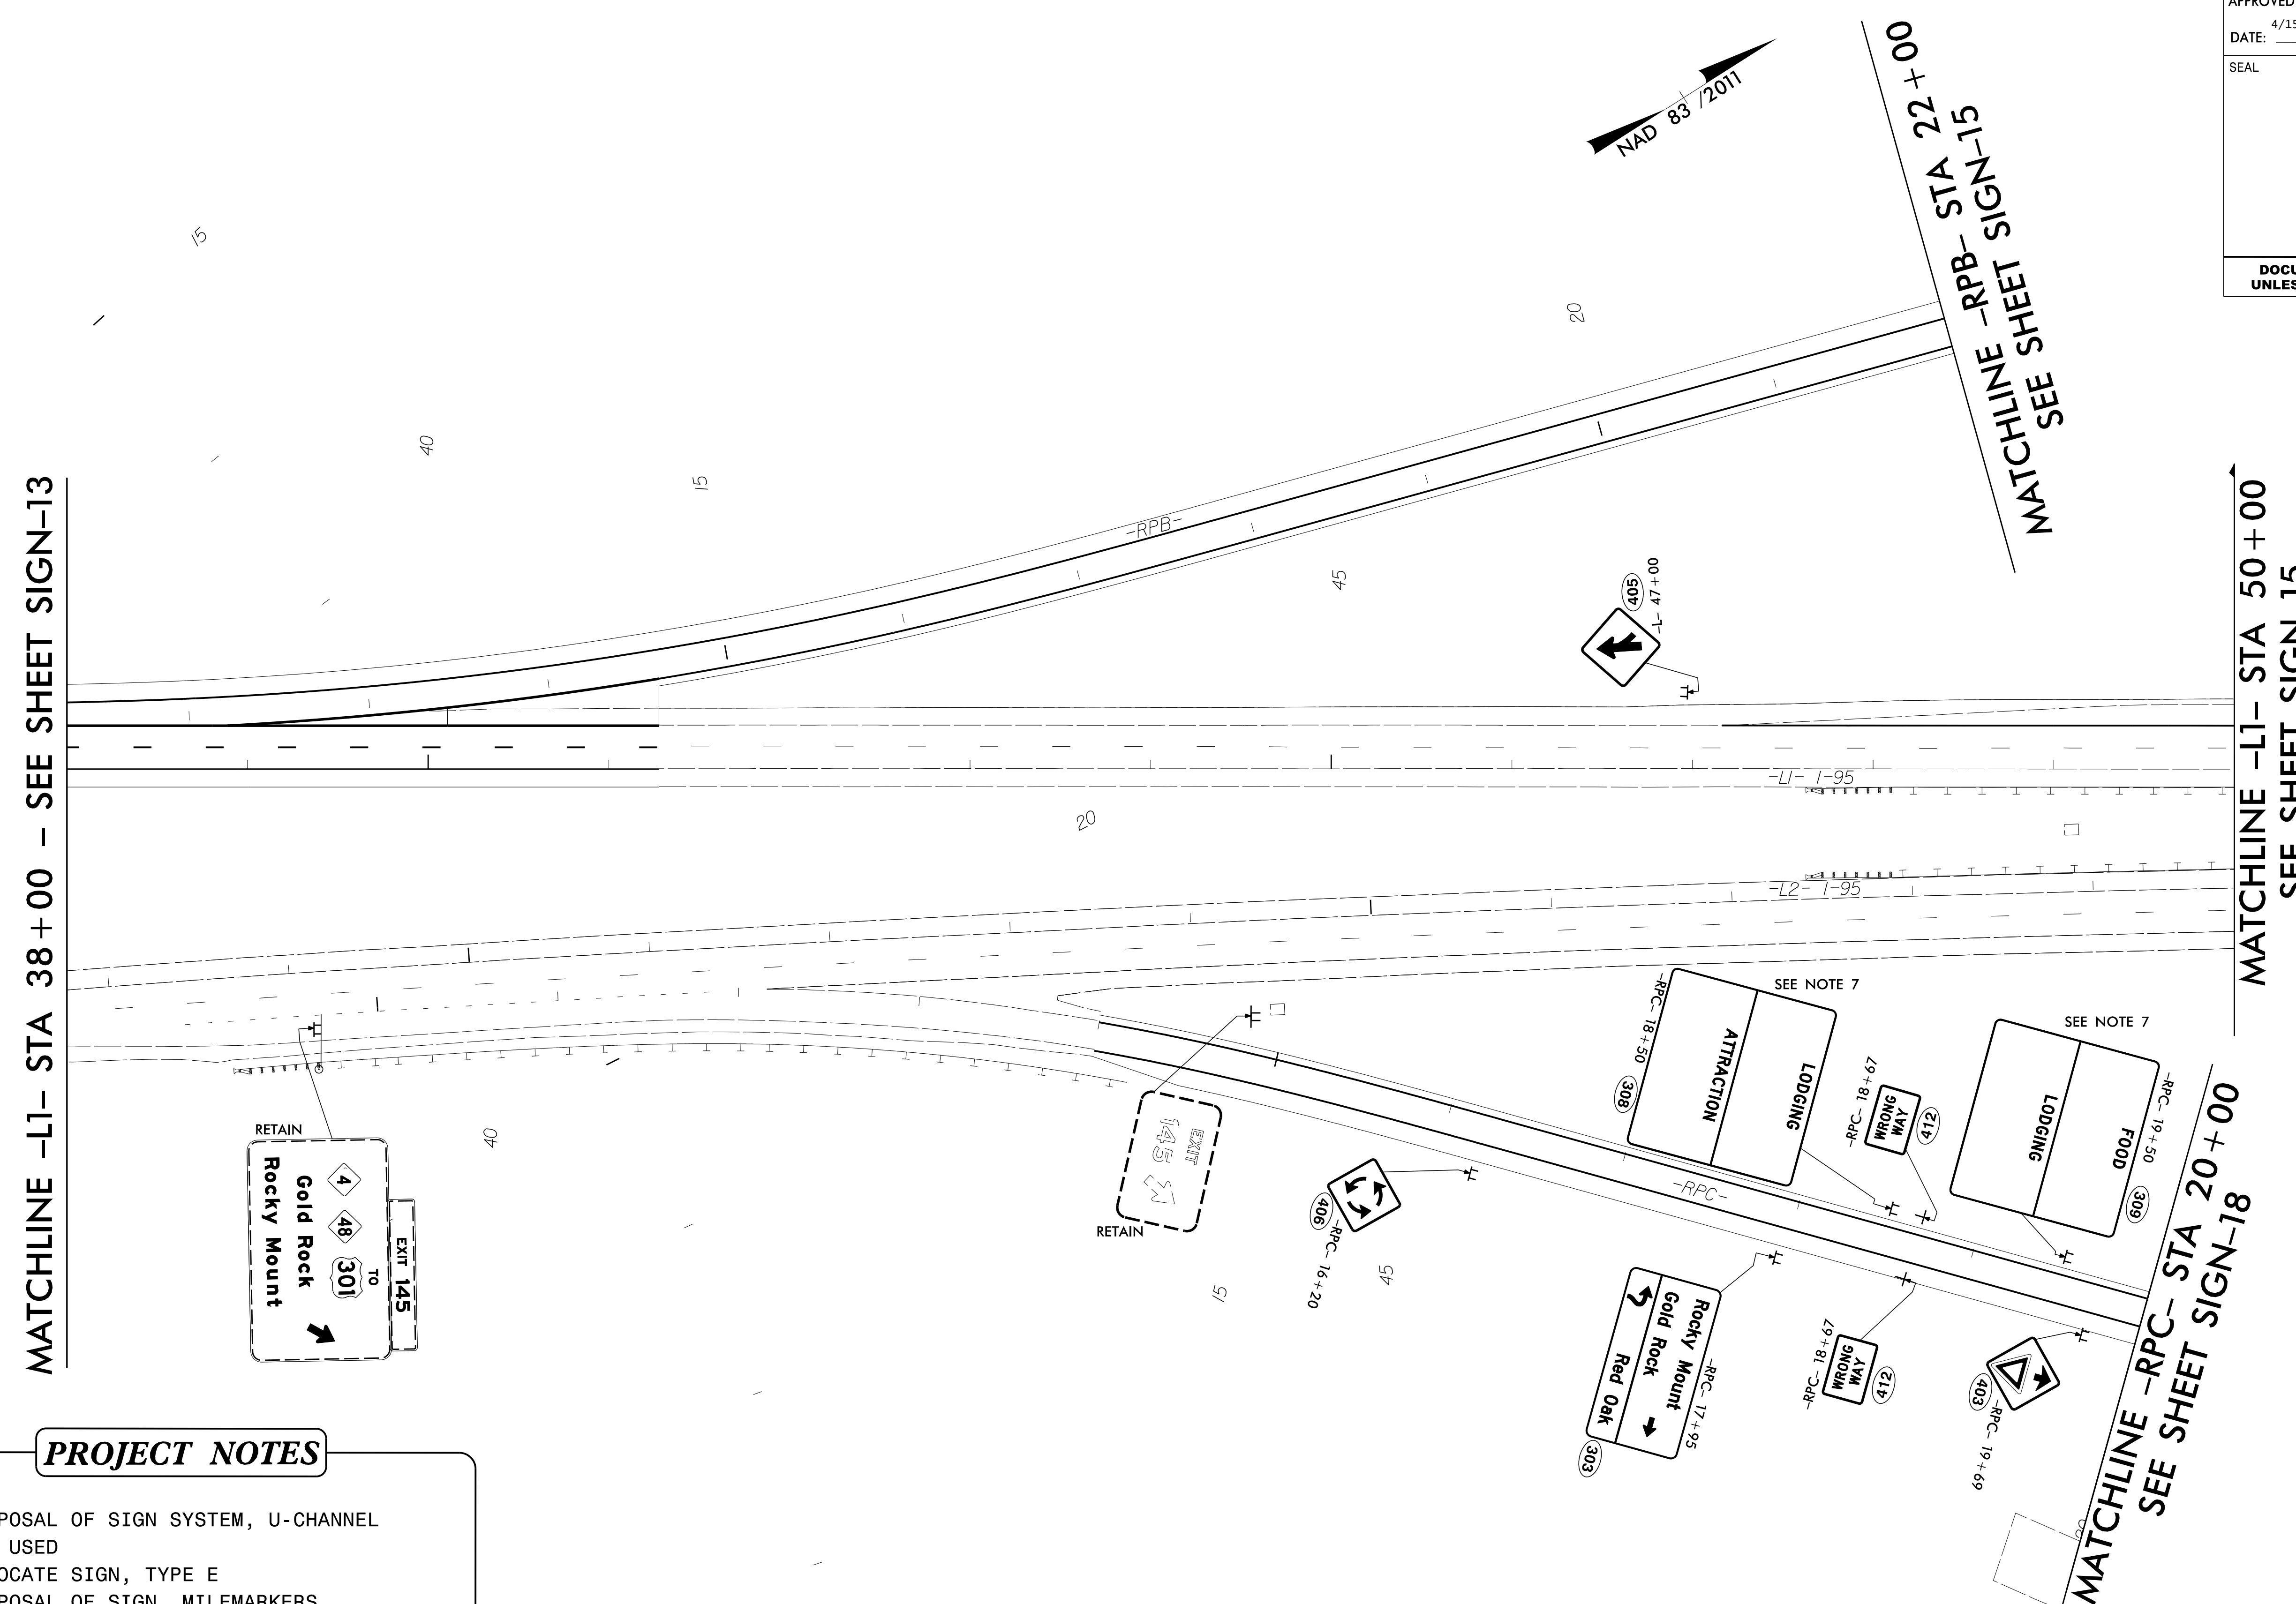

MATCHLINE -L1- STA 38+00 - SEE SHEET SIGN-13

MATCHLINE -RPC- STA 22+00  
SEE SHEET SIGN-15

MATCHLINE -L1- STA 50+00  
SEE SHEET SIGN-15

MATCHLINE -RPC- STA 20+00  
SEE SHEET SIGN-18



**PROJECT NOTES**

1. DISPOSAL OF SIGN SYSTEM, U-CHANNEL
  2. NOT USED
  3. RELOCATE SIGN, TYPE E
  4. DISPOSAL OF SIGN, MILEMARKERS
  5. DISPOSAL OF SIGN, A OR B (OVERHEAD)
  6. DISPOSAL OF LIGHTING SYSTEM
  7. CONTACT DOUG DRAKE, DIVISION 4 LOGO COORDINATOR 252-640-6534
- ★ SIGNALIZED INTERSECTION

**PROPOSED SIGNING**  
-L1- 23+60 STA TO -L1- STA 50+00

2/20/2020  
 R:\Traffic\Control\TCP\B5980\_sign\_14\_PROPOSED.dgn  
 User: jkootz

TIP NO. B-5980	SHEET NO. SIGN-15
APPROVED: <i>Jeffrey D. Kootz</i> 4/15/2020	
DATE: 4/15/2020	
SEAL	
DOCUMENT NOT CONSIDERED FINAL UNLESS ALL SIGNATURES COMPLETED	

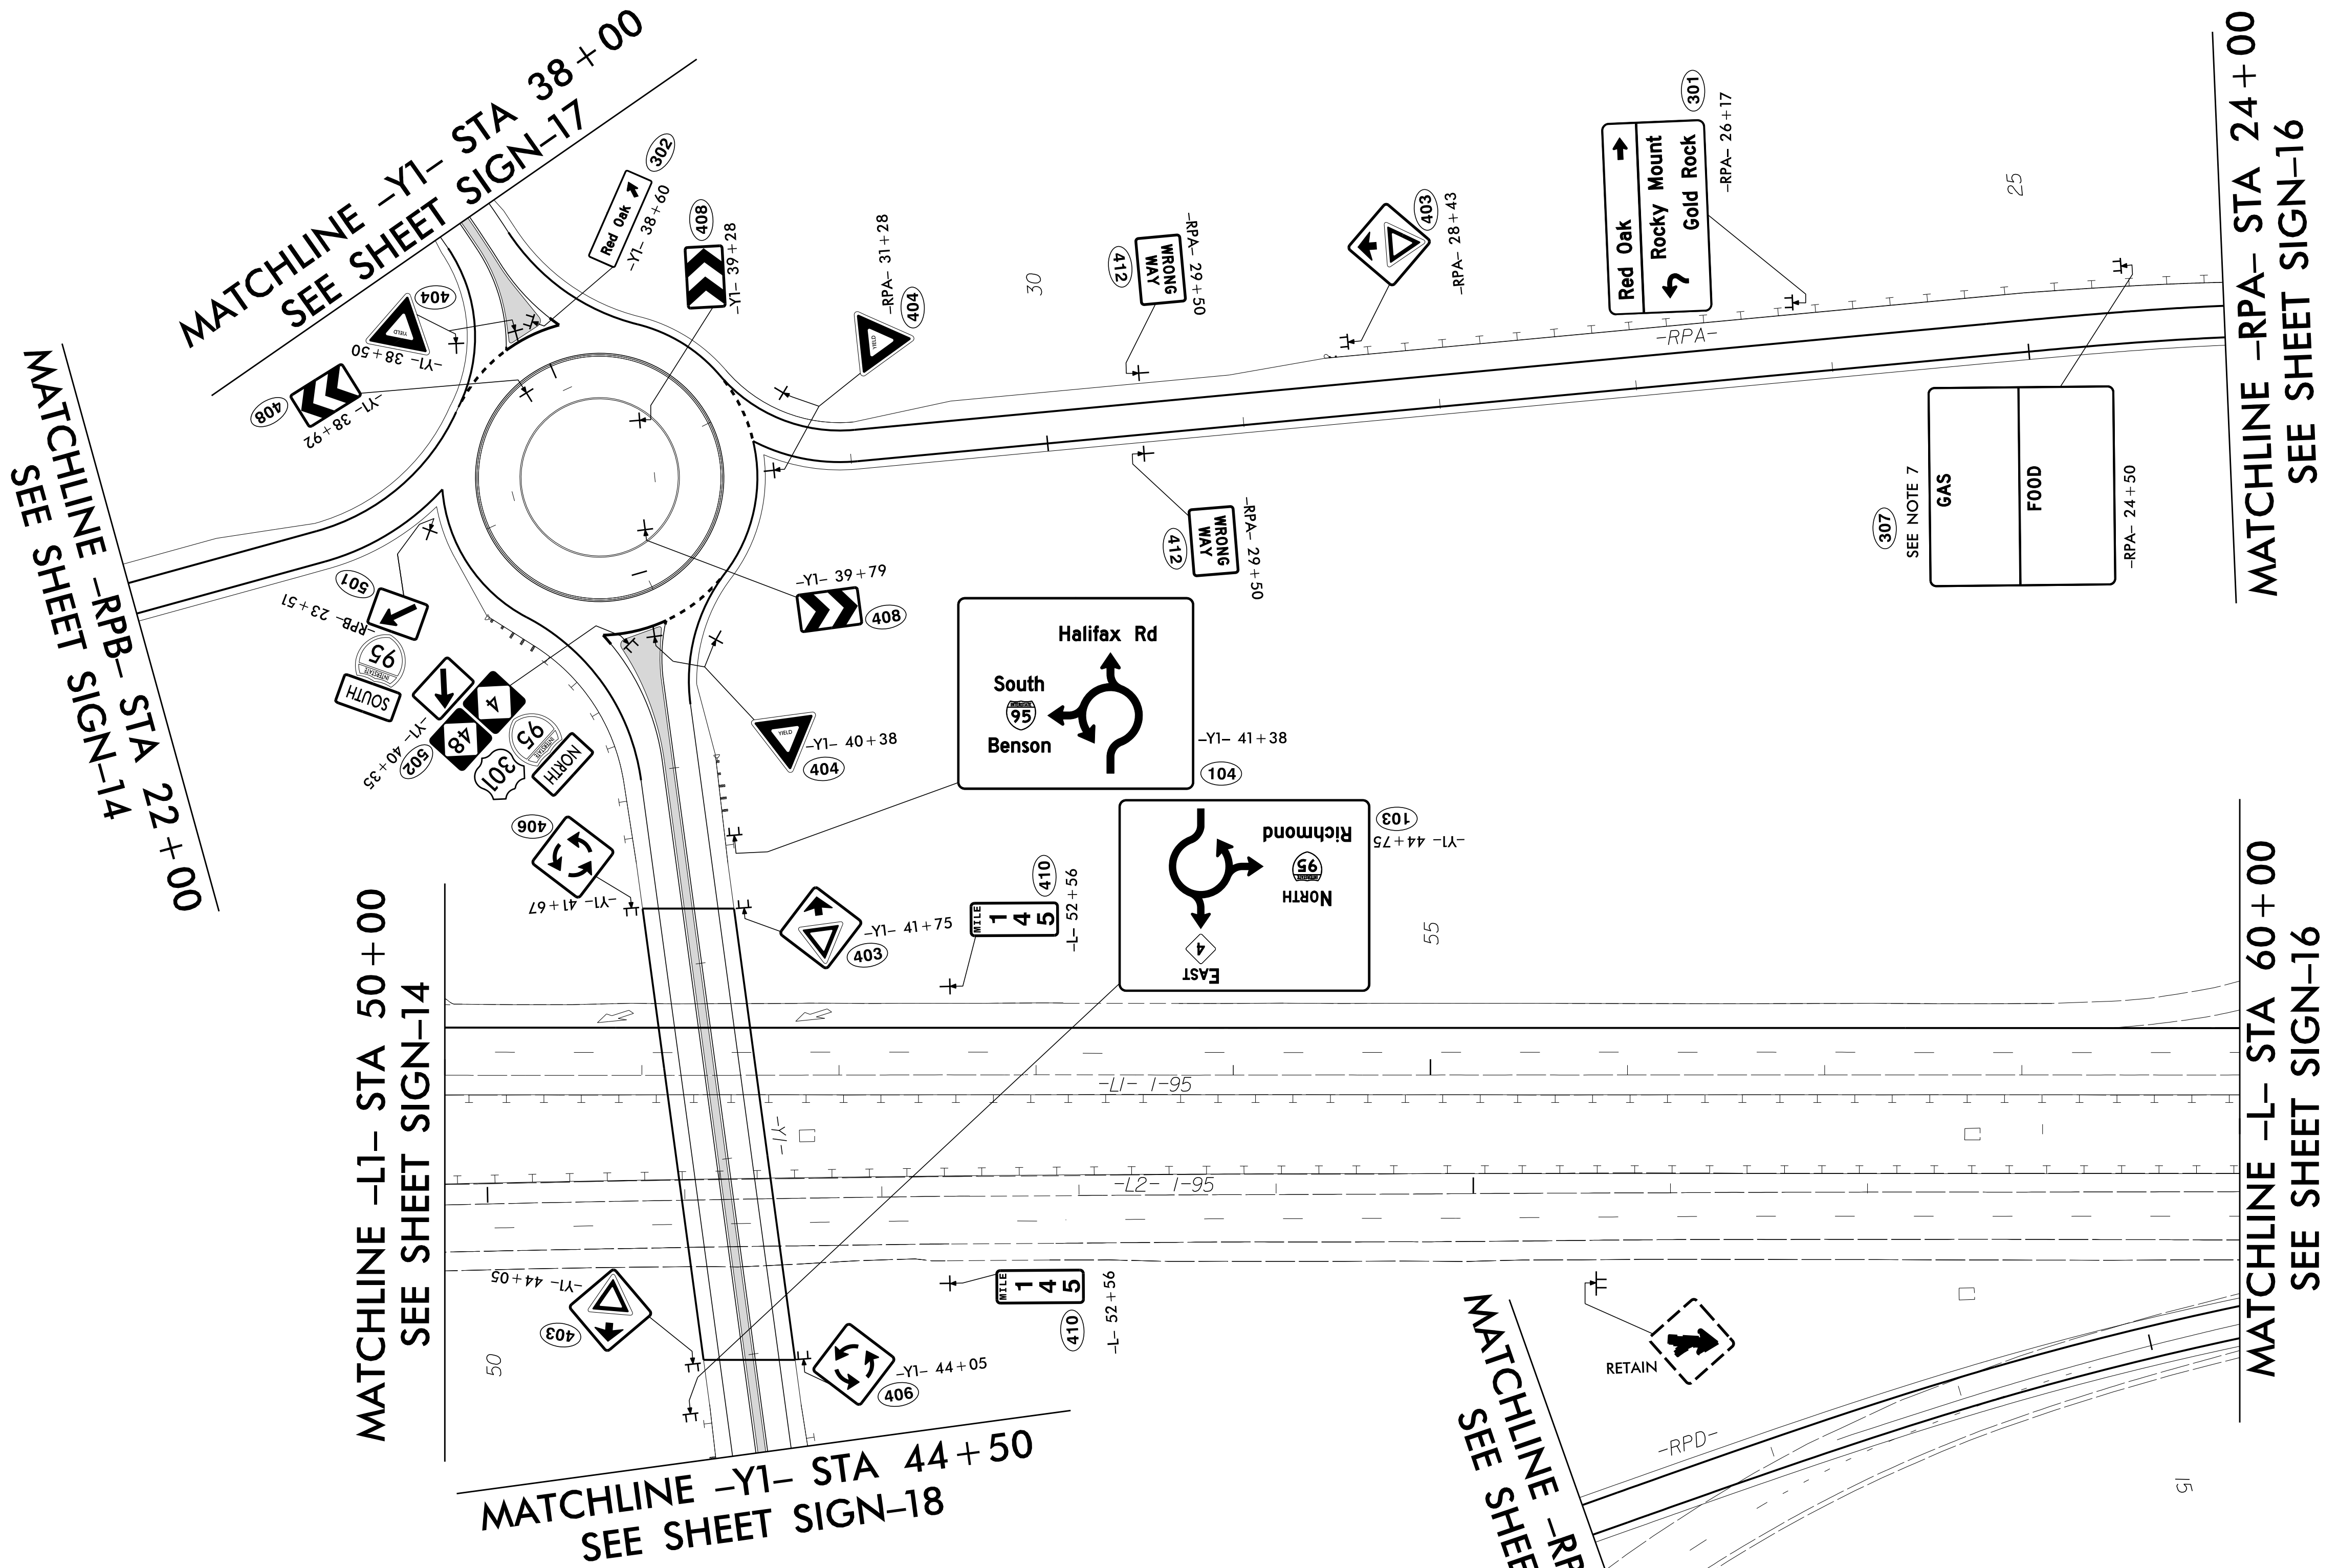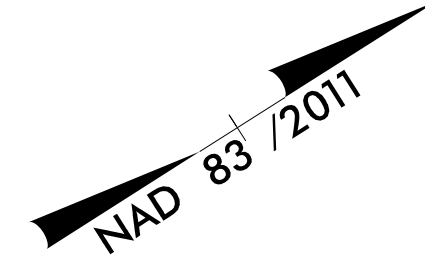


**PROJECT NOTES**

- 1. DISPOSAL OF SIGN SYSTEM, U-CHANNEL
- 2. NOT USED
- 3. RELOCATE SIGN, TYPE E
- 4. DISPOSAL OF SIGN, MILEMARKERS
- 5. DISPOSAL OF SIGN, A OR B (OVERHEAD)
- 6. DISPOSAL OF LIGHTING SYSTEM
- 7. CONTACT DOUG DRAKE, DIVISION 4 LOGO  
COORDINATOR 252-640-6534
- ★ SIGNALIZED INTERSECTION


2/20/2020  
 R:\Traffic\TrafficControl\TCP\B5980\_sign\_15\_PROPOSED.dgn  
 User: jefk

**PROPOSED SIGNING**  
-L1- 50+00 STA TO -L1- STA 60+00

TIP NO. B-5980	SHEET NO. SIGN-16
APPROVED: <i>Jeffrey D. Kootz</i> 4/15/2020	
DATE: 4/15/2020	
SEAL 	
DOCUMENT NOT CONSIDERED FINAL UNLESS ALL SIGNATURES COMPLETED	

MATCHLINE -RPA- STA 24+00  
SEE SHEET SIGN-15

MATCHLINE -L- STA 60+00 - SEE SHEET SIGN-15

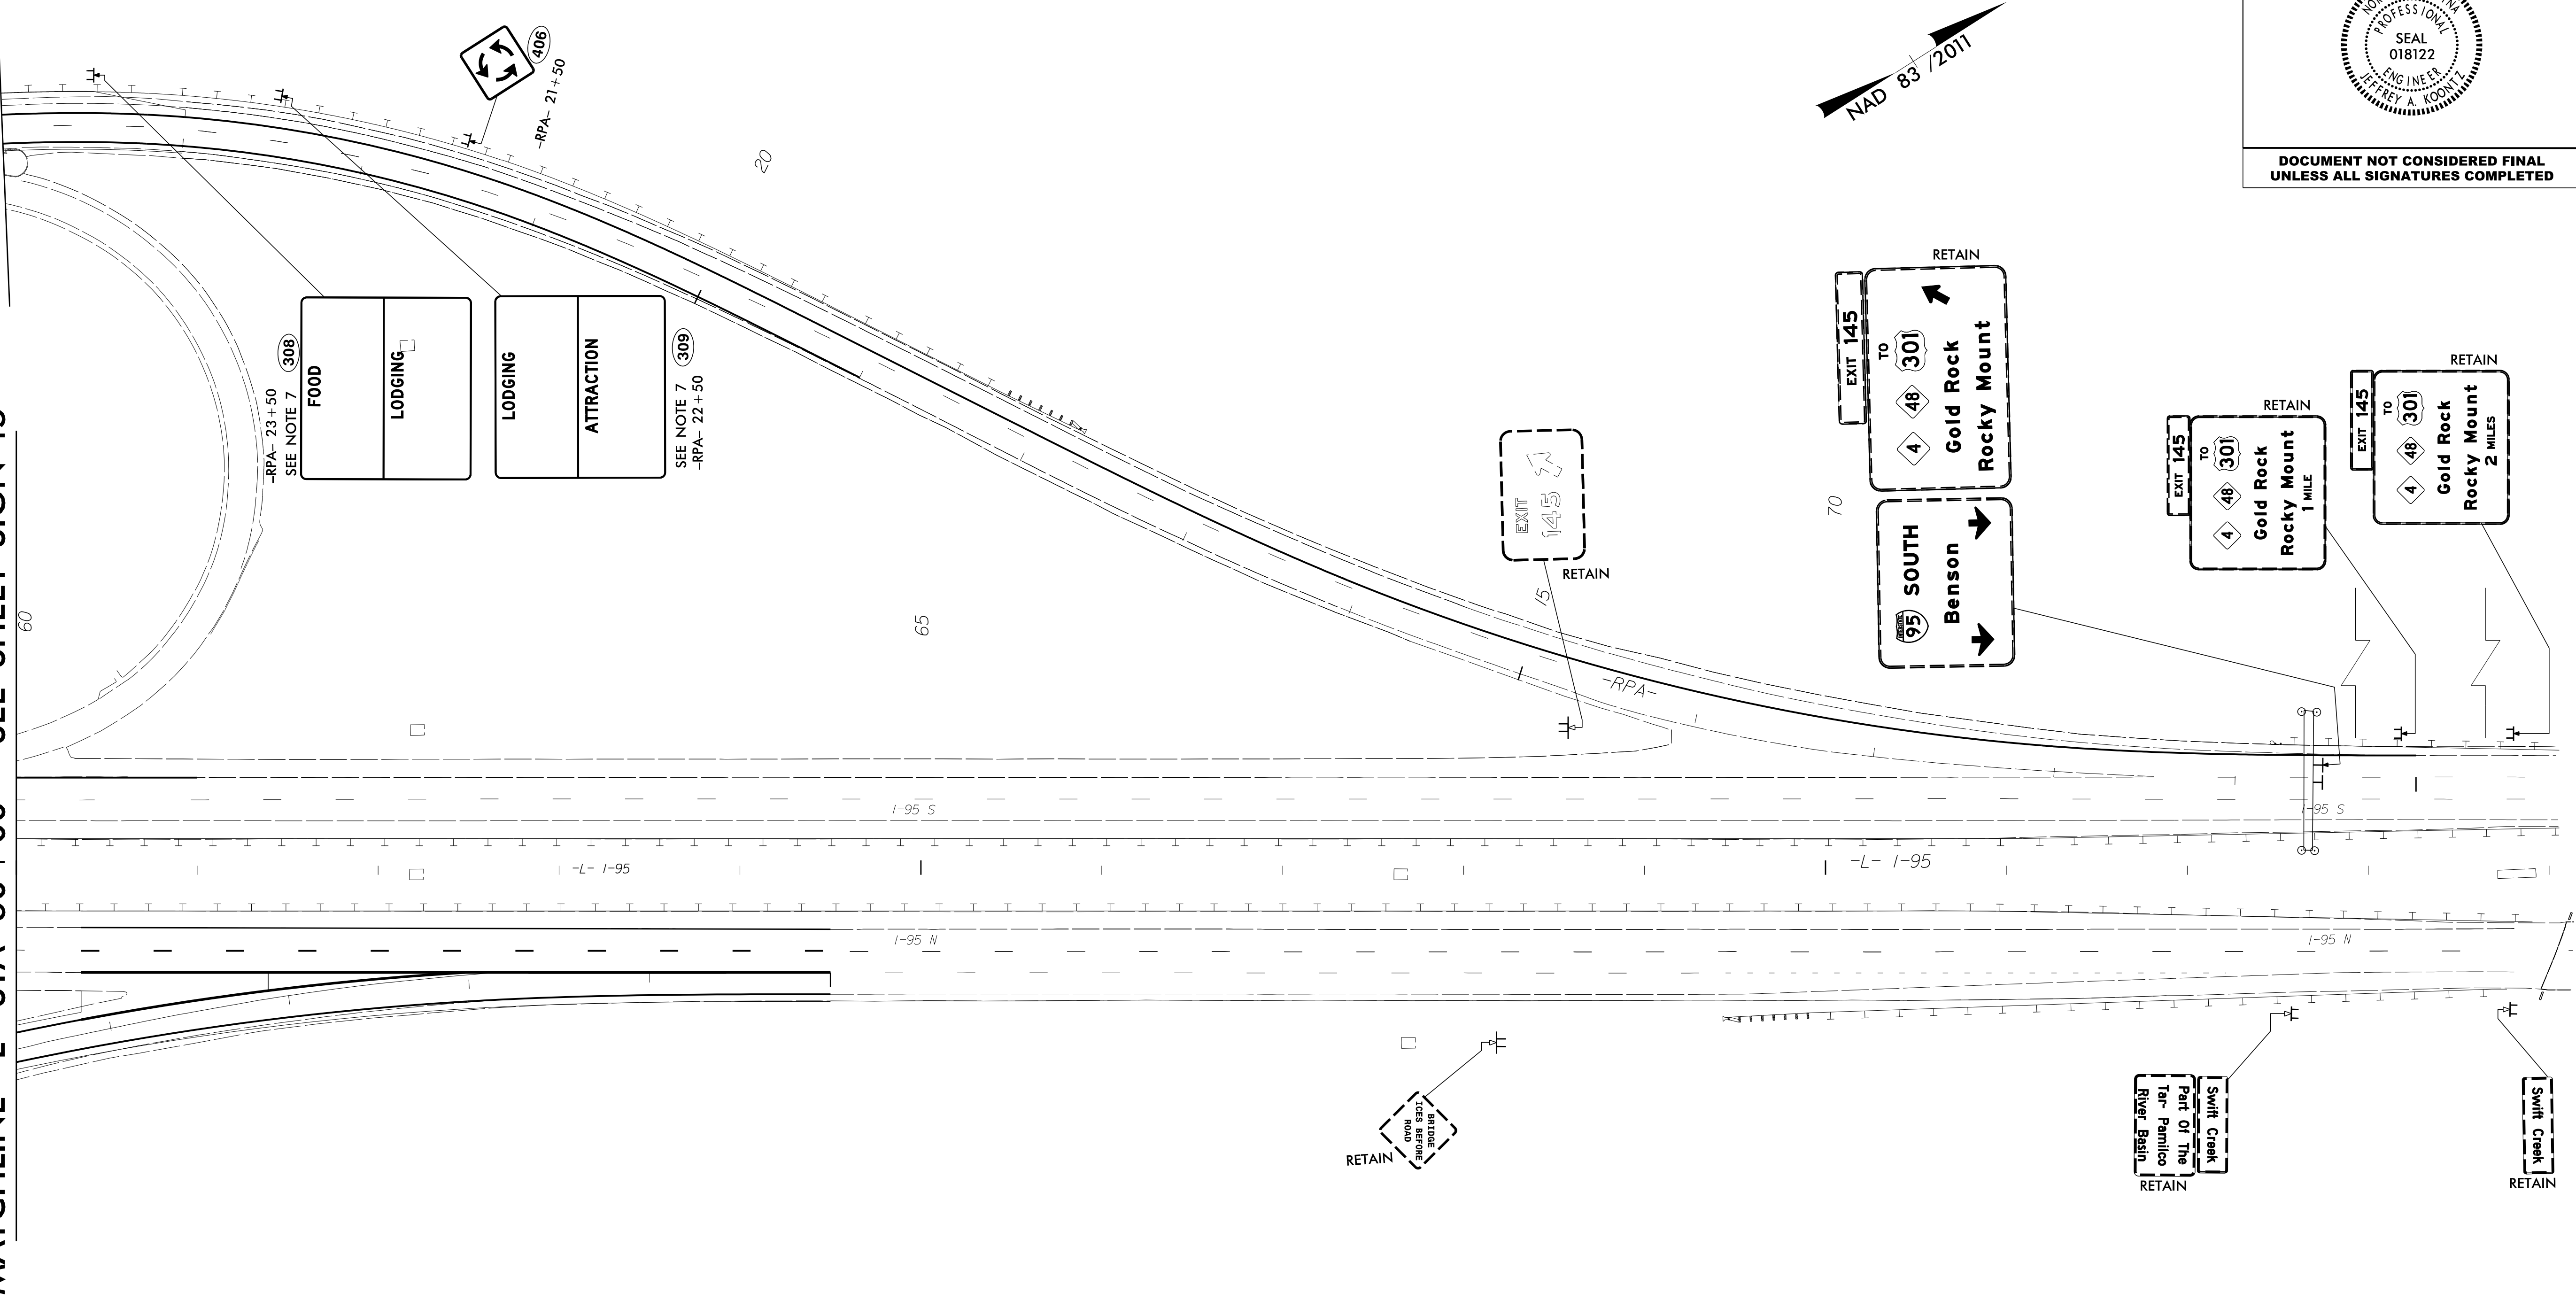

**PROJECT NOTES**

1. DISPOSAL OF SIGN SYSTEM, U-CHANNEL
  2. NOT USED
  3. RELOCATE SIGN, TYPE E
  4. DISPOSAL OF SIGN, MILEMARKERS
  5. DISPOSAL OF SIGN, A OR B (OVERHEAD)
  6. DISPOSAL OF LIGHTING SYSTEM
  7. CONTACT DOUG DRAKE, DIVISION 4 LOGO  
COORDINATOR 252-640-6534
- ★ SIGNALIZED INTERSECTION

**PROPOSED SIGNING**  
-L1- 60+00 STA TO -L1- STA 74+00


2/20/2020  
R:\Traffic\Control\TCP\B5980\_sign\_16\_PROPOSED.dgn  
User: jdk

TIP NO. B-5980	SHEET NO. SIGN-17
APPROVED: <i>Jeffrey A. Kooty</i> -BEBFECC0284F7-	
DATE: 4/15/2020	
SEAL	
DOCUMENT NOT CONSIDERED FINAL UNLESS ALL SIGNATURES COMPLETED	

MATCHLINE -Y1- STA 25+00  
SEE THIS SHEET


25

45  
-Y1- 27+40  
(417)

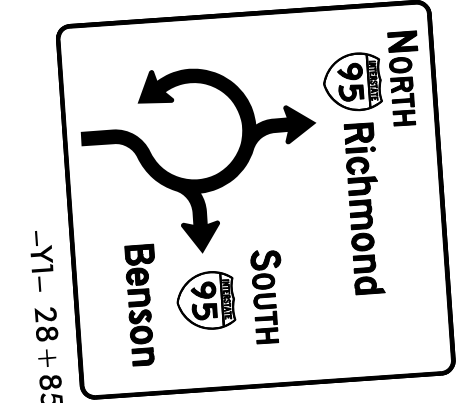


-Y1- 28+85


419  
-Y1- 30+50

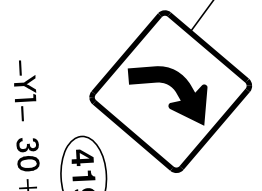


418  
-Y1- 33+00

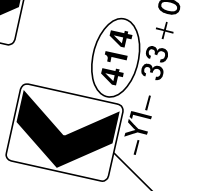



418  
-Y1- 34+35

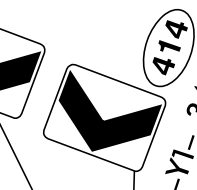

418  
-Y1- 35+35

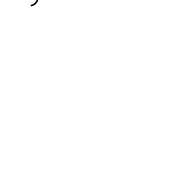

403  
-Y1- 35+35

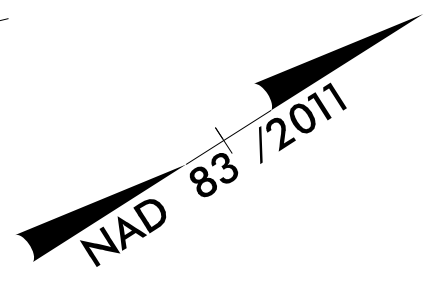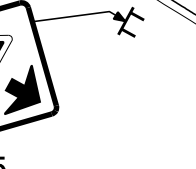


MATCHLINE -Y1- STA 38+00  
SEE SHEET SIGN-15

SR 1544



RETAIN

418  
-Y1- 17+50

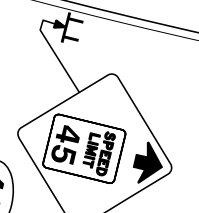

-Y1-

402  
-Y2- 10+58



401  
-Y2- 10+28



411  
-Y2- 14+12

MATCHLINE -Y1- STA 25+00  
SEE THIS SHEET



### PROJECT NOTES

1. DISPOSAL OF SIGN SYSTEM, U-CHANNEL
  2. NOT USED
  3. RELOCATE SIGN, TYPE E
  4. DISPOSAL OF SIGN, MILEMARKERS
  5. DISPOSAL OF SIGN, A OR B (OVERHEAD)
  6. DISPOSAL OF LIGHTING SYSTEM
  7. CONTACT DOUG DRAKE, DIVISION 4 LOGO  
COORDINATOR 252-640-6534
- ★ SIGNALIZED INTERSECTION

**PROPOSED SIGNING**  
-Y1- 25+00 STA TO -Y1- STA 38+00

2/20/2020  
R:\Traffic\TrafficControl\TCP\B5980\_sign\_17\_PROPOSED.dgn  
User: jefk

TIP NO. B-5980	SHEET NO. SIGN-18
APPROVED: <i>Jeffrey D. Kootz</i> 4/15/2020	
DATE: 4/15/2020	
SEAL	
DOCUMENT NOT CONSIDERED FINAL UNLESS ALL SIGNATURES COMPLETED	


MATCHLINE -RPD- STA 18+00  
SEE SHEET SIGN-15

MATCHLINE -Y1- STA 44+50  
SEE SHEET SIGN-15


MATCHLINE -RPC- STA 20+00  
SEE SHEET SIGN-14

2/20/2020  
R:\Traffic\TrafficControl\TCP\B5980\_sign\_18\_PROPOSED.dgn  
User:Jeff.Kootz


- PROJECT NOTES**
- DISPOSAL OF SIGN SYSTEM, U-CHANNEL
  - NOT USED
  - RELOCATE SIGN, TYPE E
  - DISPOSAL OF SIGN, MILEMARKERS
  - DISPOSAL OF SIGN, A OR B (OVERHEAD)
  - DISPOSAL OF LIGHTING SYSTEM
  - CONTACT DOUG DRAKE, DIVISION 4 LOGO COORDINATOR 252-640-6534
  - ★ SIGNALIZED INTERSECTION

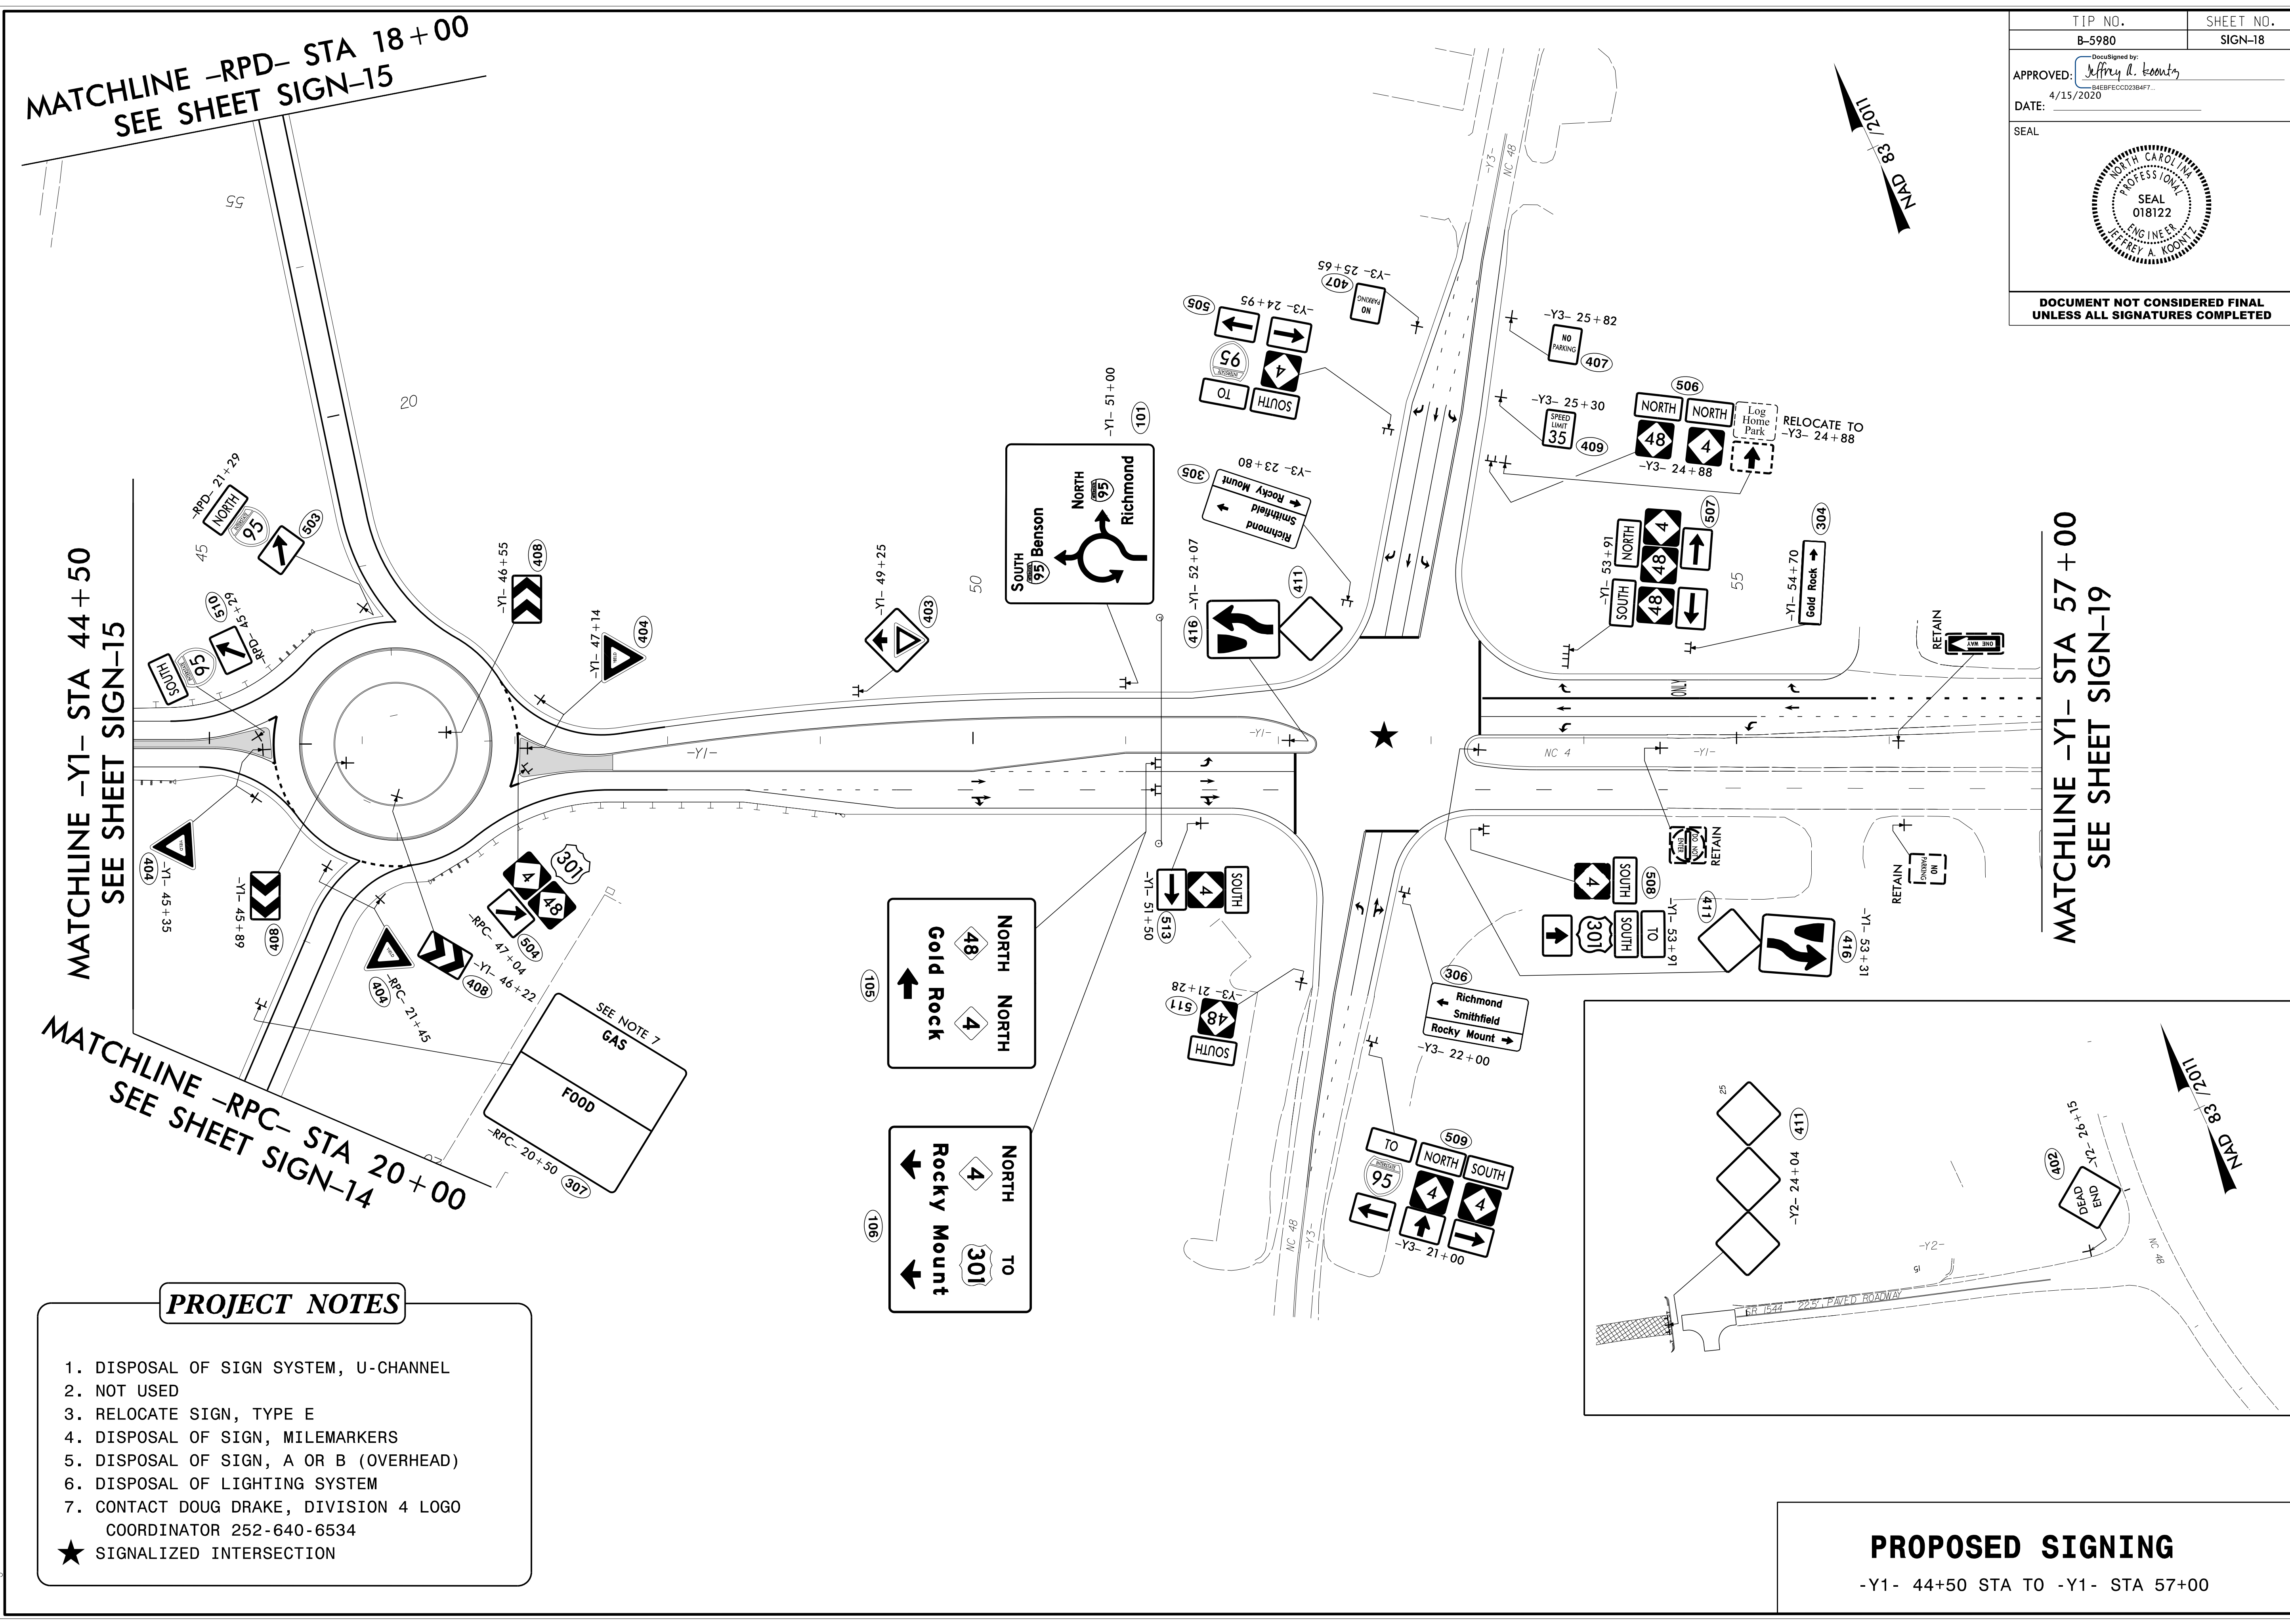

MATCHLINE -Y1- STA 57+00  
SEE SHEET SIGN-19

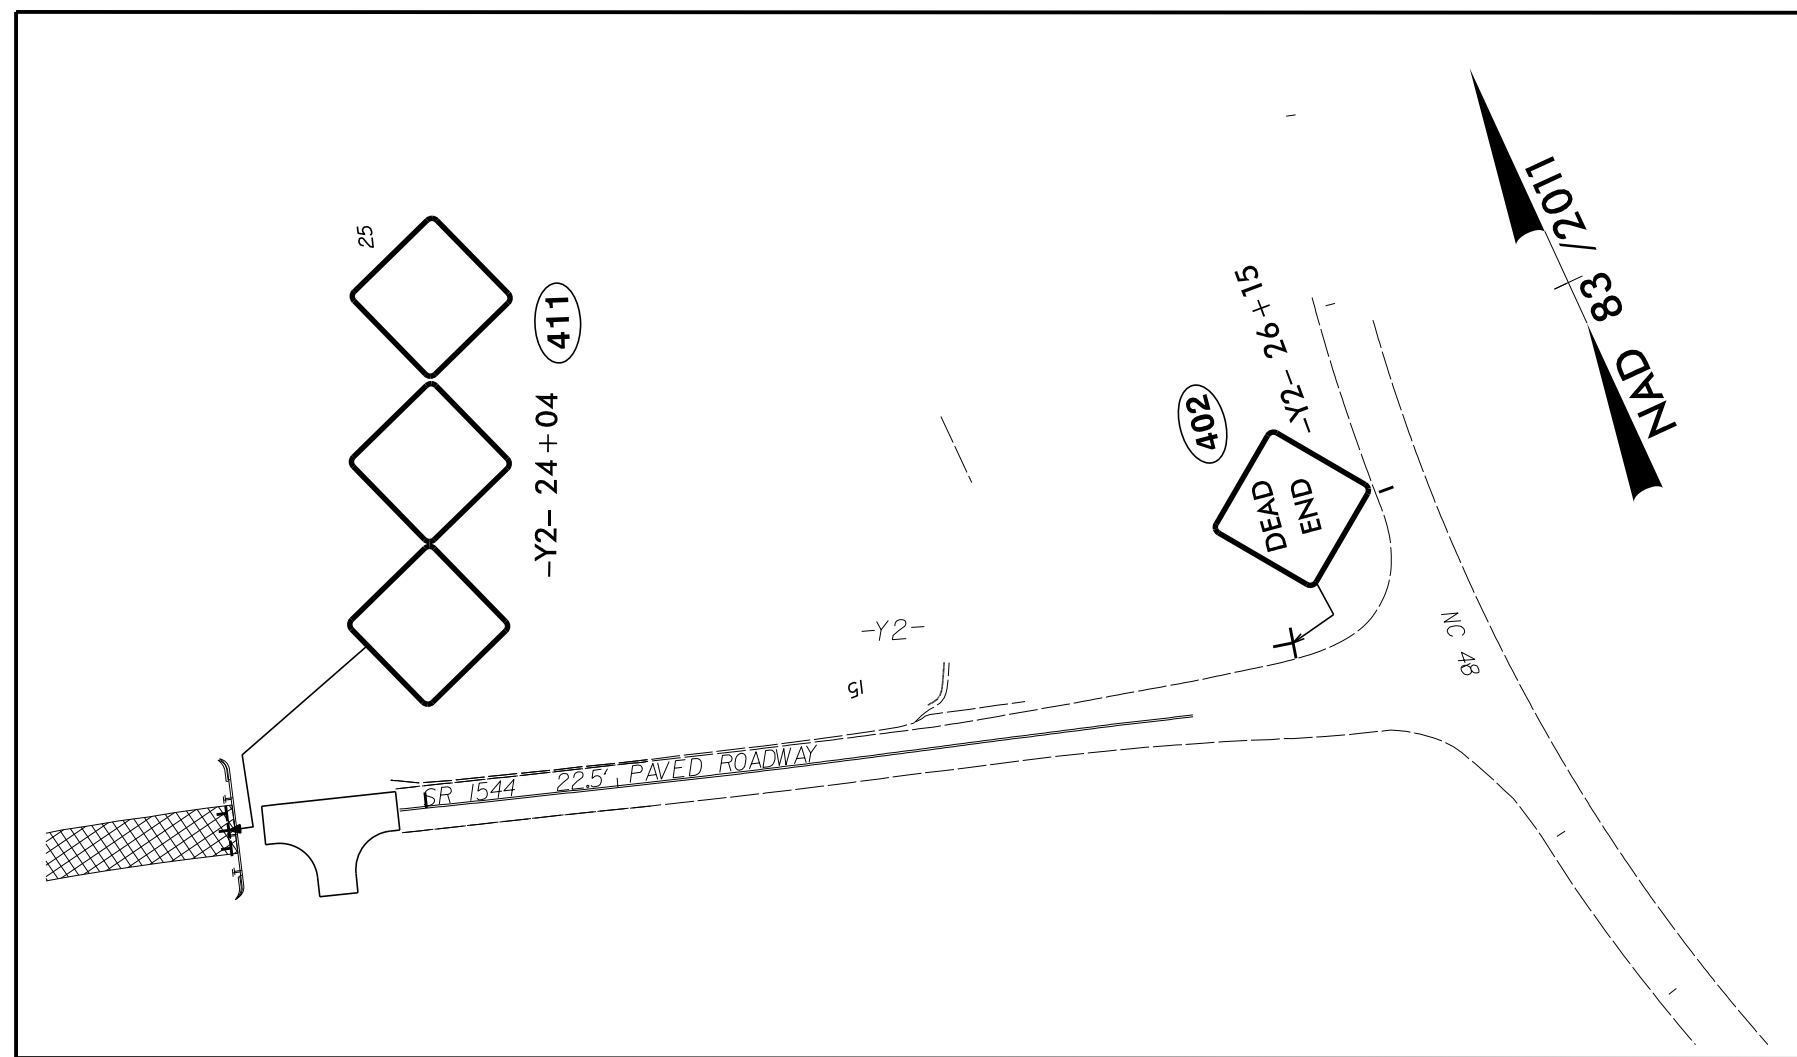


**PROPOSED SIGNING**  
-Y1- 44+50 STA TO -Y1- STA 57+00

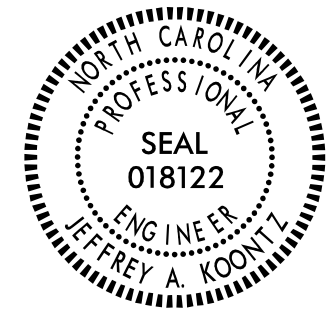TIP NO. B-5980	SHEET NO. SIGN-19
APPROVED: <i>Jeffrey A. Koontz</i> 4/15/2020	
SEAL	
	
<b>DOCUMENT NOT CONSIDERED FINAL UNLESS ALL SIGNATURES COMPLETED</b>	

MAY 28 2011

MATCHLINE -Y1- STA 57+00  
SEE SHEET SIGN-18

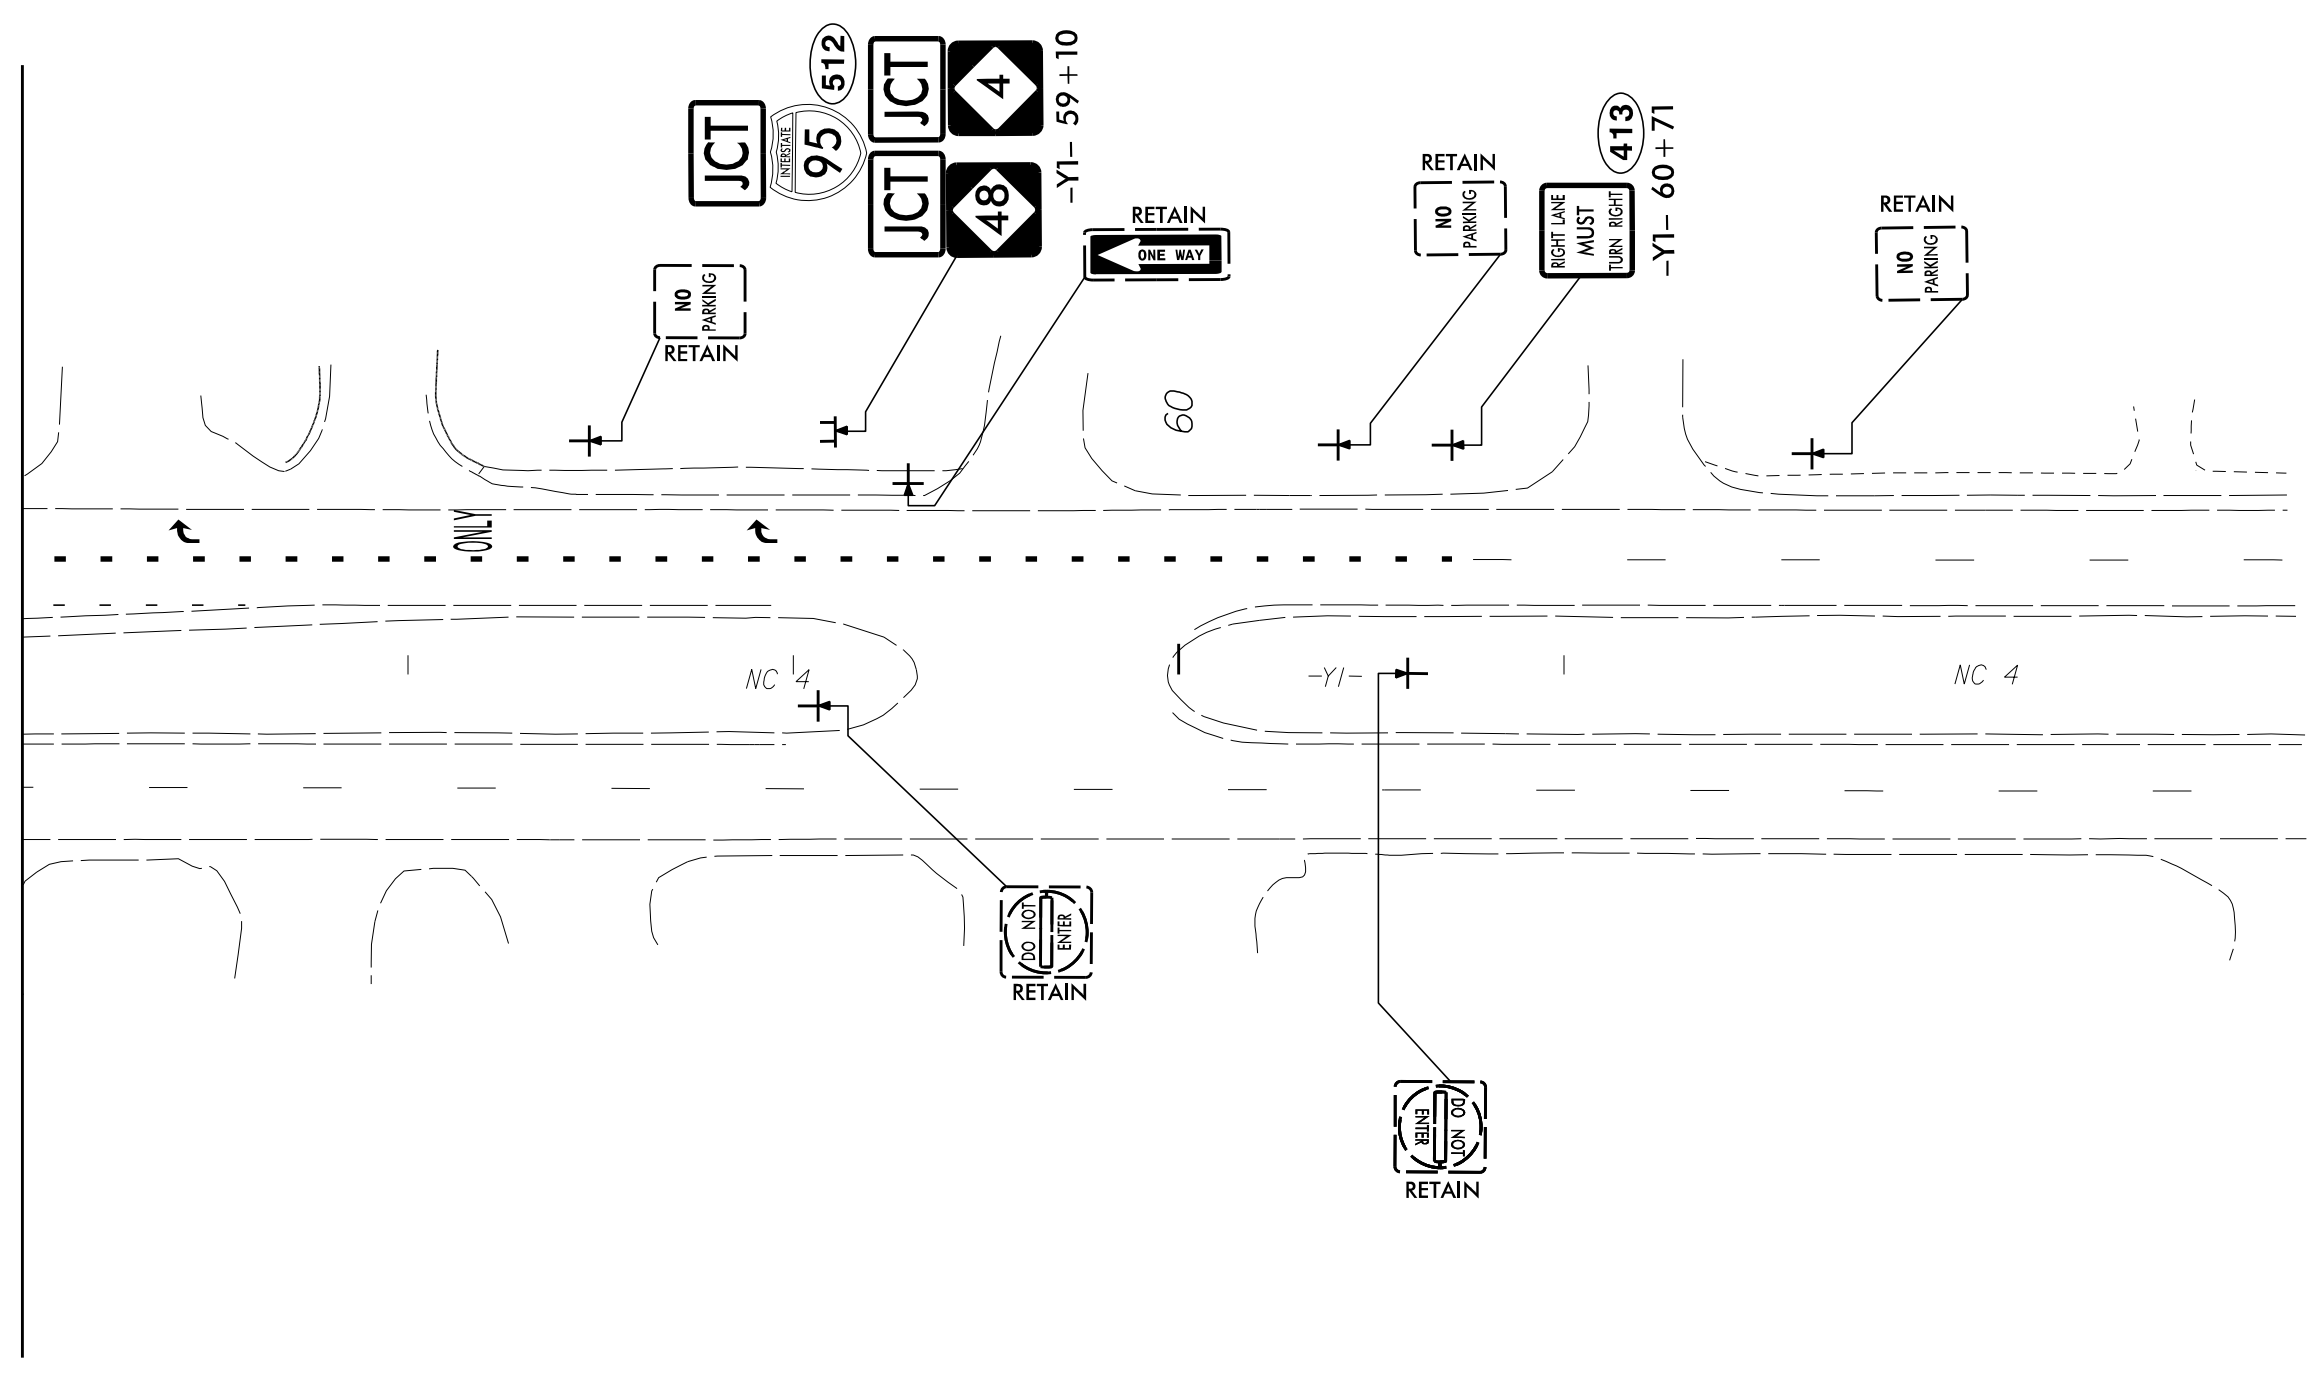

**PROJECT NOTES**

1. DISPOSAL OF SIGN SYSTEM, U-CHANNEL
  2. NOT USED
  3. RELOCATE SIGN, TYPE E
  4. DISPOSAL OF SIGN, MILEMARKERS
  5. DISPOSAL OF SIGN, A OR B (OVERHEAD)
  6. DISPOSAL OF LIGHTING SYSTEM
  7. CONTACT DOUG DRAKE, DIVISION 4 LOGO  
COORDINATOR 252-640-6534
- ★ SIGNALIZED INTERSECTION

2/20/2020  
F:\Traffic\TrafficControl\TCP\B5980\sign\_19\_PROPOSSED.dgn  
User: jkkoontz

**PROPOSED SIGNING**  
-Y1- 57+00 STA TO -Y1- STA 69+90