

STATE OF NORTH CAROLINA
DIVISION OF HIGHWAYS

EDGECOMBE COUNTY


LOCATION: US 64 (FUTURE I-87) FROM NC-33
TO MARTIN COUNTY LINE.

TYPE OF WORK: PAVEMENT REHABILITATION.

STATE	STATE PROJECT REFERENCE NO.	SHEET NO.	TOTAL SHEETS
N.C.	I-6042	1	
STATE PROJ. NO.	F.A. PROJ. NO.	DESCRIPTION	
47991.1.1	0087049	PE	
47991.3.1	0087049	CONST	

TIP PROJECT: I-6042

CONTRACT: C204819

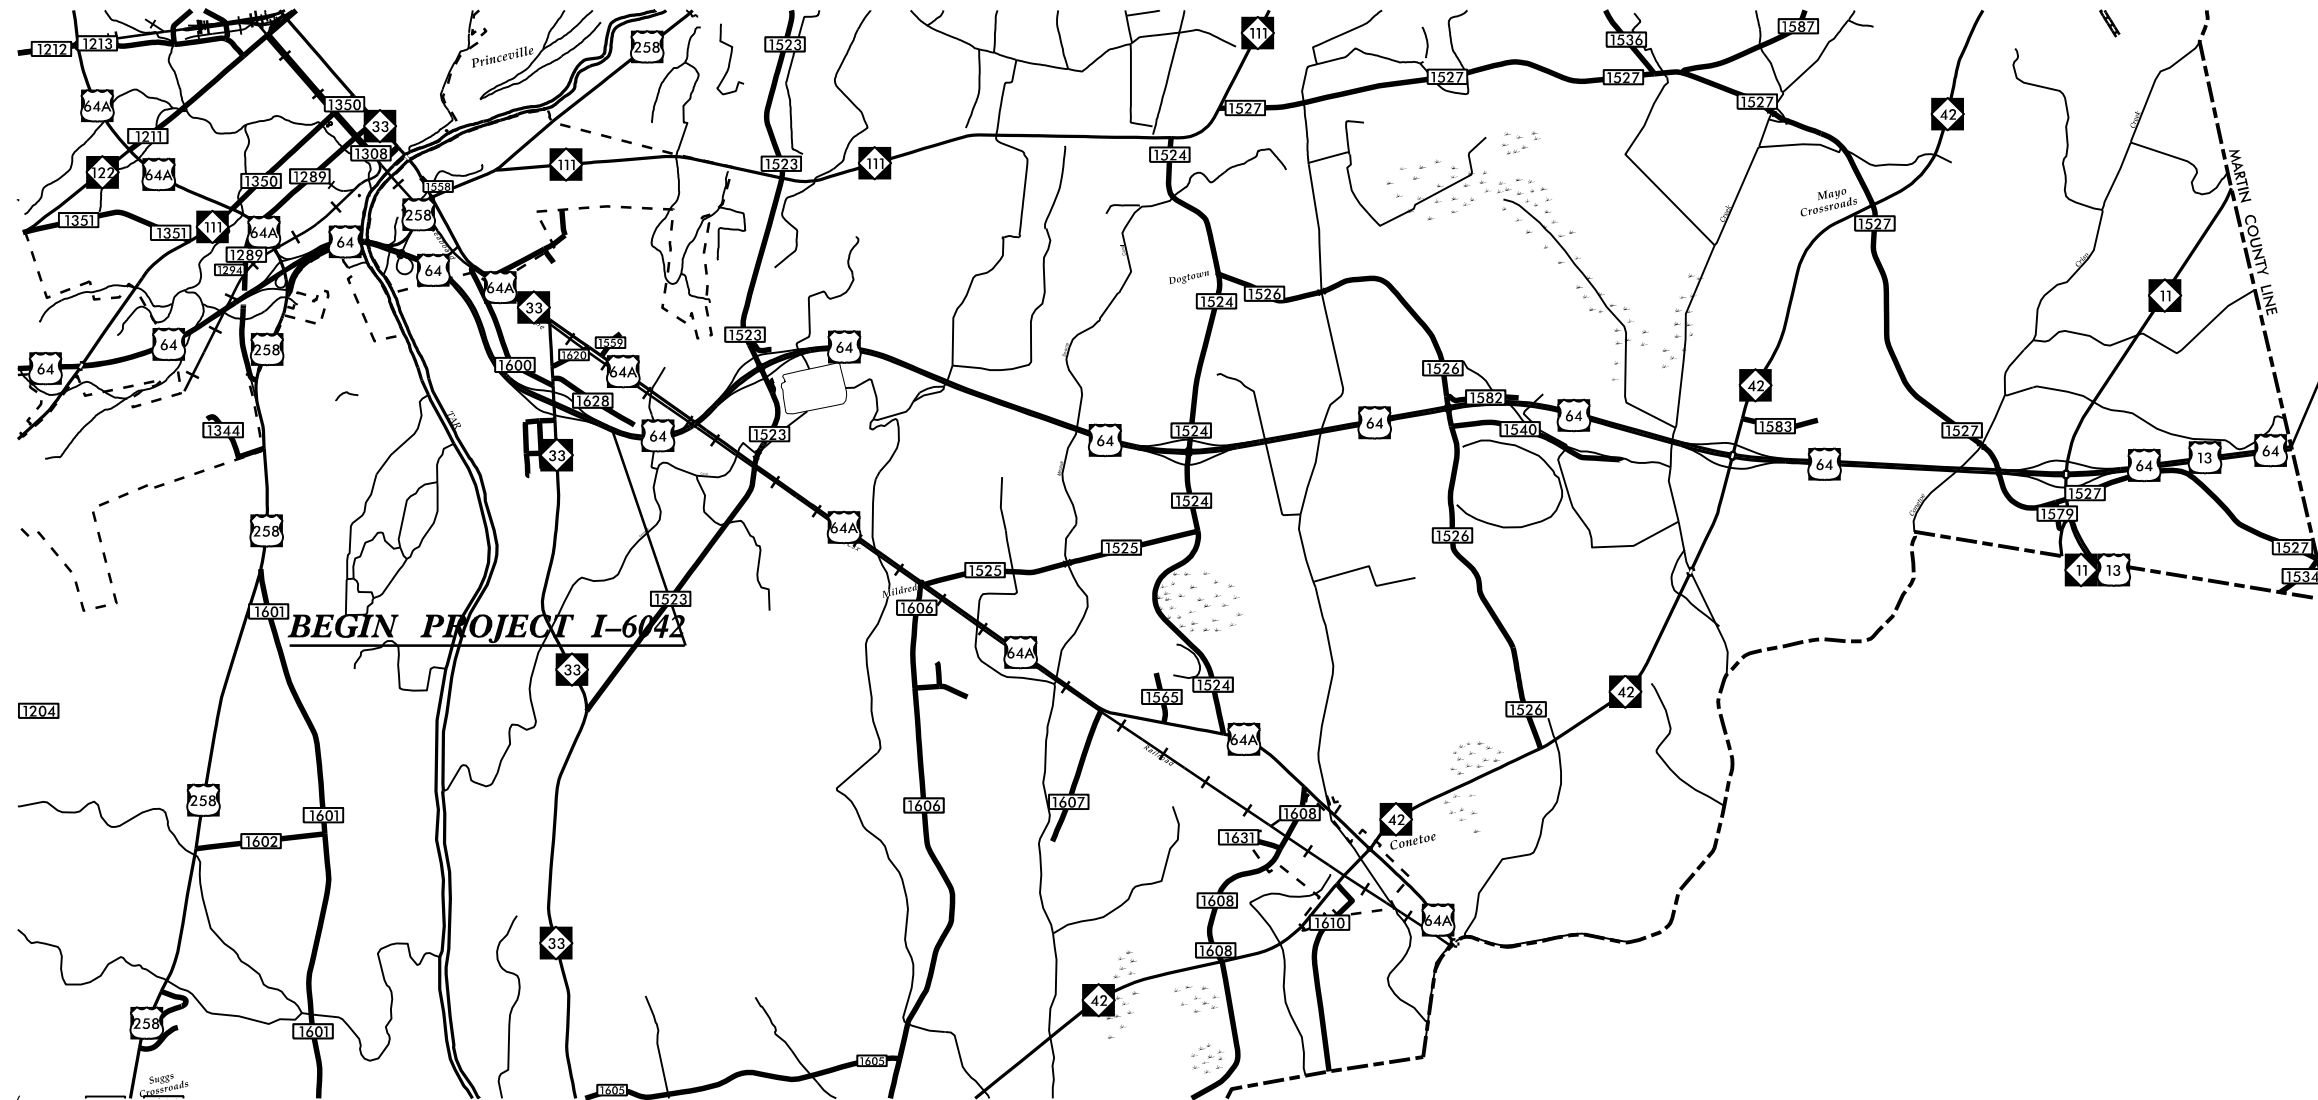

VICINITY MAP

21-FEB-2023 14:07
C:\Users\drehrdige\Desktop\I-6042\I-6042-DDC4_Lsh.dgn
Division 4 DDC

DESIGN DATA
ADT 2017 = 12500

FUNCTIONAL CLASS
OTHER FREEWAY
(FUTURE INTERSTATE)

PROJECT LENGTH

LENGTH ROADWAY (WBL) TIP PROJECT I-6042 = 10.22 MILES
TOTAL LENGTH TIP PROJECT I-6042 = 10.22 MILES

Prepared in the Office of:
DIVISION OF HIGHWAYS

Division 4 DDC
509 Ward Blvd., Wilson NC, 27895

2018 STANDARD SPECIFICATIONS

RIGHT OF WAY DATE:
NA

LETTING DATE:
MAY 16, 2023

KEITH EASON, PE
PROJECT ENGINEER

D.R. ETHRIDGE
PROJECT DESIGN ENGINEER

