


EDGECOMBE COUNTY

PROJECT REFERENCE NO.	SHEET NO.
I-6042 47991.3.1	2

2

1

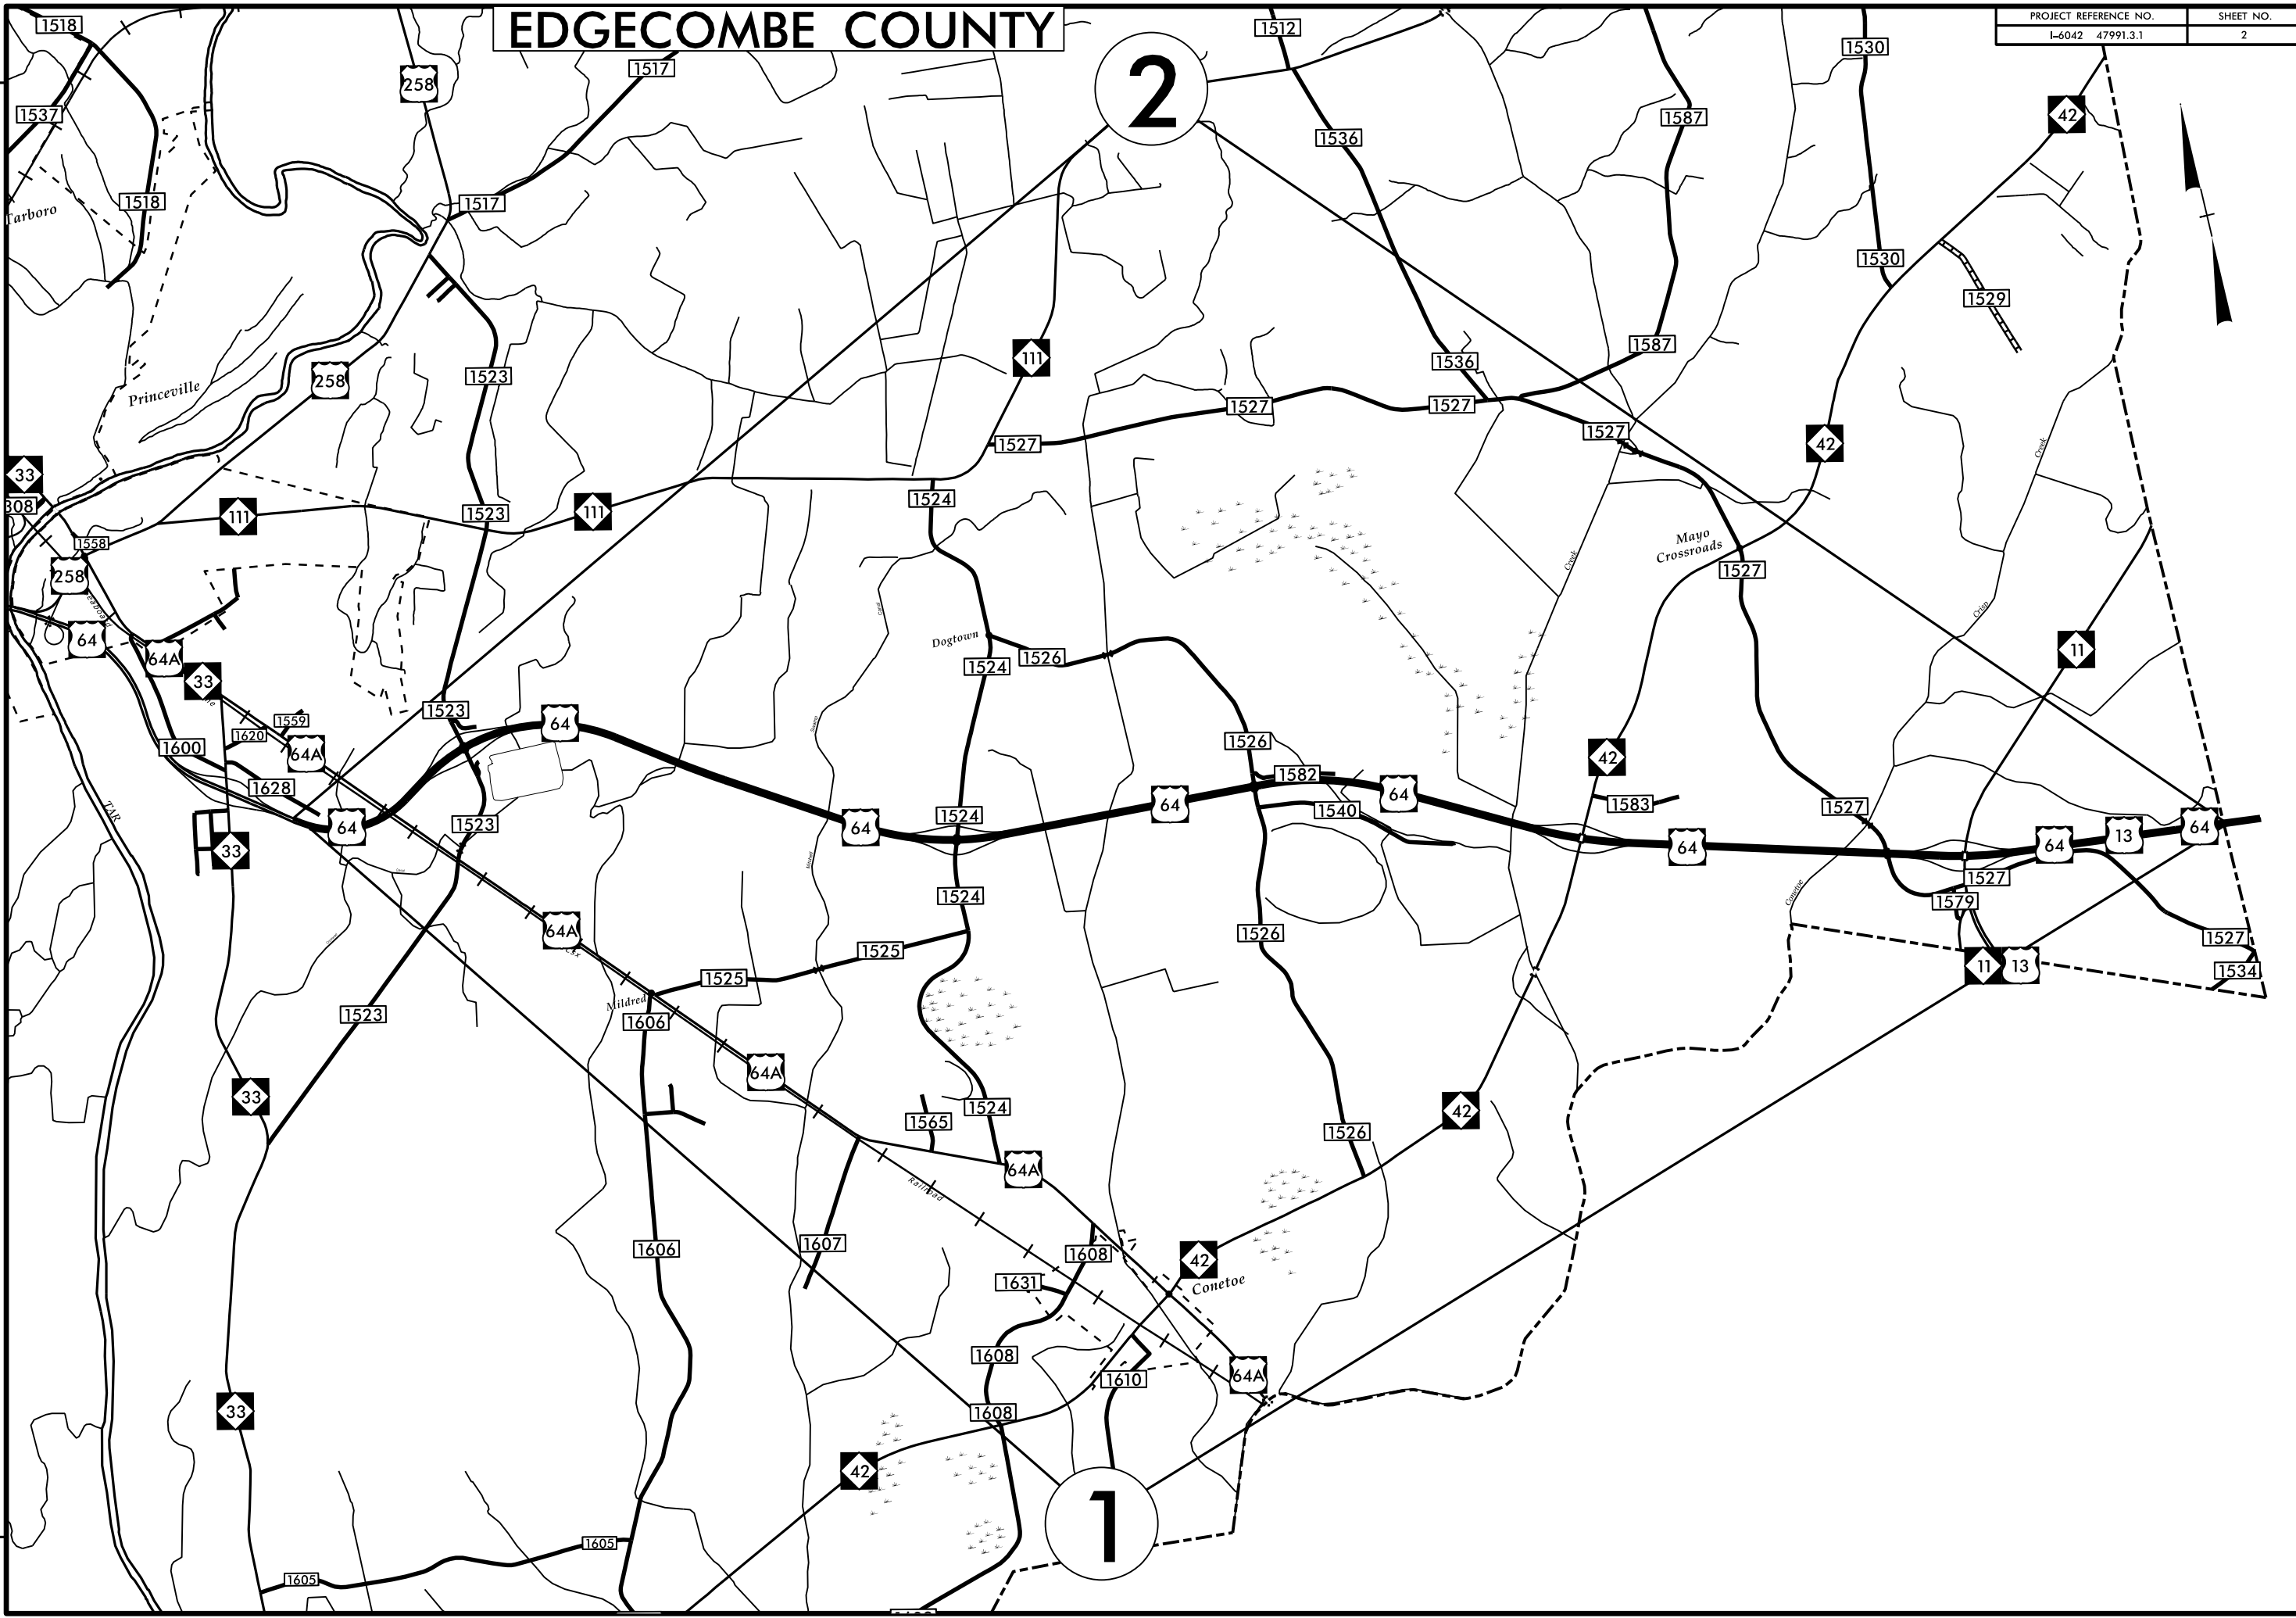

Carboro

Princeville

Dogtown

Mayo Crossroads

Mildred

Conetoe

REVISIONS

30-JAN-2023 11:42
 C:\Users\drehrhidge\Desktop\I-6042\I-6042\I-6042_DDC4_MAPS_PRINT_1.dgn
 Division 4 DDC

