

CONTRACT: C204715 STATE PROJECT NO.: 17BP.14.R.212


STATE OF NORTH CAROLINA
DIVISION OF HIGHWAYS

STATE PROJECT NO.	SHEET NO.
17BP.14.R.212	UC-1

UTILITY CONSTRUCTION PLANS JACKSON COUNTY


LOCATION: SR 1336 (MONTEITH GAP ROAD) FROM NORTH OF SR 1002 (OLD CULLOWHEE ROAD) TO NORTH OF SR 1337 (LEDBETTER ROAD)

TYPE OF WORK: WATER & SEWER LINE CONSTRUCTION

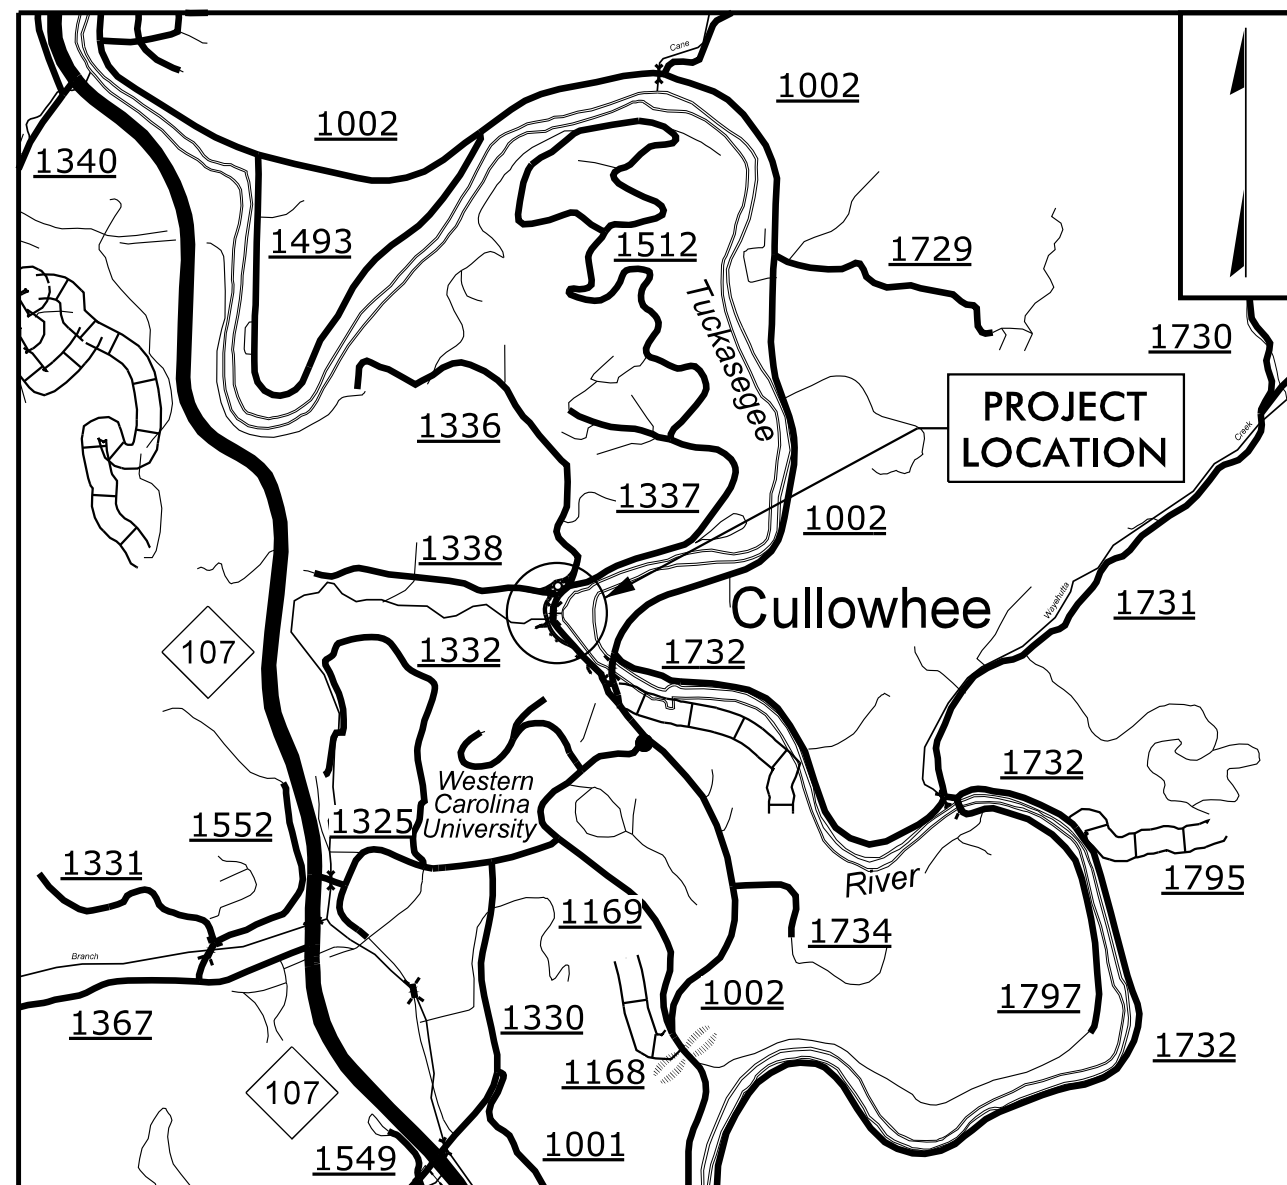

VICINITY MAP (NOT TO SCALE)


BEGIN CONSTRUCTION PROJECT 17BP.14.R.212
-L- STA. 11+14.45
TIE TO TIP PROJECT
B-4159 -Y1- STA. 11+20.00

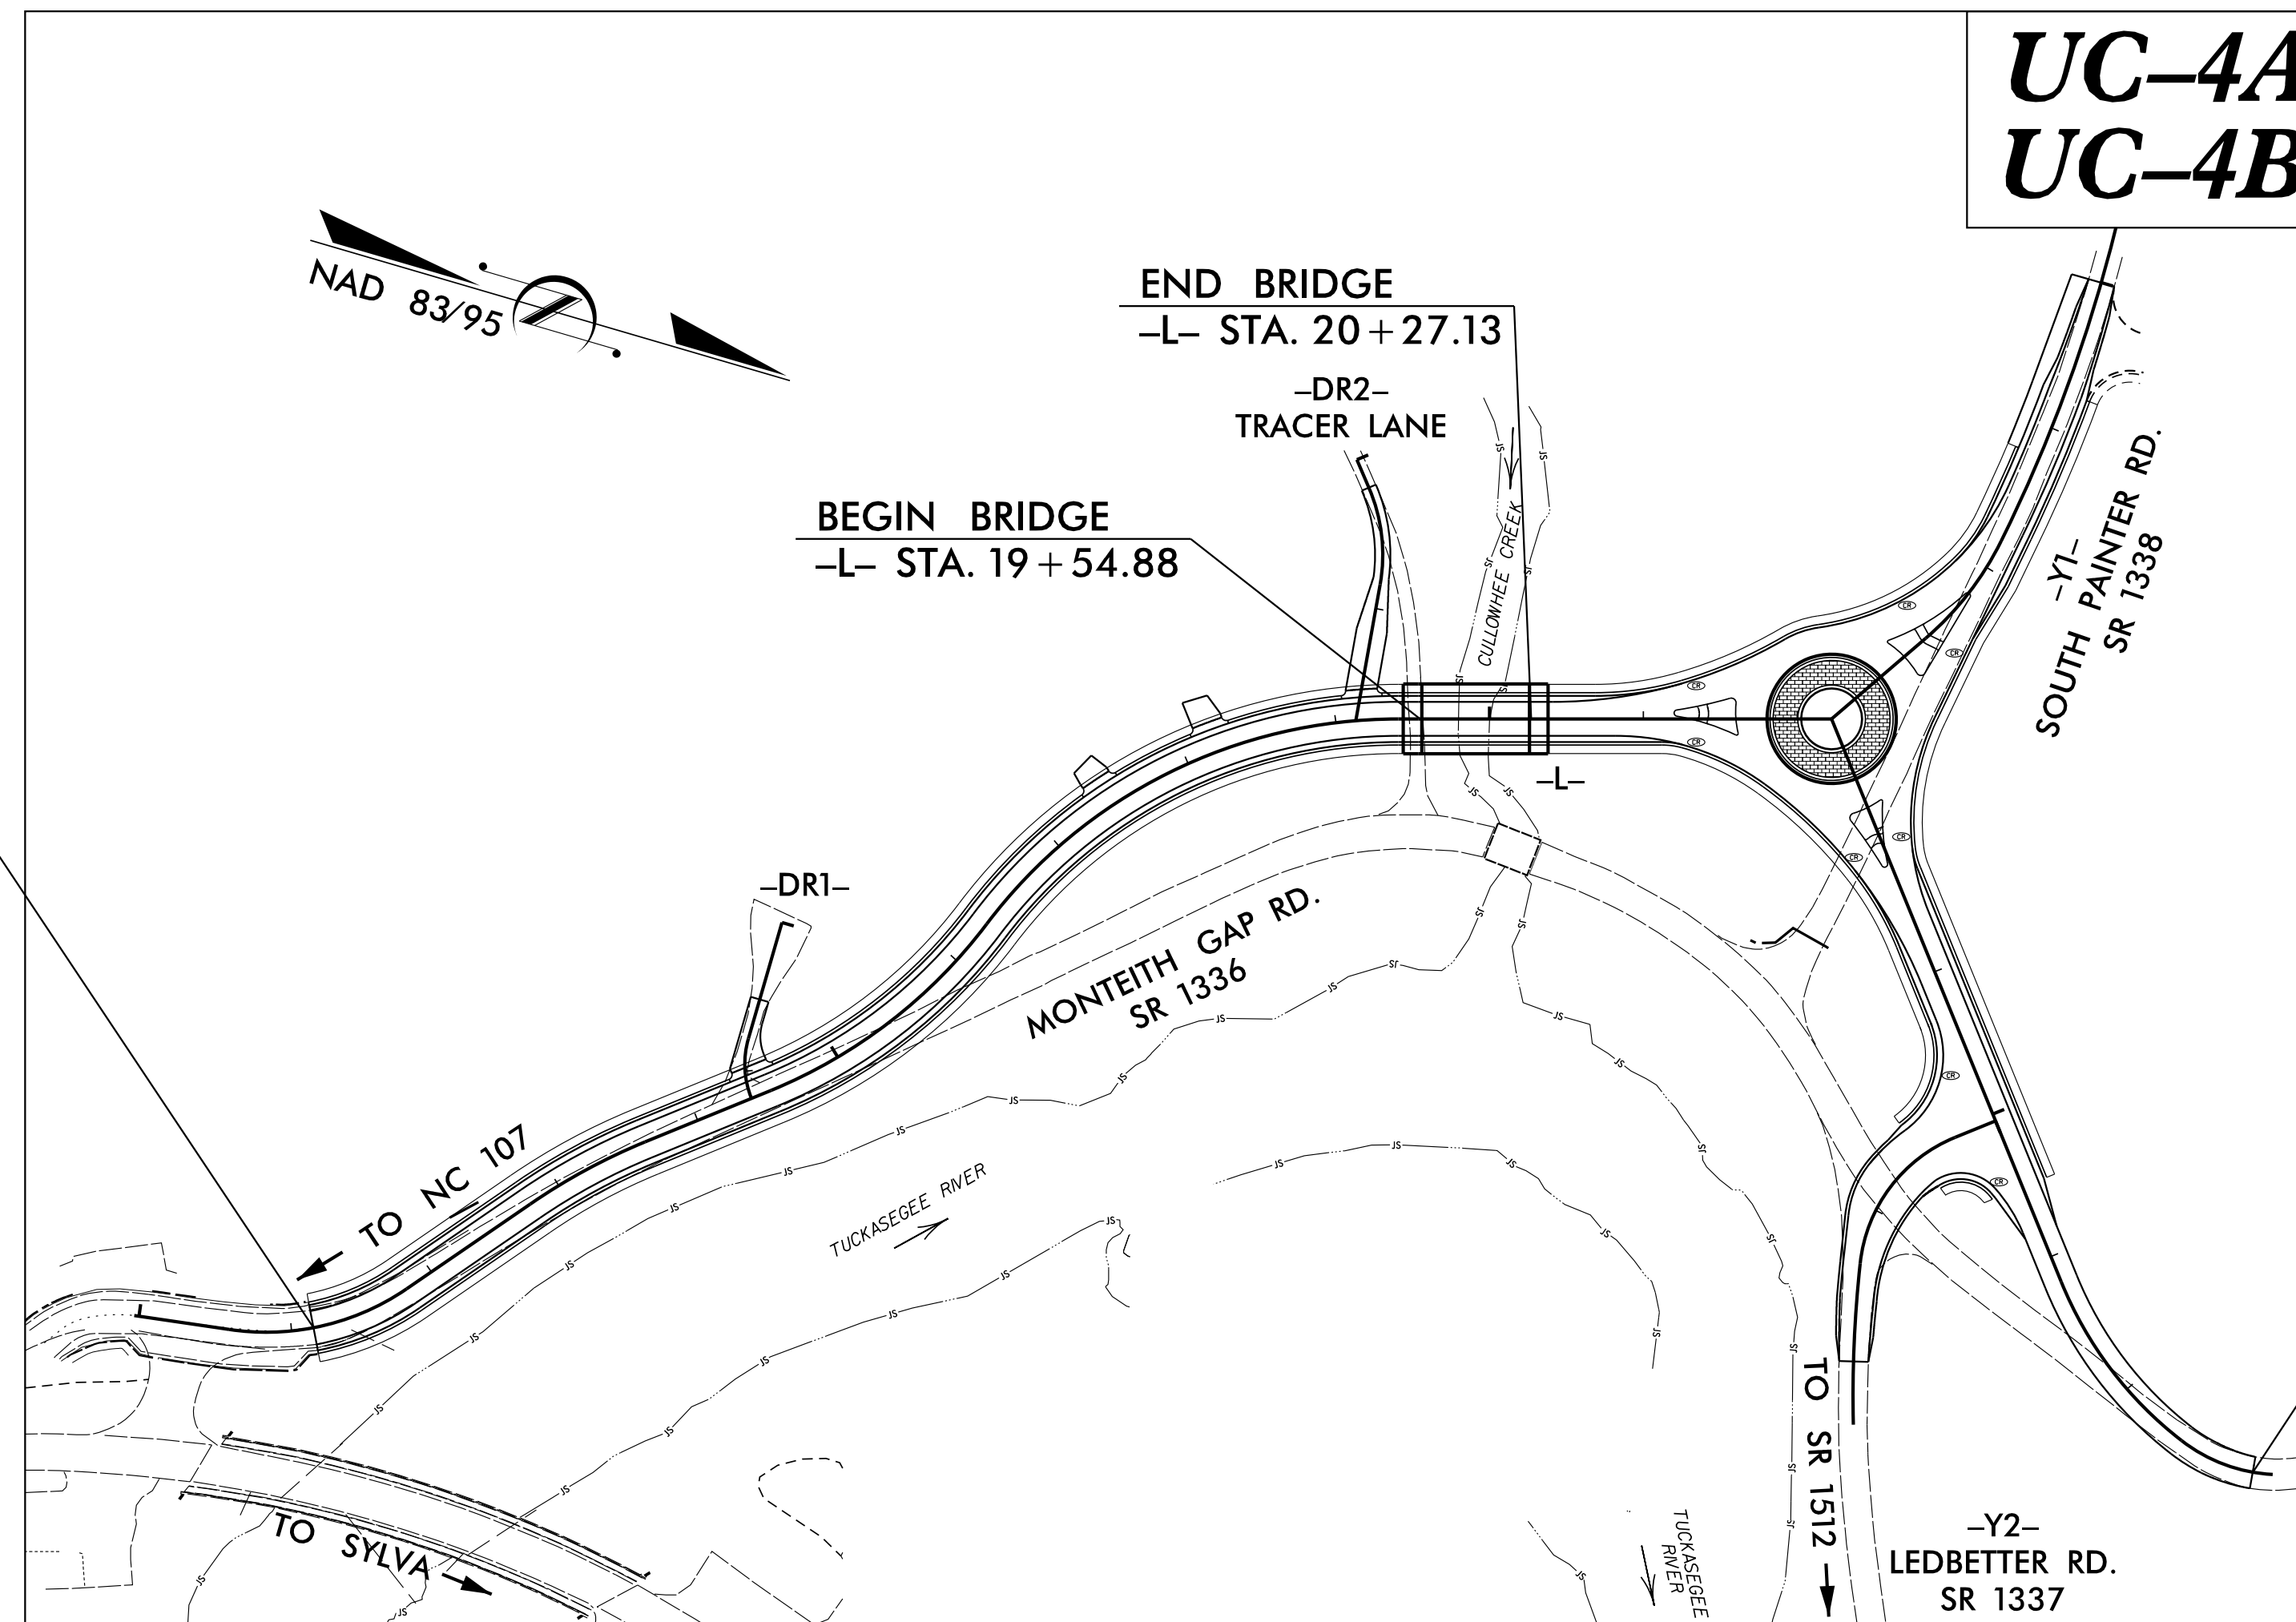

UC-4A
UC-4B

END CONSTRUCTION
PROJECT 17BP.14.R.212
-L- STA. 28+00.00

DOCUMENT NOT CONSIDERED FINAL
UNTIL ALL SIGNATURES ARE COMPLETED

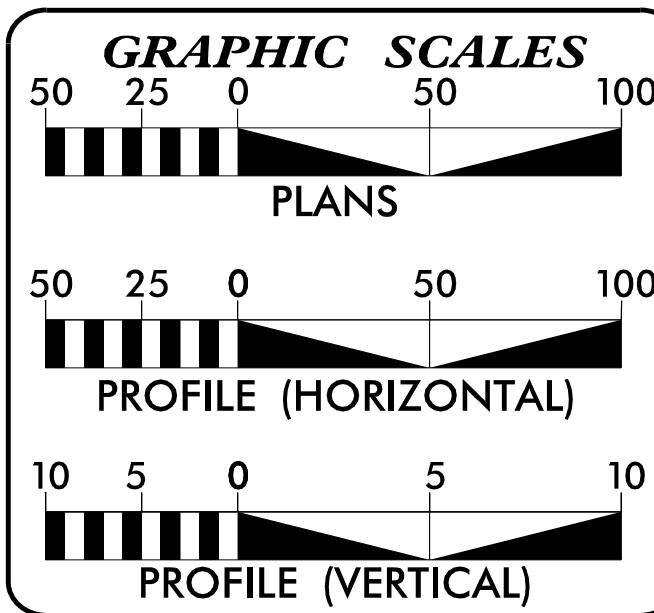

SHEET NO.	DESCRIPTION
UC-1	TITLE SHEET
UC-2	UTILITY SYMBOLOGY
UC-3	UTILITY CONSTRUCTION NOTES
UC-3A thru UC-3C	UTILITY DETAILS
UC-4	UTILITY PLAN SHEET (WATER) -WL-1-, -WL-2- & -WL-3-
UC-4A	UTILITY PROFILE SHEET (WATER) -WL-1-, -WL-2- & -WL-3-
UC-4B	UTILITY PLAN & PROFILE SHEET (SEWER)-SL-1- & -SL-2-

(1) WATER & SEWER - TUCKASEEGEE WATER & SEWER AUTHORITY (TWSA)

PREPARED IN THE OFFICE OF:

Consulting Engineers
1318-F Patton Avenue
Asheville, NC 28806
(828) 253-2796

SEAL: [Professional Engineer Seal for Reece Schuler, P.E., No. 26960, State of North Carolina, expires 6/6/2023]

Reece Schuler, P.E. PROJECT UTILITY ENGINEER
James Montgomery PROJECT UTILITY COORDINATOR
David Dawson PROJECT UTILITY DESIGNER

NORTH CAROLINA DEPARTMENT OF TRANSPORTATION -DIVISION 14
253 WEBSTER ROAD
SYLVA, NC 28779
WANDA H. AUSTIN, P.E.
DIVISION ENGINEER
PHONE (828) 586-2141

Zach Shuler, P.E. PROJECT TEAM LEAD
Robert Golding DIVISION UTILITIES ENGINEER
Lynn Kieselhorst DIVISION UTILITIES COORDINATOR