

STATE OF NORTH CAROLINA
DIVISION OF HIGHWAYS

NASH COUNTY


LOCATION: US 64 (FUTURE I-87) FROM SR-1306 (SOUTH OLD FRANKLIN RD.)
TO SR-1603 (OLD CARRIAGE RD.)

TYPE OF WORK: PAVEMENT REHABILITATION.

STATE	STATE PROJECT REFERENCE NO.	SHEET NO.	TOTAL SHEETS
N.C.	I-6045	1	
STATE PROJ. NO.	F.A. PROJ. NO.	DESCRIPTION	
47994.1.1		PE	
47994.3.2	NHPIM-0087(044)	CONST	

TIP PROJECT: I-6045

CONTRACT: C204820

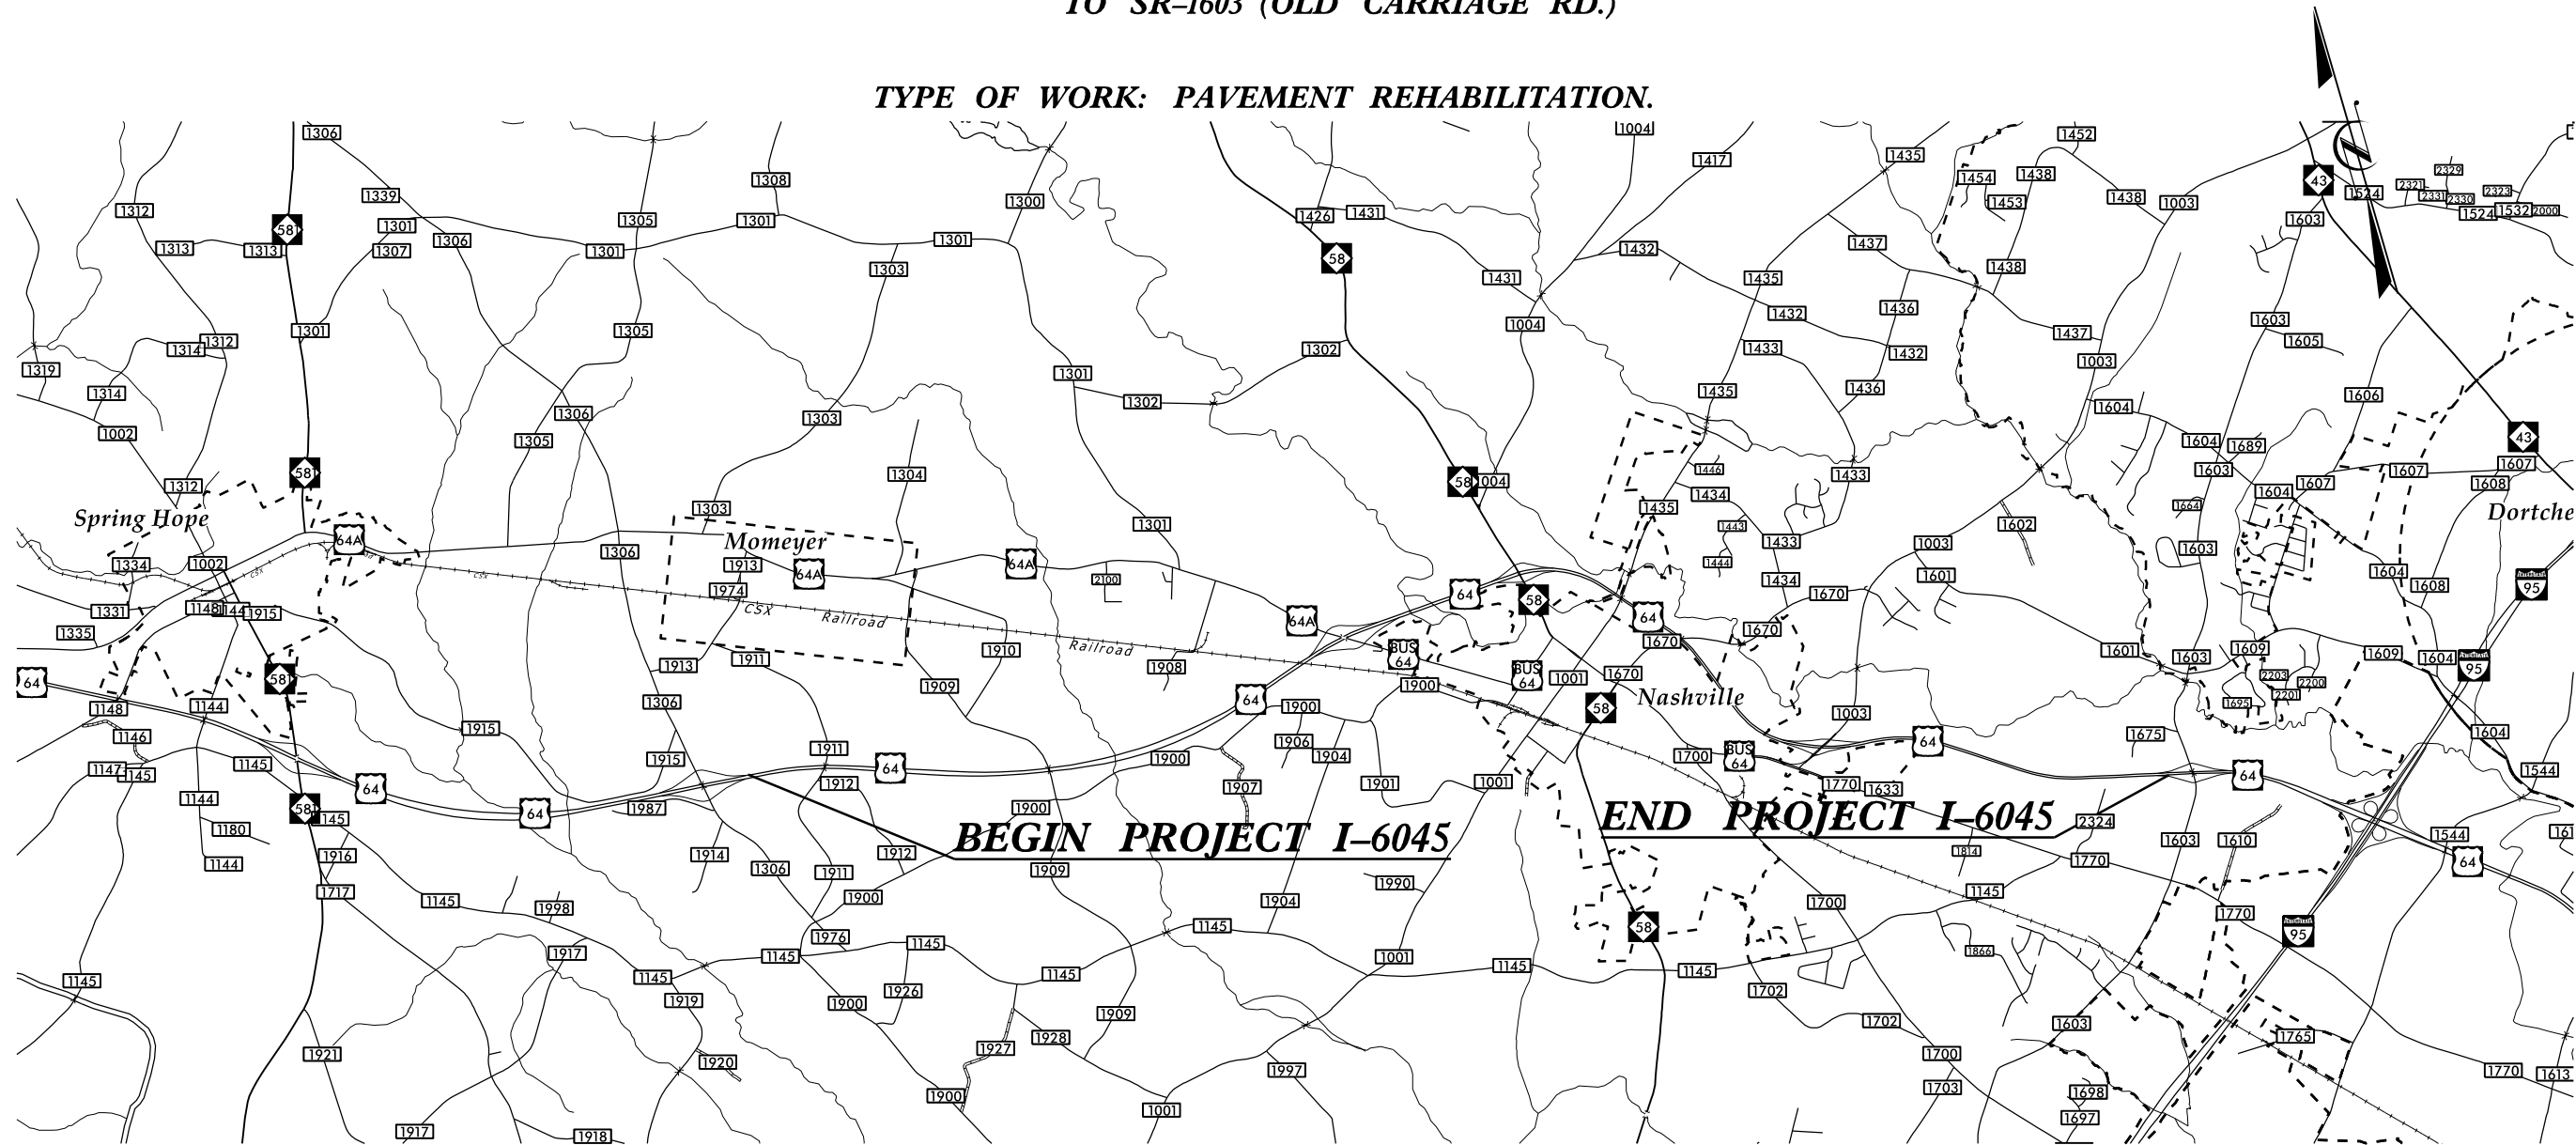

VICINITY MAP

DESIGN DATA
ADT 2017 = 44000

FUNCTIONAL CLASS
OTHER FREEWAY
(FUTURE INTERSTATE)

PROJECT LENGTH

LENGTH ROADWAY (WBL) TIP PROJECT I-6045 = 9.47 MILES
TOTAL LENGTH TIP PROJECT I-6045 = 9.47 MILES

Prepared in the Office of:
DIVISION OF HIGHWAYS
Division 4 DDC
509 Ward Blvd., Wilson NC, 27895

2018 STANDARD SPECIFICATIONS

RIGHT OF WAY DATE:
NA

LETTING DATE:
JULY 18, 2023

KEITH EASON, PE
PROJECT ENGINEER

D.R. ETHRIDGE
PROJECT DESIGN ENGINEER



30-MAY-2023 14:09
C:\Users\drehring\OneDrive\Desktop\I-6045\I-6045-DDC4_DDC4_1sh.dgn
Division 4 DDC