


NASH COUNTY

PROJECT REFERENCE NO.	SHEET NO.
L-6045 47994.3.2	2

2

1

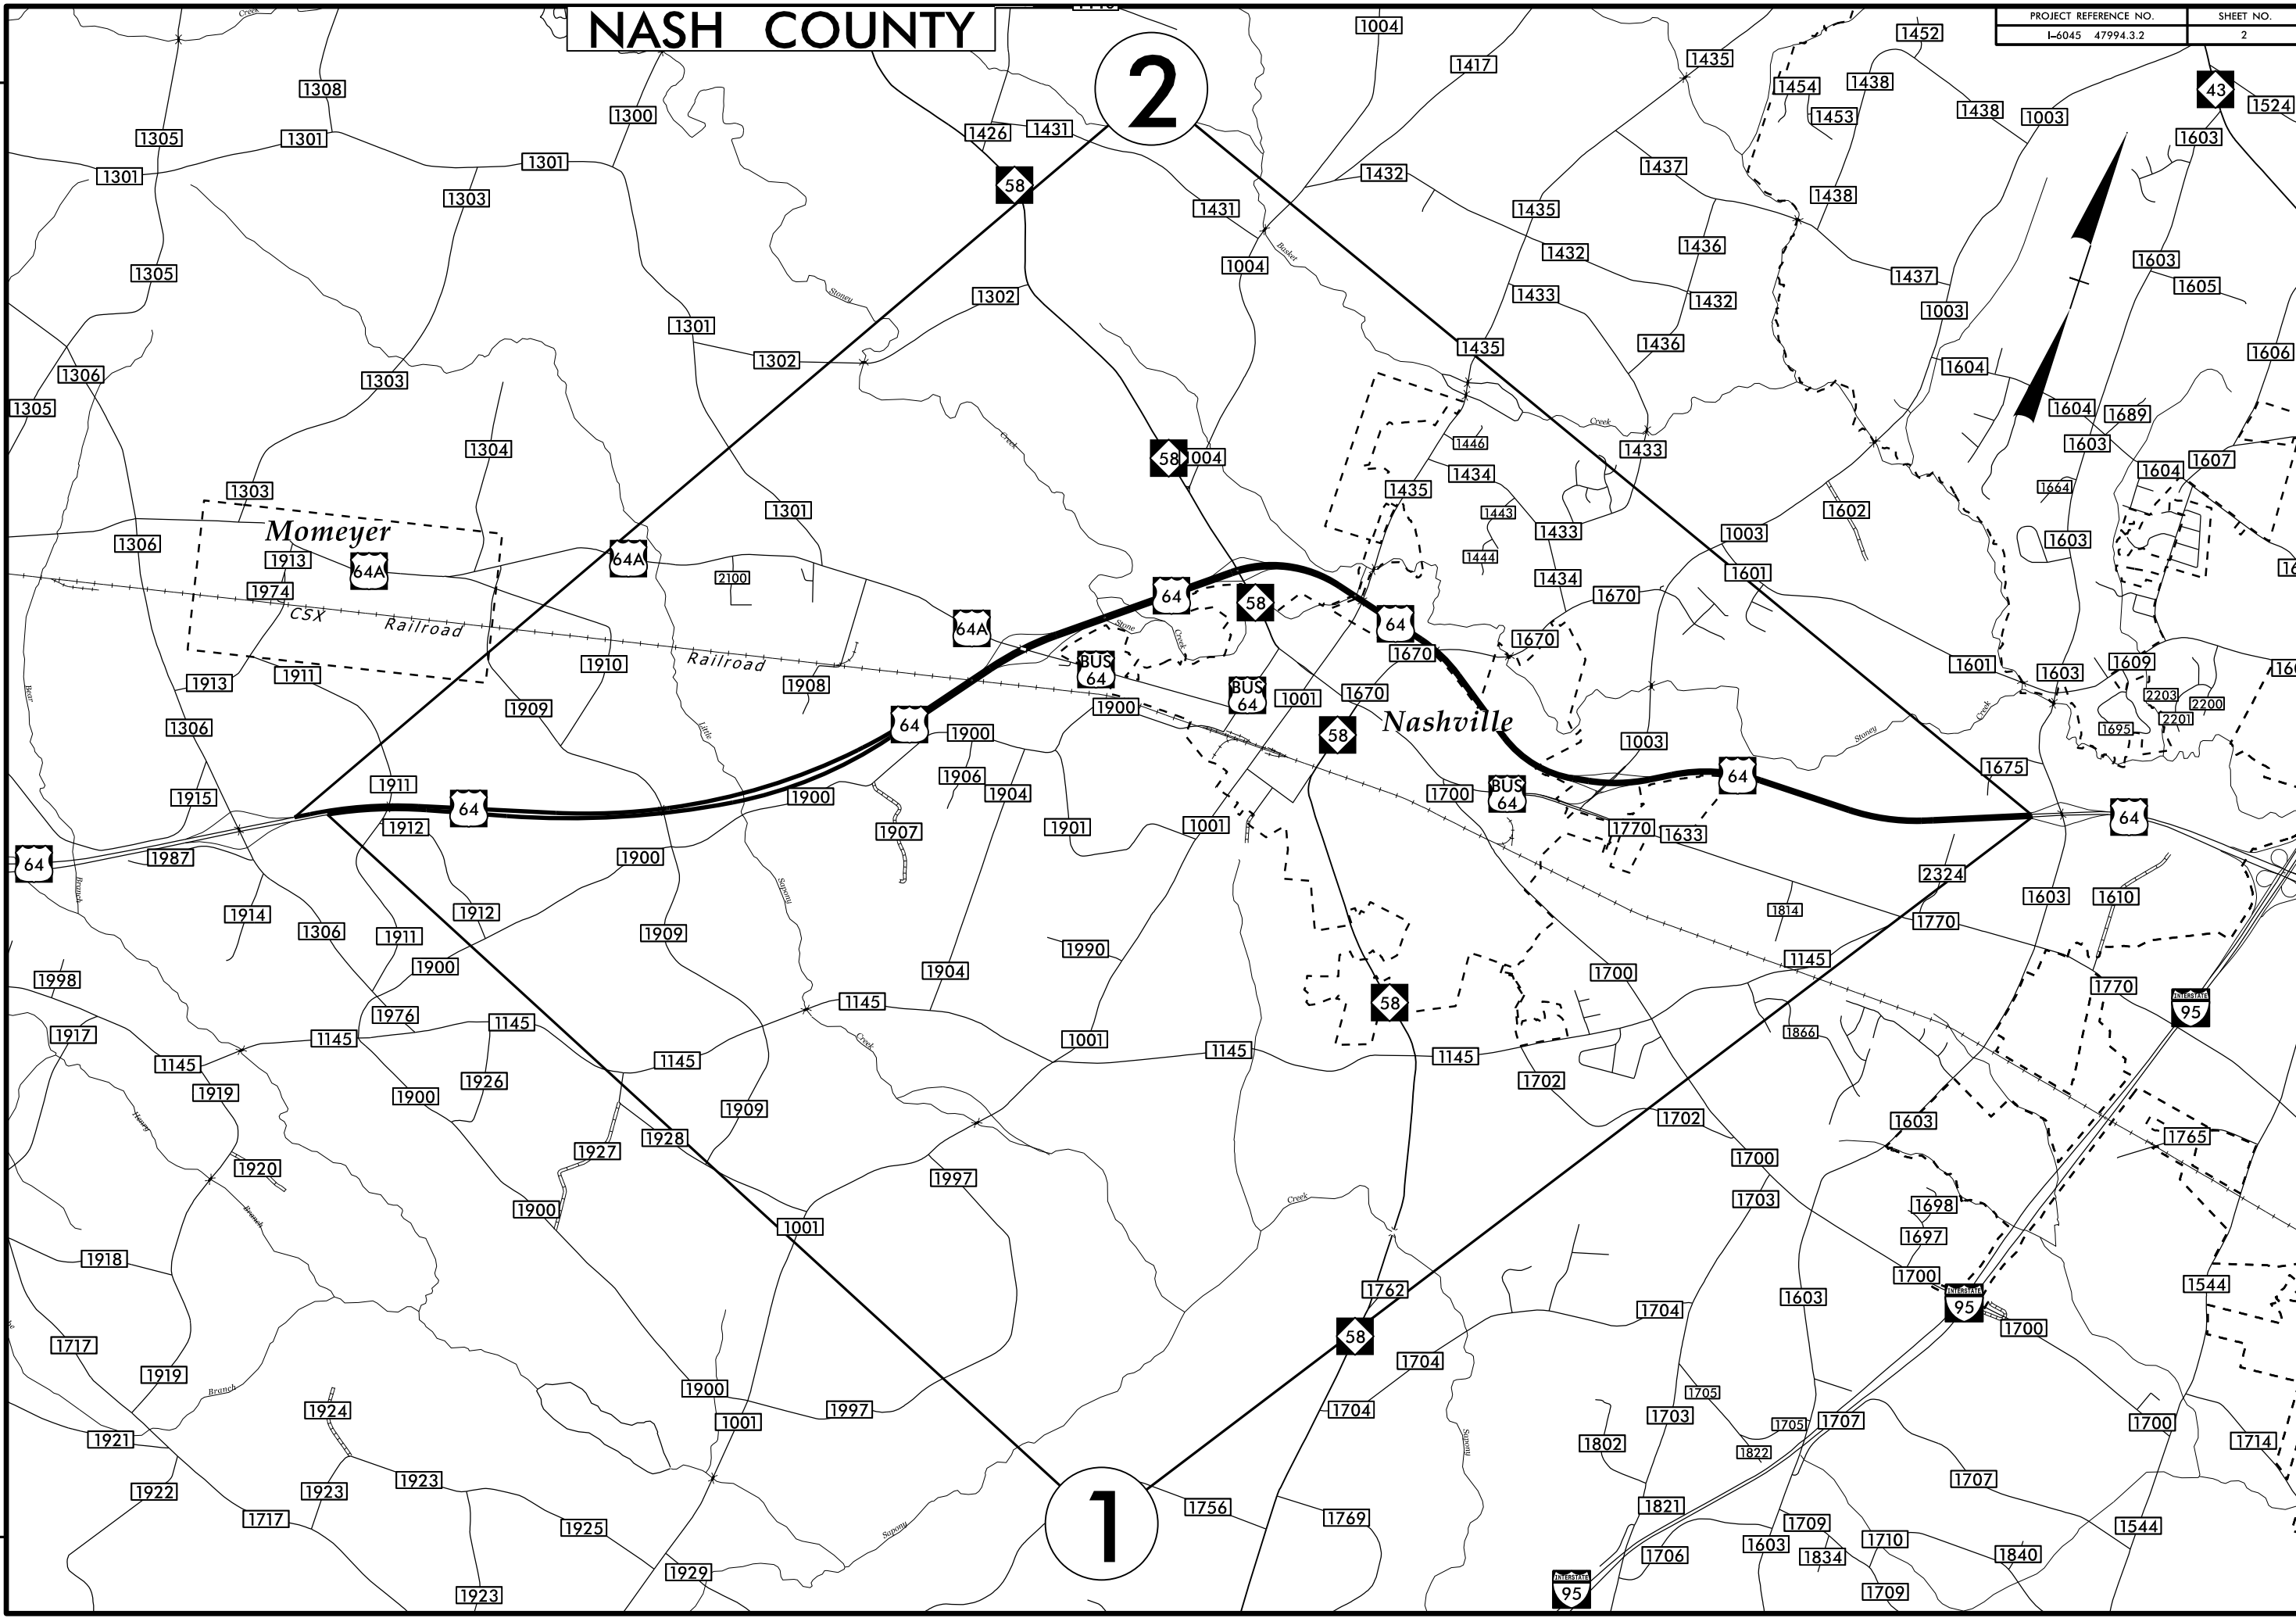

REVISIONS

01-MAR-2023 14:32
 C:\Users\drehrtdge\Desktop\1-604_1-6045_DDCA_MAPS_PRINT 1.dgn
 Division 4 DDC