


PLAN AND PROFILE OF NOISE WALL 2

Stantec
 Stantec Consulting Services Inc.
 801 Jones Franklin Road
 Suite 300
 Raleigh, NC 27606
 Tel. (919) 851-6866
 Fax. (919) 851-7024
 www.stantec.com
 License No. F-0672

PROJECT REFERENCE NO. R-3833C	SHEET NO. 2N-1
RW SHEET NO.	
ROADWAY DESIGN ENGINEER <i>A. Dean Sarvis</i> 19828	GEOTECHNICAL ENGINEER <i>J. James K. Brown</i> 39779
4/27/2023	4/27/2023


**DOCUMENT NOT CONSIDERED FINAL
UNLESS ALL SIGNATURES COMPLETED**

FALCON ENGINEERING
 FALCON ENGINEERING, INC.
 1210 TRINITY ROAD, SUITE 110
 CARY, NC 27513
 PHONE: 919.871.0800
 www.falconengineers.com
 Corporate License Number C-3193

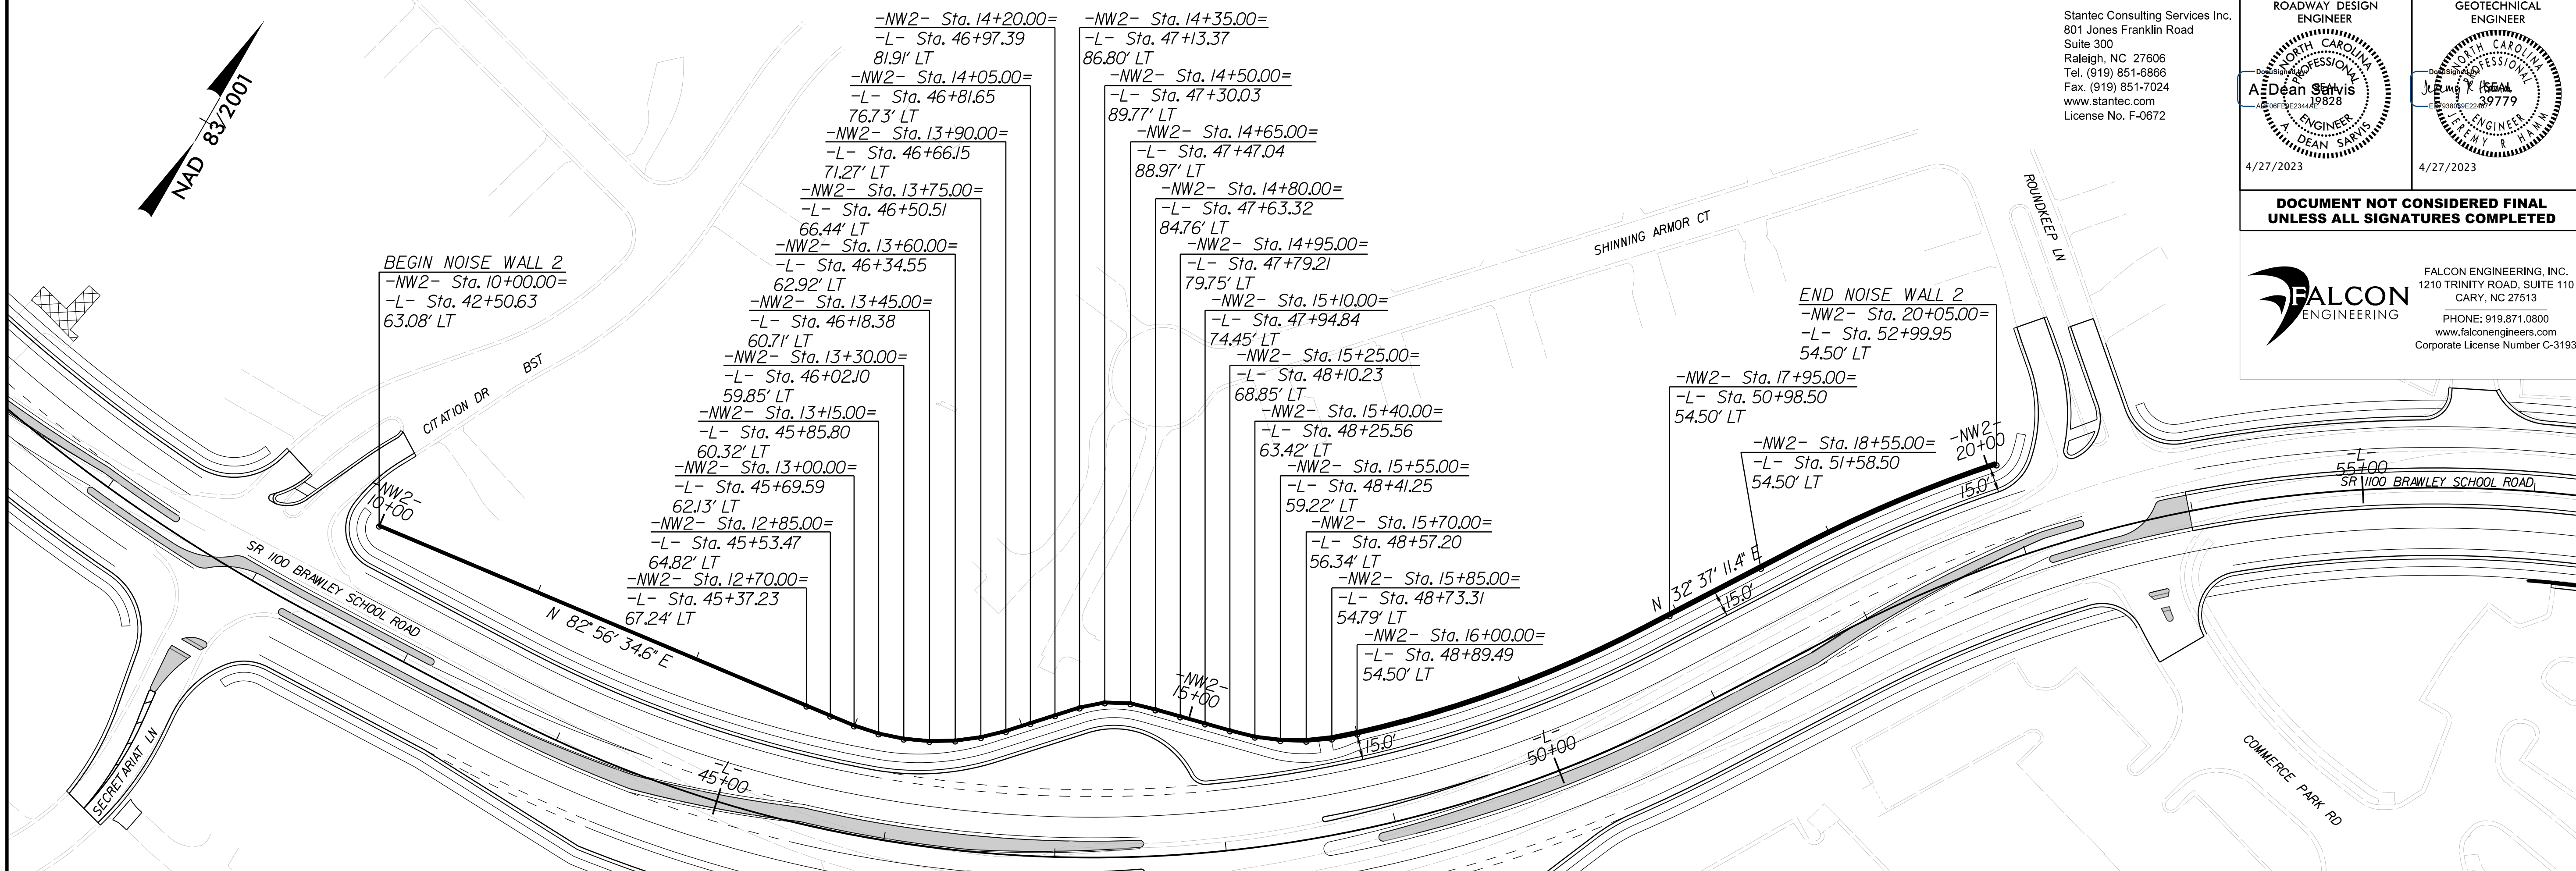

NOISE WALL 2

PANEL NUMBER	1	2-3	4	5-6	7-8	9	10-11	12-13	14	15	16	17-18	19	20	21	22-23	24-25	26	27-31	32-33	34	35-37	38-49	50-53	54-56	57-59	60-62	63-66	67
TOP ELEVATION	812'	813'	814'	815'	816'	817'	818'	819'	820'	821'	822'	823'	824'	825'	826'	827'	828'	828'	829'	830'	830'	831'	832'	832'	832'	833'	834'	835'	835'
PANEL LENGTH	15'	30'	15'	30'	30'	15'	30'	30'	15'	15'	15'	30'	15'	15'	30'	30'	15'	15'	75'	30'	15'	45'	180'	60'	45'	45'	45'	60'	15'
PANEL HEIGHT	7'	7'	7'	7'	7'	7'	7'	7'	7'	7'	8'	8'	8'	9'	10'	10'	11'	10'	11'	12'	11'	12'	13'	12'	11'	11'	11'	11'	10'

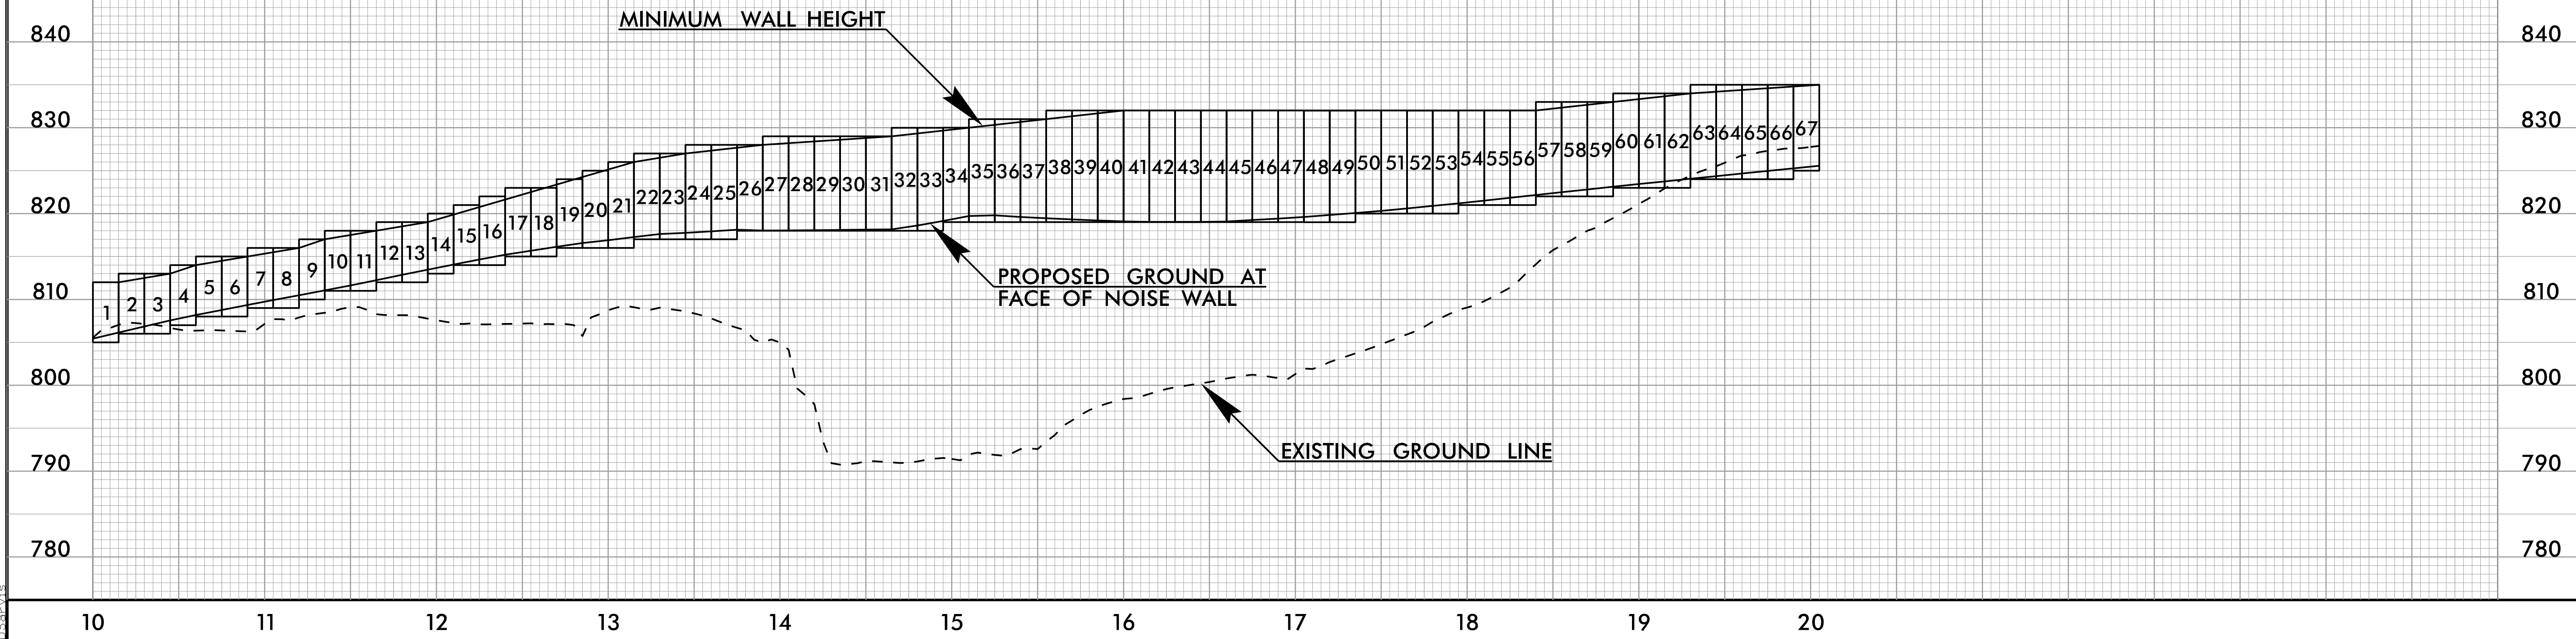

I:\V2022\34171002034\transportation\R3833C\HEU_Noise_Air\VDGN\R3833C_NW2_psh01.dgn
 8/17/2023 10:20:34 AM A. Dean Sarvis