


TIP PROJECT: R-3833C


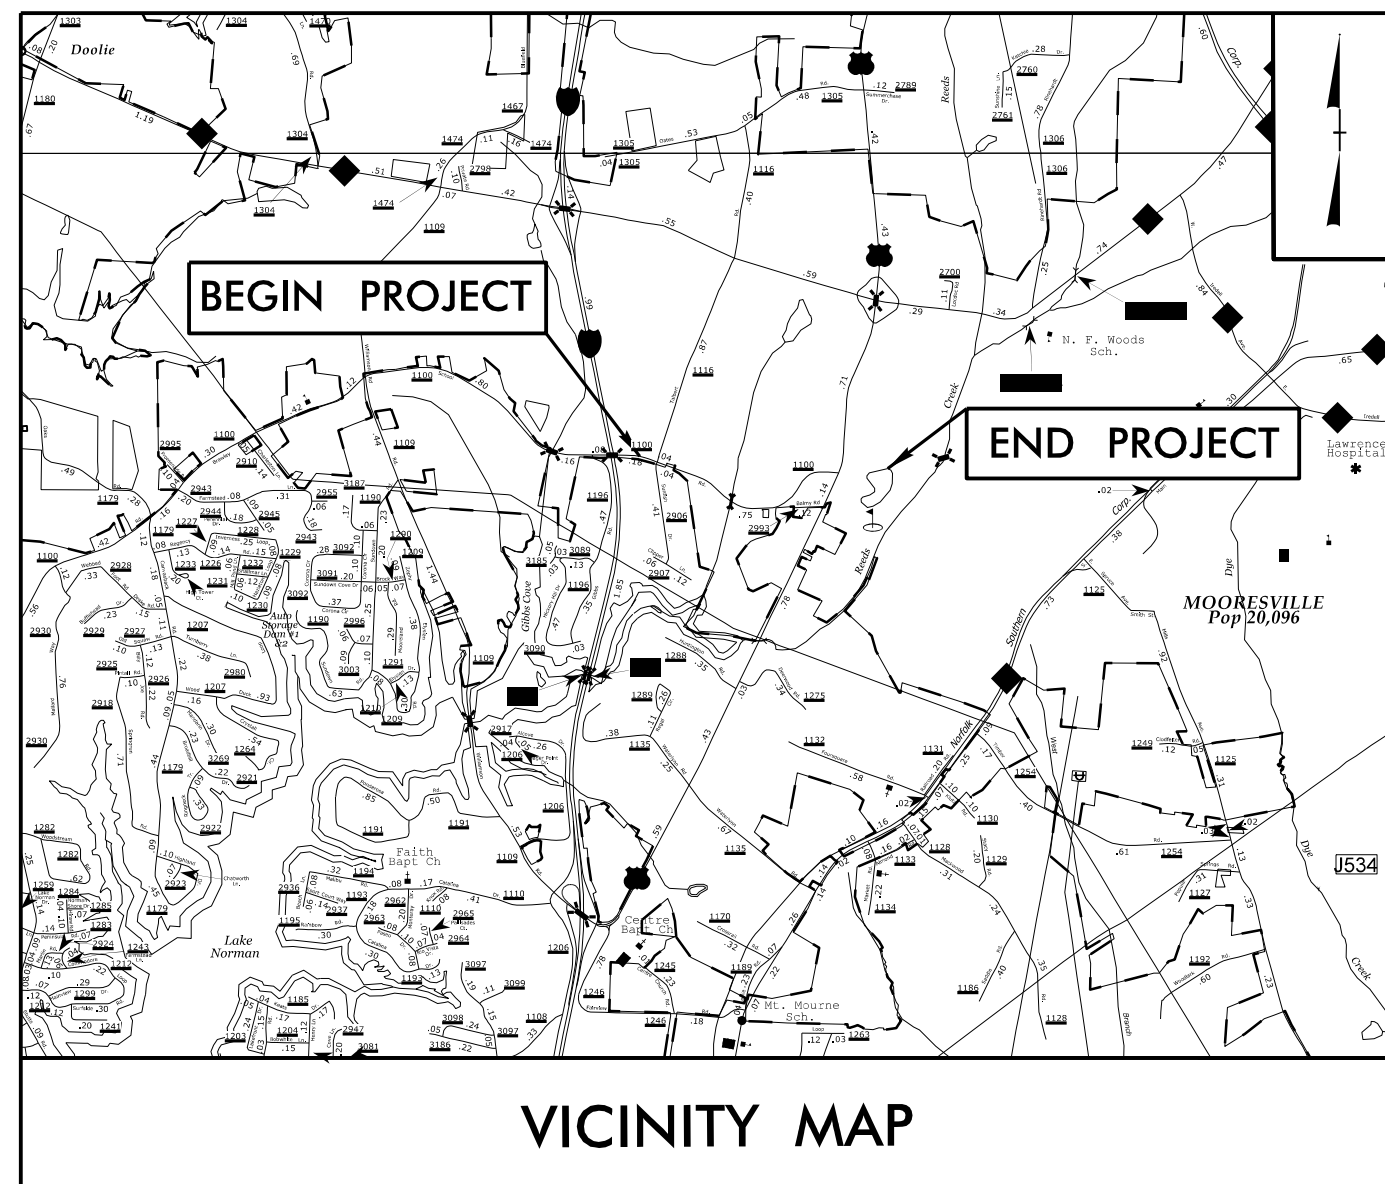


STATE OF NORTH CAROLINA
DIVISION OF HIGHWAYS

IREDELL COUNTY


**LOCATION: SR 1100 BRAWLEY SCHOOL ROAD FROM
SR 1116 TALBERT ROAD TO
1000' EAST OF US 21**

TYPE OF WORK: TRAFFIC SIGNALS & SIGNAL COMMUNICATIONS

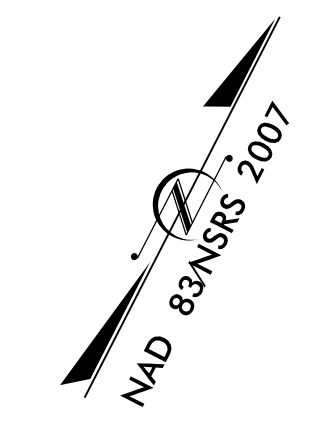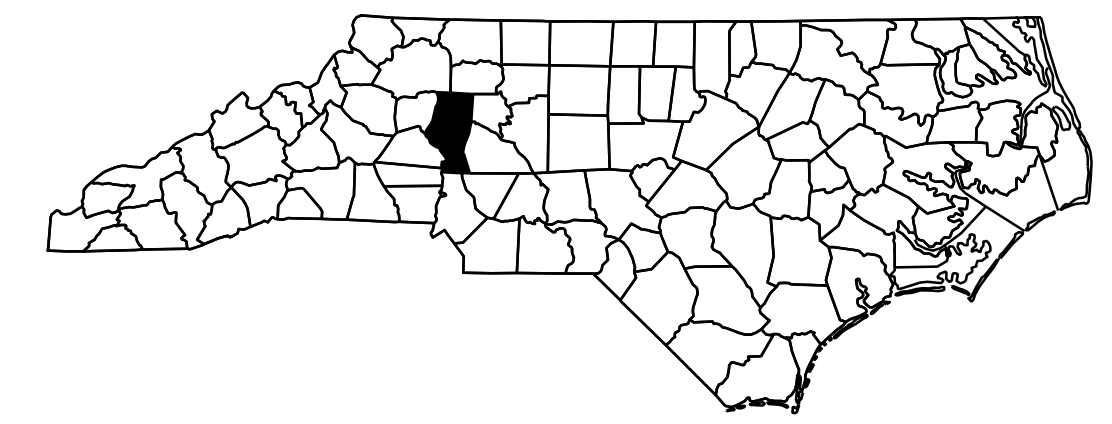

**BEGIN TIP PROJECT R-3833C
-L- POT 18+05.86
BRAWLEY SCHOOL ROAD**

**END TIP PROJECT R-3833C
-L- STA. 75+82.64
WEST WILSON AVENUE**

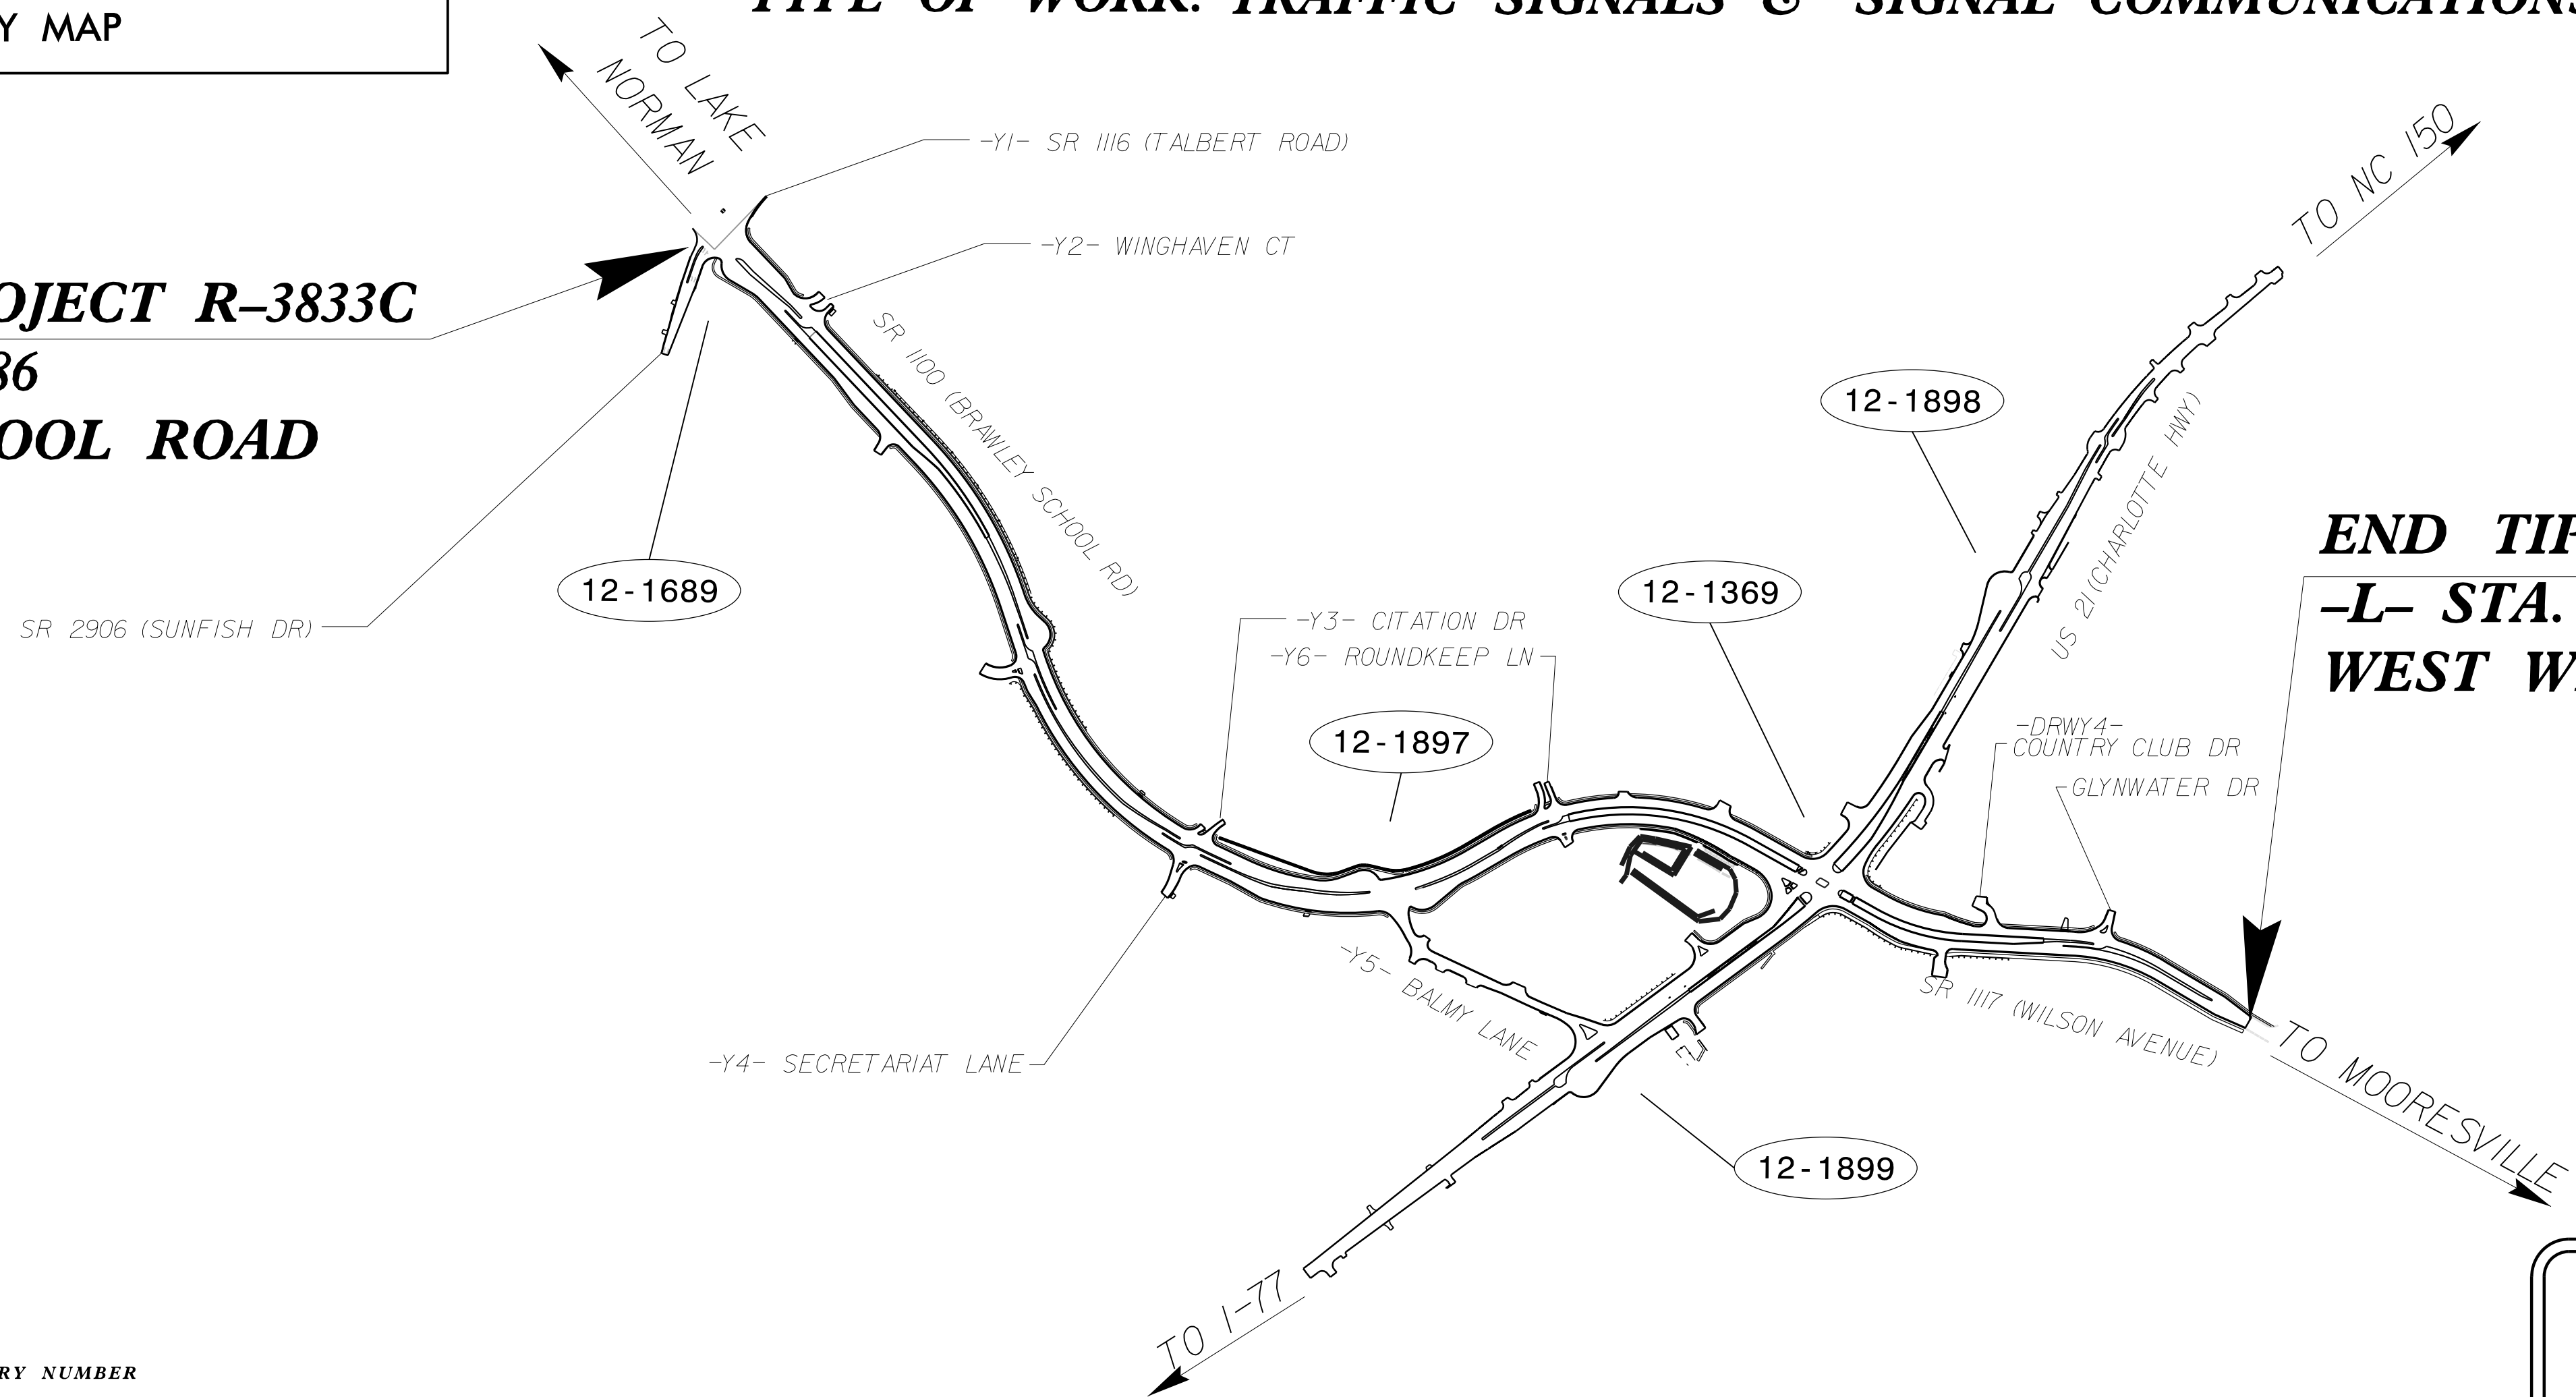

LEGEND
XX-XXXX - SIGNAL INVENTORY NUMBER

Refer to "Roadway Standard Drawings NCDOT" dated January 2018 and "Standard Specifications for Roads and Structures" dated January 2018.

INDEX OF PLANS		
SHEET NO.	SIG. INV. #	DESCRIPTION
SIG-1.0		Title Sheet
SIG-1.1 - SIG-1.2		Standard Plate Sheets
SIG-2.0 - SIG-5.3	12-1689	SR 1100 (Brawley School Road) at SR 1116 (Talbert Road) / SR 2906 (Sunfish Drive)
SIG-6.0 - SIG 6.6	12-1897	SR 1100 (Brawley School Road) at Balmy Lane
SIG-7.0 - SIG-12.5	12-1369	US 21 (Charlotte Highway) at SR 1100 (Brawley School Road) / SR 1117 (Wilson Avenue)
SIG-13.0 - SIG-13.2	12-1898	US 21 (Charlotte Highway) at SR 1100 (Brawley School Road) U-Turn
SIG-14.0 - SIG-14.2	12-1899	US 21 (Charlotte Highway) at SR 1100 (Wilson Avenue) U-Turn / Balmy Lane
MI - M8		Metal Pole Standards
SCP-01 - SCP-10		Signal Communication Plans

 
INTELLIGENT TRANSPORTATION AND SIGNALS UNIT
Contacts:
Tim Williams, PE
Signals Engineer, Western Region
Todd Joyce, PE
Signal Equipment Design Review Engineer
Gregory Green
Signal Communication Project Engineer
Heidi Berggren, EIT
Signal Communication Project Design Engineer


Plans Prepared for the NCDOT
DIVISION OF HIGHWAYS
TRANSPORTATION MOBILITY & SAFETY DIVISION

750 N. Greenfield Parkway, Garner, NC 27529

Stantec
Stantec Consulting Services Inc.
801 Jones Franklin Rd-Suite 300
Raleigh, NC 27606
Tel. 919.851.6866
Fax. 919.851.7024
www.stantec.com
License No. F-0672

Betsy L. Watson, PE Senior Principal
Derrick Waller, PE Transportation Engineer
Regina Muncey, PE Transportation Engineer
James Hambright Senior Transportation Technician

APPROVED: 
DATE: 3/22/2023

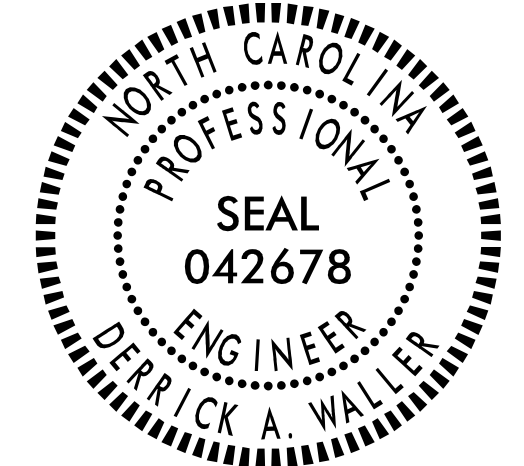

2/14/23 4:03 PM C:\Signals\Design\Title Sheet\R-3833C.sig-tsh.dgn User:dwaller