


TIP PROJECT: R-3833C

T.I.P. NO.	SHEET NO.
R-3833C	UC-01


STATE OF NORTH CAROLINA
DIVISION OF HIGHWAYS

**UTILITY CONSTRUCTION PLANS
IREDELL COUNTY**

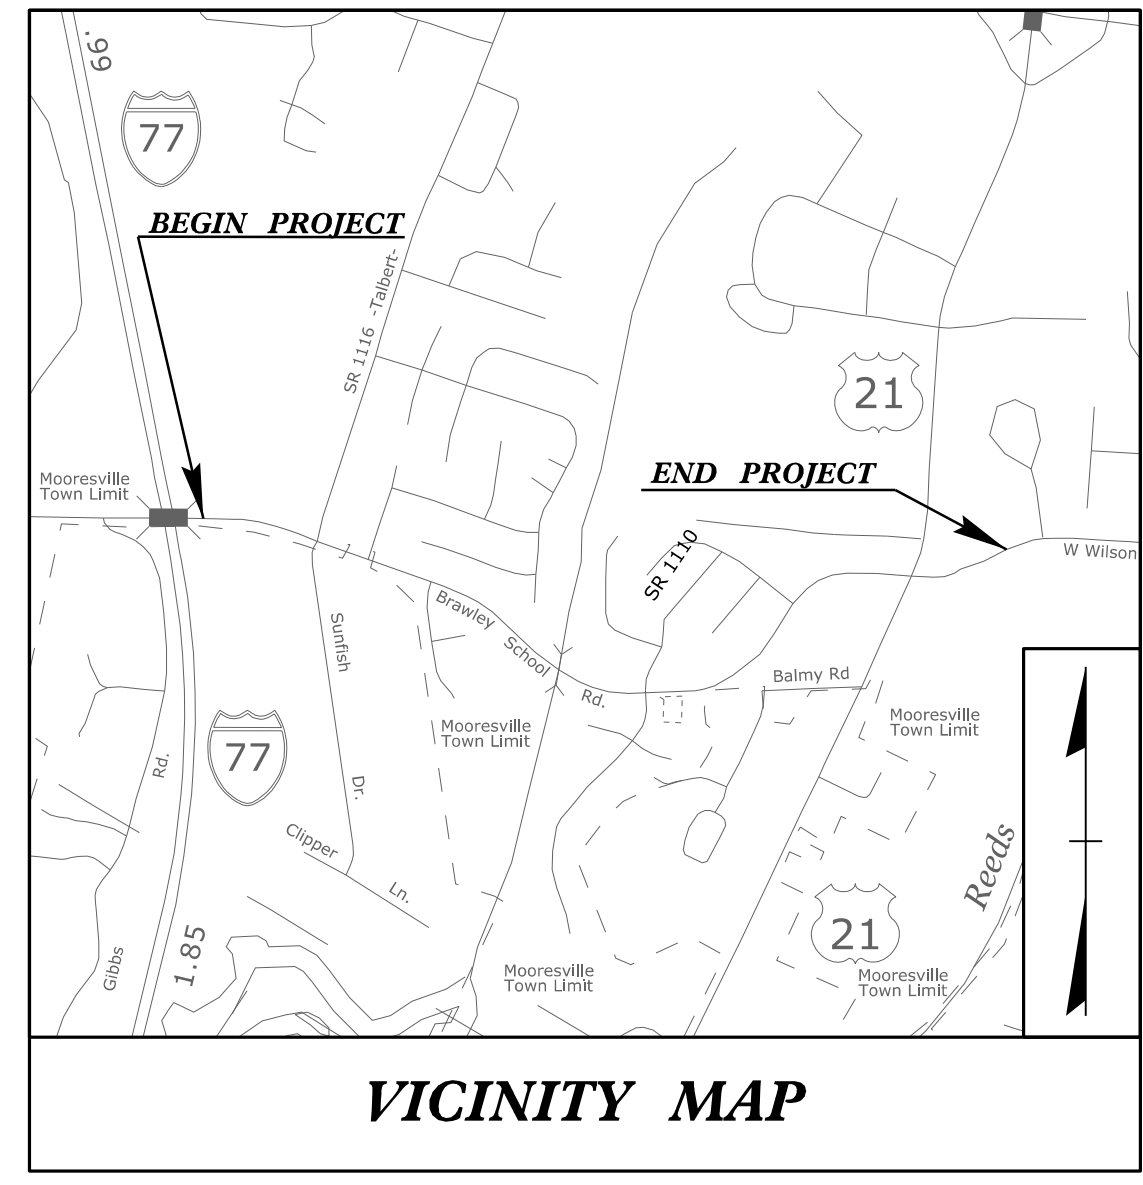


**LOCATION: SR 1100 BRAWLEY SCHOOL ROAD
FROM SR 1116 TALBERT ROAD
TO 1000' EAST OF US 21**

**TYPE OF WORK: UTILITY RELOCATES FOR
GRAVITY SANITARY SEWER, FORCED SANITARY
SEWER, AND WATER**

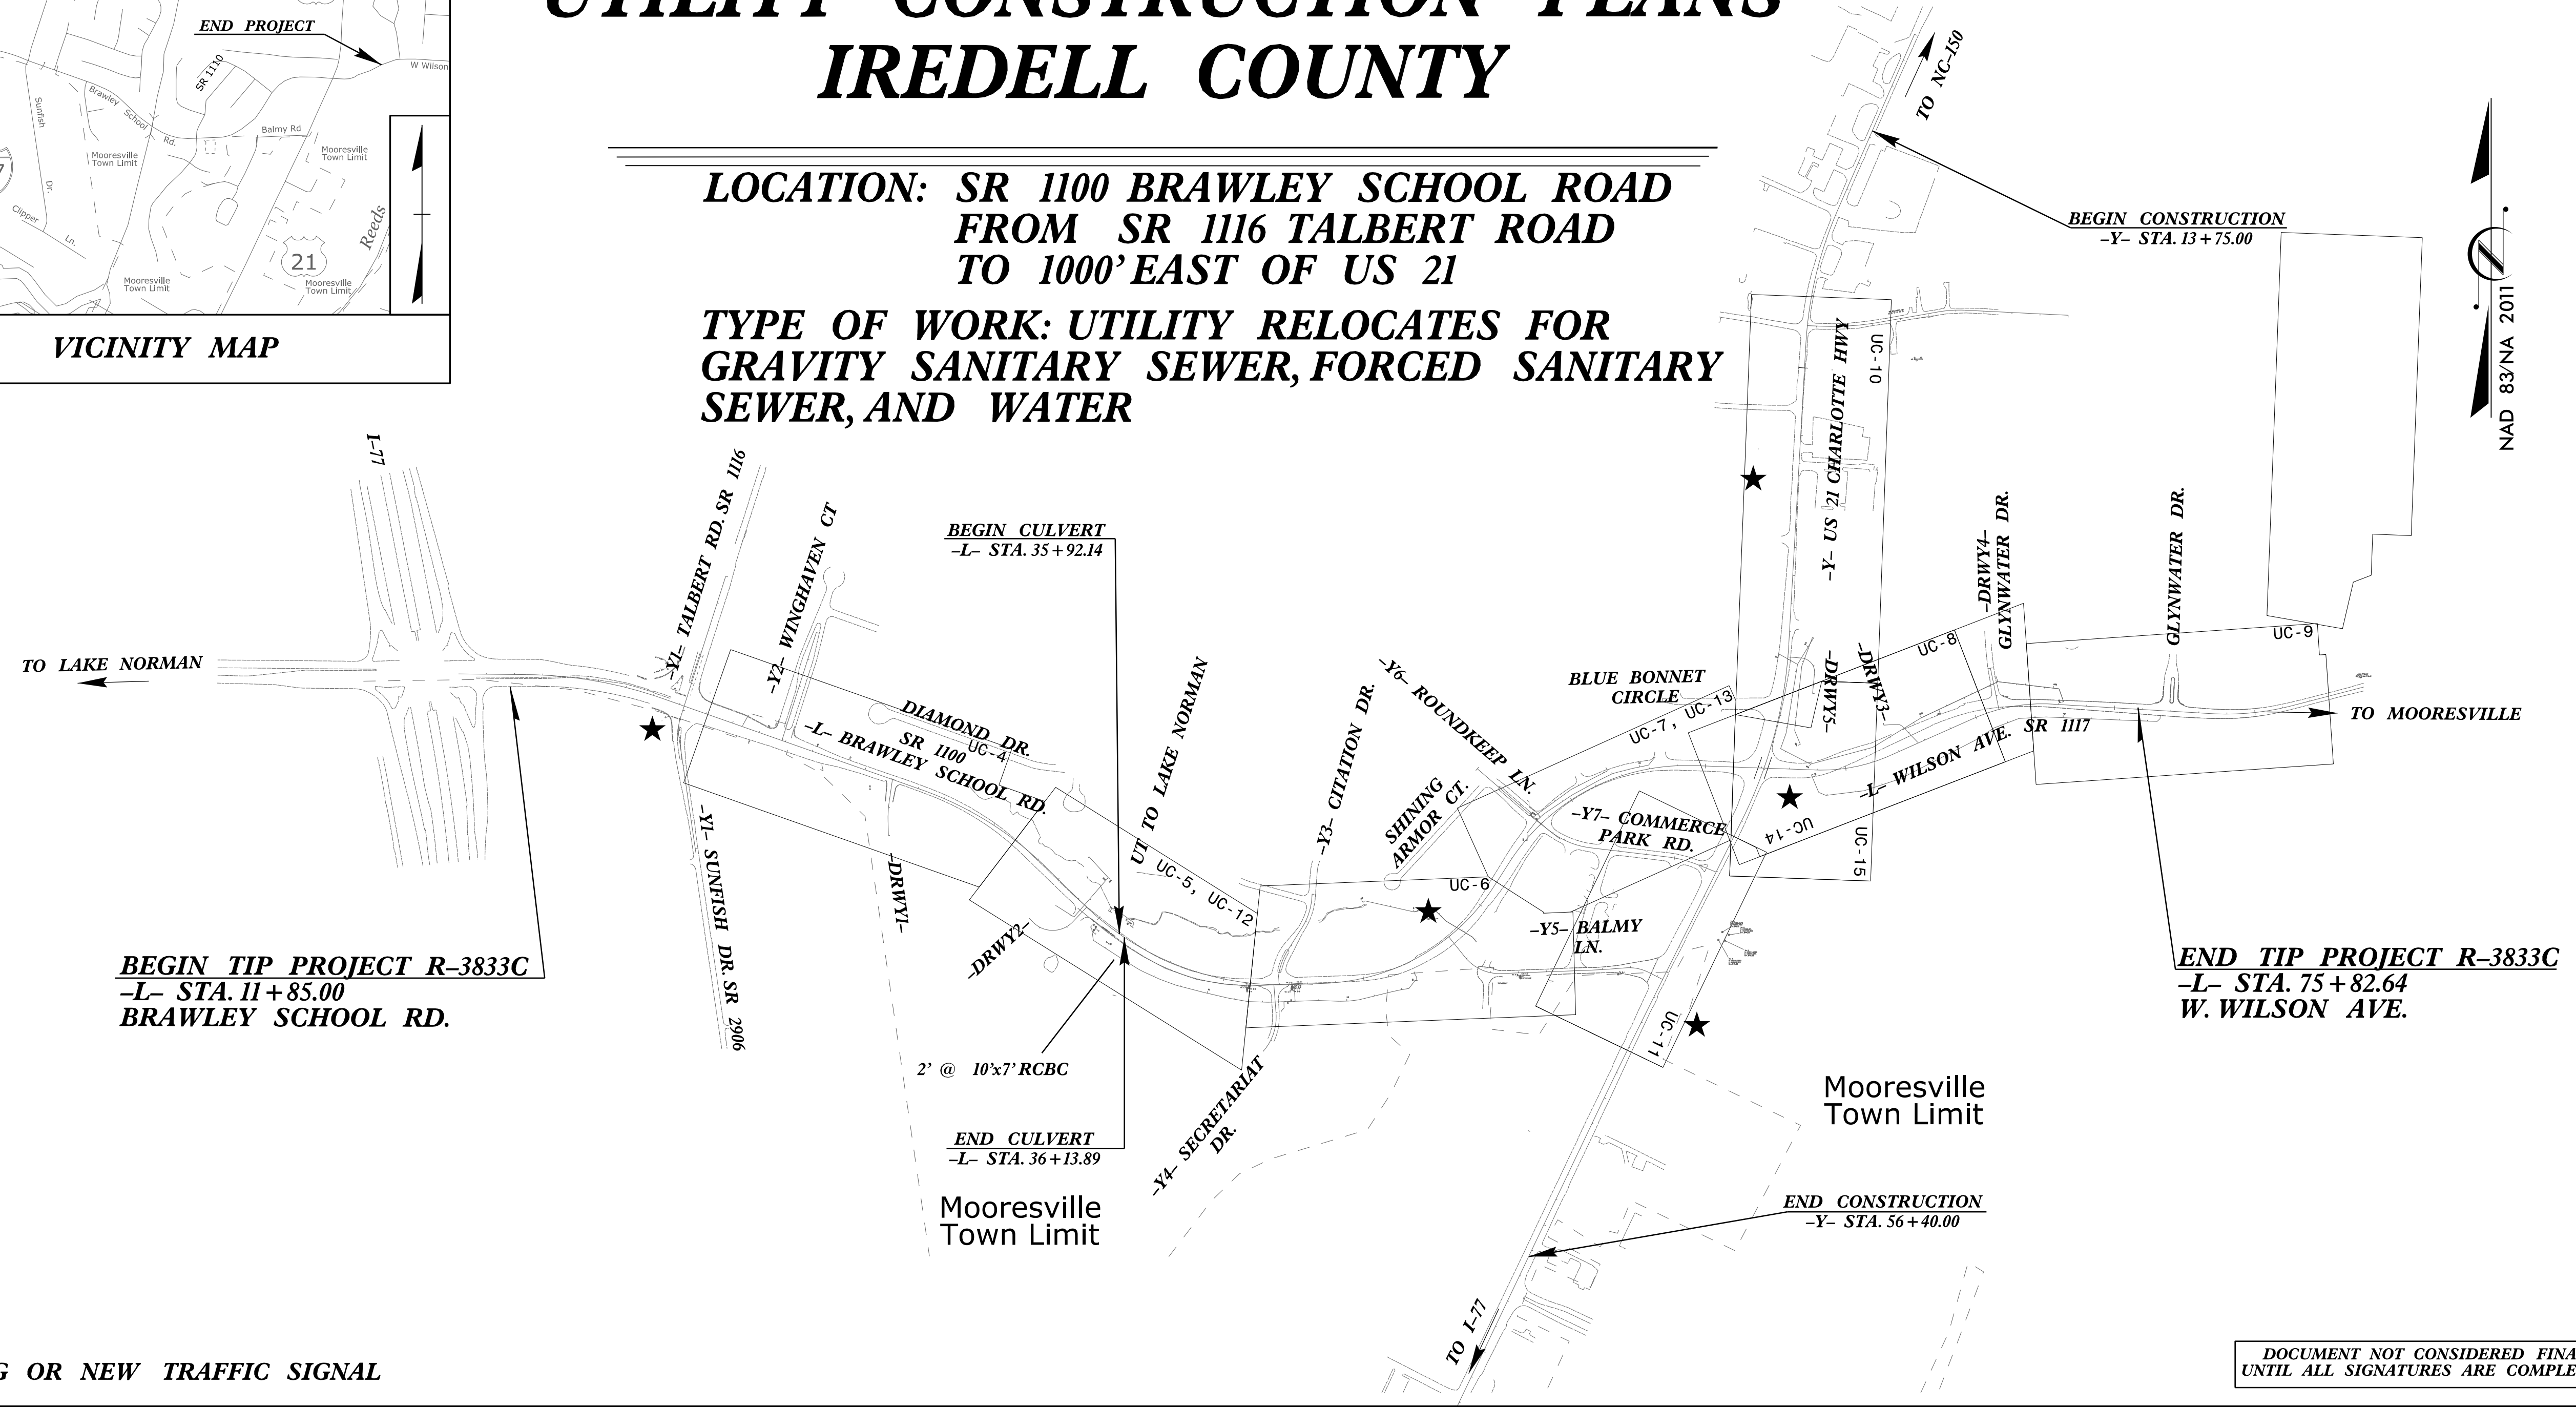

★ EXISTING OR NEW TRAFFIC SIGNAL

DOCUMENT NOT CONSIDERED FINAL
UNTIL ALL SIGNATURES ARE COMPLETED

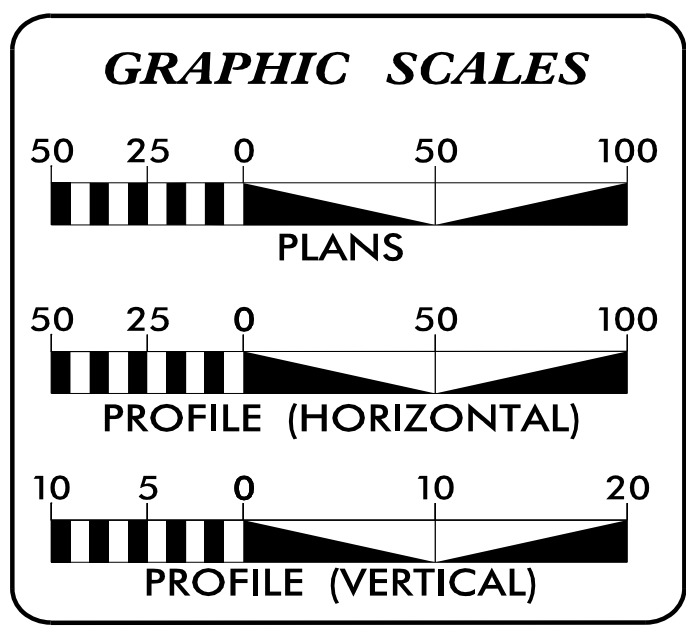

INDEX OF SHEETS

SHEET NO.:	DESCRIPTION:
UC-1	TITLE SHEET
UC-2	UTILITY SYMBOLOGY
UC-3	NOTES
UC-3A - UC-3I	DETAILS
UC-4 - UC-15	UTILITY CONSTRUCTION PLAN AND PROFILE SHEETS

WATER AND SEWER OWNERS ON PROJECT

TOWN OF MOORESVILLE PUBLIC UTILITIES
413 NORTH MAIN STREET
MOORESVILLE, NC 28115

PREPARED IN THE OFFICE OF

Stantec

STANTEC CONSULTING SERVICES INC.
801 JONES FRANKLIN ROAD
SUITE 300
RALEIGH, NC 27686
TEL: (919) 851-6865
FAX: (919) 851-7024
www.stantec.com
License No.: F-0672

DEAN SARVIS, PE CONSULTANT CONTACT #1
LINDA PASS, PE CONSULTANT CONTACT #2
LAURA WILSON, PE CONSULTANT CONTACT #3

SEAL

8/24/2023

DIVISION OF HIGHWAYS UTILITIES UNIT
1555 MAIL SERVICES CENTER
RALEIGH, NC 27699-1555
PHONE (919) 707-6690
FAX (919) 250-4151

MICHAEL BRIGHT UTILITIES REGIONAL ENGINEER
CHAD DREWERY UTILITIES ENGINEER
AMY DUPREE UTILITIES AREA COORDINATOR
WARREN ANDERSON UTILITIES COORDINATOR