

I:\Projects\2017\18-49 Signals\Signal Design Section\Central Region\Div 9\U-6003\U-6003.sig.tsh.dgn
 15/11/2017 10:49 AM
 P. Pemberton

Project: U-6003

Contract: C204880

STATE OF NORTH CAROLINA
DIVISION OF HIGHWAYS



Project No.	Sheet No.
U-6003	Sig. 1.0

FORSYTH COUNTY

**LOCATION: MACY GROVE ROAD FROM SR 1969 (PINEY GROVE ROAD)
TO SR 4315 (N. MAIN STREET) AND SR 4315/NC 150 (N. MAIN STREET)
FROM NC 150 (MACY GROVE ROAD) TO SR 2037 (COUNTY LINE ROAD)**

TYPE OF WORK: TRAFFIC SIGNALS AND SIGNAL COMMUNICATIONS

Vicinity

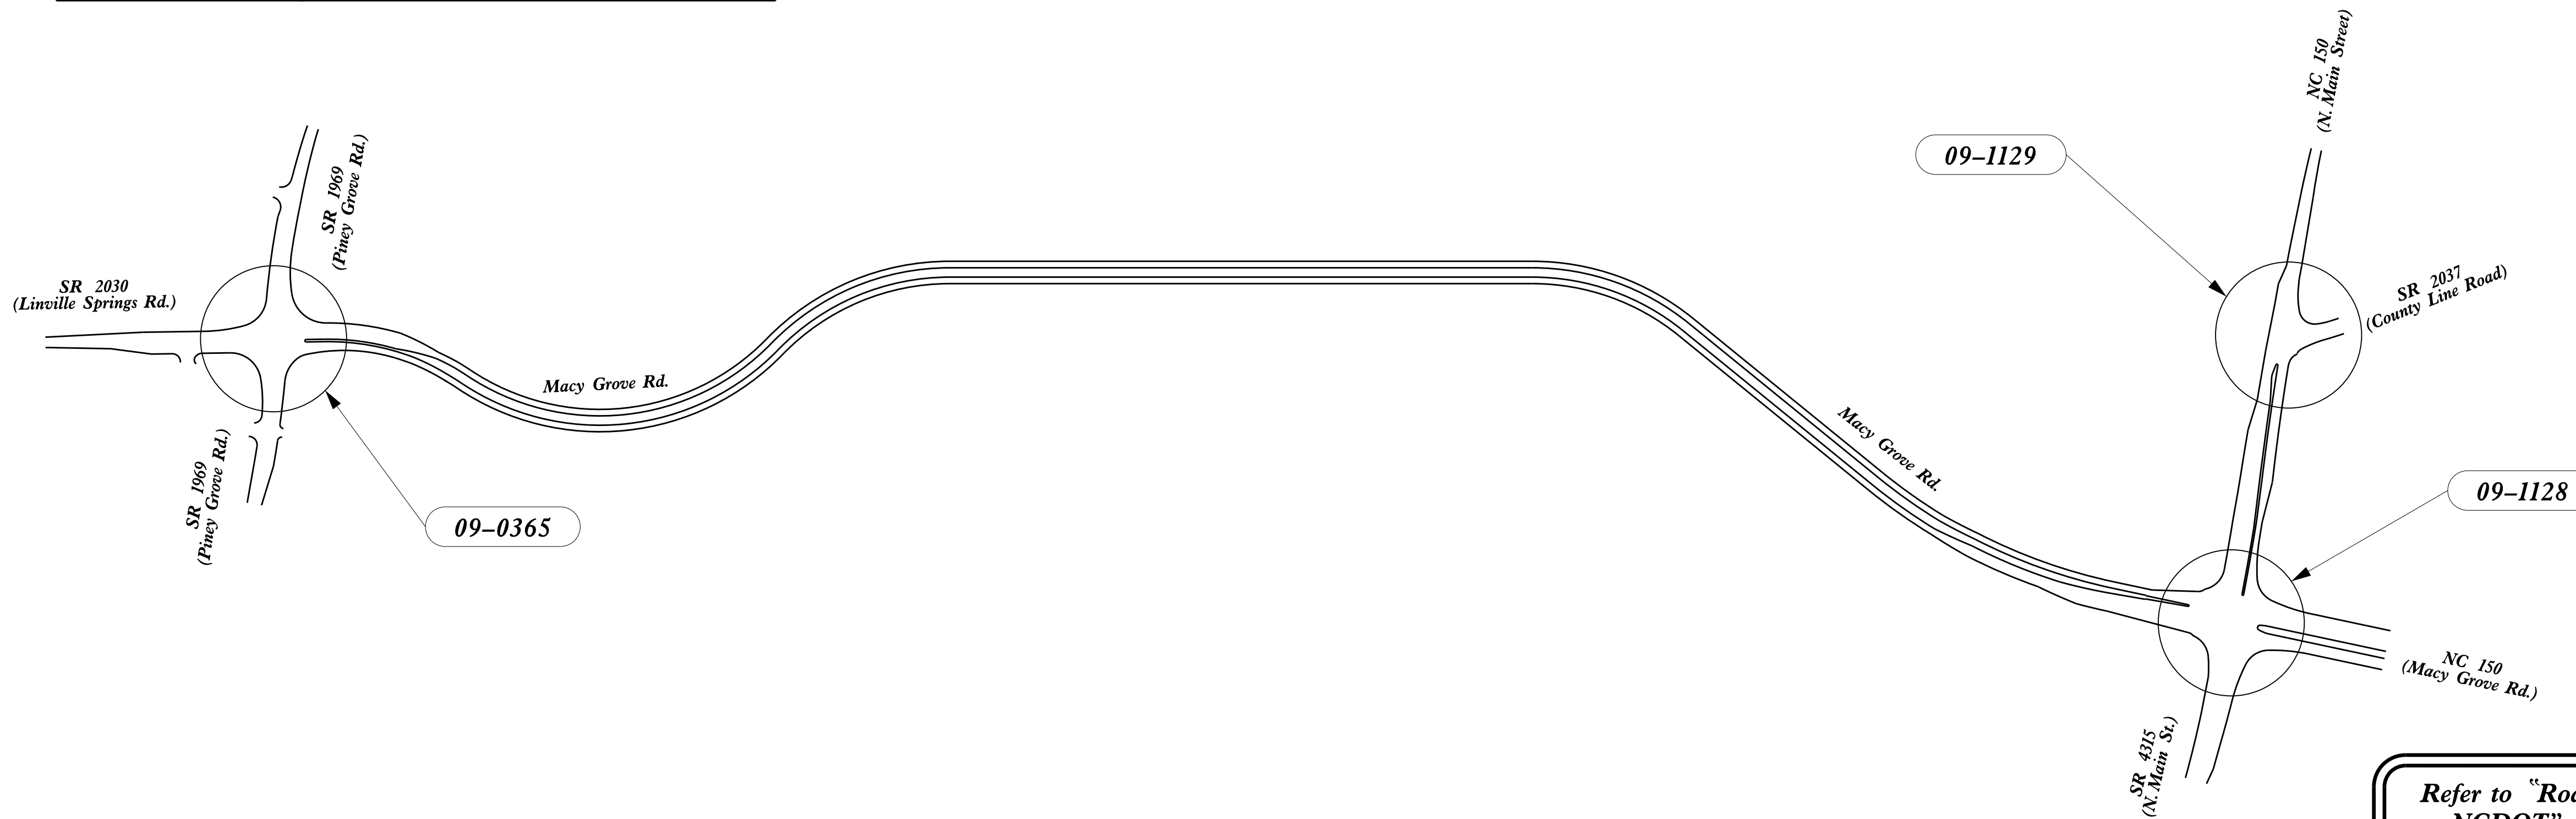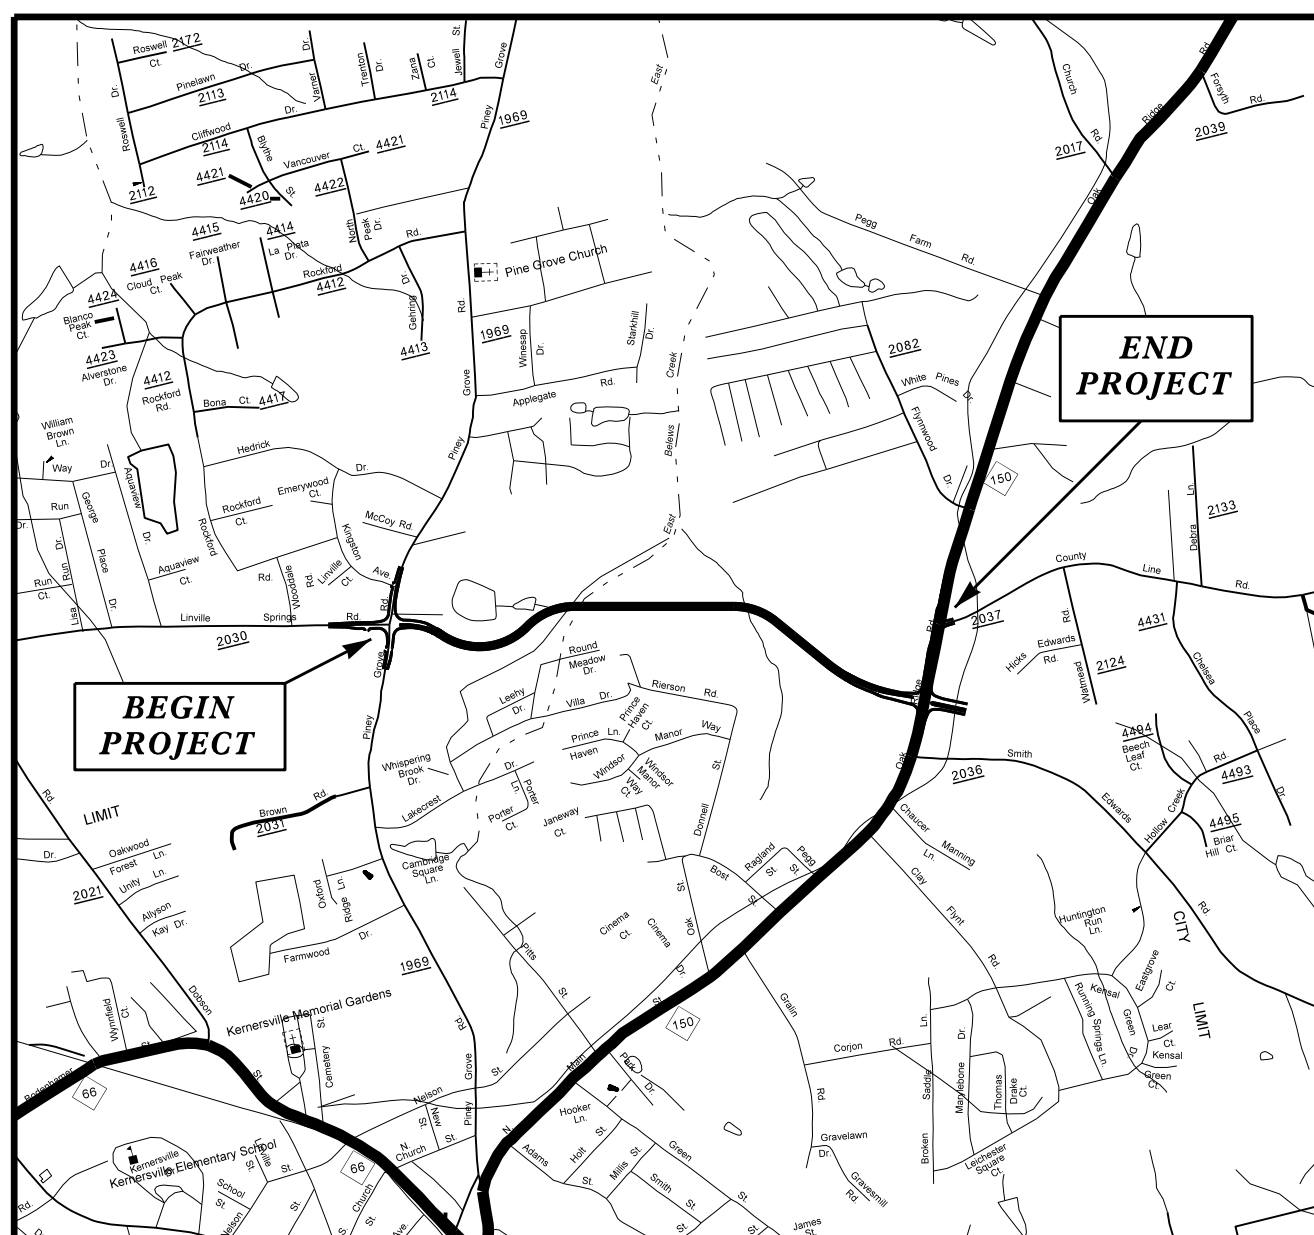

Refer to "Roadway Standard Drawings
NCDOT" dated January 2018 and
"Standard Specifications for Roads
and Structures" dated January 2018.

Sheet #	Reference #	Index of Plans	Location/Description
Sig. 1.0	-----	Title Sheet	
Sig. 1.1	-----	Standard Plate Sheet	
Sig. 2.0-2.3	09-0365	SR 1969 (Piney Grove Road) at SR 2030 (Linville Springs Road) and Macy Grove Road	
Sig. 3.0-3.3	09-1128	NC 150/SR 4315 (N. Main Street) at NC 150 (Macy Grove Road)	
Sig. 4.0-4.2	09-1129	NC 150 (N. Main Street) at SR 2037 (County Line Road)	
MI-M8	-----	Standard Metal Pole Sheets	
SCP 1-6	-----	Signal Communication Plans	

**TRANSPORTATION SYSTEMS
MANAGEMENT & OPERATIONS UNIT**

Contacts:

Robert J. Ziemba, PE - Central Region Signals Engineer
Ryan W. Hough, PE - Signal Equipment Project Engineer
Gregg Green - Signal Communications Project Engineer

Prepared in the Office of:
DIVISION OF HIGHWAYS
TRANSPORTATION MOBILITY & SAFETY DIVISION

