


TIP PROJECT: U-5312

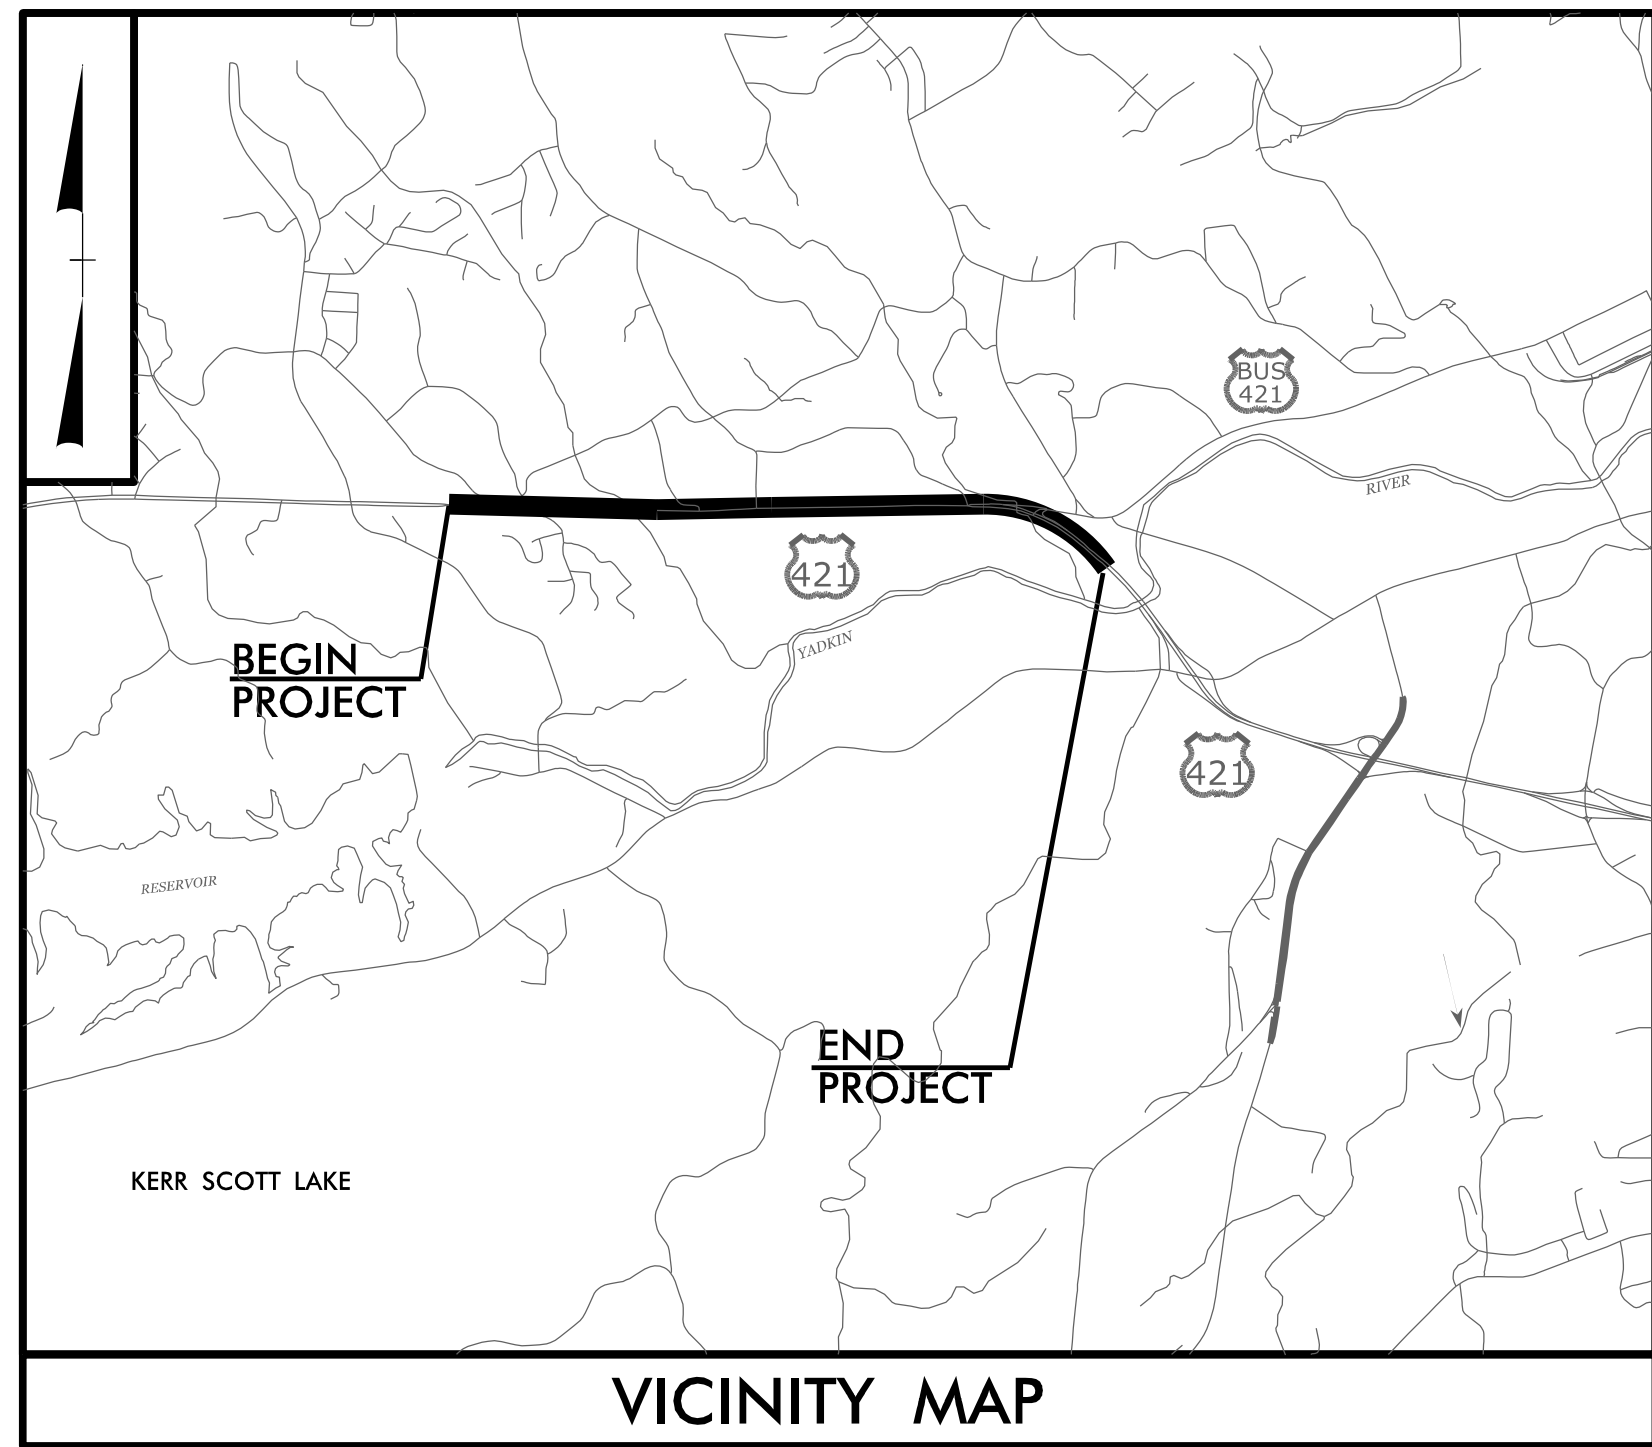

STATE OF NORTH CAROLINA
DIVISION OF HIGHWAYS



WILKES COUNTY

LOCATION: US 421 FROM NC 16 TO US 421 BUSINESS IN WILKESBORO
TYPE OF WORK: WATER AND SANITARY SEWER RELOCATION

STATE	STATE PROJECT REFERENCE NO.	SHEET NO.
N.C.	U-5312	UC-1
STATE PROJ. NO.	P.A. PROJ. NO.	DESCRIPTION
45446.1.1	NHS-0421(072)	PE
45446.2.1	NHS-0421(072)	RW
45446.2.U1	NHS-0421(072)	UTILITY

LICENSE # C-0281


AGREEMENT PLANS

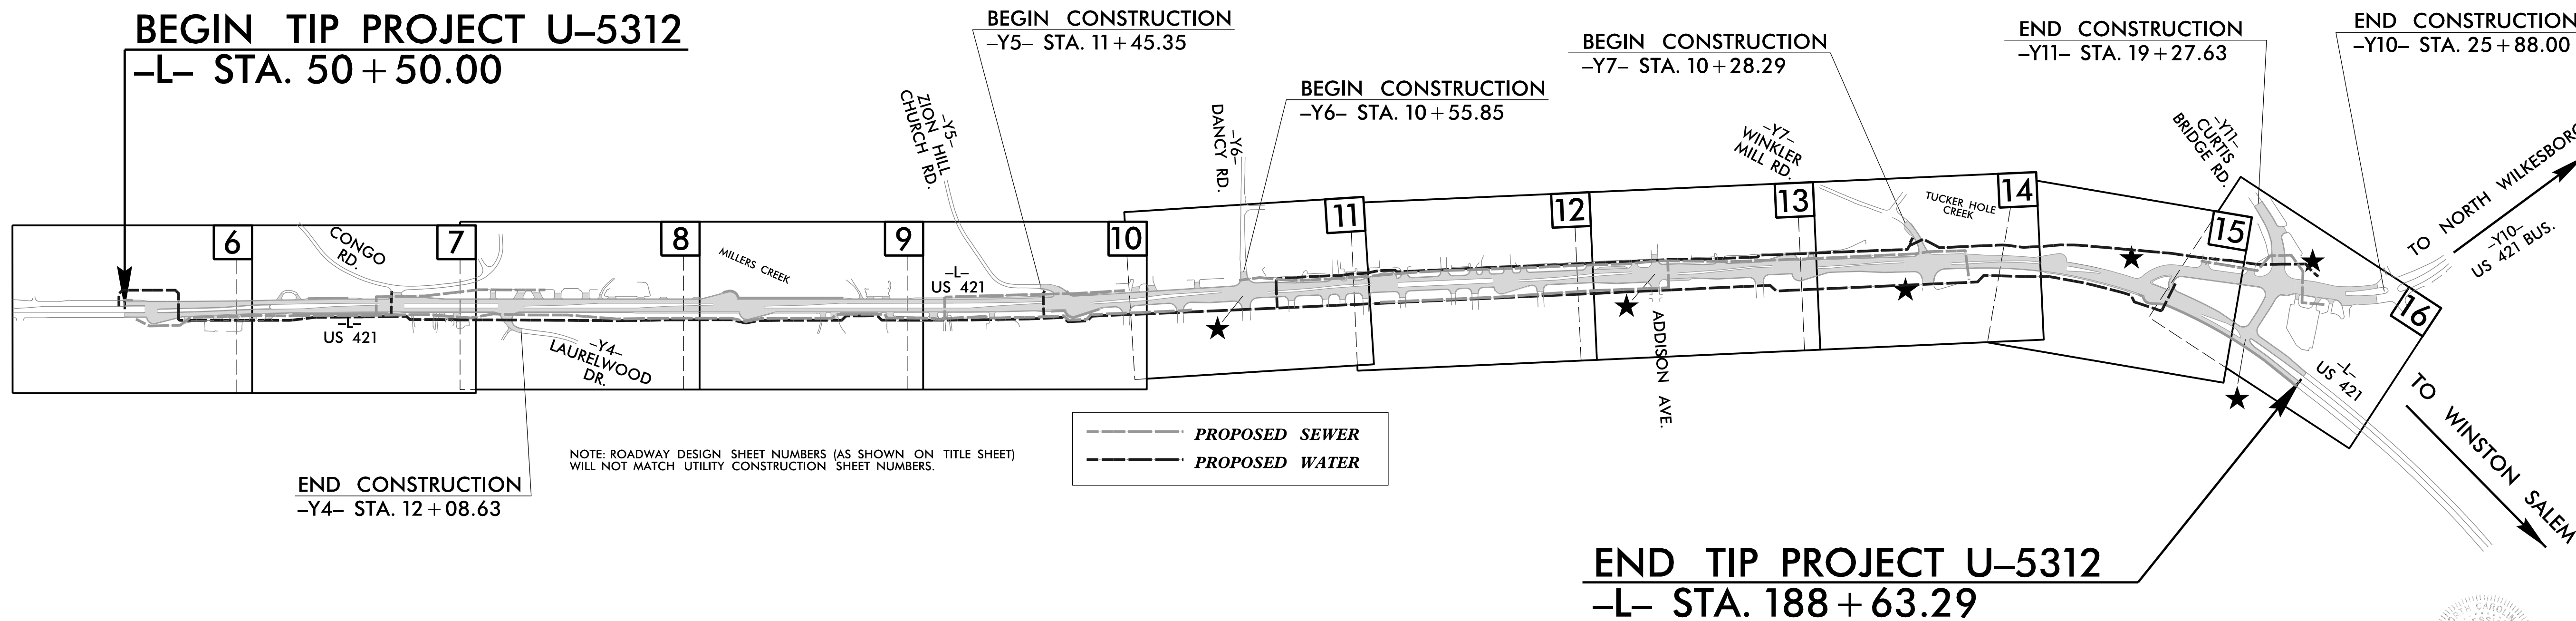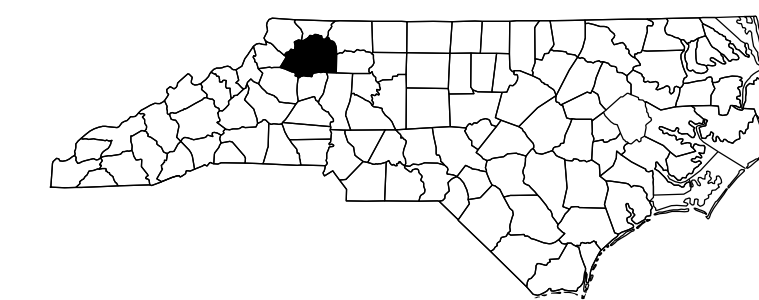

NOTE: ROADWAY DESIGN SHEET NUMBERS (AS SHOWN ON TITLE SHEET) WILL NOT MATCH UTILITY CONSTRUCTION SHEET NUMBERS.

CONTRACT:

GRAPHIC SCALES

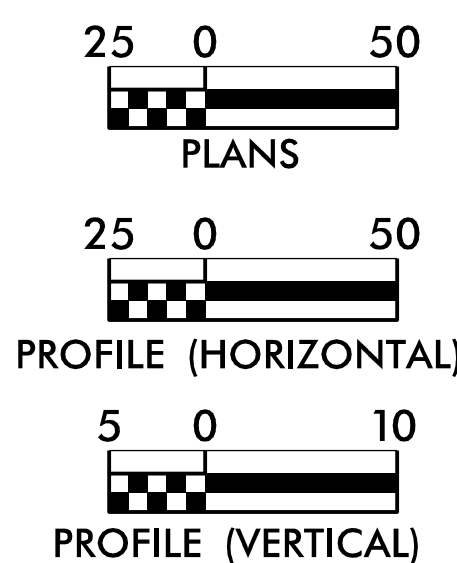

INDEX OF SHEETS


SHEET No.	DESCRIPTION
UC-1	TITLE SHEET
UC-2	PLAN SHEET SYMBOLS
UC-3A-UC-3D	NOTES AND DETAILS
UC-4 - UC-18	SEWER PLAN AND PROFILE SHEETS
UC-19 - UC-33	WATER PLAN AND PROFILE SHEETS

UTILITY OWNERS ON PROJECT

UTILITY	OWNER
WATER /SEWER	TOWN OF WILKESBORO

Municipal Services Engineering Company, P.A.
P.O. BOX 97 GARNER, N.C. 27529 | P.O. BOX 349 BOONE, N.C. 28607
(919) 772-5393 | (828) 262-1767
LICENSE NUMBER: C-0281

UTILITY DESIGN ENGINEER BENJAMIN D. CLAWSON, PE

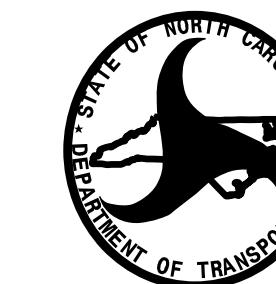

DIVISION OF HIGHWAYS UTILITIES UNIT

1555 MAIL SERVICES CENTER
RALEIGH NC 27699-1555
PHONE (919) 707-6690
FAX (919) 250-4119

BRANDON GREER NCDOT CONTACT
DANIEL ADAMS PROJECT ENGINEER
DESIREE HAGWOOD PROJECT DESIGN ENGINEER

