
 


STATE OF NORTH CAROLINA
DEPARTMENT OF TRANSPORTATION

| | |
|---|----------------------------|
| PROJECT REFERENCE NO. HI-0017 | SHEET NO. SIGN-1 |
| DocuSigned by: <i>Richard D. Lasher</i> -FA81F1EB929945F... 10/11/2023 | |
|  | |
|  | |

SIGNING PLAN
ROBESON COUNTY

**LOCATION: US 74 FROM THE SCOTLAND COUNTY LINE
TO I-74 /US 74 BUSINESS**

ROADWAY STANDARD DRAWING

THE FOLLOWING ROADWAY STANDARDS AS APPEAR IN "ROADWAY STANDARD DRAWINGS" - PROJECT SERVICES UNIT - N.C. DEPARTMENT OF TRANSPORTATION - RALEIGH, N.C., DATED JANUARY 2018 ARE APPLICABLE TO THIS PROJECT AND BY REFERENCE HEREBY ARE CONSIDERED A PART OF THESE PLANS:

| STD. NO. | TITLE |
|----------|---|
| 901.10 | TYPE 'A' SIGNS |
| 901.20 | TYPE 'B' SIGNS |
| 901.50 | ARROWS AND SHIELDS |
| 901.70 | SIGN STRINGERS AND SUPPORT SPACING |
| 901.80 | SIGN MOUNTING DETAILS - FOR TYPE A AND TYPE B SIGNS |
| 904.10 | ORIENTATION OF GROUND MOUNTED SIGNS |
| 904.20 | SECONDARY SIGN MOUNTING |
| 904.50 | MOUNTING OF TYPE 'D', 'E', AND 'F' SIGNS ON 'U' CHANNEL POSTS |

GENERAL NOTES

- SIGNS FURNISHED BY STATE
- CONFIRM IN WRITING AT LEAST 4 MONTHS IN ADVANCE, THE ACTUAL DATE THE DEPARTMENT FURNISHED SIGNS WILL BE REQUIRED.
- ALL TYPE 'D' SIGNS SHALL BE MOUNTED ON TWO U-CHANNEL POSTS UNLESS OTHERWISE INDICATED ON THE PLANS.
- WHEN NOT STATIONED OR DIMENSIONED ON PLANS, ALL 'E' AND 'F' SIGNS SHALL BE FIELD LOCATED BY THE ENGINEER
- WHEN EXISTING SIGNS ARE REMOVED AND INSTALLED ON NEW SUPPORTS, THE RE-ERECTION SHALL IMMEDIATELY FOLLOW THE REMOVAL.
- THE BACKGROUND FOR TYPE E & F SIGNS SHALL BE TYPE C REFLECTIVE SHEETING.
- SIGNING PLANS DO NOT INCLUDE TEMPORARY CONSTRUCTION SIGNING, SEE TRAFFIC CONTROL PLANS, SEE PAVEMENT MARKING PLAN FOR PAVEMENT MARKING DESIGN.
- ALL SIGNS SHOWN ARE EXISTING AND SHALL REMAIN UNLESS OTHERWISE SPECIFIED BY PLAN NOTES.

SUMMARY OF QUANTITIES

| ITEM NO. | | ITEM DESCRIPTION | QUANTITY | UNIT |
|------------|-----------|---------------------------------------|----------|------|
| DESC. NO. | SECT. NO. | | | |
| 4048000000 | 902 | REINFORCED CONCRETE SIGN FOUNDATIONS | 8.0 | CY |
| 4054000000 | 902 | PLAIN CONCRETE SIGN FOUNDATIONS | 1.0 | CY |
| 4060000000 | 903 | SUPPORTS, BREAKAWAY STEEL BEAM | 8440 | LBS |
| 4072000000 | 903 | SUPPORTS, 3 LB STEEL U CHANNEL | 170 | LF |
| 4102000000 | 904 | SIGN ERECTION TYPE E | 6 | EA |
| 4108000000 | 904 | SIGN ERECTION TYPE F | 1 | EA |
| 4110000000 | 904 | SIGN ERECTION TYPE A (GROUND MOUNTED) | 10 | EA |
| 4110000000 | 904 | SIGN ERECTION TYPE B (GROUND MOUNTED) | 8 | EA |
| 4152000000 | 907 | DISPOSAL OF SIGN SYSTEM, STEEL BEAM | 11 | EA |
| 4155000000 | 907 | DISPOSAL OF SIGN SYSTEM, U-CHANNEL | 1 | EA |

PAY ITEM NOTES

- 1 DISPOSAL OF SIGN AND SIGN ERECTION, SIGN TYPE D, E, AND F
- 2 SIGN ERECTION, TYPE A, GROUND MOUNT
- 3 SIGN ERECTION, TYPE B, GROUND MOUNT
- 4 SIGN ERECTION, TYPE E
- 5 DISPOSAL OF SIGN A OR B (GROUND MOUNT)

INDEX

| SHEET NO. | DESCRIPTION |
|------------|--------------------|
| SIGN-1 | TITLE SHEET |
| SIGN-2 | TYPE E AND F SIGNS |
| SIGN-3 | SIGN SUPPORT SHEET |
| SIGN-3A-3E | TYPE A AND B SIGNS |
| SIGN-4-8 | SIGNING PLAN SHEET |

PLAN SUBMITTED TO: NCDOT SIGNING AND DELINEATION UNIT

MITCH EATON, PE SIGNING & DELINEATION REGIONAL ENGINEER
STACEY JOHNS SIGNING & DELINEATION PROJECT DESIGN ENGINEER



8/17/08

401

QUANTITY REQ'D 2




36" X 36"
W8-5

ONE "U" POST PER SIGN

501

QUANTITY REQ'D 1

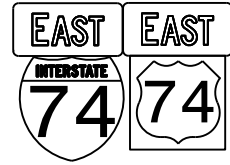

24" X 12"
M3-2
24" X 12"
M3-2
24" X 24"
M1-1
24" X 24"
M1-4

TWO "U" POST PER SIGN

402

QUANTITY REQ'D 1




36" X 48"
R2-1

TWO "U" POST PER SIGN

403

QUANTITY REQ'D 1

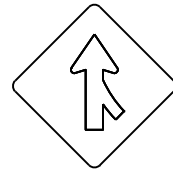


48" X 48"
W4-1

TWO "U" POST PER SIGN

404

 QUANTITY REQ'D 1




36" X 48"
W13-2

TWO "U" POST PER SIGN

405

 QUANTITY REQ'D 1



24" X 30"
R4-7


 
ONE "U" POST PER SIGN

| | |
|--|----------------------------|
| PROJECT REFERENCE NO. <i>HI-0017</i> | SHEET NO. <i>SIGN-2</i> |
| DocuSigned by: <i>Richard D. Lasher</i> FAR1F1EB929945F... 10/11/2023 | |
| | |
| | |

TYPE "E" & "F" SIGNS

10/16/2023
Richard D. Lasher


 
8/17/23

| | |
|---|----------------------------|
| PROJECT REFERENCE NO. HI-0017 | SHEET NO. SIGN-3 |
| DocuSigned by: <i>Richard D. Lashner</i> FA81F1EB929945F... 10/11/2023 | |
|  | |
|  | |


| SIGN | | | | | ROADWAY STATION | NUMBER OF SUPPORTS | BEAM SECTION | SUPPORT TYPE BA or S | OMNI COUPLER | ATTACHMENT METHOD | MOUNTING METHOD | HORIZONTAL CLEARANCE* (ft.) | SUPPORT SPACING | LENGTH (ft) | | | LEFT SUPPORT (ft) | | | CENTER SUPPORT (ft) | | | RIGHT SUPPORT (ft) | | | SUPPORT WEIGHTS | | FOOTINGS | | | | FIELD VERIFIED SEE NOTE 2 (mm/dd/yy) |
|--------------|--------|------------|--------|-----------|-----------------|--------------------|--------------|----------------------|--------------|-------------------|-----------------|-----------------------------|-----------------|-------------|------------|------------|-------------------|-------|--------|---------------------|-------|--------|--------------------|-------|--------|-----------------|---------------|----------------|-------------|-------------------|--------------|--------------------------------------|
| NUMBER | TYPE | SIZE (in.) | | | | | | | | | | | | SNS HT "H" | MTG HT "C" | EMBED-MENT | S | L | LENGTH | S | L | LENGTH | S | L | LENGTH | B/A (lbs.) | SIMPLE (lbs.) | DIAMETER (ft.) | DEPTH (ft.) | REINFORCED (c.y.) | PLAIN (c.y.) | |
| | | w | x | h | | | | | | | | | | | | | | | | | | | | | | | | | | | | |
| 101A 101B | B A | 132 192 | x x | 30 150 | 12+00 | 2 | W8x18 | BA | N/A | 1-R N/A | N/A N/A | 30.00 | 9.38 | 12.50 | 7.00 | 4.5 | 0.00 | 19.50 | 24.00 | 0.00 | 0.00 | 0.00 | 0.00 | 19.50 | 24.00 | 1004.00 | 0 | 2.0 | 5 | 1.16 | 0.00 | _____ |
| 102A 102B | B A | 132 192 | x x | 30 156 | 33+00 | 2 | W8x18 | BA | N/A | 1-R N/A | N/A N/A | 30.00 | 9.38 | 13.00 | 7.00 | 4.5 | 0.00 | 20.00 | 24.50 | 0.00 | 0.00 | 0.00 | 0.00 | 20.00 | 24.50 | 1022.00 | 0 | 2.0 | 5 | 1.16 | 0.00 | _____ |
| 103A 103B | B A | 132 192 | x x | 30 156 | 59+40 | 2 | W8x18 | BA | N/A | 1-R N/A | N/A N/A | 30.00 | 9.38 | 13.00 | 7.00 | 4.5 | 0.00 | 20.00 | 24.50 | 0.00 | 0.00 | 0.00 | 0.00 | 20.00 | 24.50 | 1022.00 | 0 | 2.0 | 5 | 1.16 | 0.00 | _____ |
| 104 | A | 84 | x | 60 | 68+57 | 2 | S3x5.7 | BA | N/A | N/A | N/A | 30.00 | 4.10 | 5.00 | 7.00 | 2.5 | 0.00 | 12.00 | 14.50 | 0.00 | 0.00 | 0.00 | 0.00 | 12.00 | 14.50 | 201.30 | 0 | 1.0 | 3 | 0.00 | 0.17 | _____ |
| 105 | B | 96 | x | 36 | 87+20 | 2 | S3x5.7 | BA | N/A | N/A | N/A | 30.00 | 4.69 | 3.00 | 7.00 | 2.0 | 0.00 | 10.00 | 12.00 | 0.00 | 0.00 | 0.00 | 0.00 | 10.00 | 12.00 | 172.80 | 0 | 1.0 | 2.5 | 0.00 | 0.15 | _____ |
| 106A 106B | B A | 132 192 | x x | 30 144 | 102+00 | 2 | W6x16 | BA | N/A | 1-R N/A | N/A N/A | 30.00 | 9.38 | 12.00 | 7.00 | 5.0 | 0.00 | 19.00 | 24.00 | 0.00 | 0.00 | 0.00 | 0.00 | 19.00 | 24.00 | 862.00 | 0 | 1.5 | 5.5 | 0.72 | 0.00 | _____ |
| 107A 107B | A A | 186 240 | x x | 30 138 | 137+65 | 3 | W6x16 | BA | N/A | 1-R N/A | N/A N/A | 30.00 | 7.10 | 11.50 | 7.00 | 4.5 | 0.00 | 18.50 | 23.00 | 0.00 | 18.50 | 23.00 | 0.00 | 18.50 | 23.00 | 1245.00 | 0 | 1.5 | 5 | 0.98 | 0.00 | _____ |
| 108 | B | 102 | x | 48 | 154+34 | 2 | S3x5.7 | BA | N/A | N/A | N/A | 30.00 | 4.98 | 4.00 | 7.00 | 2.5 | 0.00 | 11.00 | 13.50 | 0.00 | 0.00 | 0.00 | 0.00 | 11.00 | 13.50 | 189.90 | 0 | 1.0 | 3 | 0.00 | 0.17 | _____ |
| 109 | A | 126 | x | 60 | 196+80 | 2 | S3x5.7 | BA | N/A | N/A | N/A | 30.00 | 6.15 | 5.00 | 7.00 | 3.0 | 0.00 | 12.00 | 15.00 | 0.00 | 0.00 | 0.00 | 0.00 | 12.00 | 15.00 | 207.00 | 0 | 1.0 | 3.5 | 0.00 | 0.20 | _____ |
| 110A 110B | B A | 132 240 | x x | 30 144 | 244+42 | 3 | W6x16 | BA | N/A | 1-R N/A | N/A N/A | 30.00 | 7.10 | 12.00 | 7.00 | 4.5 | 0.00 | 19.00 | 23.50 | 0.00 | 19.00 | 23.50 | 0.00 | 19.00 | 23.50 | 1269.00 | 0 | 1.5 | 5 | 0.98 | 0.00 | _____ |
| 111A 111B | B A | 132 240 | x x | 30 138 | 297+30 | 3 | W6x16 | BA | N/A | 1-R N/A | N/A N/A | 30.00 | 7.10 | 11.50 | 7.00 | 4.5 | 0.00 | 18.50 | 23.00 | 0.00 | 18.50 | 23.00 | 0.00 | 18.50 | 23.00 | 1245.00 | 0 | 1.5 | 5 | 0.98 | 0.00 | _____ |

10/16/2023

Richard D. Lashner

| | |
|---|-----------------------------|
| PROJECT REFERENCE NO. HI-0017 | SHEET NO. SIGN-3C |
| DocuSigned by: <i>Richard L. Ashin</i> FA81F1EB929945F... 10/11/2023 | |
|  | |
|  | |

| | | |
|--|---|---|
| SIGN NUMBER: 108 TYPE: B QUANTITY: 1 SIGN WIDTH: 8'-6" HEIGHT: 4'-0" TOTAL AREA: 34.0 Sq.Ft. BORDER TYPE: FLUSH RECESS: 0" WIDTH: 1" RADII: 6" NO. Z BARS: 2 LENGTH: 94.0 | BACKG COLOR: Green COPY COLOR: White SYMBOl X Y WID HT MAT'L: 0.125" (3.2 mm) ALUMINUM | DESIGN BY: none PROJECT ID: ID CHECKED BY: LOCATION: Feb 08, 2023 DIV: DIV |
|--|---|---|

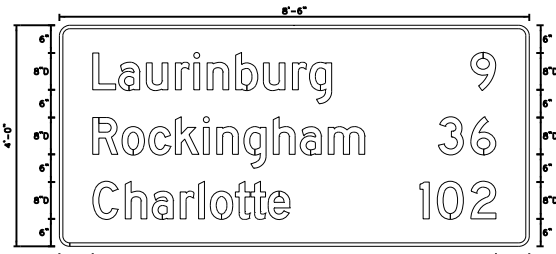

Panel Style: DI-1.ssi
M.U.T.C.D.: 2009 Edition


USE NOTES:

- Legend and border(except those that are colored black) shall be direct applied Grade C sheeting.
- Background shall be Grade C reflective sheeting.
- Shields; A, B, and C type arrows shall be on 0.032" (0.8mm) aluminum with Grade C reflective sheeting and demountable.
- Bottom panel shall be yellow Grade C sheeting. Legend shall be direct applied black non-reflective sheeting. Arrow shall be on 0.032" aluminum, black non-reflective sheeting an demountable. Yellow panel is:

| Letter locations are panel edge to lower left corner | | | | | | | | | | | Series/Size |
|--|------|------|------|------|------|------|------|------|------|--|----------------|
| L | a | u | r | i | n | b | u | r | g | | Text Length |
| 7.2 | 12.8 | 18.8 | 25.2 | 29.2 | 32 | 38.3 | 44.3 | 50.6 | 54.3 | | D 2000 51.8 |
| 9 | | | | | | | | | | | D 2000 5.4 |
| 89.3 | | | | | | | | | | | |
| R | o | c | k | i | n | g | h | a | m | | Text Length |
| 7.2 | 13.6 | 19.4 | 25.2 | 31.2 | 34.1 | 40 | 46.4 | 52.3 | 58.4 | | D 2000 59 |
| 3 | 6 | | | | | | | | | | D 2000 12.5 |
| 82.3 | 89.3 | | | | | | | | | | |
| C | h | a | r | l | o | t | t | e | | | Text Length |
| 7.2 | 14.3 | 20.1 | 26.2 | 30.2 | 32.8 | 38.2 | 41.6 | 45.3 | | | D 2000 42.8 |
| 1 | 0 | 2 | | | | | | | | | D 2000 16.5 |
| 78.3 | 82 | 89.3 | | | | | | | | | |

FILENAME: Proposed signs NORTH CAROLINA D.O.T. SIGN DETAIL

| | | |
|--|---|---|
| SIGN NUMBER: 1108 TYPE: A QUANTITY: 1 SIGN WIDTH: 20'-0" HEIGHT: 12'-0" TOTAL AREA: 267.5 Sq.Ft. BORDER TYPE: FLUSH RECESS: 0" WIDTH: 2" RADII: 12" NO. Z BARS: 3 LENGTH: 232.0 | BACKG COLOR: Green COPY COLOR: White SYMBOl X Y WID HT MI_4 44.1 75 36 36 MI_4 151.1 75 36 36 AR_Type A 107.6 10.2 22.25 35 MAT'L: 0.125" (3.2 mm) ALUMINUM | DESIGN BY: none PROJECT ID: ID CHECKED BY: LOCATION: Feb 08, 2023 DIV: DIV |
|--|---|---|

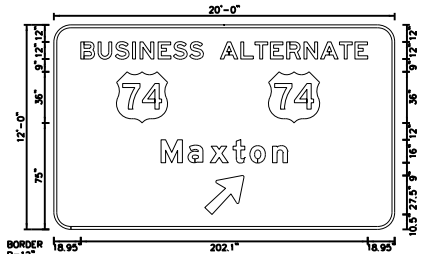

Panel Style: guide_fwy_advance_a.ssi
M.U.T.C.D.: 2009 Edition


USE NOTES:

- Legend and border(except those that are colored black) shall be direct applied Grade C sheeting.
- Background shall be Grade C reflective sheeting.
- Shields; A, B, and C type arrows shall be on 0.032" (0.8mm) aluminum with Grade C reflective sheeting and demountable.
- Bottom panel shall be yellow Grade C sheeting. Legend shall be direct applied black non-reflective sheeting. Arrow shall be on 0.032" aluminum, black non-reflective sheeting an demountable. Yellow panel is:

| Letter locations are panel edge to lower left corner | | | | | | | | | | | Series/Size |
|--|-------|-------|-------|-------|-------|-------|------|-----|--|--|-----------------|
| B | U | S | I | N | E | S | S | | | | Text Length |
| 19 | 31.1 | 43.2 | 55.3 | 60.6 | 73.4 | 84.1 | 95.5 | | | | 86.3 |
| A | L | T | E | R | N | A | T | E | | | Text Length |
| 117.2 | 131.5 | 141.5 | 152.5 | 163.9 | 176 | 187.8 | 201 | 212 | | | E 2000 103.8 |
| M | o | x | t | o | n | | | | | | Text Length |
| 75.5 | 94.4 | 109.9 | 126.1 | 138.1 | 153.9 | | | | | | EM 2000 89 |

FILENAME: Proposed signs NORTH CAROLINA D.O.T. SIGN DETAIL

| | | |
|--|---|---|
| SIGN NUMBER: 109 TYPE: A QUANTITY: 1 SIGN WIDTH: 10'-6" HEIGHT: 5'-0" TOTAL AREA: 52.5 Sq.Ft. BORDER TYPE: FLUSH RECESS: 0" WIDTH: 1.5" RADII: 8" NO. Z BARS: 2 LENGTH: 106.0 | BACKG COLOR: Green COPY COLOR: White SYMBOl X Y WID HT AR_Type A 85 6 18.5 29.2 MAT'L: 0.125" (3.2 mm) ALUMINUM | DESIGN BY: none PROJECT ID: ID CHECKED BY: LOCATION: Feb 08, 2023 DIV: DIV |
|--|---|---|

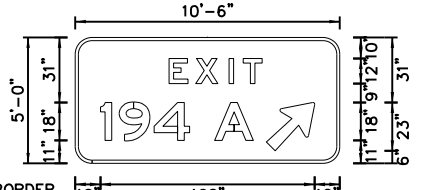

Panel Style: guide_fwy_gore.ssi
M.U.T.C.D.: 2009 Edition


 
USE NOTES:

- Legend and border(except those that are colored black) shall be direct applied Grade C sheeting.
- Background shall be Grade C reflective sheeting.
- Shields; A, B, and C type arrows shall be on 0.032" (0.8mm) aluminum with Grade C reflective sheeting and demountable.
- Bottom panel shall be yellow Grade C sheeting. Legend shall be direct applied black non-reflective sheeting. Arrow shall be on 0.032" aluminum, black non-reflective sheeting an demountable. Yellow panel is:


| Letter locations are panel edge to lower left corner | | | | | Series/Size |
|--|------|------|------|--|------------------|
| E | X | I | T | | Text Length |
| 38.6 | 49.3 | 62.2 | 66.4 | | E 2000 44.376 |
| 1 | 9 | 4 | | | E 2000 42.5 |
| 6 | 15 | 31.5 | | | E 2000 18.4 |
| A | | | | | Text Length |
| 60.4 | | | | | |

FILENAME: Proposed signs NORTH CAROLINA D.O.T. SIGN DETAIL

8/17/23

| | |
|---|-----------------------------|
| PROJECT REFERENCE NO. HI-0017 | SHEET NO. SIGN-3D |
| DocuSigned by: <i>Richard D. Laster</i> FAB1F1EB929945F 10/11/2023 | |
|  | |
|  | |

| SIGN NUMBER: 111B TYPE: A QUANTITY: 1 SIGN WIDTH: 20'-0" HEIGHT: 11'-6" TOTAL AREA: 257.5 Sq.Ft. BORDER TYPE: FLUSH RECESS: 0" WIDTH: 2" RADII: 12" NO. Z BARS: 3 LENGTH: 232.0 | BACKG COLOR: Green COPY COLOR: White <table border="1"> <thead> <tr> <th>SYMBOL</th> <th>X</th> <th>Y</th> <th>WID</th> <th>HT</th> </tr> </thead> <tbody> <tr> <td>M1_4</td> <td>44.1</td> <td>68</td> <td>36</td> <td>36</td> </tr> <tr> <td>M1_4</td> <td>151.1</td> <td>68</td> <td>36</td> <td>36</td> </tr> </tbody> </table> MAT'L: 0.125" (3.2 mm) ALUMINUM | SYMBOL | X | Y | WID | HT | M1_4 | 44.1 | 68 | 36 | 36 | M1_4 | 151.1 | 68 | 36 | 36 | DESIGN BY: none PROJECT ID: ID CHECKED BY: LOCATION: Feb 08, 2023 DIV: DIV |
|--|---|--------|-----|----|-----|----|------|------|----|----|----|------|-------|----|----|----|---|
| SYMBOL | X | Y | WID | HT | | | | | | | | | | | | | |
| M1_4 | 44.1 | 68 | 36 | 36 | | | | | | | | | | | | | |
| M1_4 | 151.1 | 68 | 36 | 36 | | | | | | | | | | | | | |

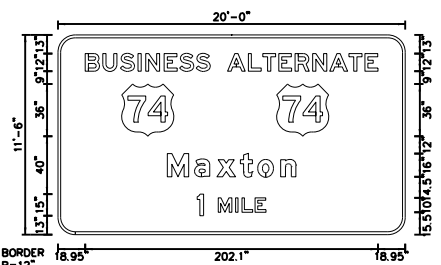

Panel Style: guide_fwy_advance_ossf
M.U.T.C.D.: 2009 Edition

Spacing Factor is 1 unless specified otherwise


USE NOTES:

- Legend and border(except those that are colored black) shall be direct applied Grade C sheeting.
- Background shall be Grade C reflective sheeting.
- Shields: A, B, and C type arrows shall be on 0.032" (0.8mm) aluminum with Grade C reflective sheeting and demountable.
- Bottom panel shall be yellow Grade C sheeting. Legend shall be direct applied black non-reflective sheeting. Arrow shall be on 0.032" aluminum, black non-reflective sheeting an demountable. Yellow panel is:

| Letter locations are panel edge to lower left corner | | | | | | | | | | Series/Size | Text Length | |
|--|-------|-------|-------|-------|-------|-------|------|-----|--|-------------|-------------|-------|
| B | U | S | I | N | E | S | S | | | | E 2000 | 86.3 |
| 19 | 31.1 | 43.2 | 55.3 | 60.6 | 73.4 | 84.1 | 95.5 | | | | | |
| A | L | T | E | R | N | A | T | E | | | E 2000 | 103.8 |
| 117.2 | 131.5 | 141.5 | 152.5 | 163.9 | 176 | 187.8 | 201 | 212 | | | | |
| M | a | x | t | o | n | | | | | | EM 2000 | 89 |
| 75.5 | 94.4 | 109.9 | 126.1 | 138.1 | 153.9 | | | | | | | |
| 1 | M | I | L | E | | | | | | | E 2000 | 47.6 |
| 96.2 | 110.7 | 122.7 | 127.1 | 136.3 | | | | | | | | |

FILENAME: Proposed signs NORTH CAROLINA D.O.T. SIGN DETAIL

| SIGN NUMBER: 101A,102A TYPE: B QUANTITY: 4 SIGN WIDTH: 2'-6" HEIGHT: 11'-0" TOTAL AREA: 27.5 Sq.Ft. BORDER TYPE: FLUSH RECESS: 0" WIDTH: 2" RADII: 12" NO. Z BARS: 0 LENGTH: 184.0 | BACKG COLOR: Green COPY COLOR: White <table border="1"> <thead> <tr> <th>SYMBOL</th> <th>X</th> <th>Y</th> <th>WID</th> <th>HT</th> </tr> </thead> <tbody> </tbody> </table> MAT'L: 0.125" (3.2 mm) ALUMINUM | SYMBOL | X | Y | WID | HT | DESIGN BY: none PROJECT ID: ID CHECKED BY: LOCATION: Feb 08, 2023 DIV: DIV |
|---|--|--------|-----|----|-----|----|---|
| SYMBOL | X | Y | WID | HT | | | |

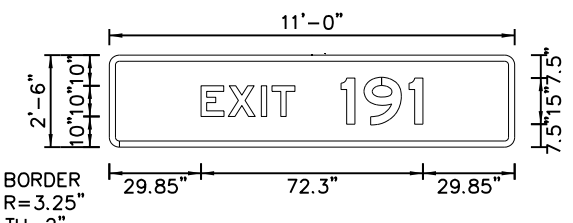

Panel Style: tab1.bsi
M.U.T.C.D.: 2009 Edition

Spacing Factor is 1 unless specified otherwise

USE NOTES:

- Legend and border(except those that are colored black) shall be direct applied Grade C sheeting.
- Background shall be Grade C reflective sheeting.
- Shields: A, B, and C type arrows shall be on 0.032" (0.8mm) aluminum with Grade C reflective sheeting and demountable.
- Bottom panel shall be yellow Grade C sheeting. Legend shall be direct applied black non-reflective sheeting. Arrow shall be on 0.032" aluminum, black non-reflective sheeting an demountable. Yellow panel is:


 
| Letter locations are panel edge to lower left corner | | | | | | | | Series/Size | Text Length |
|--|------|------|----|------|----|------|--|-------------|-------------|
| E | X | I | T | 1 | 9 | 1 | | E 2000 | 72.3 |
| 29.8 | 38.5 | 49.5 | 53 | 73.5 | 83 | 97.7 | | | |

FILENAME: Proposed signs NORTH CAROLINA D.O.T. SIGN DETAIL

TYPE A AND B SIGNS


10/6/2023

8/17/23

| | |
|---|----------------------------|
| PROJECT REFERENCE NO. HI-0017 | SHEET NO. SIGN-4 |
| DocuSigned by: <i>Richard D. Lasher</i> FAB1F1EB829945F... 10/11/2023 | |
|  | |
|  | |

BEGIN CONSTRUCTION HI-0017
-I74WBL- STA. 12+00.00
-I74EBL- STA. 12+00.00

BEGIN PROJECT HI-0017
BEGIN MILLING AND RESURFACING
MATCH EXIST.
-I74WBL- STA. 27+00.00
-I74EBL- STA. 27+00.00

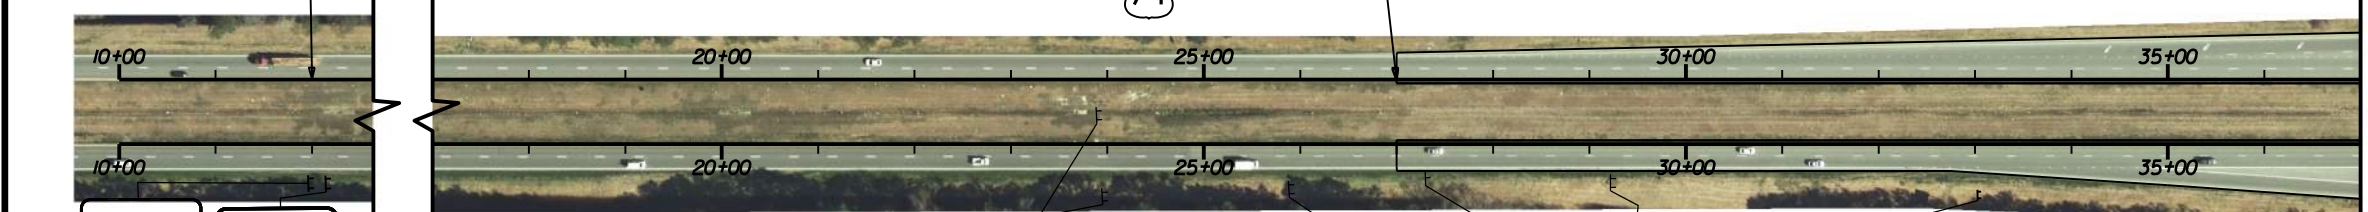


SEE NOTE 5
101B **101A**
SEE NOTES 2 AND 3

SEE NOTES 2, 3, AND 5


- PROJECT NOTES**
- DISPOSAL OF SIGN, AND SIGN ERECTION, SIGN TYPE D, E, AND F
 - SIGN ERECTION, TYPE A, GROUND MOUNT
 - SIGN ERECTION, TYPE B, GROUND MOUNT
 - SIGN ERECTION, TYPE E
 - DISPOSAL OF SIGN A OR B (GROUND MOUNT)

MATCHLINE THIS SHEET
-I74WBL- STA 37+00.00

MATCHLINE SHEET SIGN-5
-I74WBL- STA 62+00.00

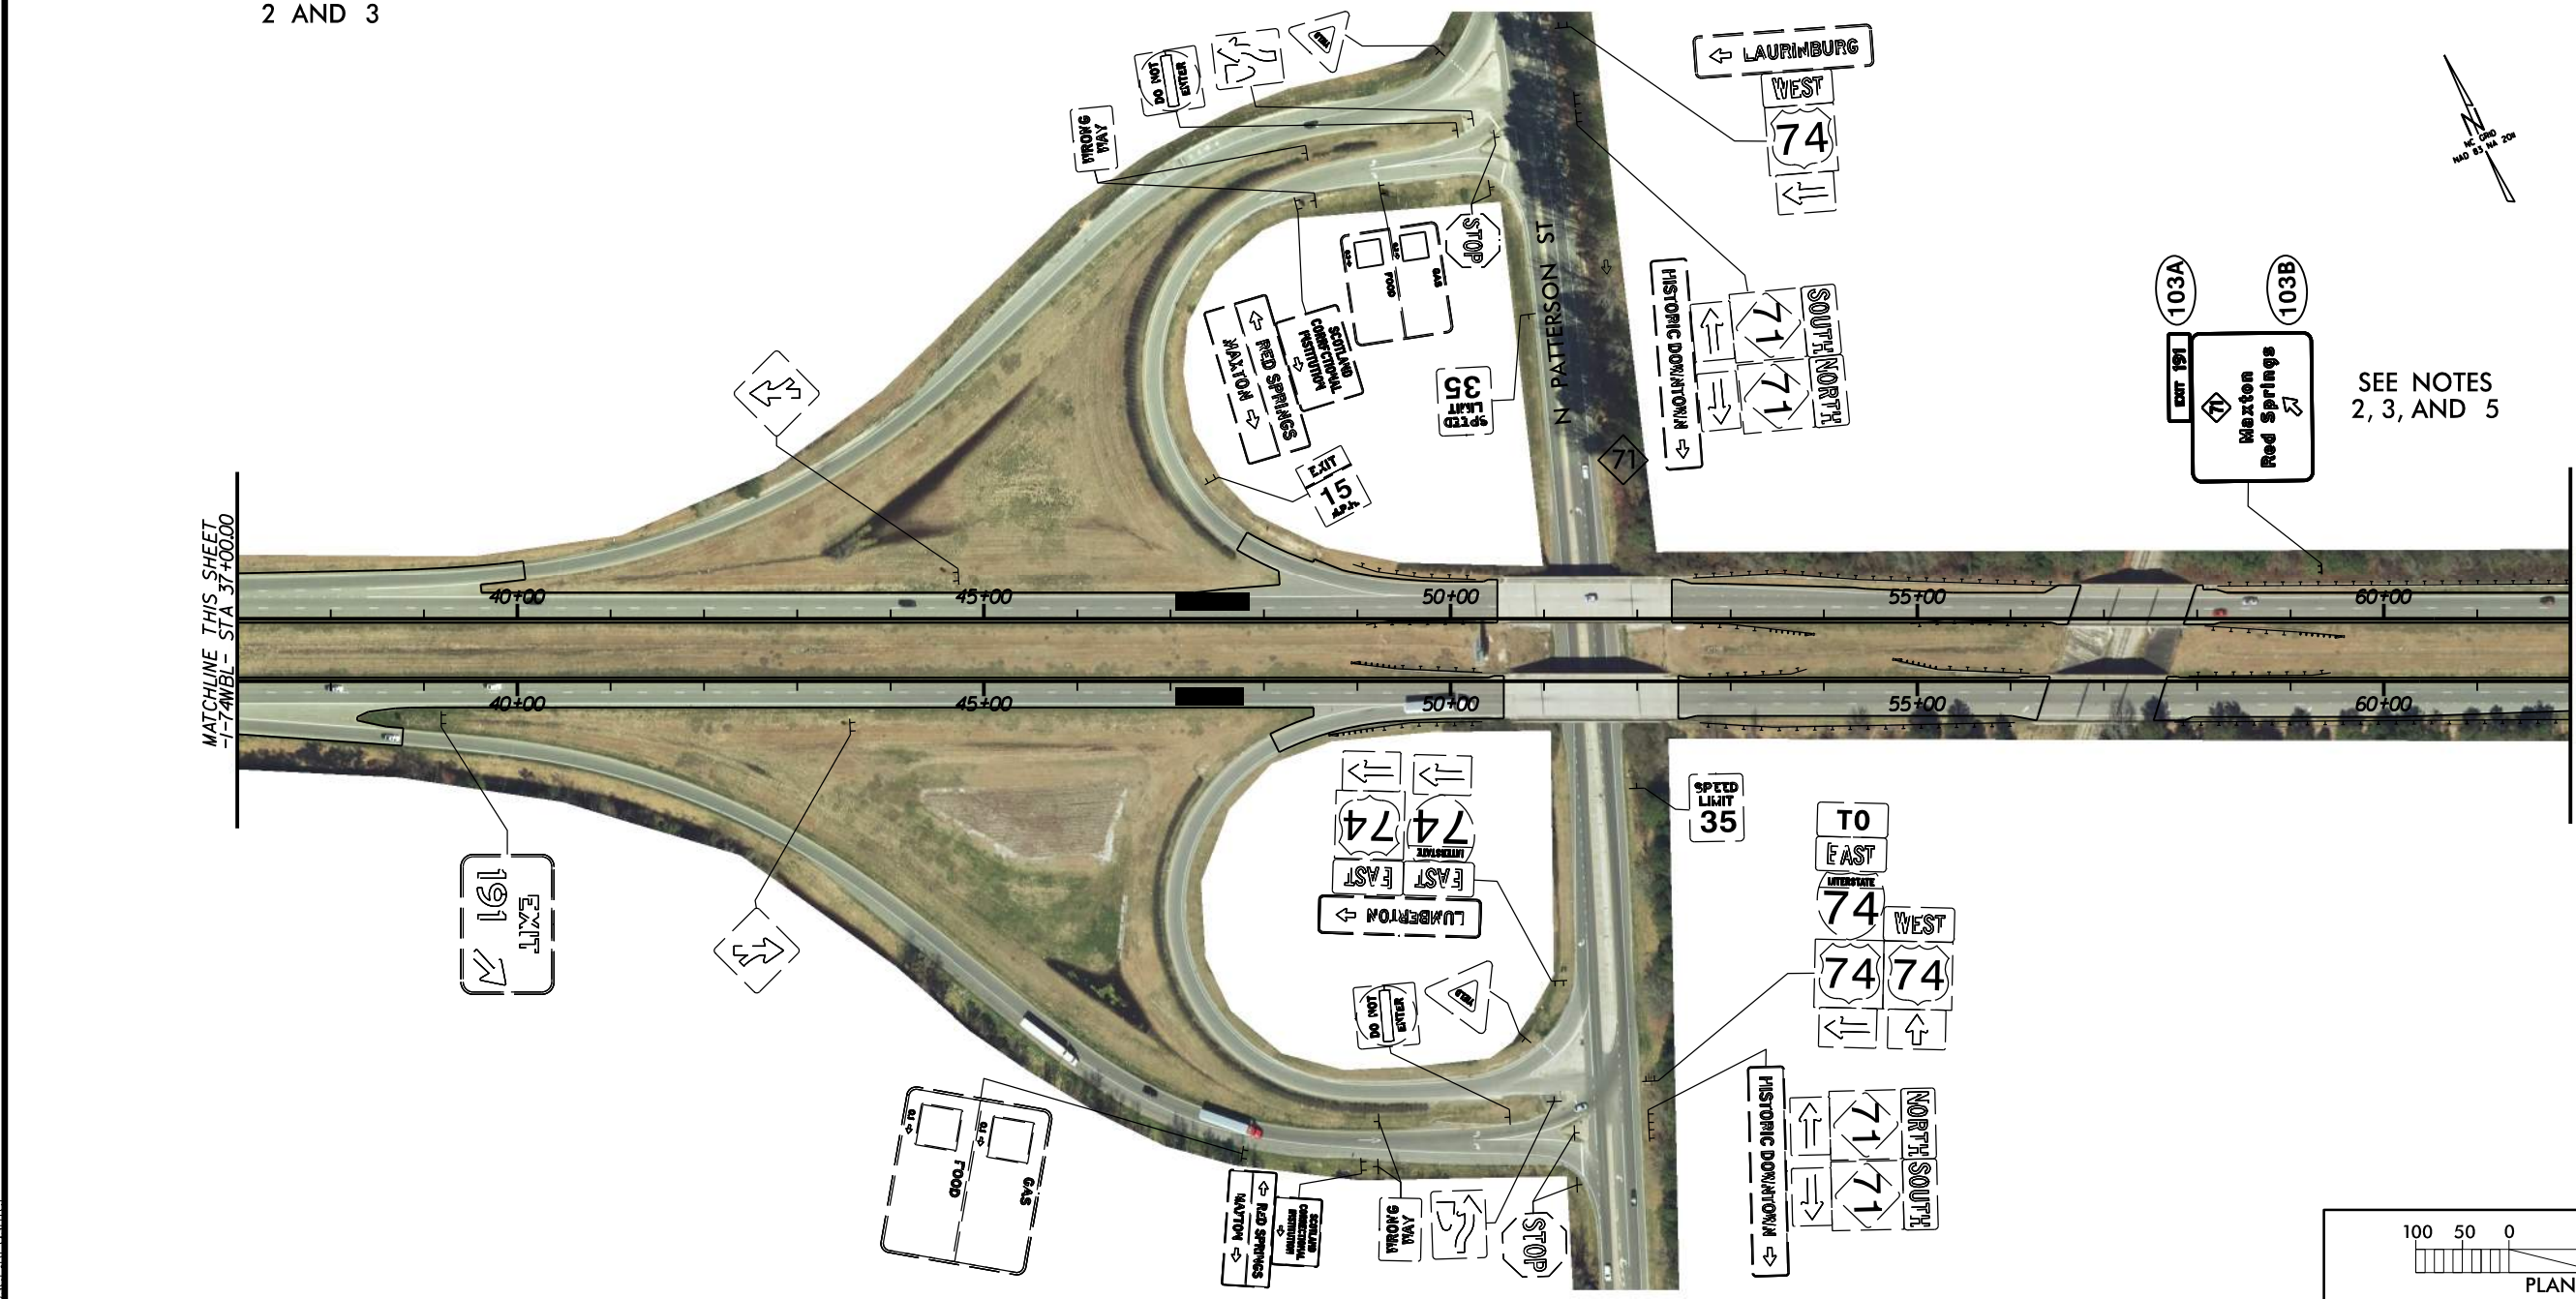


SEE NOTES 2, 3, AND 5

 


8/17/23

| | |
|--|----------------------------|
| PROJECT REFERENCE NO. HI-0017 | SHEET NO. SIGN-5 |
| DocuSigned by: <i>Richard D. Lasher</i> FA81F1EB929945F... 10/11/2023 | |
| | |
| | |

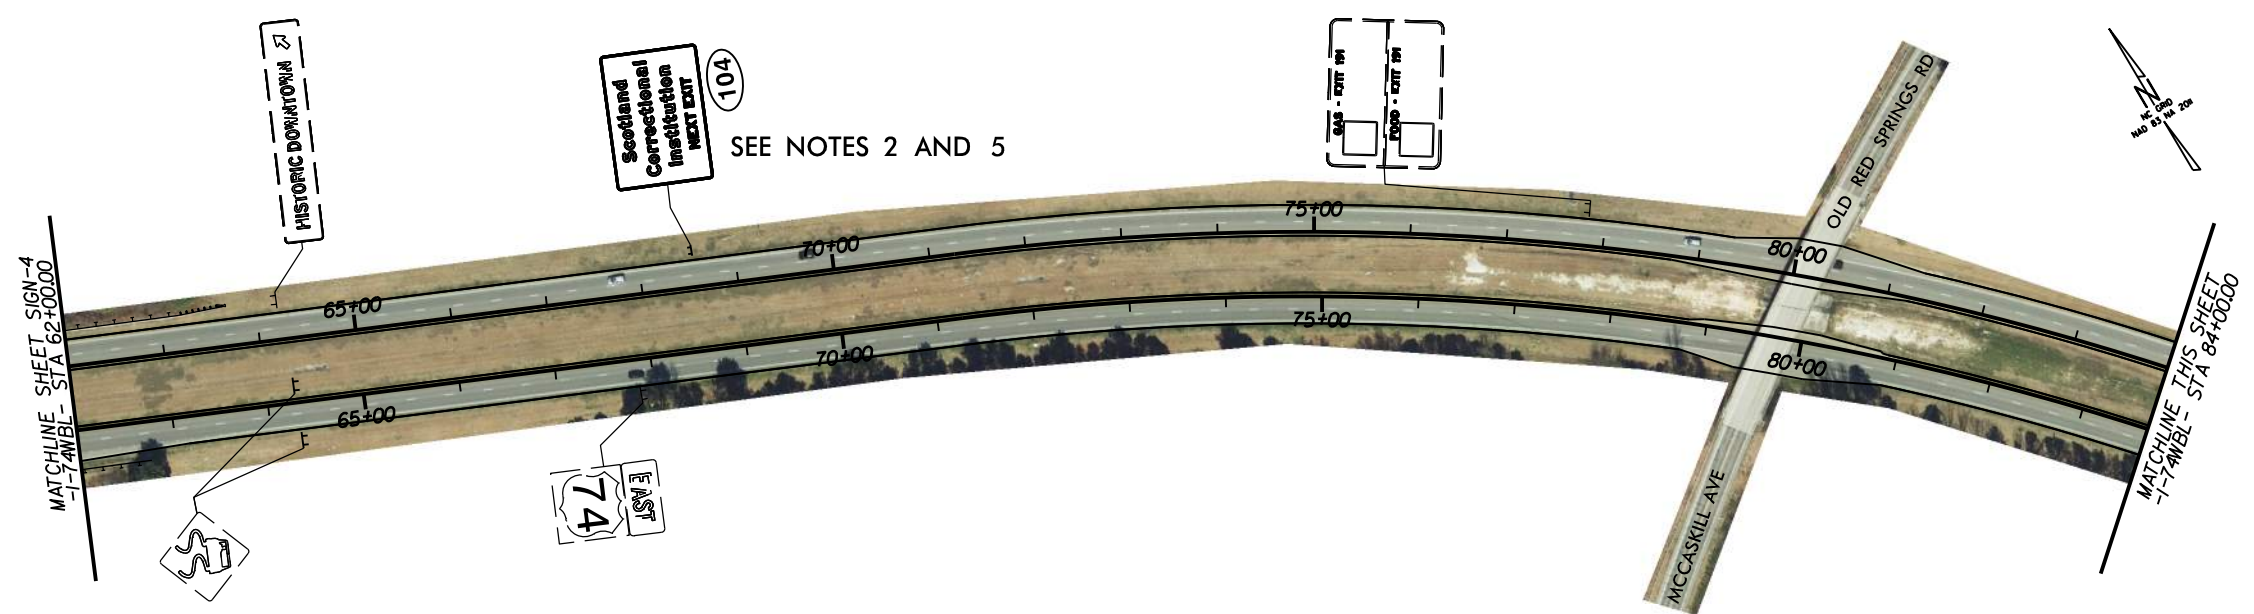


- PROJECT NOTES**
- 1 DISPOSAL OF SIGN AND SIGN ERECTION, SIGN TYPE D, E, AND F
 - 2 SIGN ERECTION, TYPE A, GROUND MOUNT
 - 3 SIGN ERECTION, TYPE B, GROUND MOUNT
 - 4 SIGN ERECTION, TYPE E
 - 5 DISPOSAL OF SIGN A OR B (GROUND MOUNT)

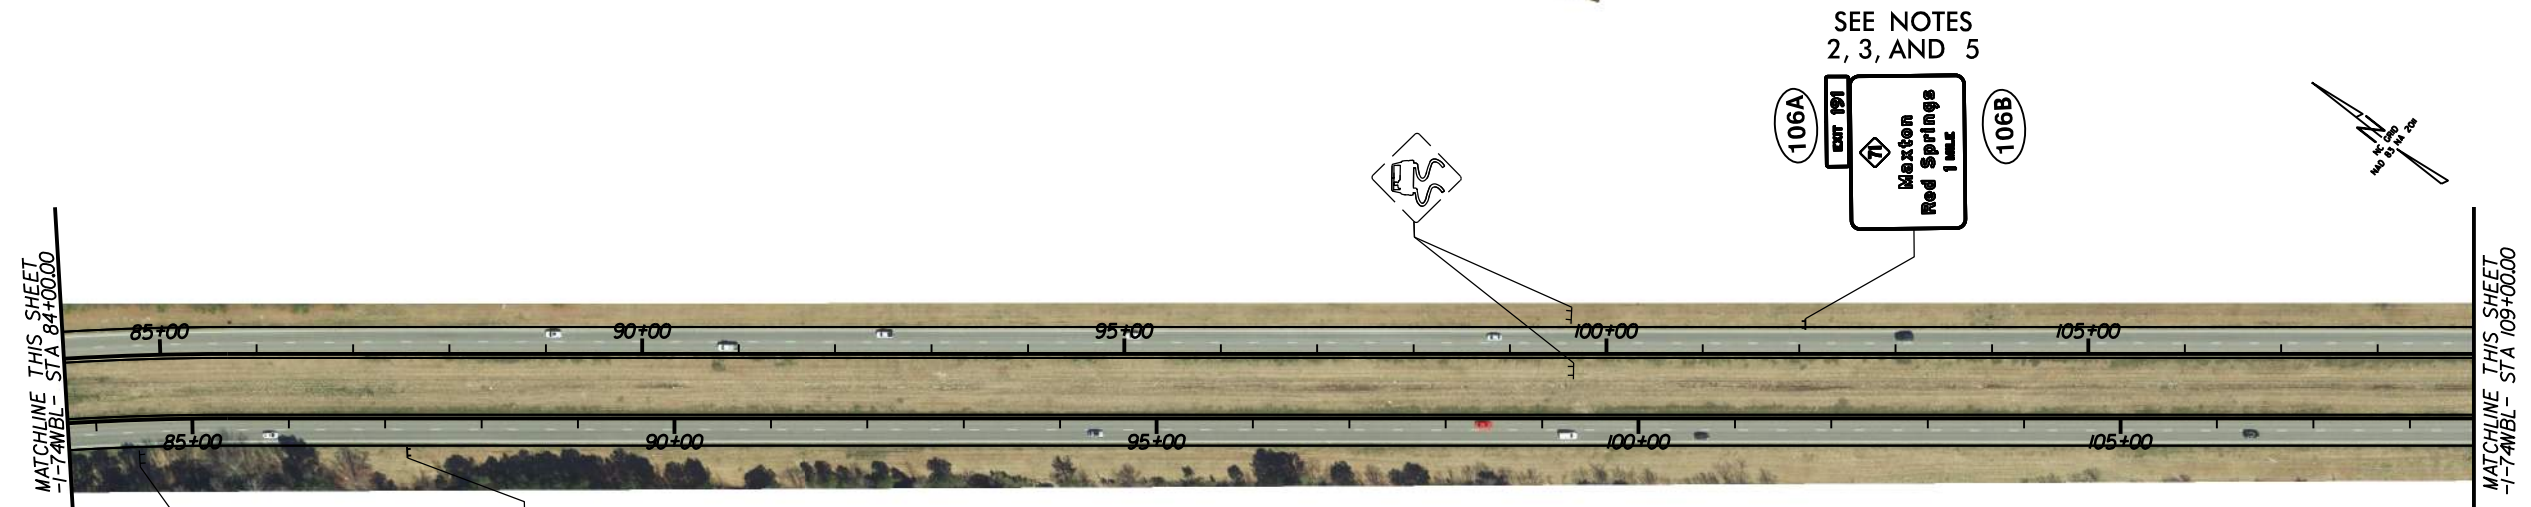

SEE NOTES 3 AND 5



 
 
SEE NOTE 4




10/16/2023
Richard D. Lasher

8/17/23


SEE NOTES 3 AND 5

| | |
|---|----------------------------|
| PROJECT REFERENCE NO. HI-0017 | SHEET NO. SIGN-6 |
| DocuSigned by: <i>Richard D. Lasher</i> FAB1F1EB929945F 10/11/2023 | |
|  | |
|  | |

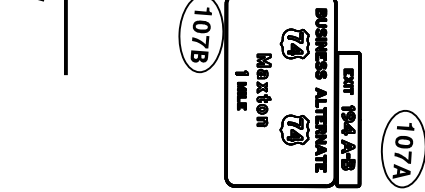


SEE NOTES 2 AND 5

- PROJECT NOTES**
- DISPOSAL OF SIGN AND SIGN ERECTION, SIGN TYPE D, E, AND F
 - SIGN ERECTION, TYPE A, GROUND MOUNT
 - SIGN ERECTION, TYPE B, GROUND MOUNT
 - SIGN ERECTION, TYPE E
 - DISPOSAL OF SIGN A OR B (GROUND MOUNT)

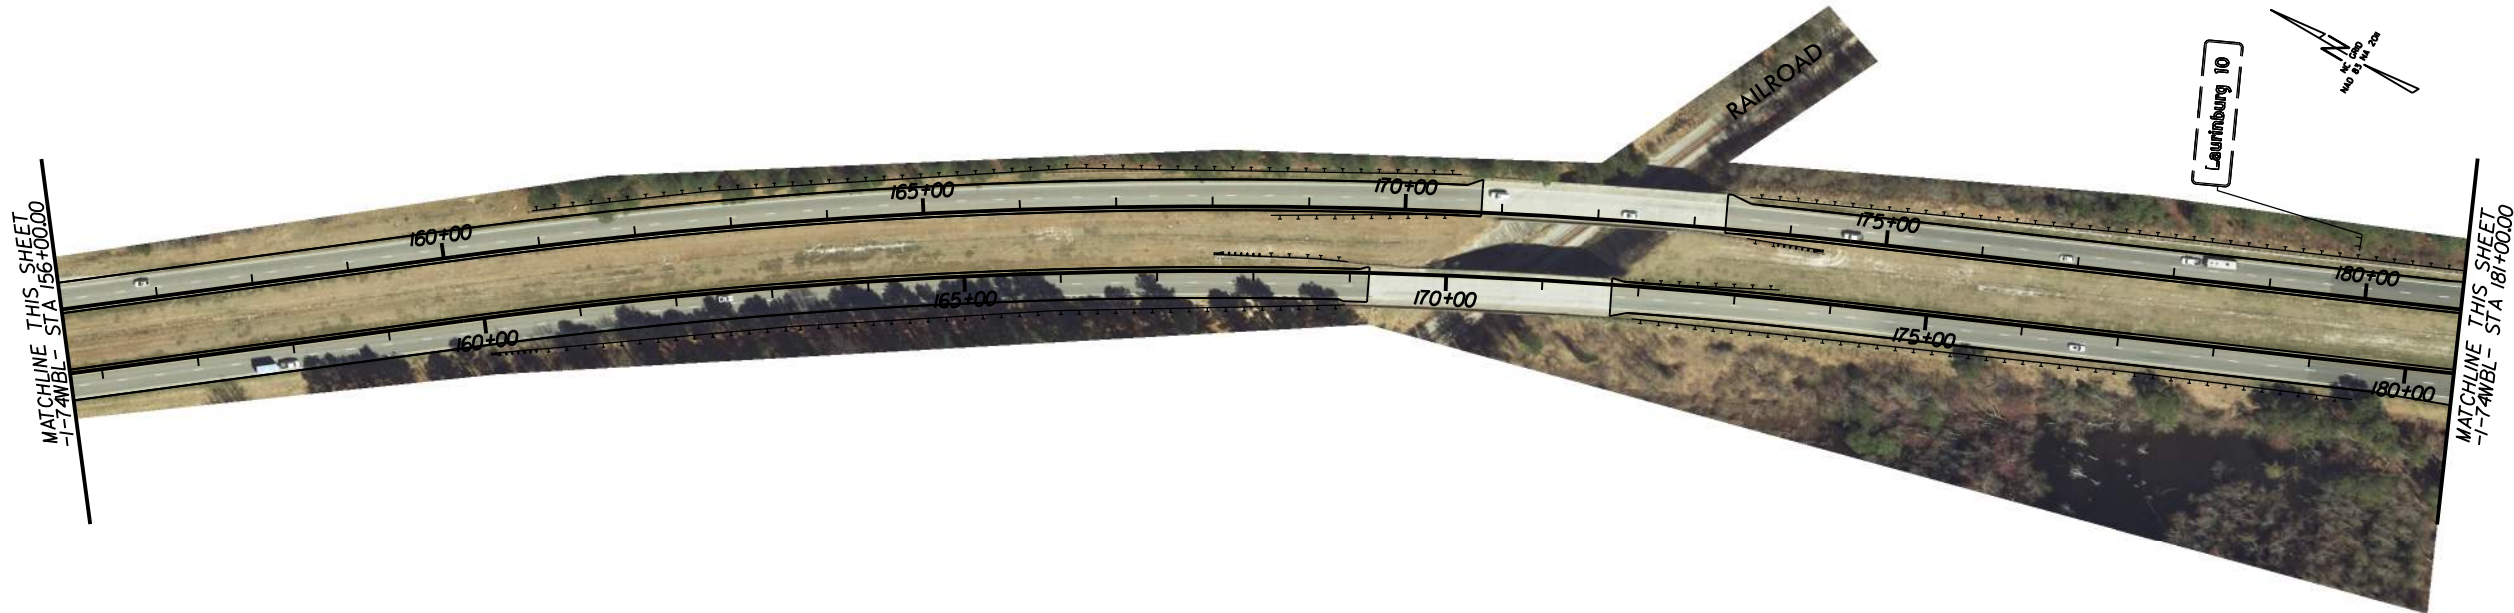


SEE NOTE 4


END PROJECT HI-0017
END MILLING AND RESURFACING
MATCH EXIST.
-I74WBL- STA. 190+00.00
-I74EBL- STA. 189+50.34

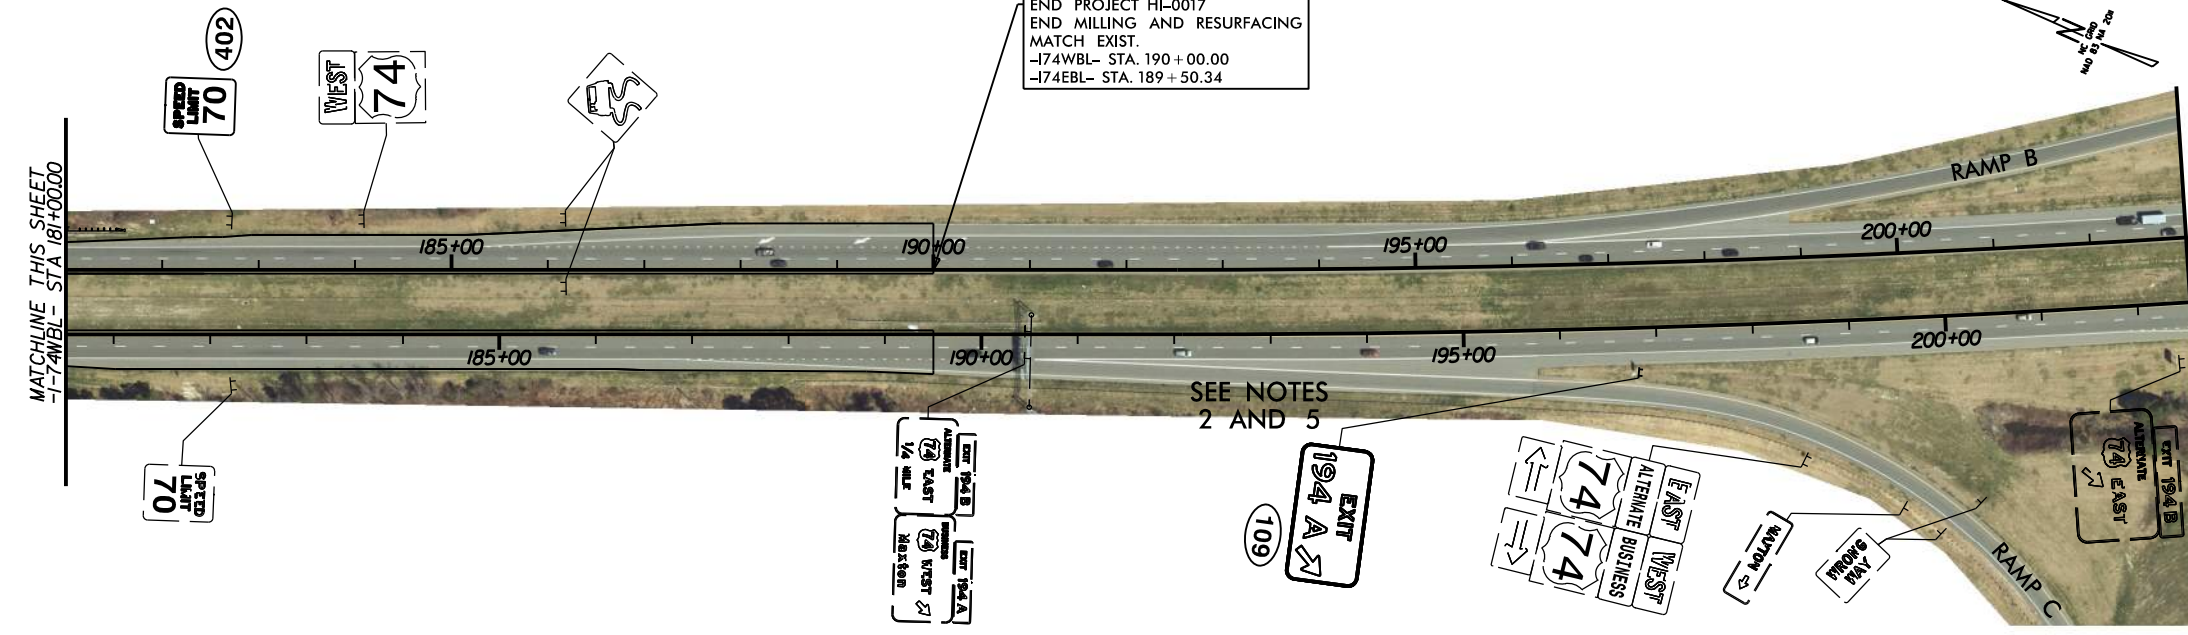

SEE NOTES 2 AND 5

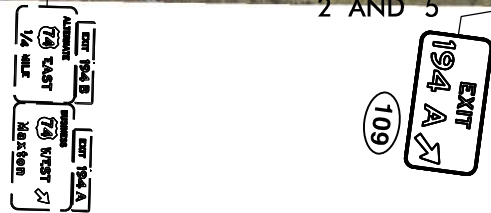

 
 
MATCHLINE THIS SHEET -I74WBL- STA 203+00.00




PLANS


9/27/2023

8/17/23

| | |
|---|----------------------------|
| PROJECT REFERENCE NO. HI-0017 | SHEET NO. SIGN-7 |
| DocuSigned by: <i>Richard D. Laster</i> FAB1F1EB929945F 10/11/2023 | |
|  | |
|  | |

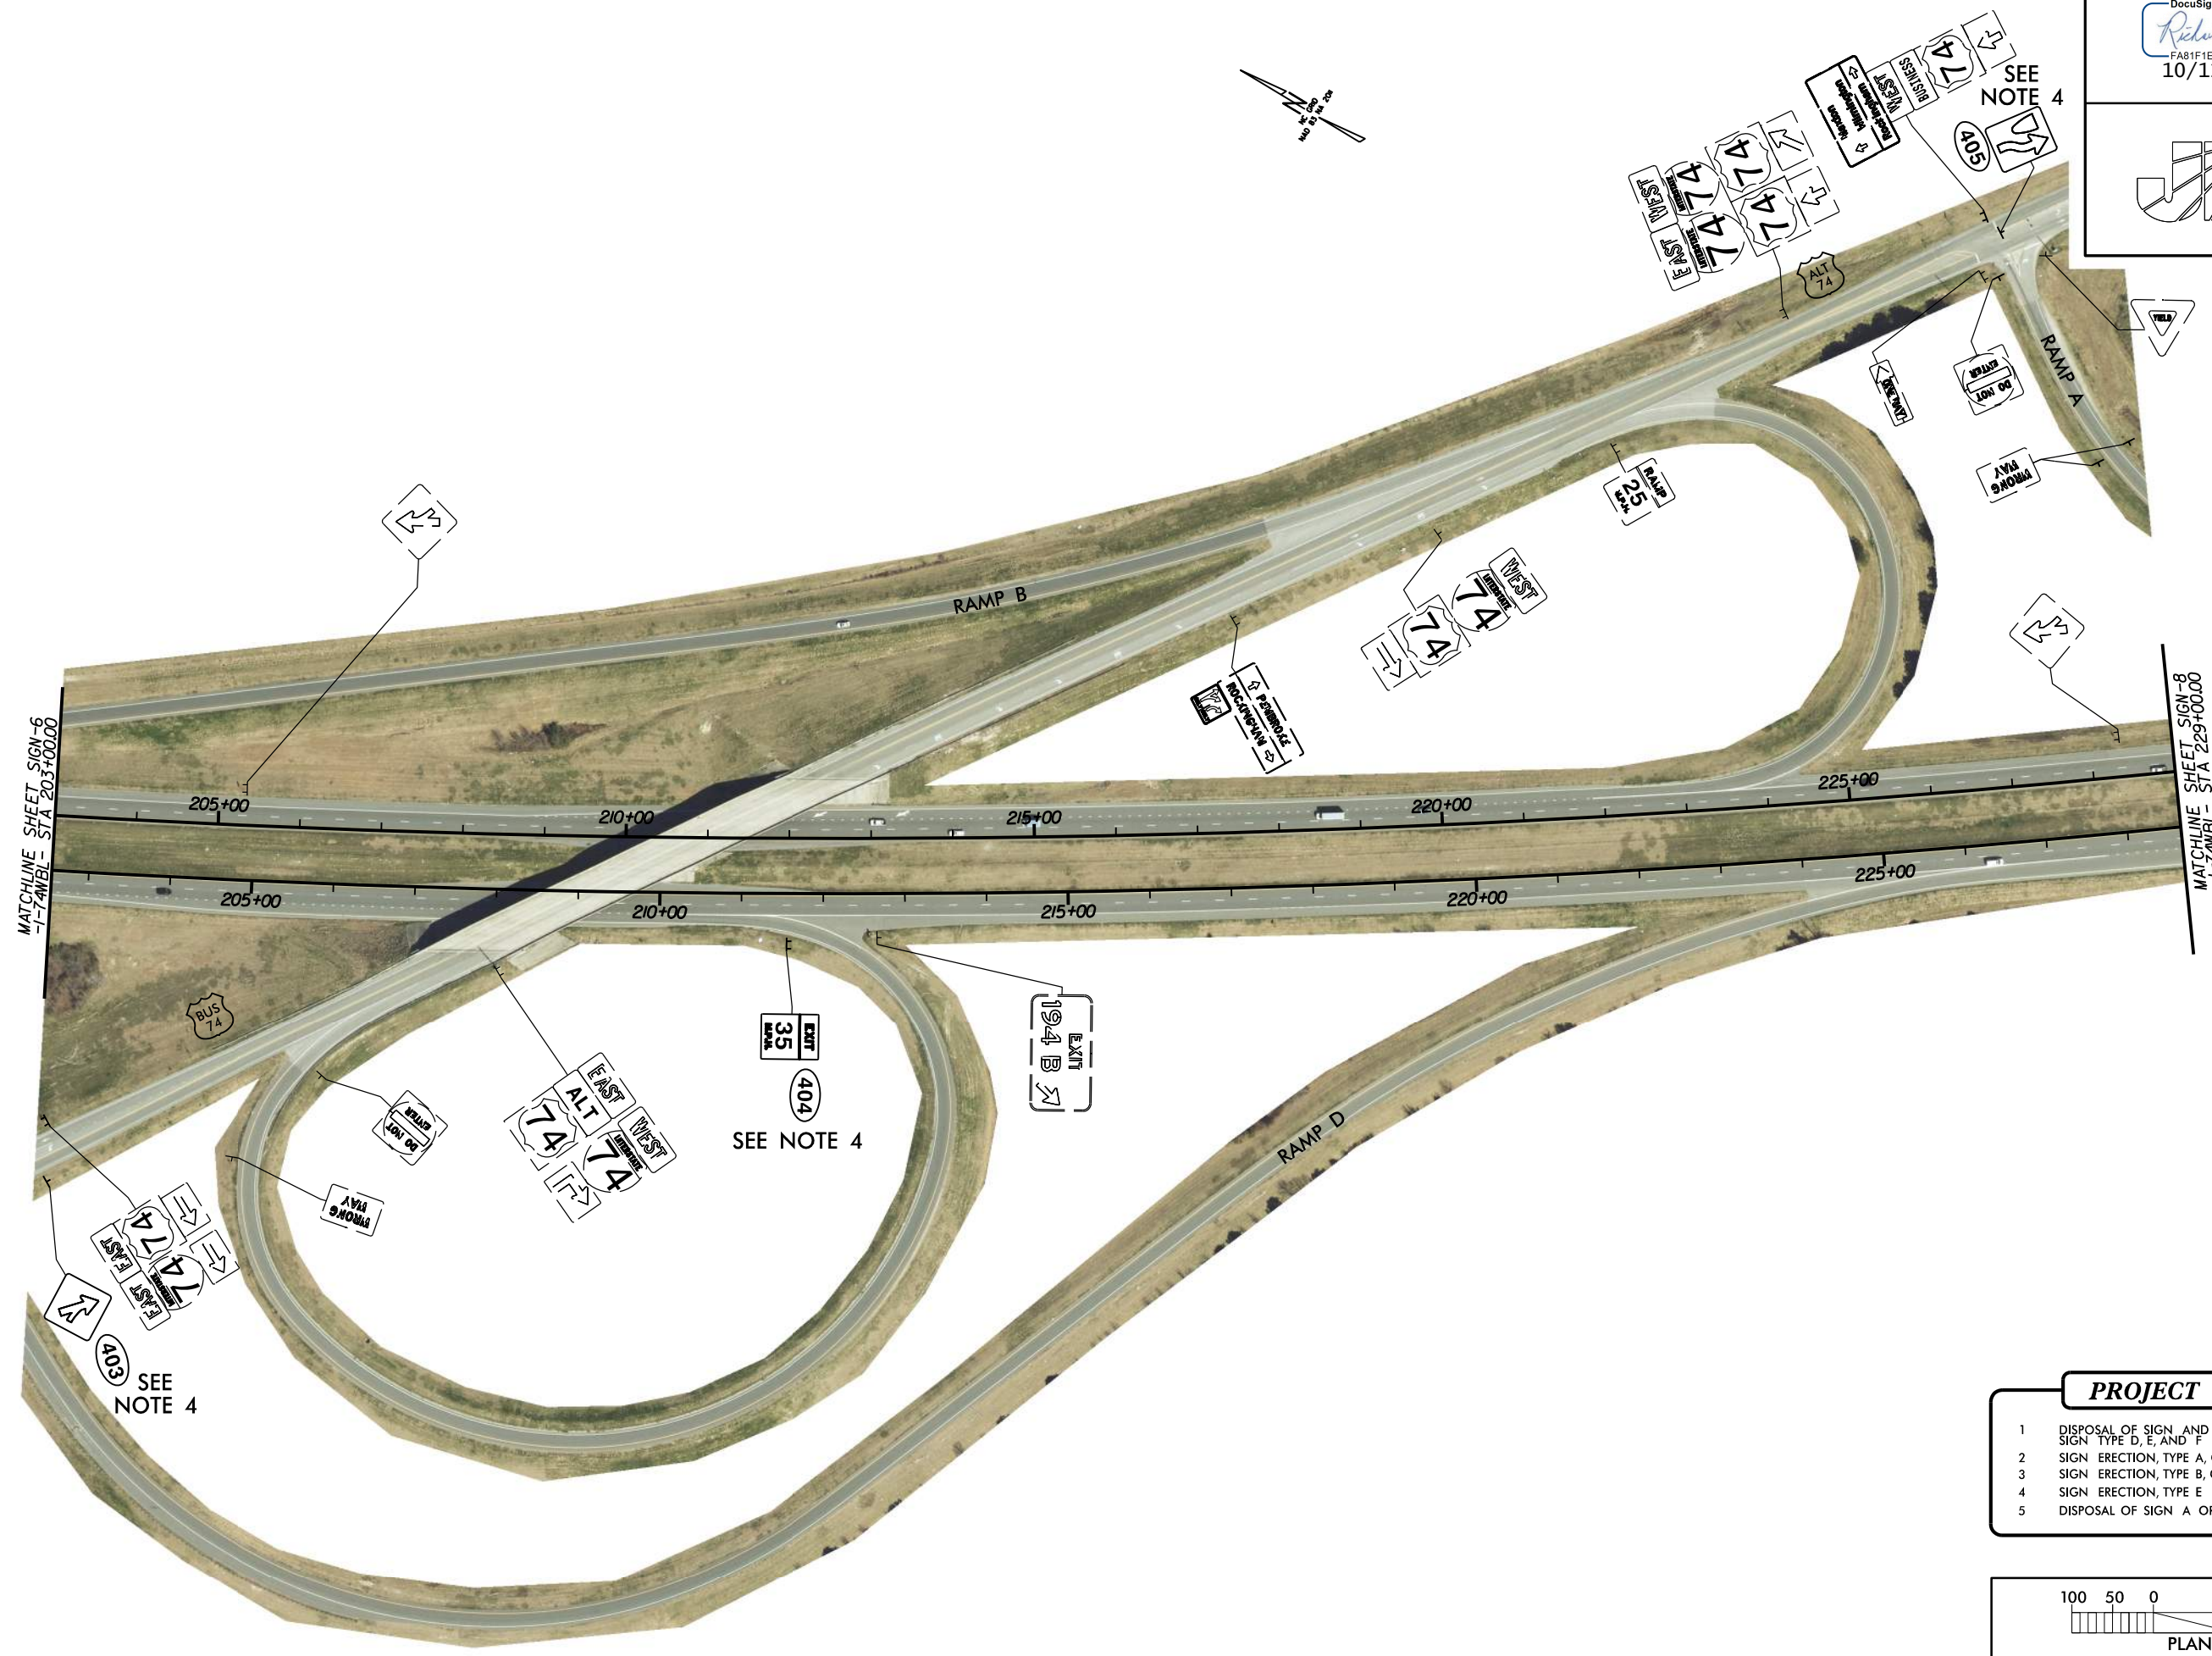


 - PROJECT NOTES**
- DISPOSAL OF SIGN AND SIGN ERECTION, SIGN TYPE D, E, AND F
 - SIGN ERECTION, TYPE A, GROUND MOUNT
 - SIGN ERECTION, TYPE B, GROUND MOUNT
 - SIGN ERECTION, TYPE E
 - DISPOSAL OF SIGN A OR B (GROUND MOUNT)



9/27/2023
Richard D. Laster

8/17/23

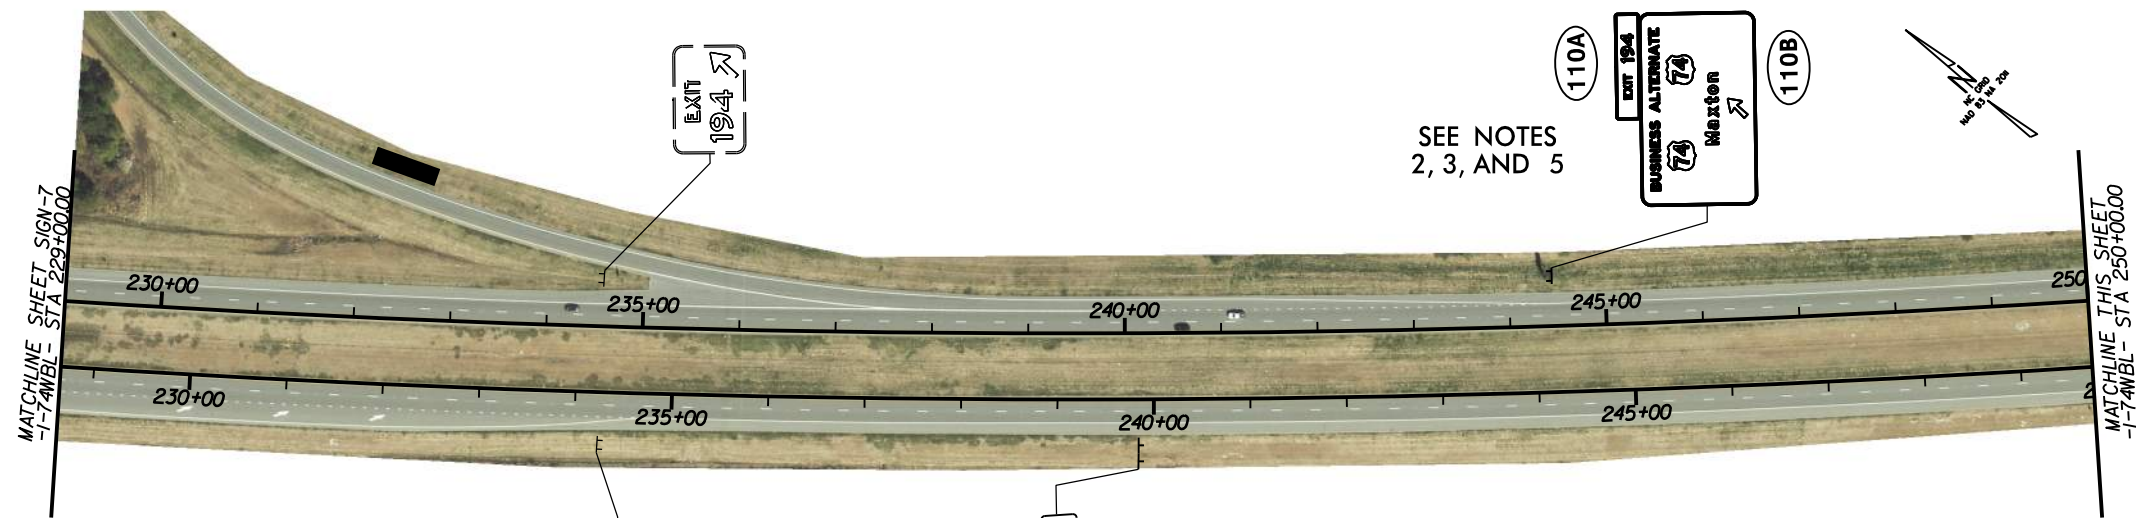

SEE NOTES 2, 3, AND 5

SEE NOTE 1

| | |
|---|----------------------------|
| PROJECT REFERENCE NO. HI-0017 | SHEET NO. SIGN-8 |
| DocuSigned by: <i>Richard D. Lasher</i> FAB1F1EB929045F 10/11/2023 | |
| | |
| | |

PROJECT NOTES

- 1 DISPOSAL OF SIGN AND SIGN ERECTION, SIGN TYPE D, E, AND F
- 2 SIGN ERECTION, TYPE A, GROUND MOUNT
- 3 SIGN ERECTION, TYPE B, GROUND MOUNT
- 4 SIGN ERECTION, TYPE E
- 5 DISPOSAL OF SIGN A OR B (GROUND MOUNT)



SEE NOTES 2, 3, AND 5



END CONSTRUCTION
-174WBL- STA. 297+00.00
-174EBL- STA. 296+75.65

