


09\_2023/299

**TIP PROJECT: U-5839**


STATE OF NORTH CAROLINA  
DIVISION OF HIGHWAYS  
**HAYWOOD COUNTY**

**LOCATION: RUSS AVENUE - US 276 FROM US 23/74 (GREAT SMOKY MOUNTAINS EXPWY) TO US 23 BUS (N MAIN ST)**  
**TYPE OF WORK: TRAFFIC SIGNALS AND SIGNAL COMMUNICATION**

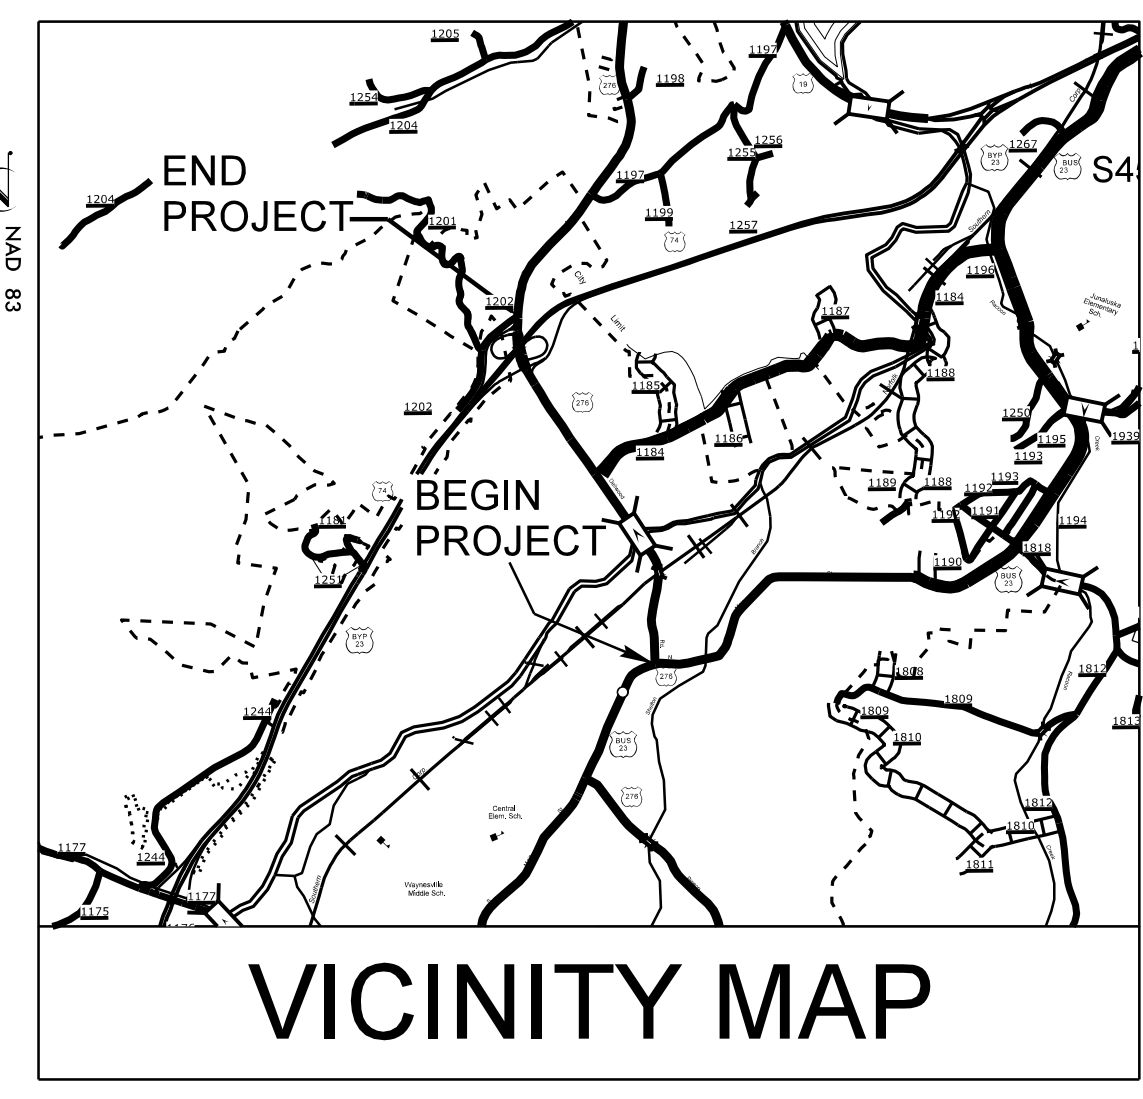

PROJECT REFERENCE NO. U-5839	SHEET NO. Sig 1.0
APPROVED BY: <i>William J. Hamilton</i> DATE: 04/11/2023	
DOCUMENT NOT CONSIDERED FINAL UNLESS ALL SIGNATURES COMPLETED	

**BEGIN TIP PROJECT U-5839**  
-L- STA. 10+19.45

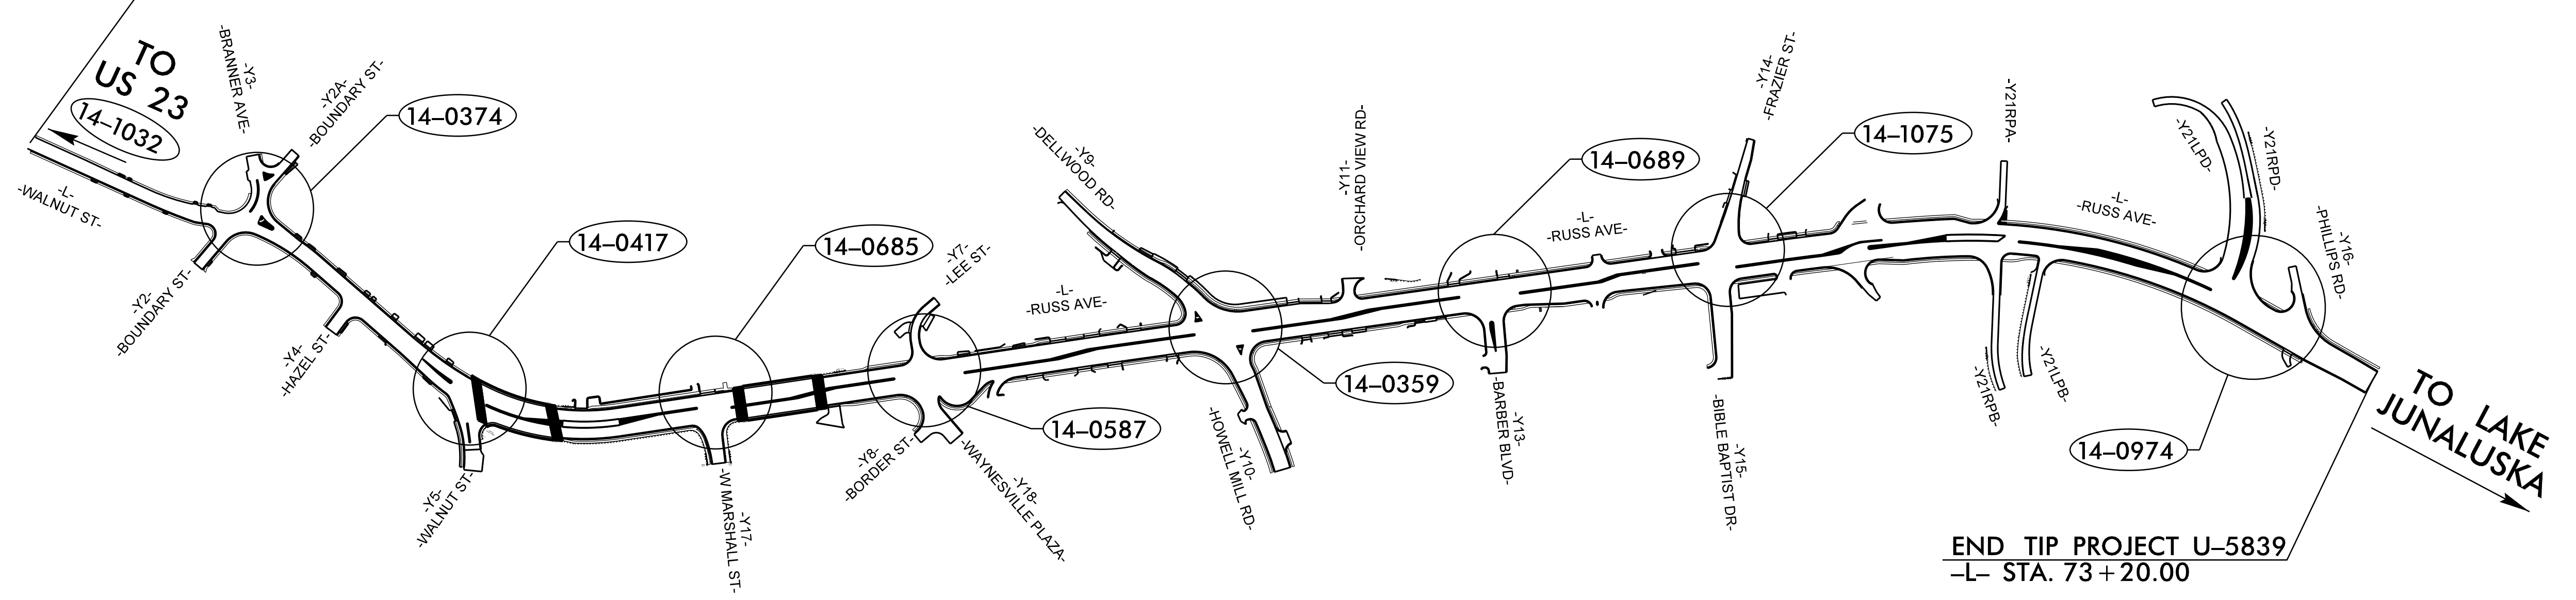

**END TIP PROJECT U-5839**  
-L- STA. 73+20.00

Refer to "Roadway Standard Drawings NCDOT" dated January 2018 and "Standard Specifications for Roads and Structures" dated January 2018.

Infrastructure Consulting Services, Inc.  
**RKA**  
RAMEY KEMP ASSOCIATES  
8210 University Executive Park Drive Suite 220 Charlotte, North Carolina 28226  
Phone: 704-549-4300 | www.rameykemp.com | NC License No. P-1489

**PLANS PREPARED BY:**  
  
**W. Jason Hamilton, P.E., PTOE - Project Manager**  
  
**Timothy S. Popelka, P.E. - Project Engineer**

**INDEX OF PLANS**

Sheet Number	SIN	Location/Description
Sig. 1.0	-	Project Title Sheet
Sig. 1.1-1.2	-	2018 Standard Plate Sheets
Sig. 1.3	-	CCTV Wood Pole Detail
Sig. 2.0-2.9	14-0374	US 276 (Walnut Street/Russ Avenue) at Branner Avenue/Boundary Street
Sig. 3.0-3.9	14-0417	US 276 (Russ Avenue) at Walnut Street
Sig. 4.0-4.13	14-0685	US 276 (Russ Avenue) at West Marshall Street/Bank Drive
Sig. 5.0-5.11	14-0587	US 276 (Russ Avenue) at Shopping Center Entrance /Lee Street
Sig. 6.0-6.15	14-0359	US 276 (Russ Avenue) at Delwood Road /SR 1184 (Howell Mill Road)
Sig. 7.0-7.13	14-0689	US 276 (Russ Avenue) at Ingles Shopping Center /Long John Silver Drive
Sig. 8.0-8.14	14-1075	US 276 (Russ Avenue) at Frazier Street/Ingles Entrance
Sig. 9.0-9.12	14-0974	US 276 (Russ Avenue) at US 23-74 WB Ramps
Sig. M1-M8	-	Standard Metal Pole Drawings
SCPI-SCP21	-	Signal Communication Plans

DIVISION OF HIGHWAYS

750 N. Greenfield Pkwy, Garner, NC 27529

**LEGEND**

(XX-XXXX) **TRAFFIC SIGNAL**

---

**TRANSPORTATION SYSTEMS  
MANAGEMENT & OPERATIONS**

Contacts:

**R. Nicholas Zinser, P.E. - Western Region Signals Engineer**  
**D. Todd Joyce, P.E. - Signal Equipment Design Review Engineer**  
**Gregory A. Green - Signal Communications Project Engineer**  
**Heidi T. Berggren, E.I. - Signal Communications Project Design Engineer**

4/12/2023  
\\04-Design\U5839\_sig\_1.sh.dgn  
User: jwendt