




**PROJECT: BR-0069**

STATE OF NORTH CAROLINA  
DEPARTMENT OF TRANSPORTATION

**SIGNING PLAN  
CASWELL COUNTY**

**LOCATION: BRIDGE NO.160001 OVER COUNTRY LINE CREEK ON  
US 158 /NC 86**

PROJECT REFERENCE NO. <b>BR-0069</b>	SHEET NO. <b>SIGN-1</b>
APPROVED:  DATE: 2/5/2024	
SEAL 	
 <b>moffatt &amp; nichol</b> <small>4700 FALLS OF NEUSE ROAD, SUITE 300 RALEIGH, NORTH CAROLINA 27609 19191 781-4626 VOICE 19191 781-4869 FAX 1F-0105</small>	
<b>DOCUMENT NOT CONSIDERED FINAL UNLESS ALL SIGNATURES COMPLETED</b>	

**PROJECT NOTES**

1 DISPOSAL OF SIGN SYSTEM, U-CHANNEL

**SUMMARY OF QUANTITIES**

ITEM NO.		ITEM DESCRIPTION	QUANTITY	UNIT
DESC. NO.	SECT. NO.			
4025000000	901	CONTRACTOR FURNISHED, TYPE D SIGN	28.00	S.F.
4072000000	903	SUPPORTS, 3LB STEEL U-CHANNEL	80.00	L.F.
4096000000	904	SIGN ERECTION, TYPE D	4	EA.
4155000000	907	DISPOSAL OF SIGN SYSTEM, U-CHANNEL	2	EA.

**INDEX**

SHEET NO.	DESCRIPTION
SIGN-1	TITLE SHEET
SIGN-2	PROPOSED SIGN DESIGN
SIGN-3	SIGNING PLAN SHEETS

**PLAN PREPARED BY: MOFFATT & NICHOL**

<u>TRENT HUFFMAN, PE</u>	PROJECT ENGINEER
<u>ZITONG LIU, EI</u>	PROJECT DESIGN

**PLAN REVIEWED BY: NCDOT SIGNING AND DELINEATION UNIT**

<u>KELVIN JORDAN</u>	SIGNING & DELINEATION REGIONAL ENGINEER
<u>WALTER JOHNSON</u>	SIGNING & DELINEATION PROJECT DESIGN ENGINEER


**GENERAL NOTES**

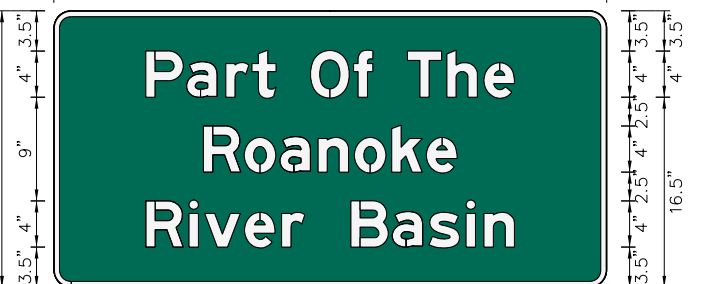
- SIGNS FURNISHED BY CONTRACTOR.
- ALL TYPE 'D' SIGNS SHALL BE MOUNTED ON TWO U-CHANNEL POSTS UNLESS OTHERWISE INDICATED ON THE PLANS.
- IF REMOVAL OR RELOCATION OF SIGNS ON PRIVATE STREET (NON-STATE MAINTAINED) IS REQUIRED DUE TO CONSTRUCTION, THE CONTRACTOR SHALL INFORM THE ENGINEER. THE WORK WILL BE COMPLETED BY OTHERS.
- ALL EXISTING SIGNS ON 'U' CHANNEL POST WITHIN THE PROJECT LIMITS SHALL BE REMOVED AND DISPOSTED OF UNLESS OTHERWISE NOTED ON PLANS.
- SEE ROADWAY PLANS FOR GUARD/GUIDE RAIL DETAILS.

**ROADWAY STANDARD DRAWINGS**

 
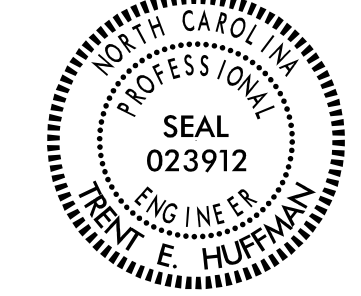

THE FOLLOWING ROADWAY STANDARDS AS SHOWN IN "ROADWAY STANDARD DRAWINGS" - PROJECT SERVICES UNIT - N.C. DEPARTMENT OF TRANSPORTATION - RALEIGH, N.C., DATED JANUARY 2024 ARE APPLICABLE TO THIS PROJECT AND BY REFERENCE HEREBY ARE CONSIDERED A PART OF THESE PLANS:

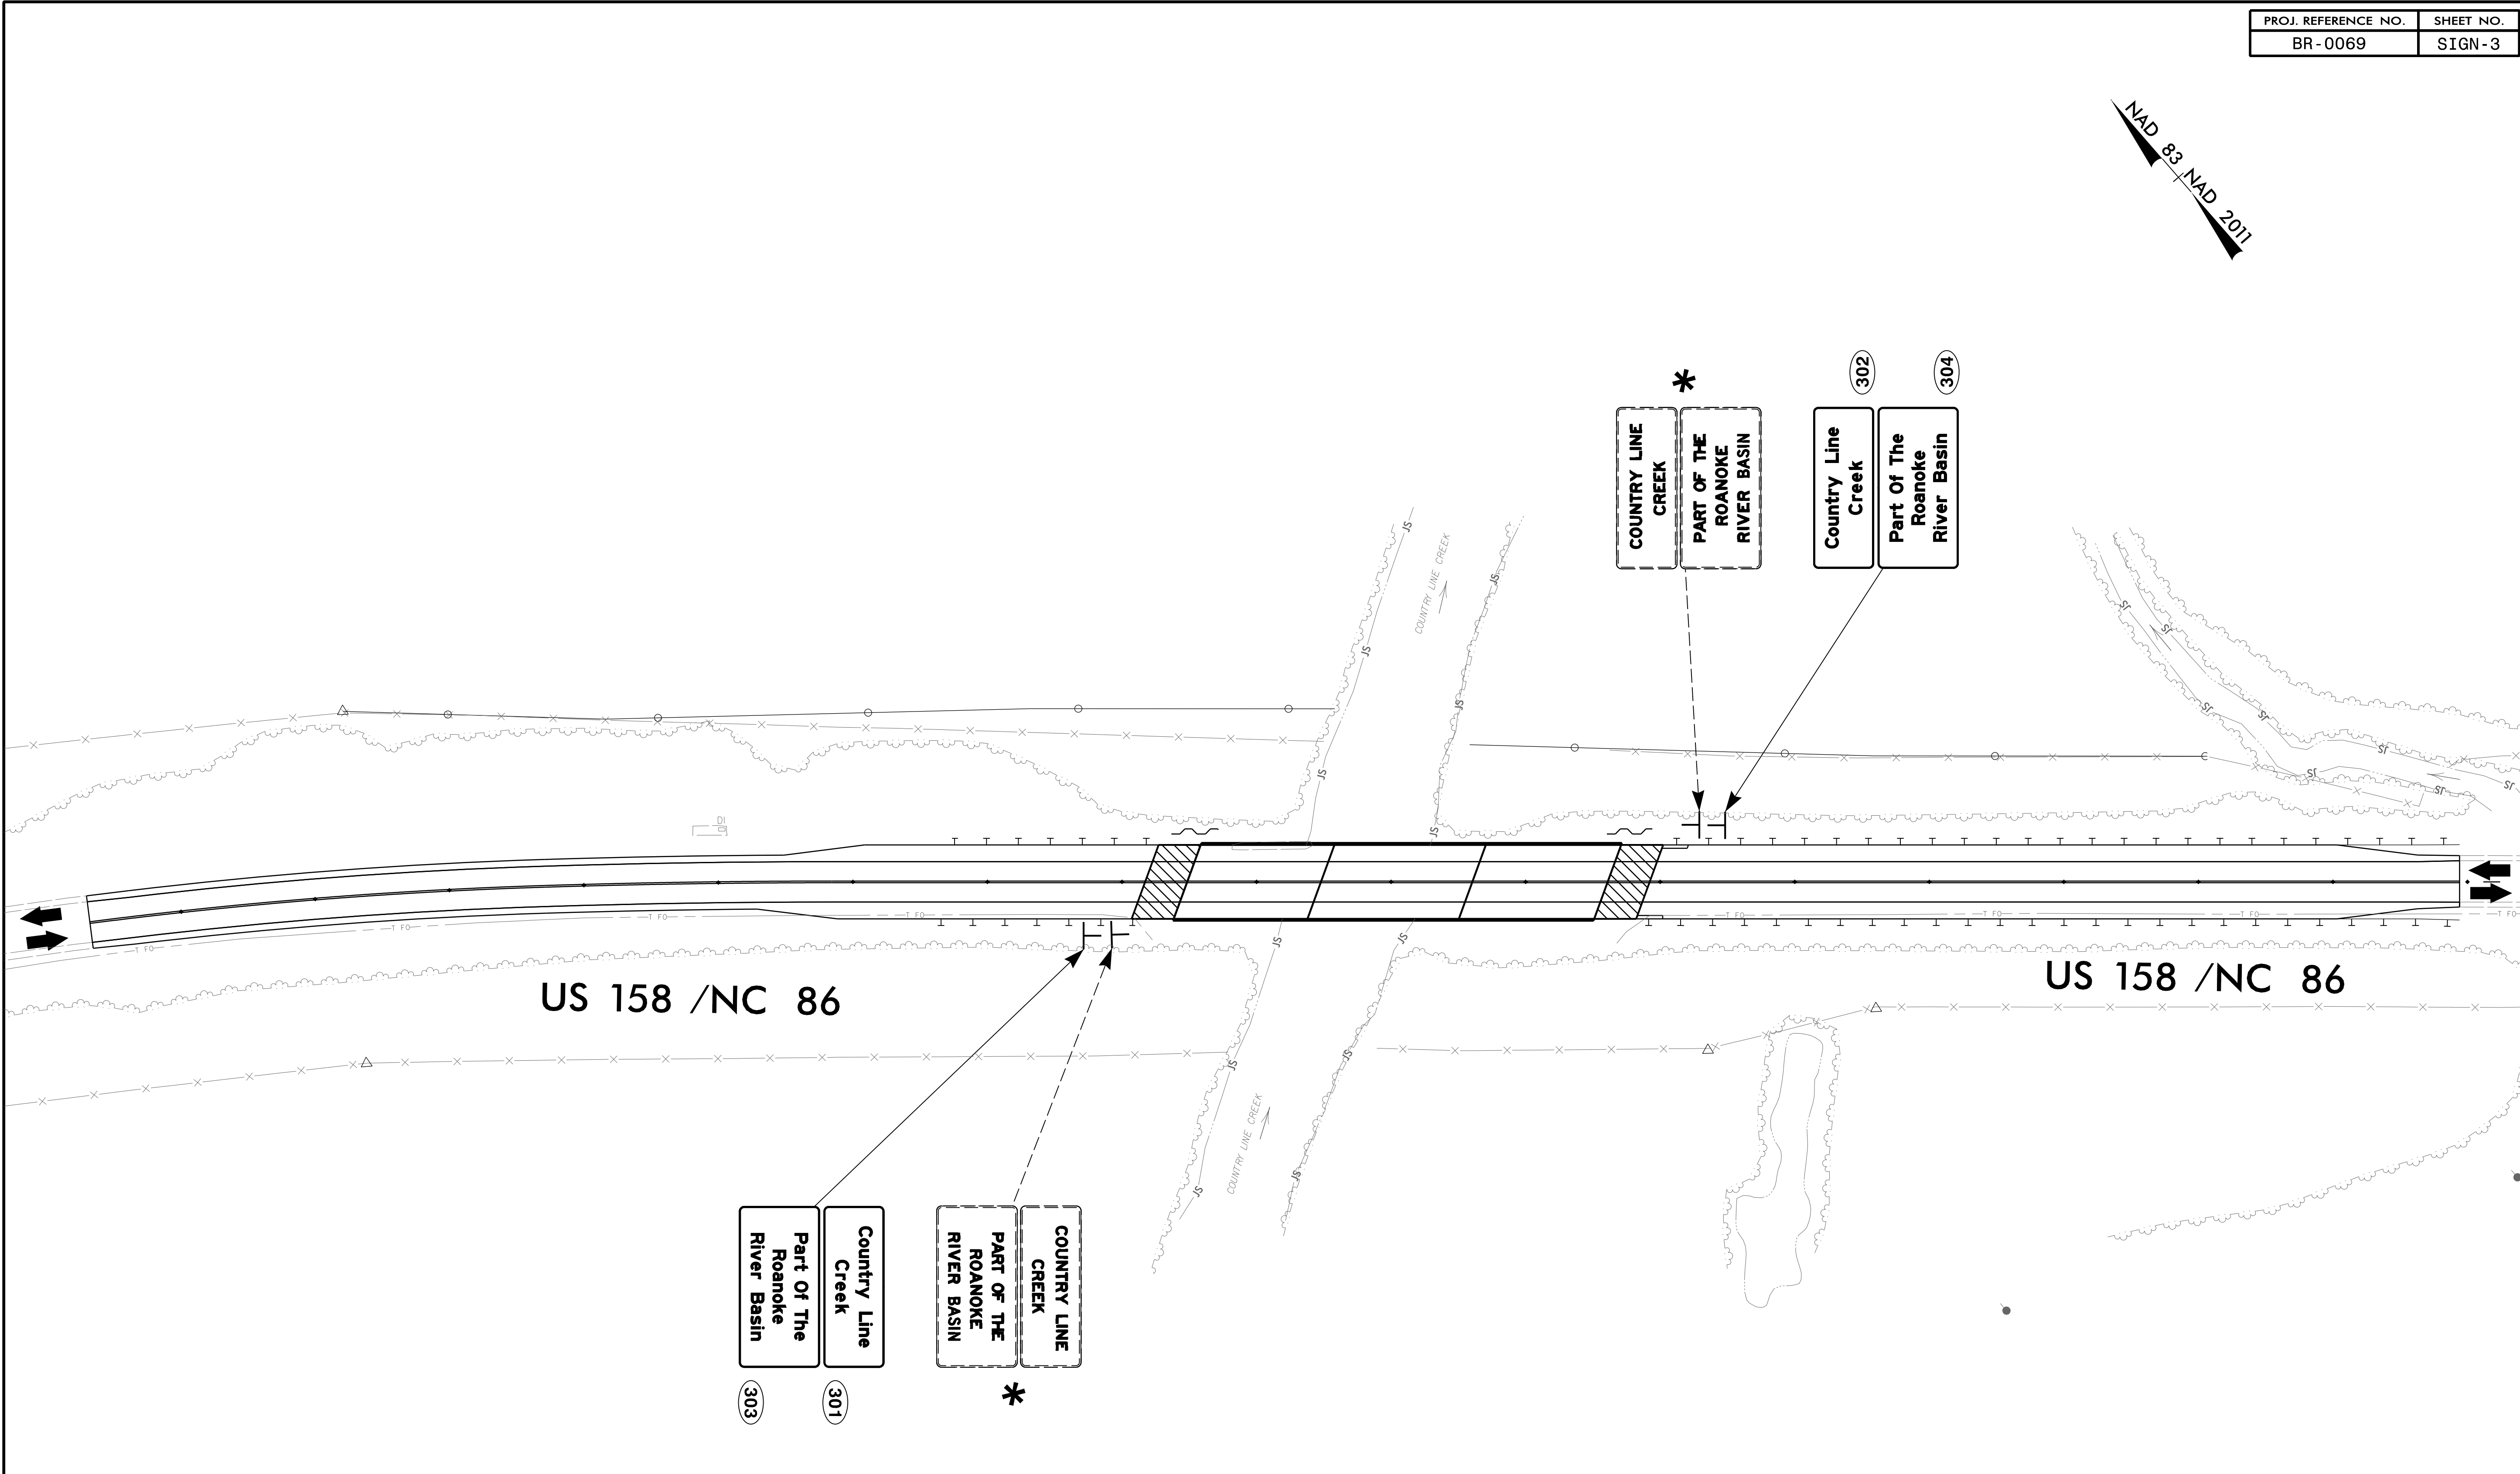
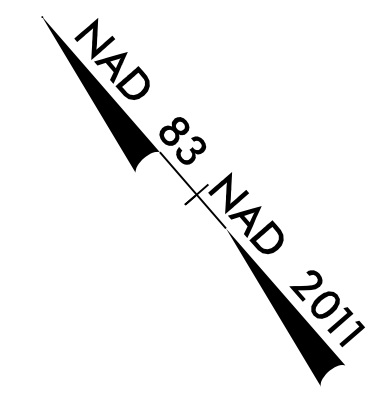
STD. NO.	TITLE
904.10	ORIENTATION OF GROUND MOUNTED SIGNS
904.50	MOUNTING OF TYPE 'D', 'E' AND 'F' SIGNS ON 'U' CHANNEL POSTS

<p>SIGN NUMBER: 301 &amp; 302                  TYPE: D                  QUANTITY: 2                  SIGN WIDTH: 4'-0"                  HEIGHT: 1'-6"                  TOTAL AREA: 6.00 Sq.Ft.                  BORDER TYPE: Reflective                  RECESS: 0.00"                  WIDTH: 0.50"                  RADII: 1.50"                  NO. Z BARS:                  LENGTH:</p>	<p>BACKG COLOR: Green                  COPY COLOR: White</p> <table border="1" style="width: 100%; border-collapse: collapse;"> <tr> <th>SYMBOL</th> <th>X</th> <th>Y</th> <th>WID</th> <th>HT</th> </tr> <tr><td> </td><td> </td><td> </td><td> </td><td> </td></tr> <tr><td> </td><td> </td><td> </td><td> </td><td> </td></tr> <tr><td> </td><td> </td><td> </td><td> </td><td> </td></tr> <tr><td> </td><td> </td><td> </td><td> </td><td> </td></tr> <tr><td> </td><td> </td><td> </td><td> </td><td> </td></tr> <tr><td> </td><td> </td><td> </td><td> </td><td> </td></tr> <tr><td> </td><td> </td><td> </td><td> </td><td> </td></tr> </table> <p>MAT'L: 0.080" (2.0 mm) ALUMINUM</p>	SYMBOL	X	Y	WID	HT																																				<p>DESIGN BY: Z LIU                  PROJECT ID: BR-0069</p> <p>CHECKED BY: G MODLIN                  LOCATION: US 158 / NC 86</p> <p>March 24, 2023                  DIV: 07</p>	<div style="text-align: center;">  <p style="font-size: small;">BORDER R=1.5" TH=0.5" Panel Style: guide_con_destination.ssi M.U.T.C.D.: 2009 Edition</p> </div> <p style="text-align: center; font-size: x-small;">Spacing Factor is 1 unless specified otherwise</p>																																																																											
SYMBOL	X	Y	WID	HT																																																																																																																		
<p><b>USE NOTES: 1,2</b></p> <p>1. Legend and border (except those that are colored black) shall be direct applied Grade C sheeting.                  2. Background shall be Grade C reflective sheeting.</p>																																																																																																																						
<p><b>LETTER POSITIONS</b></p> <table border="1" style="width: 100%; border-collapse: collapse;"> <thead> <tr> <th colspan="12">Letter spacings are to start of next letter</th> <th>Series/Size</th> </tr> <tr> <th colspan="12"></th> <th>Text Length</th> </tr> </thead> <tbody> <tr> <td>C</td><td>o</td><td>u</td><td>n</td><td>t</td><td>r</td><td>y</td><td>L</td><td>i</td><td>n</td><td>e</td><td></td><td></td><td>EM 2000</td> </tr> <tr> <td>6.0</td><td>3.6</td><td>3.2</td><td>3.3</td><td>3.1</td><td>2.6</td><td>2.2</td><td>3.4</td><td>4.0</td><td>3.3</td><td>1.5</td><td>3.1</td><td>2.6</td><td>6.0</td><td>4/3</td> </tr> <tr> <td></td><td></td><td></td><td></td><td></td><td></td><td></td><td></td><td></td><td></td><td></td><td></td><td></td><td></td><td>36</td> </tr> <tr> <td>C</td><td>r</td><td>e</td><td>e</td><td>k</td><td></td><td></td><td></td><td></td><td></td><td></td><td></td><td></td><td></td><td>EM 2000</td> </tr> <tr> <td>16.0</td><td>4.1</td><td>2.4</td><td>3.3</td><td>3.6</td><td>2.6</td><td>16.0</td><td></td><td></td><td></td><td></td><td></td><td></td><td></td><td>4/3</td> </tr> <tr> <td></td><td></td><td></td><td></td><td></td><td></td><td></td><td></td><td></td><td></td><td></td><td></td><td></td><td></td><td>16</td> </tr> </tbody> </table> <p style="font-size: x-small;">FILENAME: BR-0069_sign-02 <span style="float: right;">NORTH CAROLINA D.O.T. SIGN DETAIL</span></p>				Letter spacings are to start of next letter												Series/Size													Text Length	C	o	u	n	t	r	y	L	i	n	e			EM 2000	6.0	3.6	3.2	3.3	3.1	2.6	2.2	3.4	4.0	3.3	1.5	3.1	2.6	6.0	4/3															36	C	r	e	e	k										EM 2000	16.0	4.1	2.4	3.3	3.6	2.6	16.0								4/3															16
Letter spacings are to start of next letter												Series/Size																																																																																																										
												Text Length																																																																																																										
C	o	u	n	t	r	y	L	i	n	e			EM 2000																																																																																																									
6.0	3.6	3.2	3.3	3.1	2.6	2.2	3.4	4.0	3.3	1.5	3.1	2.6	6.0	4/3																																																																																																								
														36																																																																																																								
C	r	e	e	k										EM 2000																																																																																																								
16.0	4.1	2.4	3.3	3.6	2.6	16.0								4/3																																																																																																								
														16																																																																																																								

<p>SIGN NUMBER: 303 &amp; 304                  TYPE: D                  QUANTITY: 2                  SIGN WIDTH: 4'-0"                  HEIGHT: 2'-0"                  TOTAL AREA: 8.00 Sq.Ft.                  BORDER TYPE: Reflective                  RECESS: 0.00"                  WIDTH: 0.50"                  RADII: 1.50"                  NO. Z BARS:                  LENGTH:</p>	<p>BACKG COLOR: Green                  COPY COLOR: White</p> <table border="1" style="width: 100%; border-collapse: collapse;"> <tr> <th>SYMBOL</th> <th>X</th> <th>Y</th> <th>WID</th> <th>HT</th> </tr> <tr><td> </td><td> </td><td> </td><td> </td><td> </td></tr> <tr><td> </td><td> </td><td> </td><td> </td><td> </td></tr> <tr><td> </td><td> </td><td> </td><td> </td><td> </td></tr> <tr><td> </td><td> </td><td> </td><td> </td><td> </td></tr> <tr><td> </td><td> </td><td> </td><td> </td><td> </td></tr> <tr><td> </td><td> </td><td> </td><td> </td><td> </td></tr> <tr><td> </td><td> </td><td> </td><td> </td><td> </td></tr> </table> <p>MAT'L: 0.080" (2.0 mm) ALUMINUM</p>	SYMBOL	X	Y	WID	HT																																				<p>DESIGN BY: Z LIU                  PROJECT ID: BR-0069</p> <p>CHECKED BY: G MODLIN                  LOCATION: US 158 / NC 86</p> <p>March 24, 2023                  DIV: 07</p>	<div style="text-align: center;">  <p style="font-size: small;">BORDER R=1.5" TH=0.5" Panel Style: guide_con_destination.ssi M.U.T.C.D.: 2009 Edition</p> </div> <p style="text-align: center; font-size: x-small;">Spacing Factor is 1 unless specified otherwise</p>																																																																																																																									
SYMBOL	X	Y	WID	HT																																																																																																																																																																
<p><b>USE NOTES: 1,2</b></p> <p>1. Legend and border (except those that are colored black) shall be direct applied Grade C sheeting.                  2. Background shall be Grade C reflective sheeting.</p>																																																																																																																																																																				
<p><b>LETTER POSITIONS</b></p> <table border="1" style="width: 100%; border-collapse: collapse;"> <thead> <tr> <th colspan="12">Letter spacings are to start of next letter</th> <th>Series/Size</th> </tr> <tr> <th colspan="12"></th> <th>Text Length</th> </tr> </thead> <tbody> <tr> <td>P</td><td>a</td><td>r</td><td>t</td><td>O</td><td>f</td><td>T</td><td>h</td><td>e</td><td></td><td></td><td></td><td></td><td></td><td>EM 2000</td> </tr> <tr> <td>8.0</td><td>3.5</td><td>3.4</td><td>2.3</td><td>2.1</td><td>3.0</td><td>3.7</td><td>1.7</td><td>3.0</td><td>3.4</td><td>3.2</td><td>2.6</td><td>8.0</td><td></td><td>4/3</td> </tr> <tr> <td></td><td></td><td></td><td></td><td></td><td></td><td></td><td></td><td></td><td></td><td></td><td></td><td></td><td></td><td>32</td> </tr> <tr> <td>R</td><td>o</td><td>a</td><td>n</td><td>o</td><td>k</td><td>e</td><td></td><td></td><td></td><td></td><td></td><td></td><td></td><td>EM 2000</td> </tr> <tr> <td>13.0</td><td>3.5</td><td>3.1</td><td>3.3</td><td>3.2</td><td>3.2</td><td>3.0</td><td>2.6</td><td>13.0</td><td></td><td></td><td></td><td></td><td></td><td>4/3</td> </tr> <tr> <td></td><td></td><td></td><td></td><td></td><td></td><td></td><td></td><td></td><td></td><td></td><td></td><td></td><td></td><td>22</td> </tr> <tr> <td>R</td><td>i</td><td>v</td><td>e</td><td>r</td><td>B</td><td>a</td><td>s</td><td>i</td><td>n</td><td></td><td></td><td></td><td></td><td>EM 2000</td> </tr> <tr> <td>8.0</td><td>3.8</td><td>1.3</td><td>3.5</td><td>3.2</td><td>2.0</td><td>4.0</td><td>3.6</td><td>3.2</td><td>3.2</td><td>1.6</td><td>2.6</td><td>8.0</td><td></td><td>4/3</td> </tr> <tr> <td></td><td></td><td></td><td></td><td></td><td></td><td></td><td></td><td></td><td></td><td></td><td></td><td></td><td></td><td>32</td> </tr> </tbody> </table> <p style="font-size: x-small;">FILENAME: BR-0069_sign-02 <span style="float: right;">NORTH CAROLINA D.O.T. SIGN DETAIL</span></p>				Letter spacings are to start of next letter												Series/Size													Text Length	P	a	r	t	O	f	T	h	e						EM 2000	8.0	3.5	3.4	2.3	2.1	3.0	3.7	1.7	3.0	3.4	3.2	2.6	8.0		4/3															32	R	o	a	n	o	k	e								EM 2000	13.0	3.5	3.1	3.3	3.2	3.2	3.0	2.6	13.0						4/3															22	R	i	v	e	r	B	a	s	i	n					EM 2000	8.0	3.8	1.3	3.5	3.2	2.0	4.0	3.6	3.2	3.2	1.6	2.6	8.0		4/3															32
Letter spacings are to start of next letter												Series/Size																																																																																																																																																								
												Text Length																																																																																																																																																								
P	a	r	t	O	f	T	h	e						EM 2000																																																																																																																																																						
8.0	3.5	3.4	2.3	2.1	3.0	3.7	1.7	3.0	3.4	3.2	2.6	8.0		4/3																																																																																																																																																						
														32																																																																																																																																																						
R	o	a	n	o	k	e								EM 2000																																																																																																																																																						
13.0	3.5	3.1	3.3	3.2	3.2	3.0	2.6	13.0						4/3																																																																																																																																																						
														22																																																																																																																																																						
R	i	v	e	r	B	a	s	i	n					EM 2000																																																																																																																																																						
8.0	3.8	1.3	3.5	3.2	2.0	4.0	3.6	3.2	3.2	1.6	2.6	8.0		4/3																																																																																																																																																						
														32																																																																																																																																																						

10/5/2023  
 G:\RA\001-109\BR-0069\Traffic\Signing\VCADD\Sign Designs\BR-0069\_sign-02.dgn  
 gmodlin

<p>APPROVED:  DATE: 3/5/2024</p> <p style="font-size: x-small;">000516E4527404...</p>	<p><b>PROPOSED SIGN DESIGN</b></p>									
	<p>SCALE: NTS</p> <p>DATE: March 24, 2023</p> <p>DWG. BY:</p> <p>DESIGN BY: Z LIU</p> <p>REVIEW BY: G MODLIN</p>									
		<table border="1" style="width: 100%; border-collapse: collapse;"> <tr> <th colspan="2">REVISIONS</th> </tr> <tr> <td> </td> <td> </td> </tr> <tr> <td> </td> <td> </td> </tr> <tr> <td> </td> <td> </td> </tr> </table>	REVISIONS							
REVISIONS										
		<table border="1" style="width: 100%; border-collapse: collapse;"> <tr> <td>CAD FILE</td> </tr> </table>	CAD FILE							
CAD FILE										



**PROJECT NOTES**

1 DISPOSAL OF SIGN SYSTEM, U-CHANNEL

APPROVED: Trent Hoffman  
 DATE: 2/5/2024



\* SEE NOTE 1

EXISTING & PROPOSED SIGN  
 US 158 / NC 86

**moffatt & nichol**  
 4700 FALLS OF NEUSE ROAD, SUITE 300  
 RALEIGH, NORTH CAROLINA 27609  
 (919) 781-4626 VOICE (919) 781-4869 FAX (F-0105)

**DOCUMENT NOT CONSIDERED FINAL  
 UNLESS ALL SIGNATURES COMPLETED**

9/27/2023  
 g:\projects\0001-09\BR-0069\Traffic\Signing\CADD\Sign\_Designs\BR-0069\_sign-03.dgn  
 smodin