 




USE FOR LIGHTING CONSTRUCTION ONLY

PROJECT REFERENCE NO. R-2577A SHEET NO. E-3

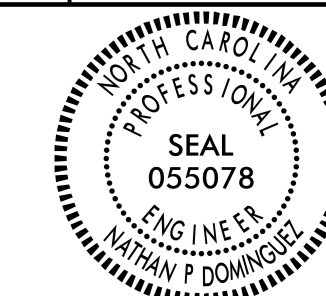

DocuSigned by:
Nathan Dominguez
12/06/2023

**DOCUMENT NOT CONSIDERED FINAL
UNLESS ALL SIGNATURES COMPLETED**

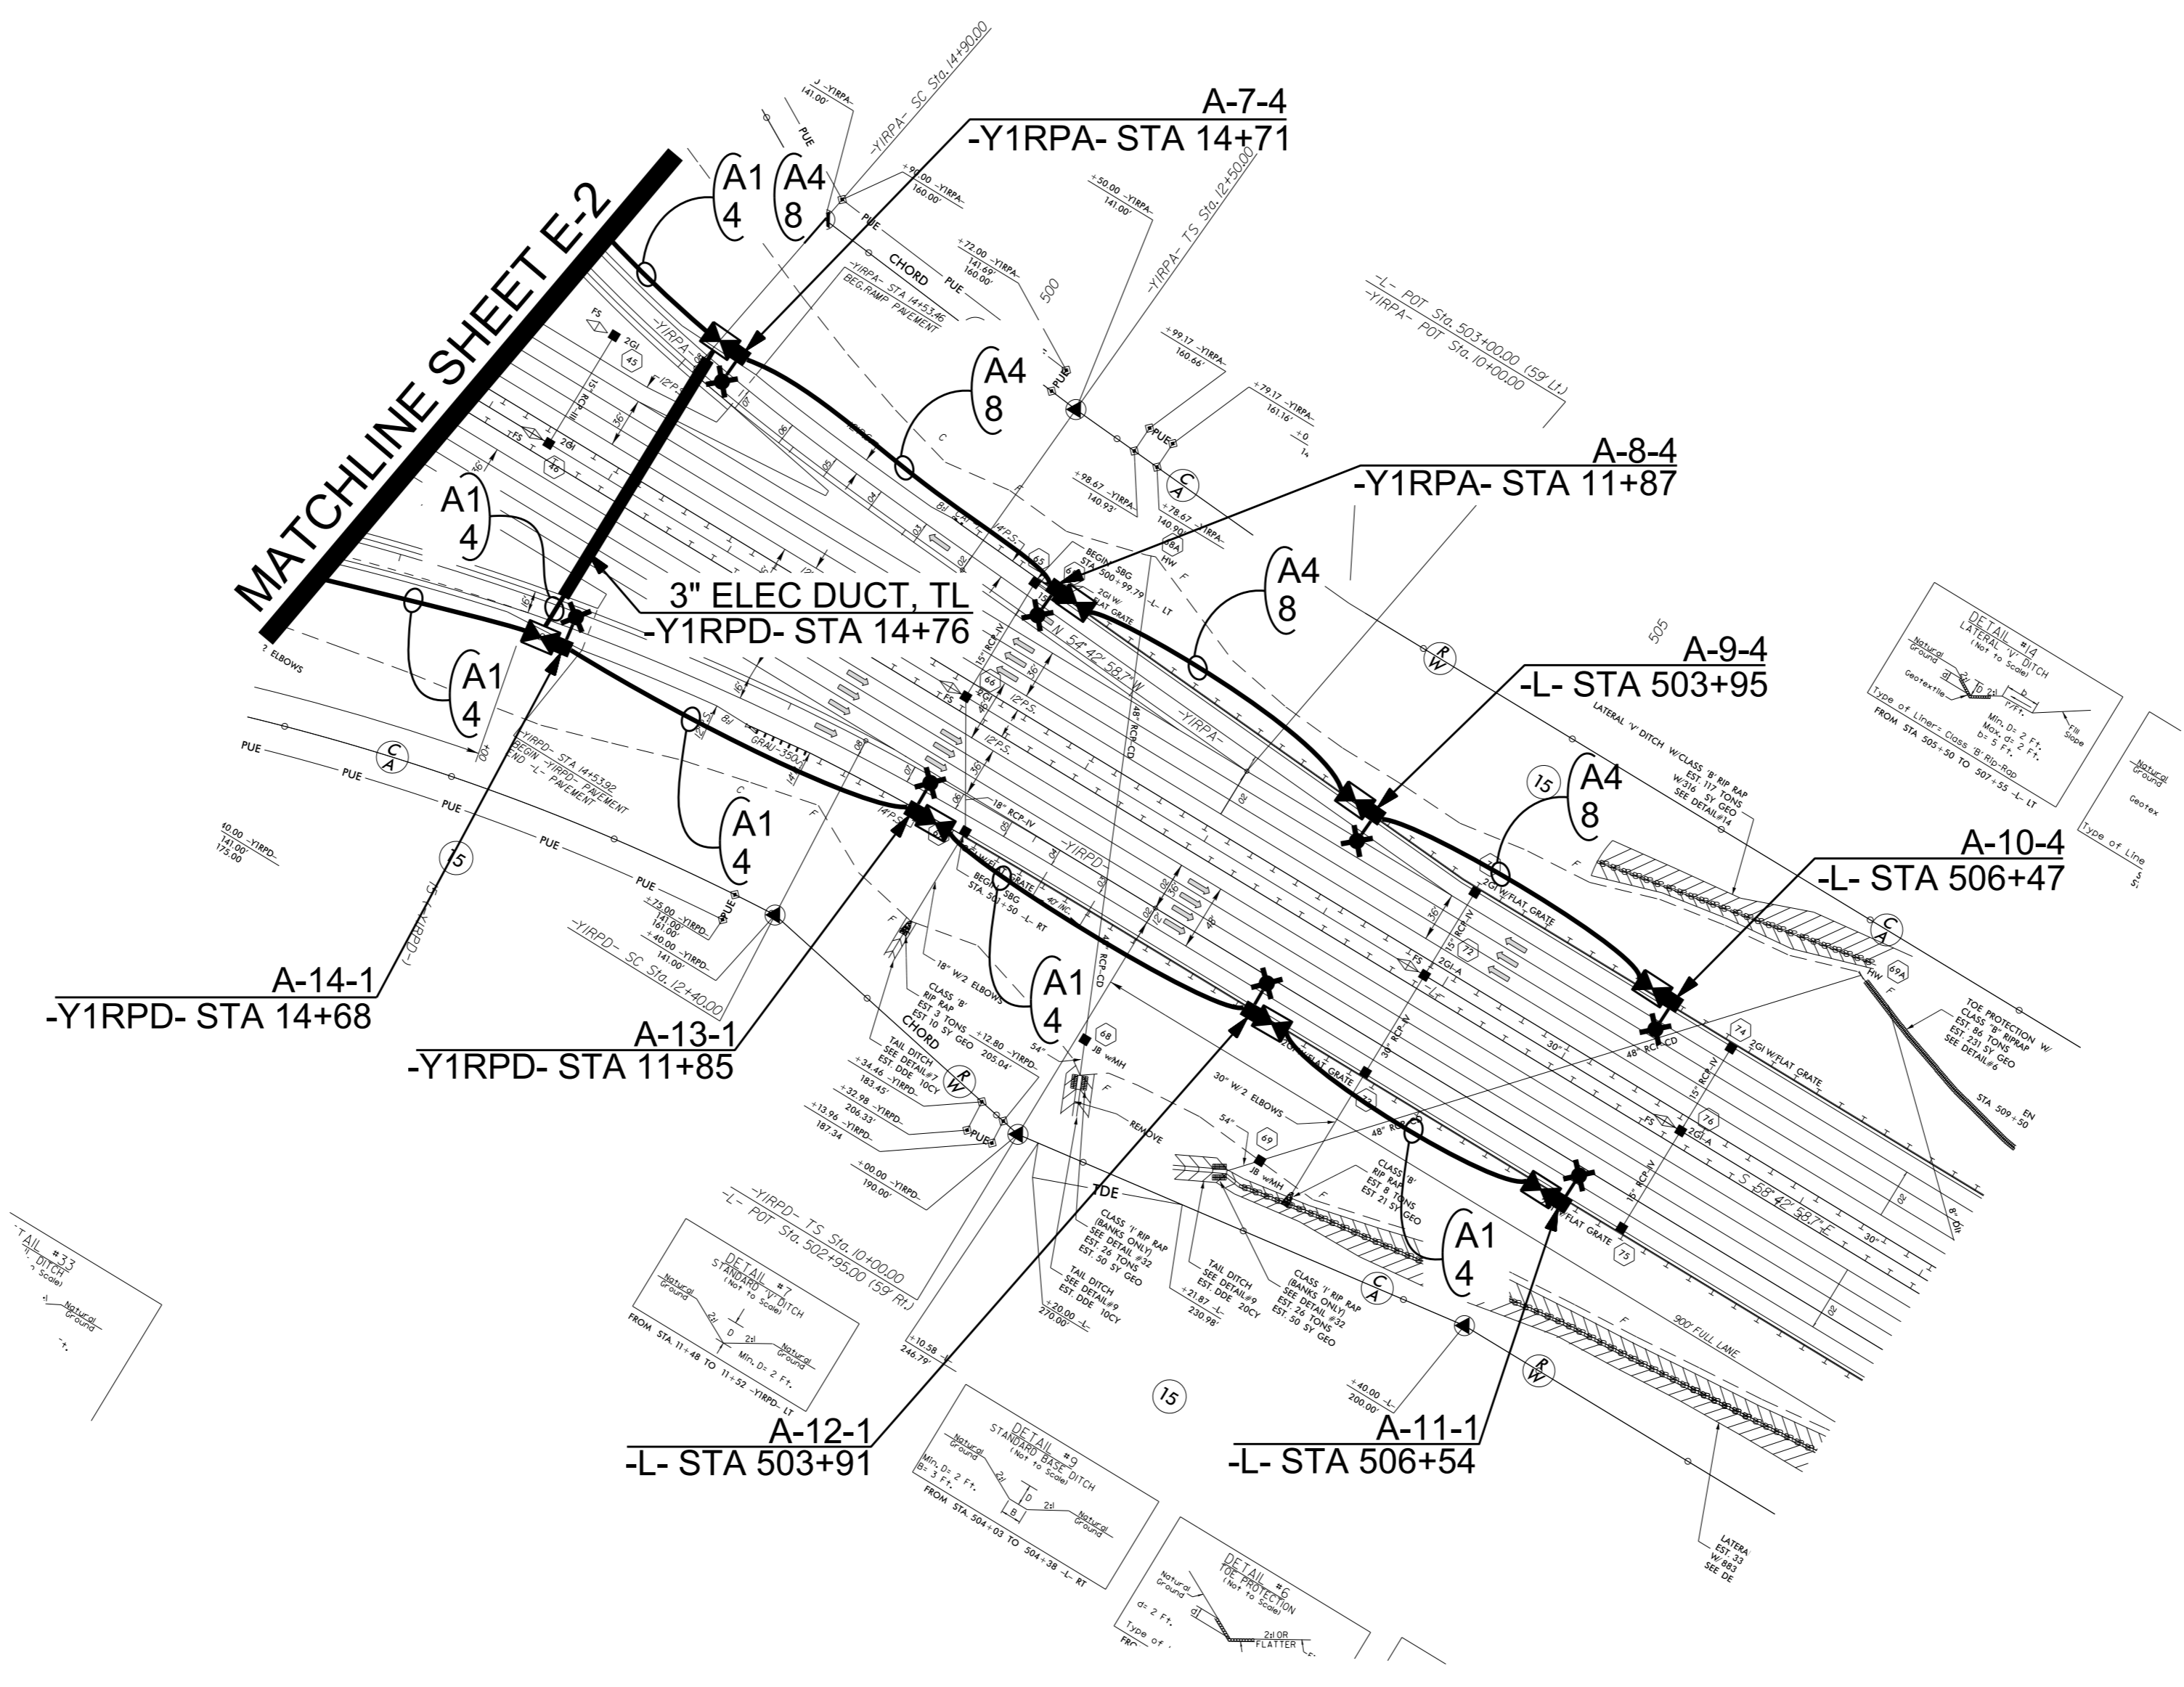

SEE SHEET "E-1" FOR
LEGEND & △ NOTES

2			
1			
Rev.	Date	Description	Approved
NORTH CAROLINA DEPARTMENT OF TRANSPORTATION ROADWAY DESIGN LIGHTING/ELECTRICAL SECTION LIGHTING LAYOUT US 158/I-74 INTERCHANGE FORSYTH COUNTY			
Drawn By:	SAM	Approved By:	RGH
Dwg No.:			

06-NOV-2023 08:57
 R:\Lighting\Lighting Design\Fresh Start 103123\R-2577A\LE_PSH.E3.dgn
 somehtk AT RD-328813L