


MATCHLINE -L- STA. 215+00 SEE SCP 18

MATCHLINE -L- STA. 228+50 SEE SCP 20

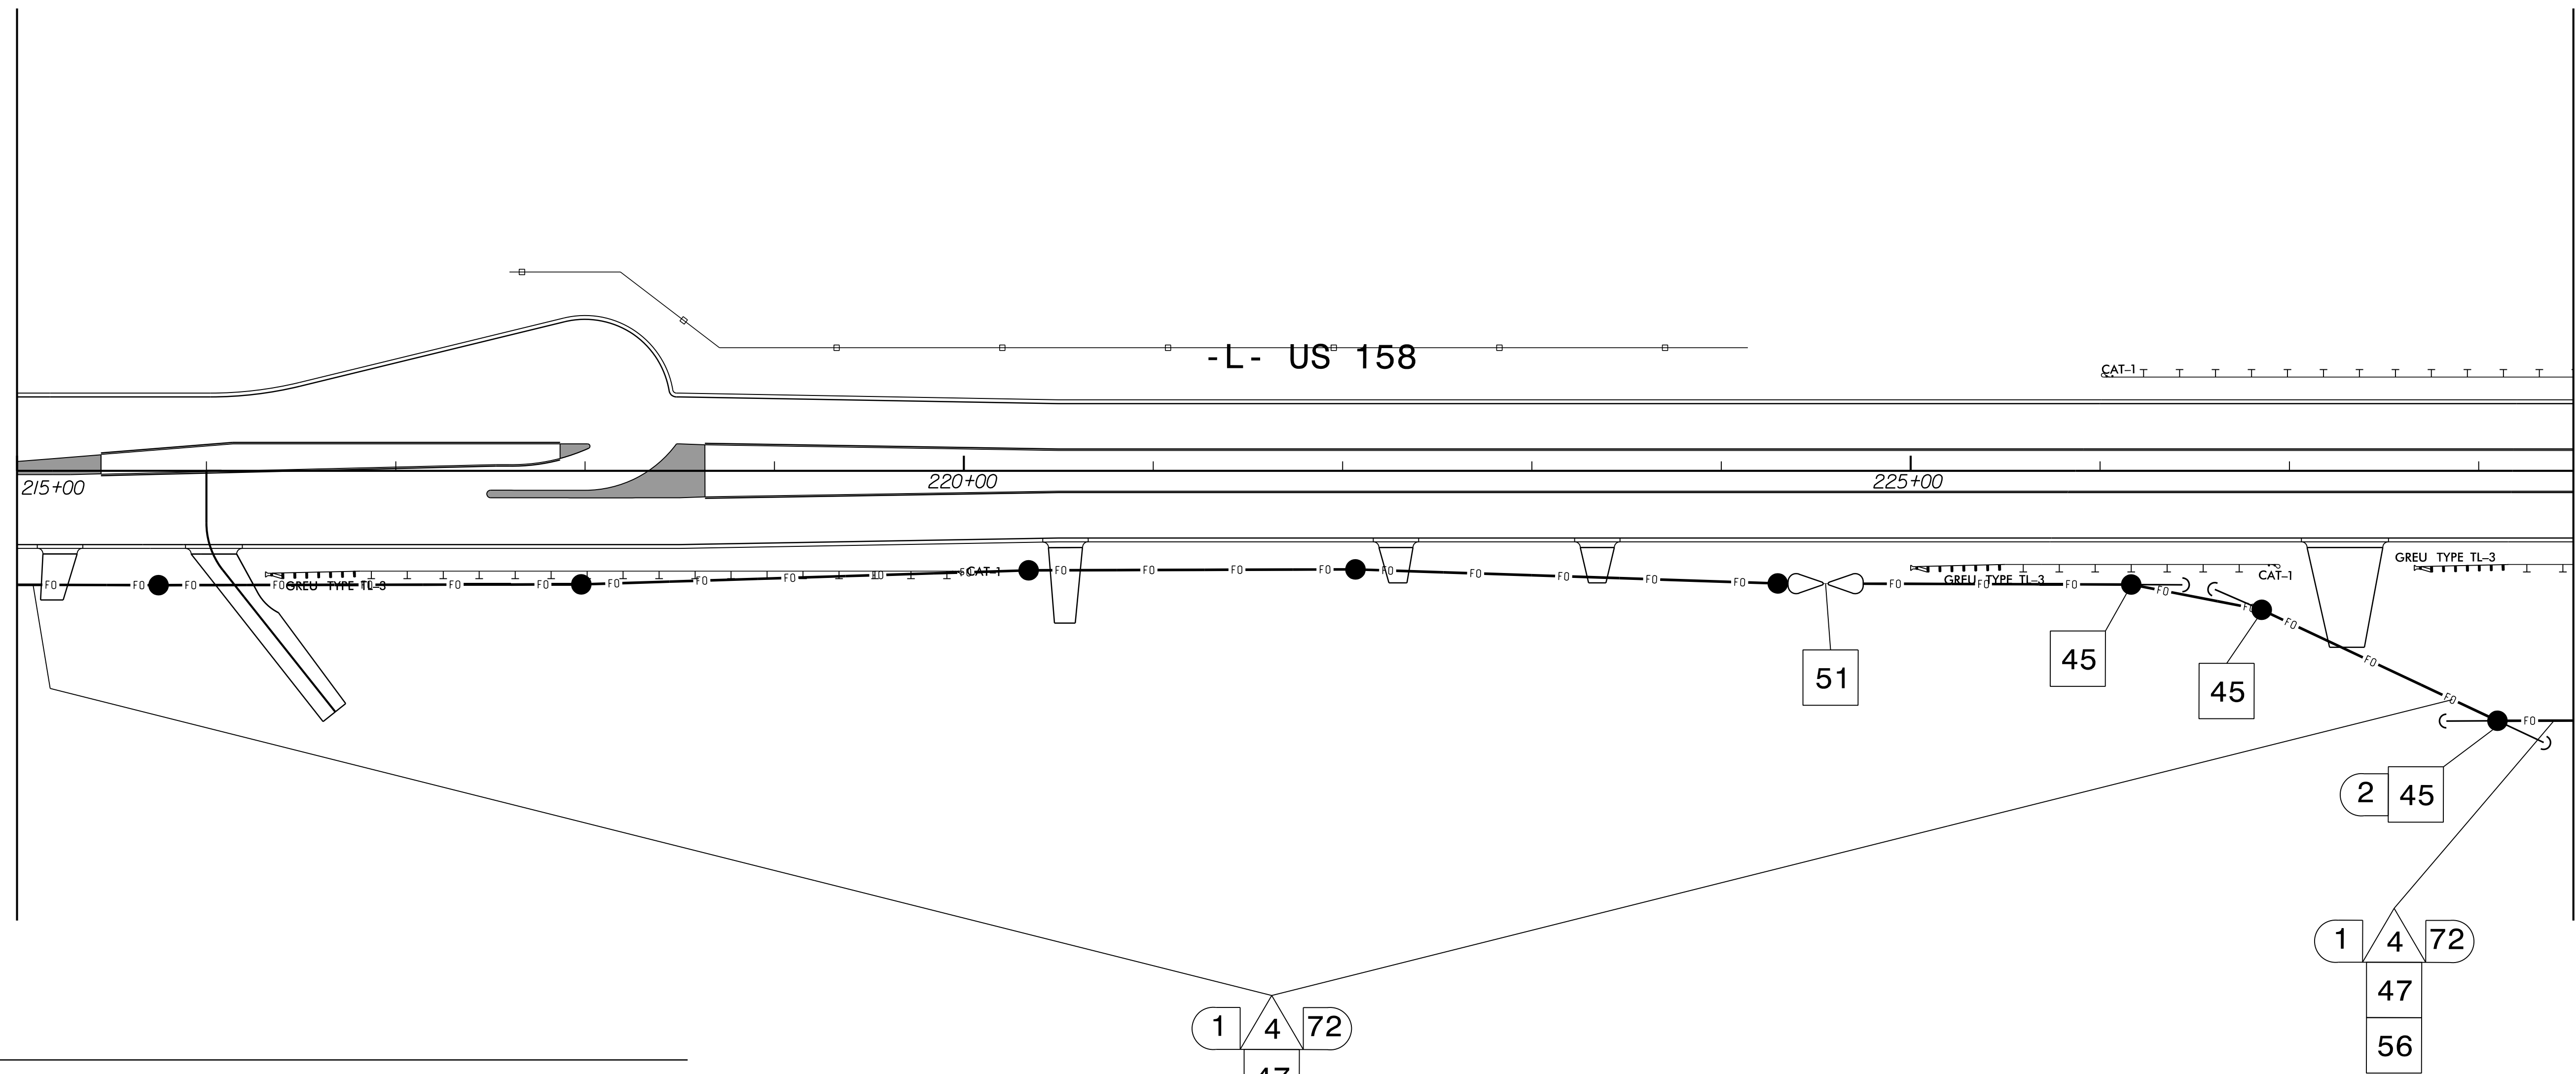

**NOTES:**

- FIVE (5) DAYS PRIOR TO BEGINNING WORK ON THE SIGNAL SYSTEM CCTV INSTALLATION, CONTACT THE WINSTON-SALEM TRAFFIC ENGINEER AT (336)747-6885 TO ARRANGE FOR THE CITY TO PROGRAM THE NEW FIELD ETHERNET SWITCHES FOR SIGNALS ON THE WINSTON-SALEM SIGNAL SYSTEM AND CONTACT THE DIVISION TRAFFIC ENGINEER AT (336)747-7800 TO ARRANGE FOR THE DIVISION TO PROGRAM THE NEW FIELD ETHERNET SWITCHES FOR SIGNALS AND ITS DEVICES ON THE D09-11 WINSTON-SALEM SYSTEM. EACH ETHERNET SWITCH WILL BE PROGRAMMED WITH THE NECESSARY NETWORK CONFIGURATION DATA, INCLUDING BUT NOT LIMITED TO: THE PROJECT IP ADDRESS, DEFAULT GATEWAY, SUBNET MASK AND VLAN ID INFORMATION. NOTIFY THE DIVISION TRAFFIC ENGINEER AFTER ALL WORK IS PERFORMED TO ENSURE THAT ALL FIBER CIRCUITS ARE FUNCTIONING PROPERLY. WORK IS NOT COMPLETE UNTIL THE SIGNAL SYSTEM IS BACK UP AND OPERATIONAL.

2/12/2024  
R:\Projects\2577A\Signal Design\Signal Design.dgn  
WPT Jones

**RK&K**  
P: (919) 878-8560  
8801 Six Forks Road Suite 700 | Raleigh, North Carolina 27615-2965  
NC License No. F-0112  
www.rk.com  
Responsive People | Creative Solutions

Prepared for the Offices of:  
  
 750 N. Greenfield Pkwy, Garner, NC 27529  
 SCALE: NTS

|   |                                    |
|---|------------------------------------|
| Signal System D09-11 Winston-Salem Signal Communication Plans |                                    |
| Division 09 Forsyth County                                    | Winston-Salem/Walkertown           |
| PLAN DATE: February 2024                                      | REVIEWED BY: Porter Erickson-Jones |
| PREPARED BY: Haylee Townsend                                  | REVIEWED BY:                       |
| REVISIONS   | INIT. DATE                         |
|   |                                    |
|   |                                    |

DOCUMENT NOT CONSIDERED FINAL UNLESS ALL SIGNATURES COMPLETED

SEAL  
  
 Porter Jones  
 2/12/2024  
 SIGNATURE DATE  
 SIG. INVENTORY NO.