



DRAWING 1

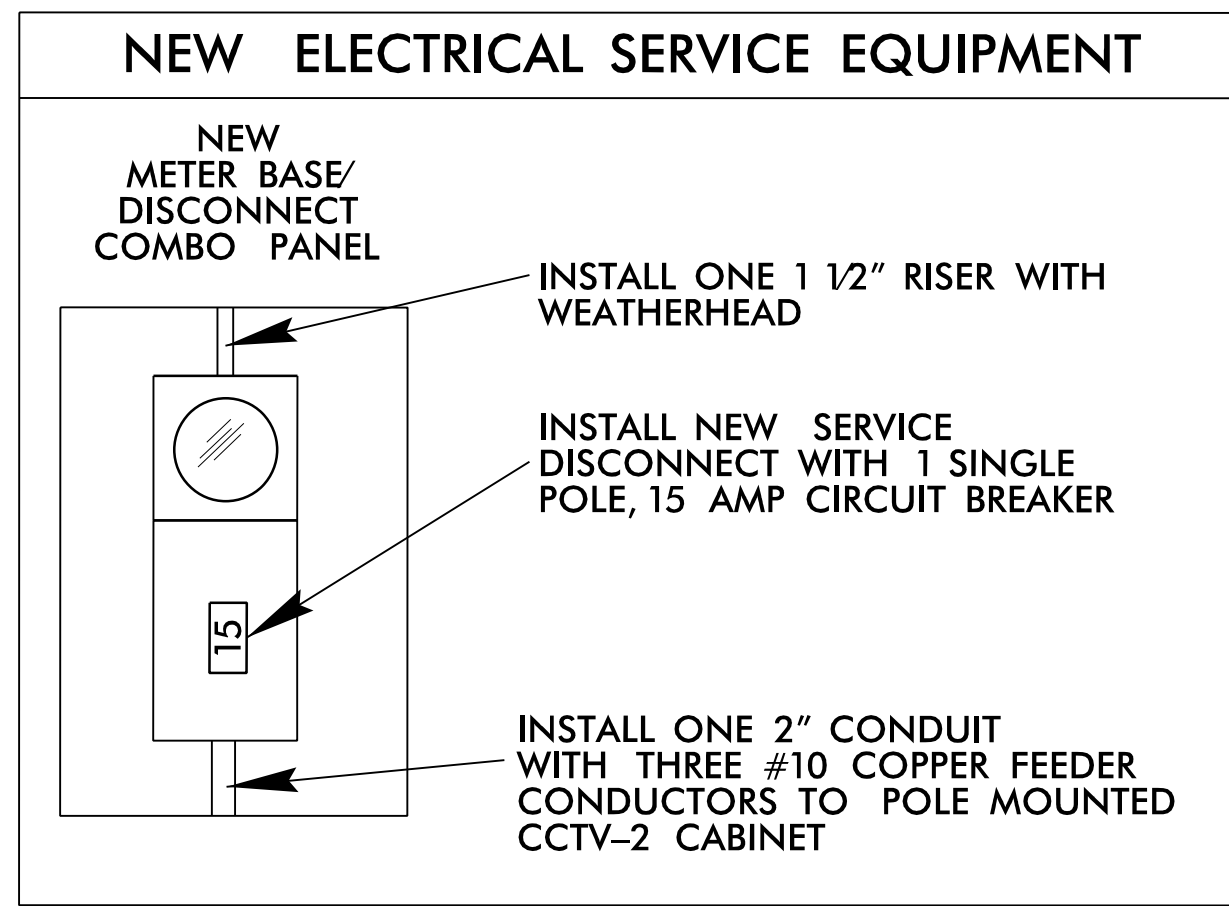

MATCHLINE -L- STA. 241+00 SEE SCP 20

MATCHLINE -L- STA. 253+00 SEE SCP 22

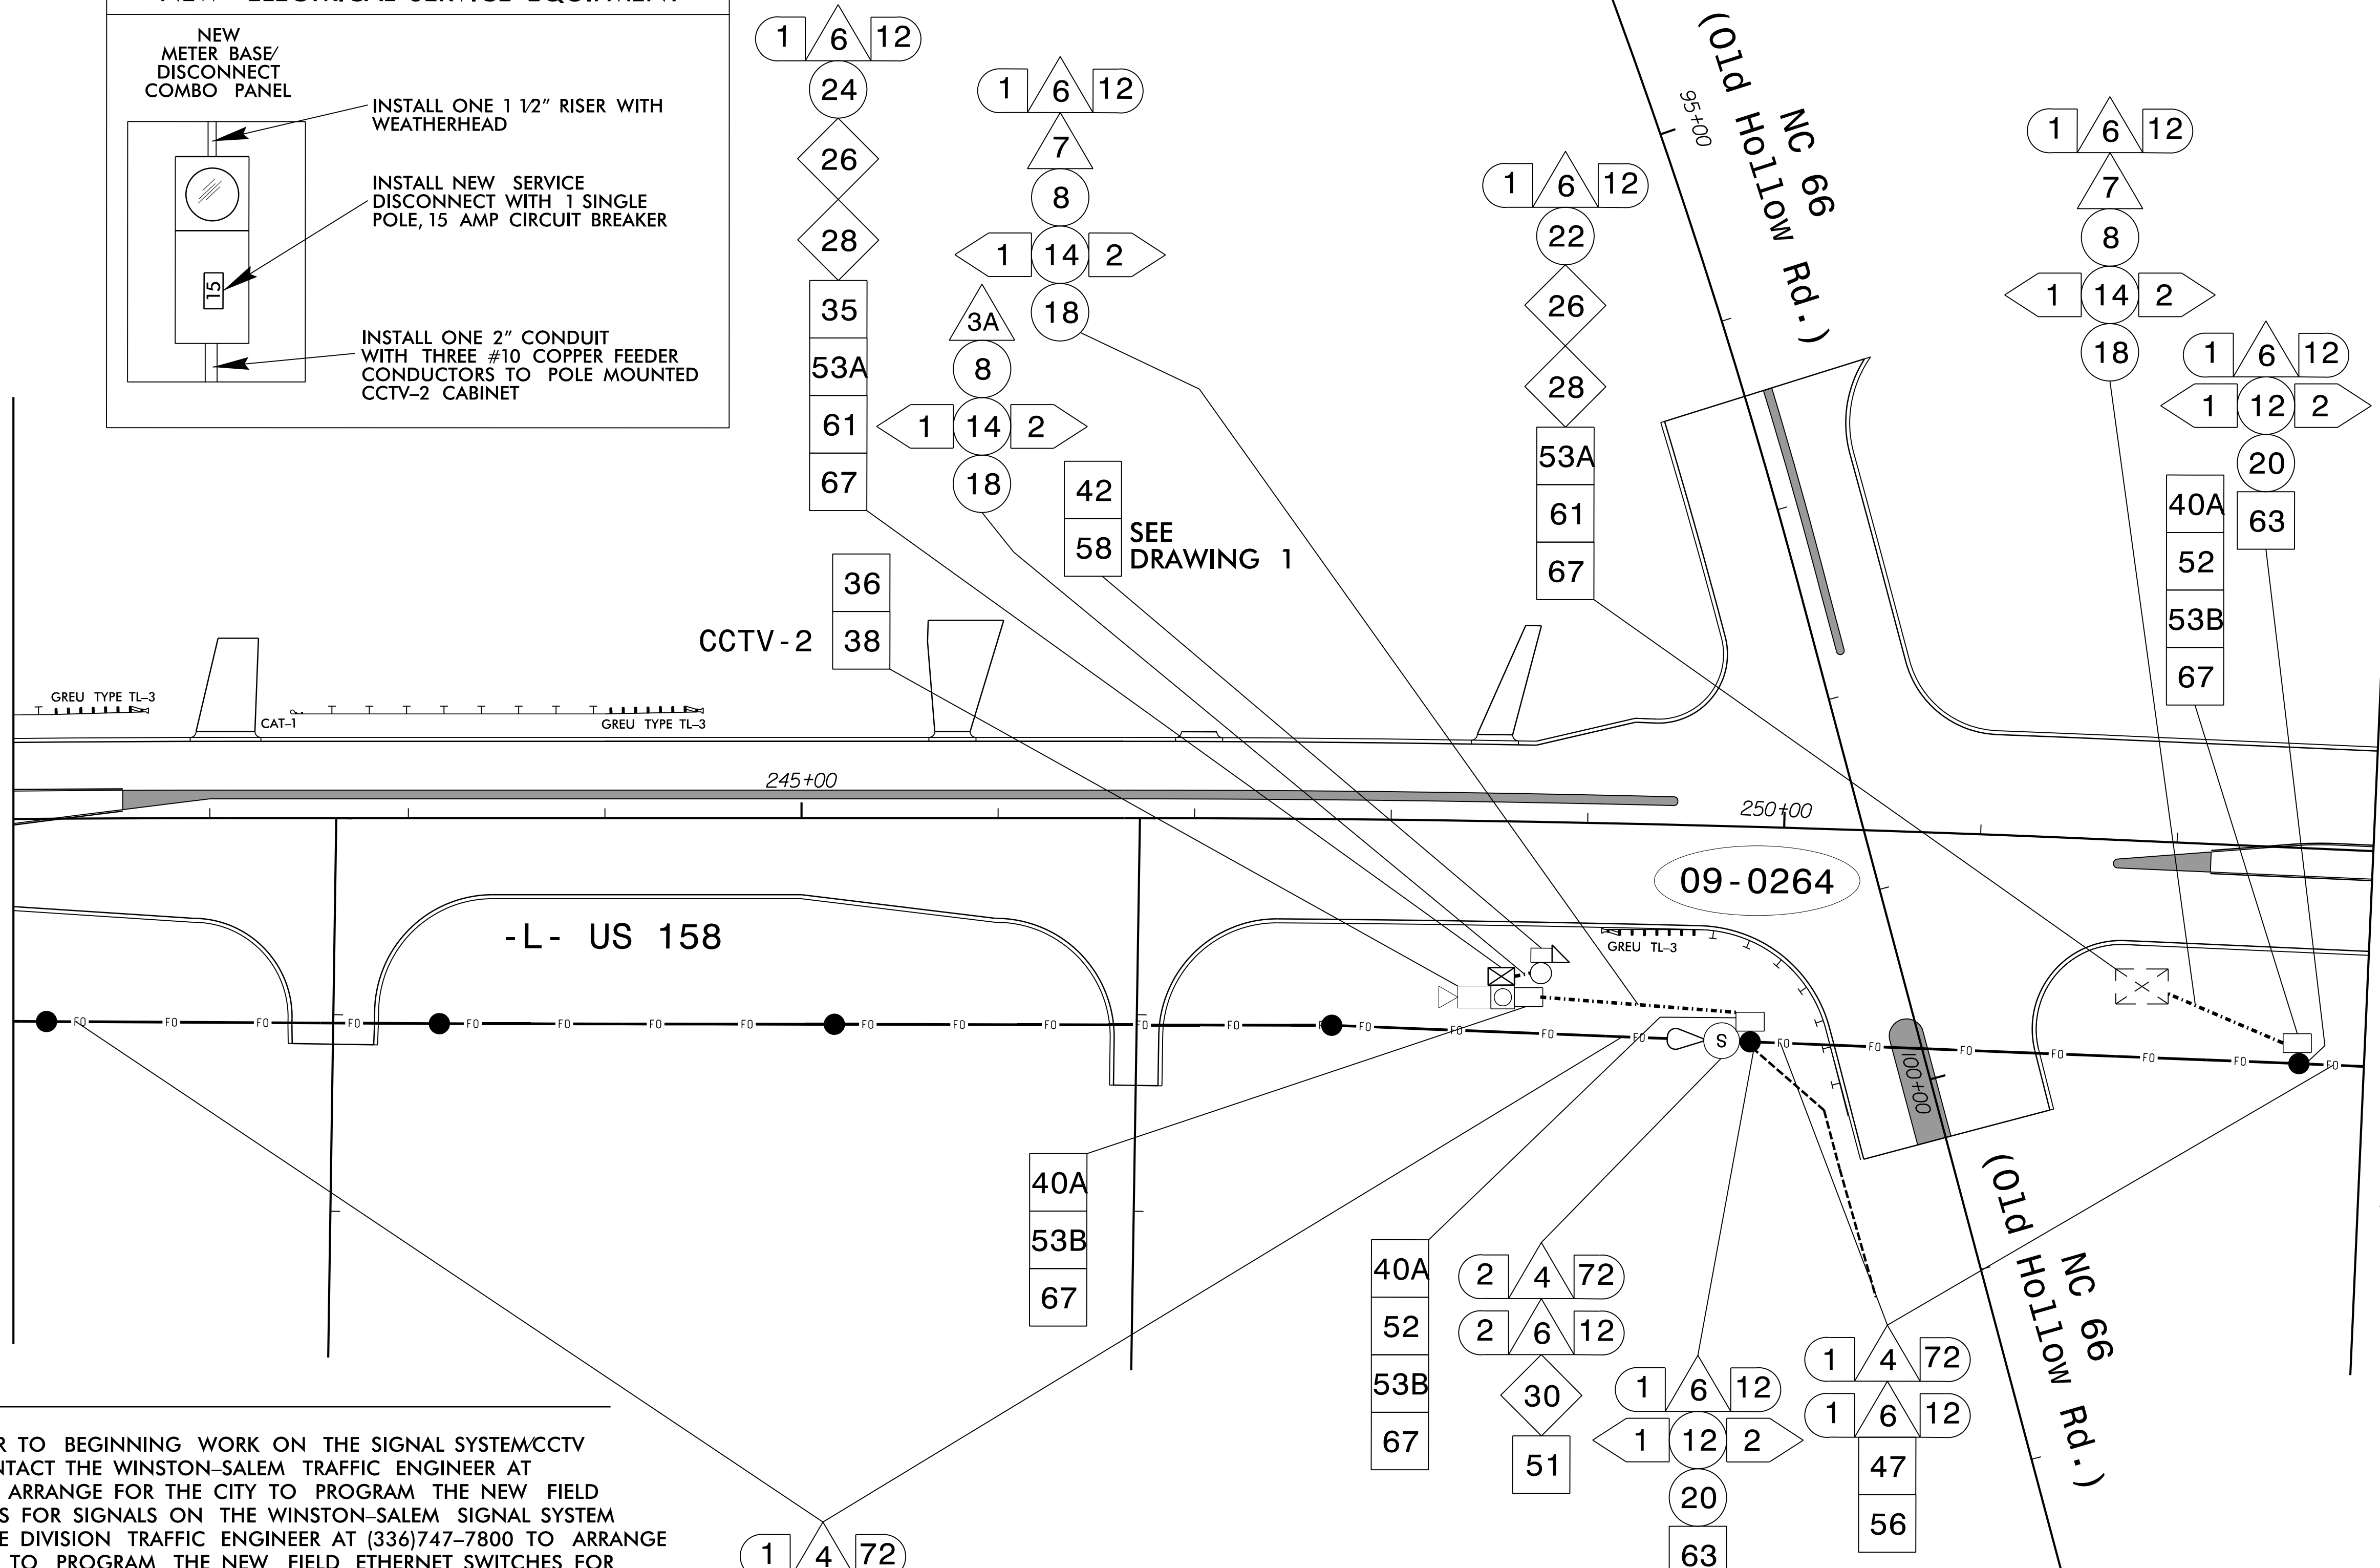

NOTES:

- FIVE (5) DAYS PRIOR TO BEGINNING WORK ON THE SIGNAL SYSTEM/CCTV INSTALLATION, CONTACT THE WINSTON-SALEM TRAFFIC ENGINEER AT (336)747-6885 TO ARRANGE FOR THE CITY TO PROGRAM THE NEW FIELD ETHERNET SWITCHES FOR SIGNALS ON THE WINSTON-SALEM SIGNAL SYSTEM AND CONTACT THE DIVISION TRAFFIC ENGINEER AT (336)747-7800 TO ARRANGE FOR THE DIVISION TO PROGRAM THE NEW FIELD ETHERNET SWITCHES FOR SIGNALS AND ITS DEVICES ON THE D09-11 WINSTON-SALEM SYSTEM. EACH ETHERNET SWITCH WILL BE PROGRAMMED WITH THE NECESSARY NETWORK CONFIGURATION DATA, INCLUDING BUT NOT LIMITED TO: THE PROJECT IP ADDRESS, DEFAULT GATEWAY, SUBNET MASK AND VLAN ID INFORMATION. NOTIFY THE DIVISION TRAFFIC ENGINEER AFTER ALL WORK IS PERFORMED TO ENSURE THAT ALL FIBER CIRCUITS ARE FUNCTIONING PROPERLY. WORK IS NOT COMPLETE UNTIL THE SIGNAL SYSTEM IS BACK UP AND OPERATIONAL.
- THE FINAL LOCATION OF ALL ITS DEVICES MUST BE VERIFIED BY THE INCIDENT MANAGEMENT ENGINEER (336)896-2395 PRIOR TO INSTALLATION.
- INSTALL CCTV CAMERA 45' ABOVE GRADE.

2/12/2024 R:\Projects\2577A\Drawings\Signal\SCP_21.dgn

RK&K
 P: (919) 878-8550
 8801 Six Forks Road Suite 700 | Raleigh, North Carolina 27615-2965
 NC License No. F-0112
 www.rk.com
 Responsive People | Creative Solutions

Prepared for the Offices of:

 SCALE: NTS

Signal System D09-11_Winston-Salem
 Signal Communication Plans
 Winston-Salem/
 Walkertown
 Division 09 Forsyth County
 PLAN DATE: February 2024 REVIEWED BY: Porter Erickson-Jones
 PREPARED BY: Haylee Townsend REVIEWED BY:
 REVISIONS: _____ INIT. DATE

DOCUMENT NOT CONSIDERED FINAL UNLESS ALL SIGNATURES COMPLETED

SEAL

 PORTER JONES
 SIGNATURE DATE: 2/12/2024
 SIG. INVENTORY NO.