

MATCHLINE SHEET E-4  
-L1\_WB- STA. 63+85



USE FOR LIGHTING CONSTRUCTION ONLY

PROJECT REFERENCE NO. 1-2513AB SHEET NO. E-5




12/21/2023

DOCUMENT NOT CONSIDERED FINAL  
UNLESS ALL SIGNATURES COMPLETED

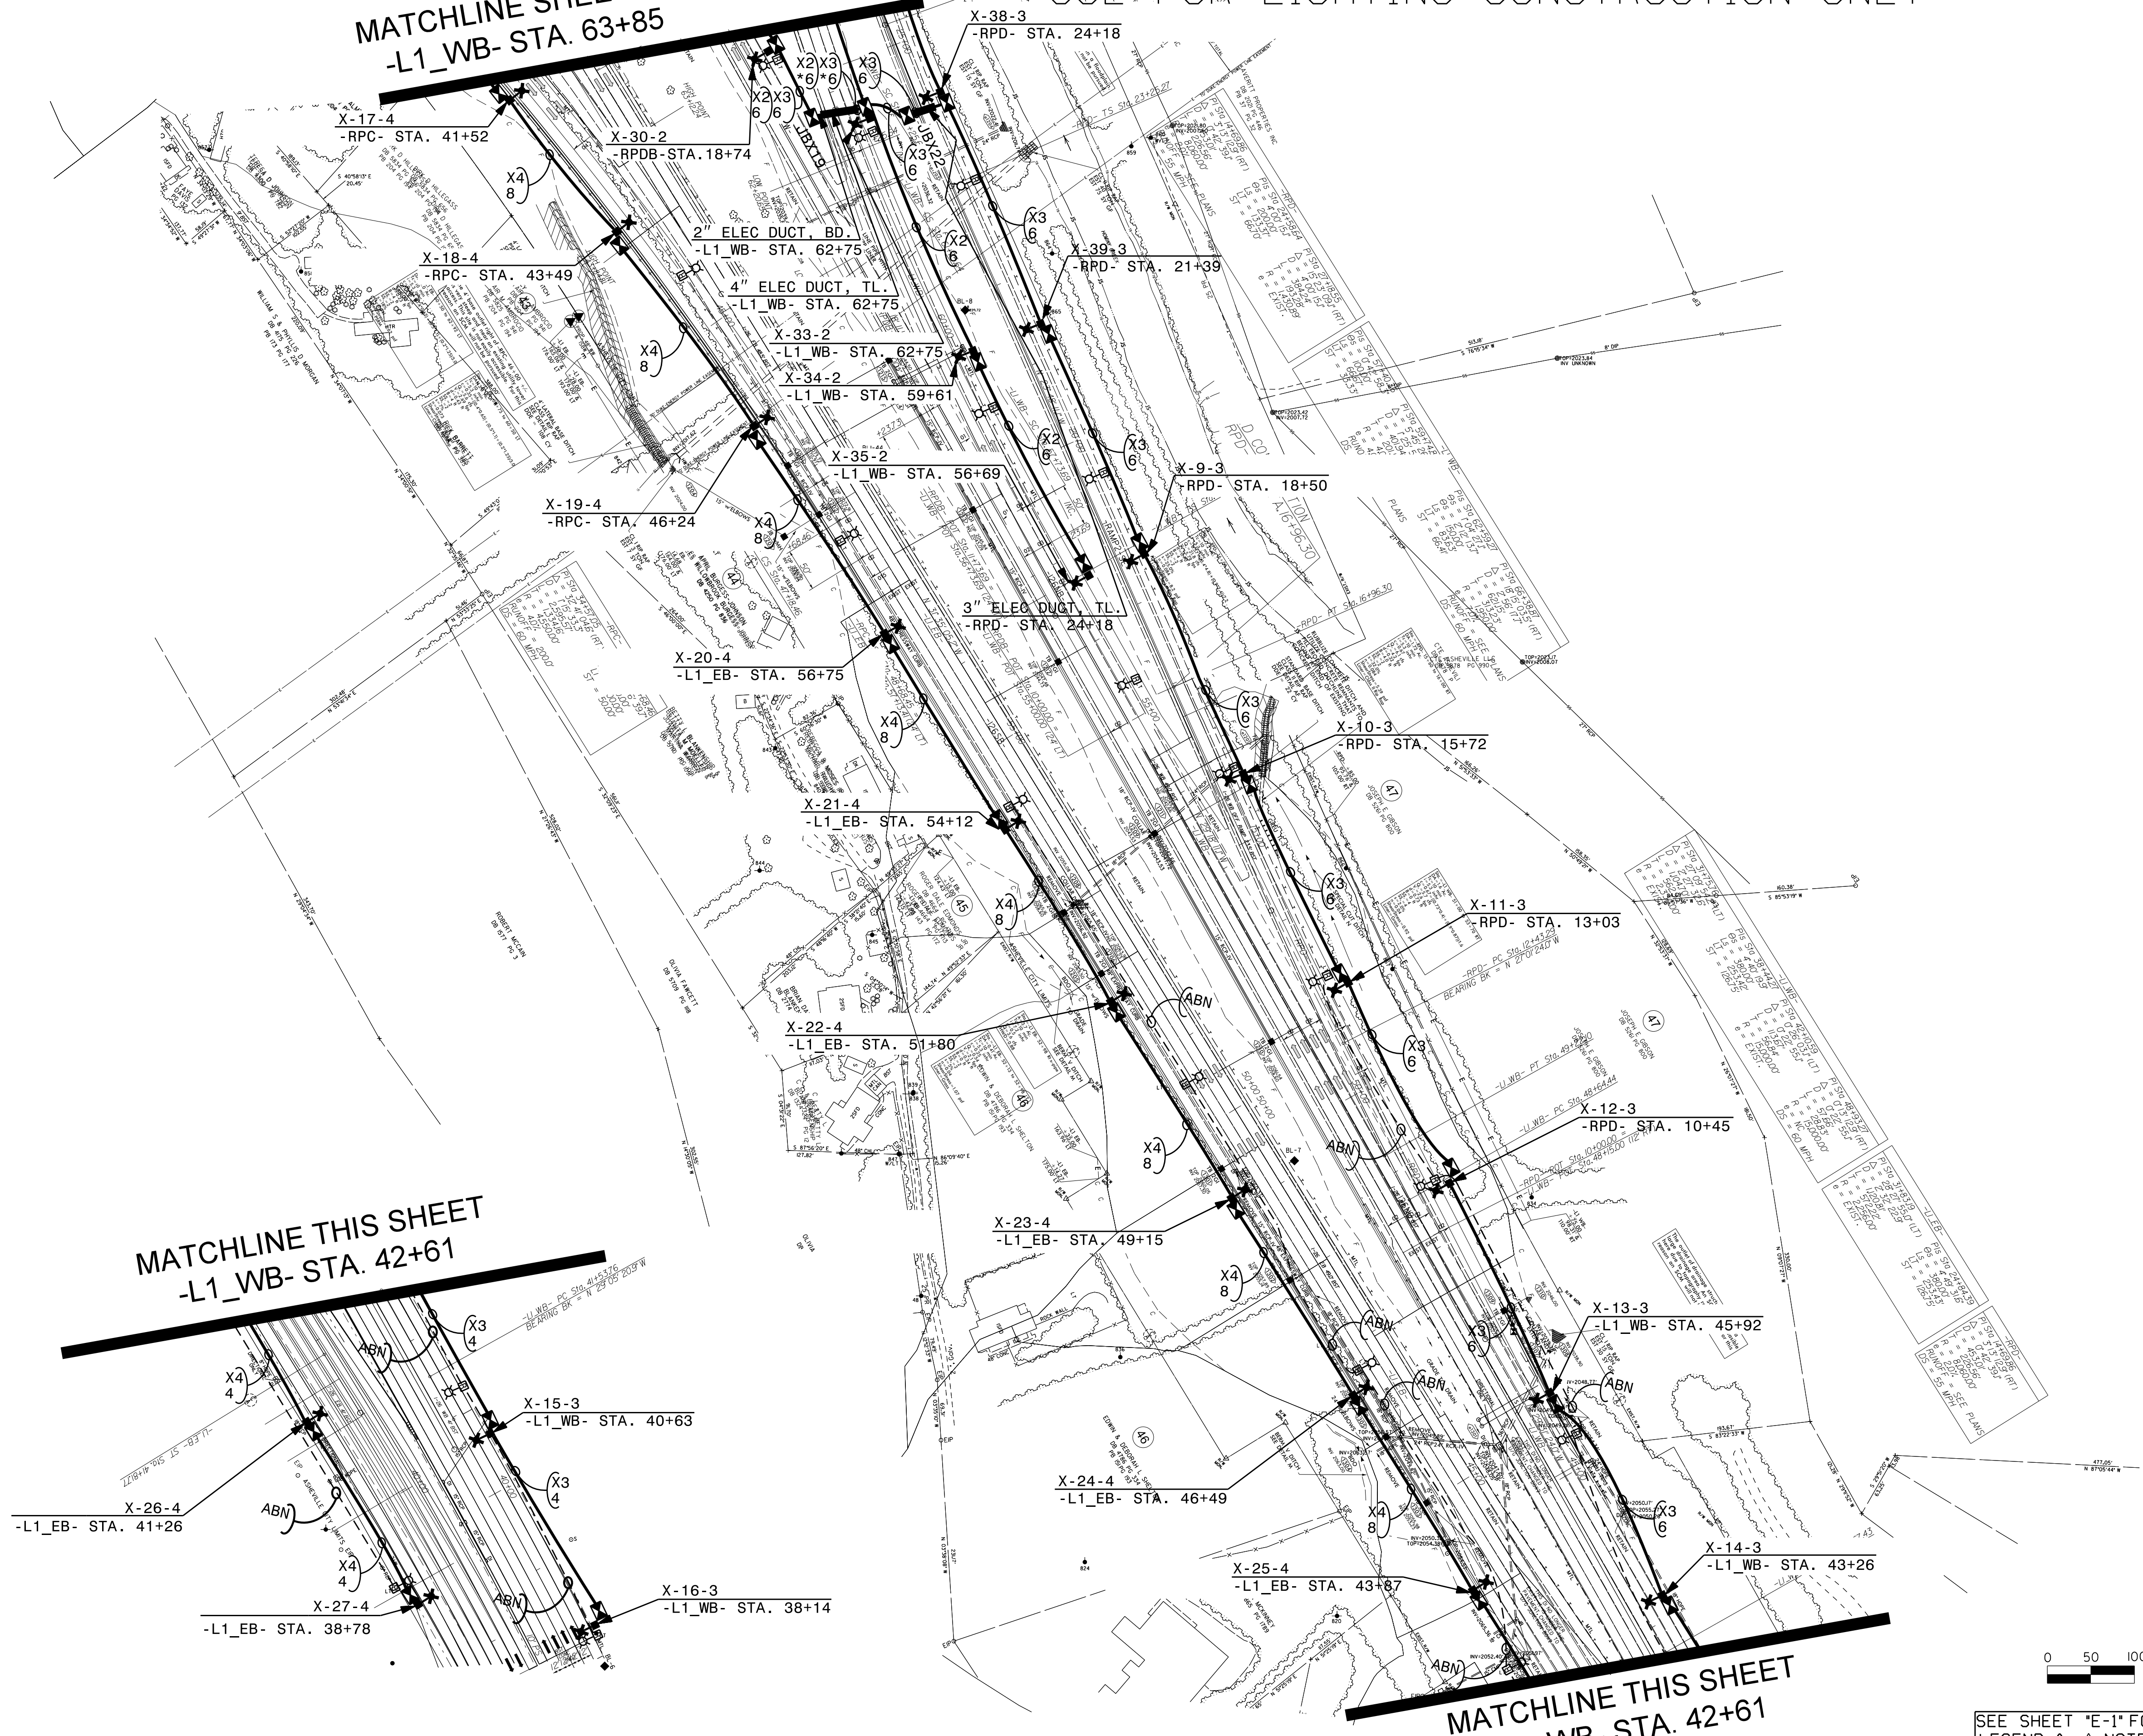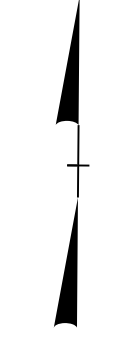

MATCHLINE THIS SHEET  
-L1\_WB- STA. 42+61

 MATCHLINE THIS SHEET  
-L1\_WB- STA. 42+61



SEE SHEET "E-1" FOR  
LEGEND & Δ NOTES

2-DEC-2023 11:34 AM C:\Users\jmsquadr1\OneDrive\Lighting Design\12513AB\PSH\_E5.dgn

2			
1			
Rev.	Date	Description	Approved
<b>NORTH CAROLINA DEPARTMENT OF TRANSPORTATION</b> ROADWAY DESIGN LIGHTING/ELECTRICAL SECTION <b>LIGHTING LAYOUT I-40/I-26 INTERCHANGE, NORTH OF POND RD</b>			
BUNCOMBE COUNTY			
Drawn By:	MSQ	Approved By:	RGH
		Dwg No.:	